

IOWA ARMY NATIONAL GUARD S54 FINISH UPGRADES


CAMP DODGE, JOHNSTON, IOWA

ISG PROJECT # 26-34920



LOCATION MAP

1 LOCATION MAP - ENLARGED
1/2" = 1'-0"

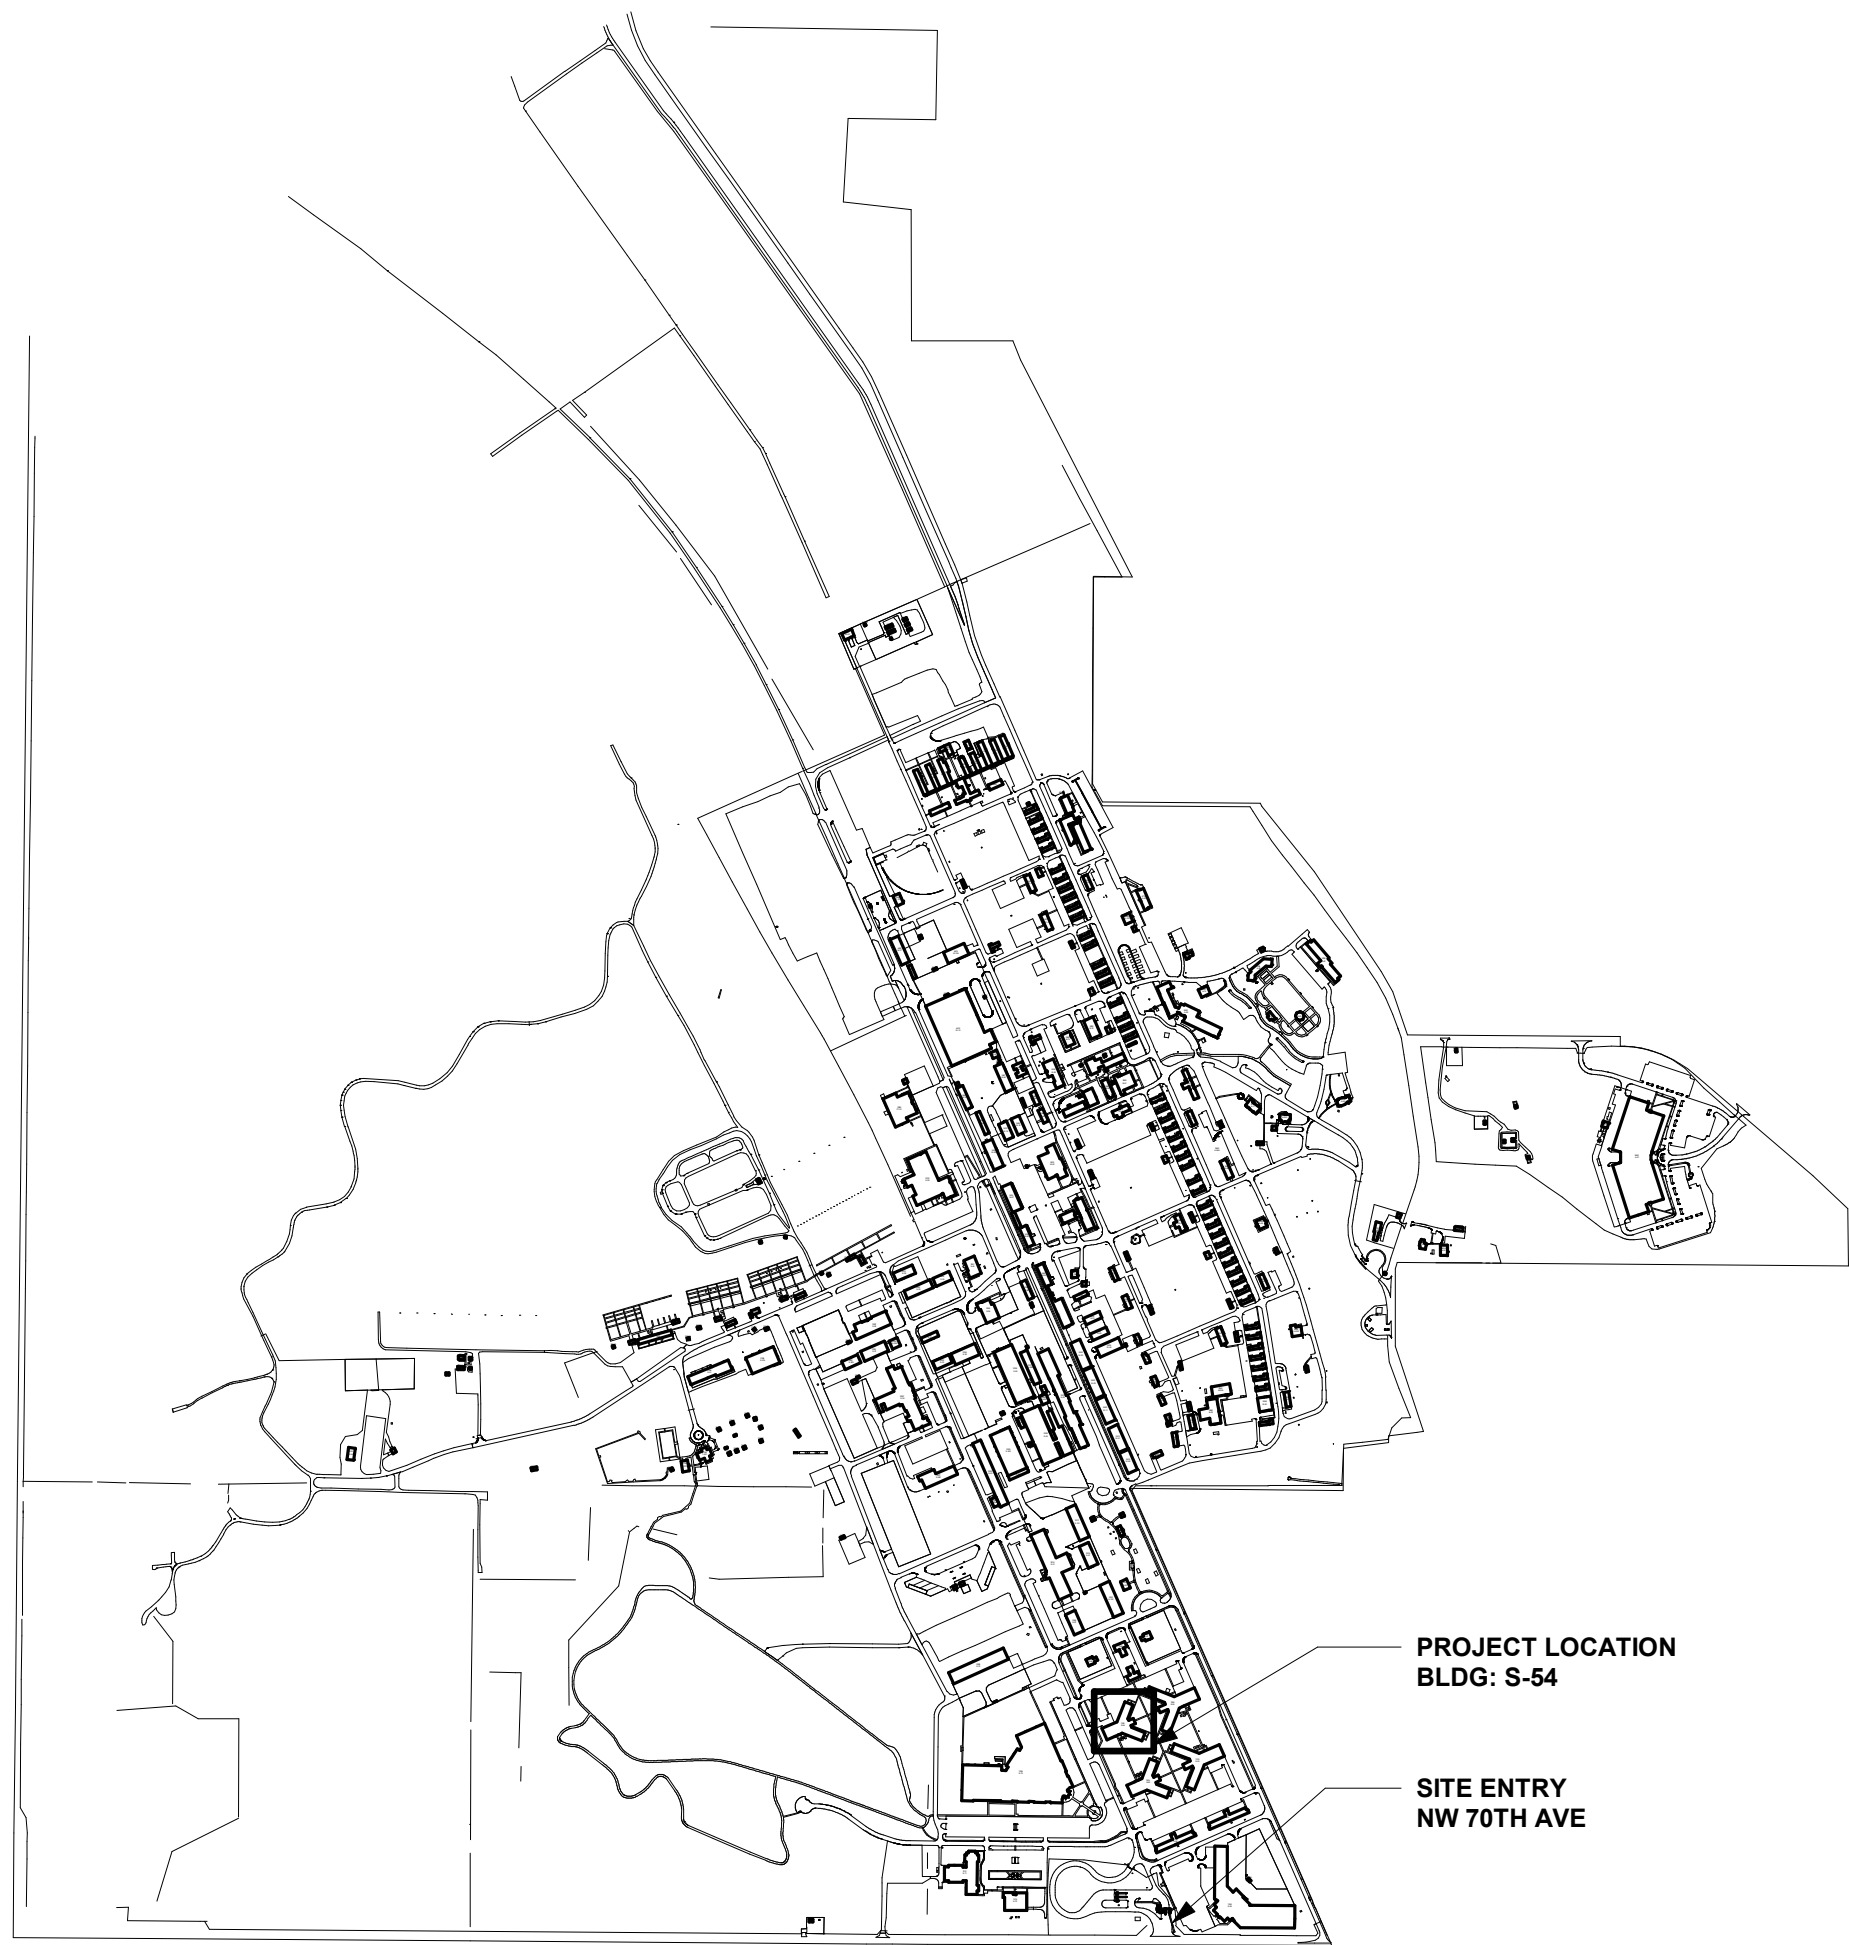

2 CAMP DODGE VICINITY MAP
1" = 400'-0"

PROJECT GENERAL NOTES	
A.	ALL WORK SHALL CONFORM TO THE CONTRACT DOCUMENTS, WHICH INCLUDE, BUT ARE NOT LIMITED TO, THE OWNER - CONTRACTOR AGREEMENT, THE PROJECT MANUAL (WHICH INCLUDES GENERAL AND SUPPLEMENTARY CONDITIONS AND SPECIFICATIONS), DRAWINGS OF ALL DISCIPLINES AND ALL ADDENDA, MODIFICATIONS AND CLARIFICATIONS ISSUED BY THE ARCHITECT / ENGINEER.
B.	CONTRACT DOCUMENTS SHALL BE ISSUED TO ALL SUBCONTRACTORS BY THE GENERAL CONTRACTOR IN COMPLETE SETS IN ORDER TO ACHIEVE THE FULL EXTENT AND COMPLETE COORDINATION OF ALL WORK. CONTRACTOR IS RESPONSIBLE FOR COORDINATING AND CORRELATING QUANTITIES AND DIMENSIONS.
C.	WRITTEN DIMENSIONS TAKE PRECEDENCE OVER SCALED DIMENSIONS. NOTIFY ARCHITECT/ENGINEER OF ANY DISCREPANCIES OR CONDITIONS REQUIRING INFORMATION OR CLARIFICATION BEFORE PROCEEDING WITH THE WORK.
D.	FIELD VERIFY ALL EXISTING CONDITIONS AND DIMENSIONS. NOTIFY ARCHITECT / ENGINEER OF ANY DISCREPANCIES OR CONDITIONS REQUIRING INFORMATION OR CLARIFICATION BEFORE PROCEEDING WITH THE WORK.
E.	DETAILS SHOWN ARE INTENDED TO BE INDICATIVE OF THE PROFILES AND TYPE OF DETAILING REQUIRED THROUGHOUT THE WORK. DETAILS NOT SHOWN ARE SIMILAR IN CHARACTER TO DETAILS SHOWN. WHERE SPECIFIC DIMENSIONS, DETAILS OR DESIGN INTENT CANNOT BE DETERMINED, NOTIFY ARCHITECT / ENGINEER BEFORE PROCEEDING WITH THE WORK.
F.	ALL MANUFACTURED ARTICLES, MATERIALS AND EQUIPMENT SHALL BE APPLIED, INSTALLED, CONNECTED, ERECTED, CLEANED AND CONDITIONED ACCORDING TO MANUFACTURERS' INSTRUCTIONS. IN CASE OF DISCREPANCIES BETWEEN MANUFACTURERS' INSTRUCTIONS AND THE CONTRACT DOCUMENTS, NOTIFY ARCHITECT / ENGINEER BEFORE PROCEEDING WITH THE WORK.
G.	LARGE-SCALE, MORE SPECIFIC DETAILS TAKE PRECEDENCE OVER SMALLER-SCALE, LESS SPECIFIC DETAILS AND INFORMATION. MORE STRINGENT REQUIREMENTS FOR CODE, PRODUCTS AND INSTALLATION TAKE PRECEDENCE OVER LESS STRINGENT REQUIREMENTS. NOTIFY ARCHITECT/ENGINEER OF ANY DISCREPANCIES OR CONDITIONS REQUIRING INFORMATION OR CLARIFICATION BEFORE PROCEEDING WITH THE WORK.
H.	PROVIDE CONTINUOUS SEALANT AROUND ALL MATERIALS AT ALL INTERIOR AND EXTERIOR WALL PENETRATIONS. REFER TO SPECIFICATIONS FOR APPROPRIATE SEALANT.
I.	ALL DISSIMILAR METALS SHALL BE EFFECTIVELY ISOLATED FROM EACH OTHER TO AVOID GALVANIC CORROSION.
J.	SEAL ALL OPENINGS IN WALLS, FLOORS, CEILINGS, AND ROOFS, AROUND DUCTS, PIPES, VENTS, TRAPS, CONDUIT AND ALL OTHER PENETRATIONS WITH FIRE STOPPING AS SPECIFIED AND REQUIRED BY CODES. IF FIRE STOPPING IS NOT REQUIRED AT PENETRATIONS PER CODE, SEAL WITH CONTINUOUS SEALANT.
K.	PROVIDE TEMPORARY WALLS, ENCLOSURES, DUST SHIELDS AND WALK-OFF MATS AS REQUIRED TO SEPARATE DEMOLITION AND CONSTRUCTION FROM EXISTING BUILDING.
L.	PROVIDE BRACING AND SHORING AS REQUIRED TO PROTECT EXISTING STRUCTURE TO REMAIN. PROVIDE SECURE AND WEATHERPROOF ENCLOSURE OF TEMPORARY OPENINGS IN EXTERIOR WALLS. PROTECT ALL BUILDING COMPONENTS FROM DAMAGE DURING DEMOLITION AND CONSTRUCTION.
M.	RESTORE ALL EXISTING AREAS AFFECTED BY DEMOLITION AND RELATED NEW CONSTRUCTION TO THEIR ORIGINAL CONDITION, INCLUDING BUT NOT LIMITED TO WALLS, FLOORS, AND CEILINGS AND THEIR ASSOCIATED FINISHES.
N.	PROVIDE SOLID WALL BACKING WITH METAL OR FIRE-RETARDANT WOOD BLOCKING BEHIND DOOR HARDWARE SUCH AS WALL STOPS, BUMPERS, HOLD OPENS, ETC. AND AT ALL ITEMS REQUIRING FASTENING THROUGH GYP BD. TO BLOCKING.
O.	RENDERED IMAGES MAY NOT BE AN ACCURATE REPRESENTATION OF BUILDING CONDITIONS. REFER TO PLANS AND DETAILS CONTAINED WITHIN FOR SCOPE OF WORK.

SHEET INDEX	
SHEET #	SHEET TITLE
GENERAL	
G1-10	TITLE SHEET, SHEET INDEX, PROJECT GENERAL NOTES
G1-12	MOUNTING HEIGHTS, ABBREVIATIONS AND SYMBOLS, HORIZONTAL ASSEMBLIES
G2-20	FIRST AND SECOND FLOOR CODE PLANS AND CODE DATA
ARCHITECTURAL	
A1-11	FIRST FLOOR DEMOLITION PLAN - OVERALL
A1-11A	FIRST FLOOR DEMOLITION PLAN - AREA A
A1-11B	FIRST AND SECOND FLOOR DEMOLITION PLAN - AREA B
A1-12	SECOND FLOOR DEMOLITION PLAN - OVERALL
A1-12A	SECOND FLOOR DEMOLITION PLAN - AREA A
A1-13	FIRST FLOOR REFLECTED CEILING DEMOLITION PLAN - OVERALL
A1-13A	FIRST FLOOR REFLECTED CEILING DEMOLITION PLAN - AREA A
A1-13B	FIRST AND SECOND FLOOR REFLECTED CEILING DEMOLITION PLANS - AREA B
A1-14	SECOND FLOOR REFLECTED CEILING DEMOLITION PLAN - OVERALL
A1-14A	SECOND FLOOR REFLECTED CEILING DEMOLITION PLAN - AREA A
A1-21	FIRST FLOOR PLAN - OVERALL
A1-21A	FIRST FLOOR PLAN - AREA A & DOOR SCHEDULE, DOOR AND FRAME TYPES
A1-21B	FIRST AND SECOND FLOOR PLAN - AREA B
A1-22	SECOND FLOOR PLAN - OVERALL
A1-22A	SECOND FLOOR PLAN - AREA A
A1-31	FIRST FLOOR REFLECTED CEILING PLAN - OVERALL
A1-31A	FIRST FLOOR REFLECTED CEILING PLAN - AREA A AND CEILING DETAILS
A1-31B	FIRST AND SECOND FLOOR REFLECTED CEILING PLANS - AREA B
A1-32	SECOND FLOOR REFLECTED CEILING PLAN - OVERALL
A1-32A	SECOND FLOOR REFLECTED CEILING PLAN - AREA A
A5-11	ENLARGED FLOOR PLANS
INTERIOR DESIGN	
I1-21	FIRST FLOOR FINISH PLAN - OVERALL
I1-21A	FIRST FLOOR FINISH PLAN - AREA A
I1-21B	FIRST AND SECOND FLOOR FINISH PLAN - AREA B
I1-22	SECOND FLOOR FINISH PLAN - OVERALL
I1-22A	SECOND FLOOR FINISH PLAN - AREA A
I1-41	FIRST FLOOR SIGNAGE PLAN - OVERALL
I1-41A	FIRST FLOOR SIGNAGE PLAN - AREA A
I1-41B	FIRST AND SECOND FLOOR SIGNAGE PLAN - AREA B
I1-42	SECOND FLOOR SIGNAGE PLAN - OVERALL
I1-42A	SECOND FLOOR SIGNAGE PLAN - AREA A
I4-11	FINISH LEGENDS, SCHEDULES, AND DETAILS
PLUMBING	
P2-12	FIRST FLOOR PLUMBING PLAN
P2-13	SECOND FLOOR PLUMBING PLAN
ELECTRICAL	
E2-11A	FIRST FLOOR POWER AND SYSTEMS PLAN - AREA A
E2-12A	SECOND FLOOR POWER AND SYSTEMS PLAN - AREA A
E5-11	ELECTRICAL SYMBOLS, PANELBOARDS SCHEDULES

SEAL	I HEREBY CERTIFY THAT THE PORTION OF THIS TECHNICAL SUBMISSION DESCRIBED BELOW WAS PREPARED BY ME OR UNDER MY DIRECT SUPERVISION AND RESPONSIBLE CHARGE. I AM A DULY LICENSED ARCHITECT UNDER THE LAWS OF THE STATE OF IOWA.
	SIGNATURE <i>Gladys Petersen</i> DATE 09/08/26
	PRINTED SIGNATURE GLADYS PETERSEN
	LICENSE NUMBER ARC08590 LICENSE RENEWAL DATE 06/30/27
	SHEETS COVERED BY THIS SEAL:
	G1-10 A1-12A A1-21A A1-32 I1-22A
	G1-12 A1-13 A1-21B A1-32A I1-41
	G2-20 A1-13A A1-22 A5-11 I1-41A
	A1-11 A1-13B A1-22A I1-21 I1-41B
	A1-11A A1-14 A1-31 I1-21A I1-42
	A1-11B A1-14A A1-31A I1-21B I1-42A
	A1-12 A1-21 A1-31B I1-22 I4-11

SEAL	I HEREBY CERTIFY THAT THE PORTION OF THIS TECHNICAL SUBMISSION DESCRIBED BELOW WAS PREPARED BY ME OR UNDER MY DIRECT SUPERVISION AND RESPONSIBLE CHARGE. I AM A DULY LICENSED ARCHITECT UNDER THE LAWS OF THE STATE OF IOWA.
	SIGNATURE <i>Casey G. Larsen</i> DATE 09/08/26
	PRINTED SIGNATURE CASEY G. LARSEN
	LICENSE NUMBER P26594 LICENSE RENEWAL DATE 12/31/26
	SHEETS COVERED BY THIS SEAL:
	E2-11A
	E2-12A
	E5-11

SEAL	I HEREBY CERTIFY THAT THE PORTION OF THIS TECHNICAL SUBMISSION DESCRIBED BELOW WAS PREPARED BY ME OR UNDER MY DIRECT SUPERVISION AND RESPONSIBLE CHARGE. I AM A DULY LICENSED ARCHITECT UNDER THE LAWS OF THE STATE OF IOWA.
	SIGNATURE <i>Adam W. Puls</i> DATE 09/08/26
	PRINTED SIGNATURE ADAM W. PULS
	LICENSE NUMBER P23206 LICENSE RENEWAL DATE 12/31/27
	SHEETS COVERED BY THIS SEAL:
	P2-12
	P2-13

PROJECT INDEX:


OWNER:	PROJECT ADDRESS:	MANAGING OFFICE:
IOWA ARMY NATIONAL GUARD 7105 NW 70TH AVE JOHNSTON, IOWA 50131	S-54 7105 NW 70TH AVE CAMP DODGE, JOHNSTON, IOWA 50131	I & S GROUP, INC. (ISG) DES MOINES OFFICE 217 EAST 2ND STREET SUITE 110 DES MOINES, IOWA 50309 PHONE: 515.243.9143 PROJECT MANAGER: ZACH THOMPSON EMAIL: ZACH.THOMPSON@ISGINC.COM

TITLE SHEET,
SHEET INDEX,
PROJECT
GENERAL NOTES

SHEET
G1-10

FIXTURE CLEARANCES

DESCRIPTION		FIXTURE GROUPS	
		R1	
		ADULTS (≥12 YR)	
		A ACCESSIBLE	S STANDARD
WCC	WATER CLOSET CENTER LINE	17" - 18"	16" - 18"
WCS	WATER CLOSET SEAT HEIGHT	17" - 19"	17" - 19"
TPH	TOILET TISSUE DISPENSER HEIGHT	18" - 48"	18" - 48"
GBH	GRAB BAR HEIGHT	33" - 36"	NA
VBR	VERTICAL GRAB BAR HEIGHT	39" - 41"	NA
VCB	VERTICAL GRAB BAR CENTERLINE	39" - 41"	NA
URR	URINAL RIM HEIGHT	17"	24"
TSK	TOP OF SINK OR COUNTER HEIGHT	34"	34"
KCH	KNEE CLEARANCE HEIGHT	27"	27"
LHD	HIGH DRINKING FOUNTAIN SPOUT HEIGHT	38" - 43"	38" - 43"
LSD	LOW DRINKING FOUNTAIN SPOUT HEIGHT	36"	36"
DD	DRINKING FOUNTAIN SPOUT DEPTH	5"	5"

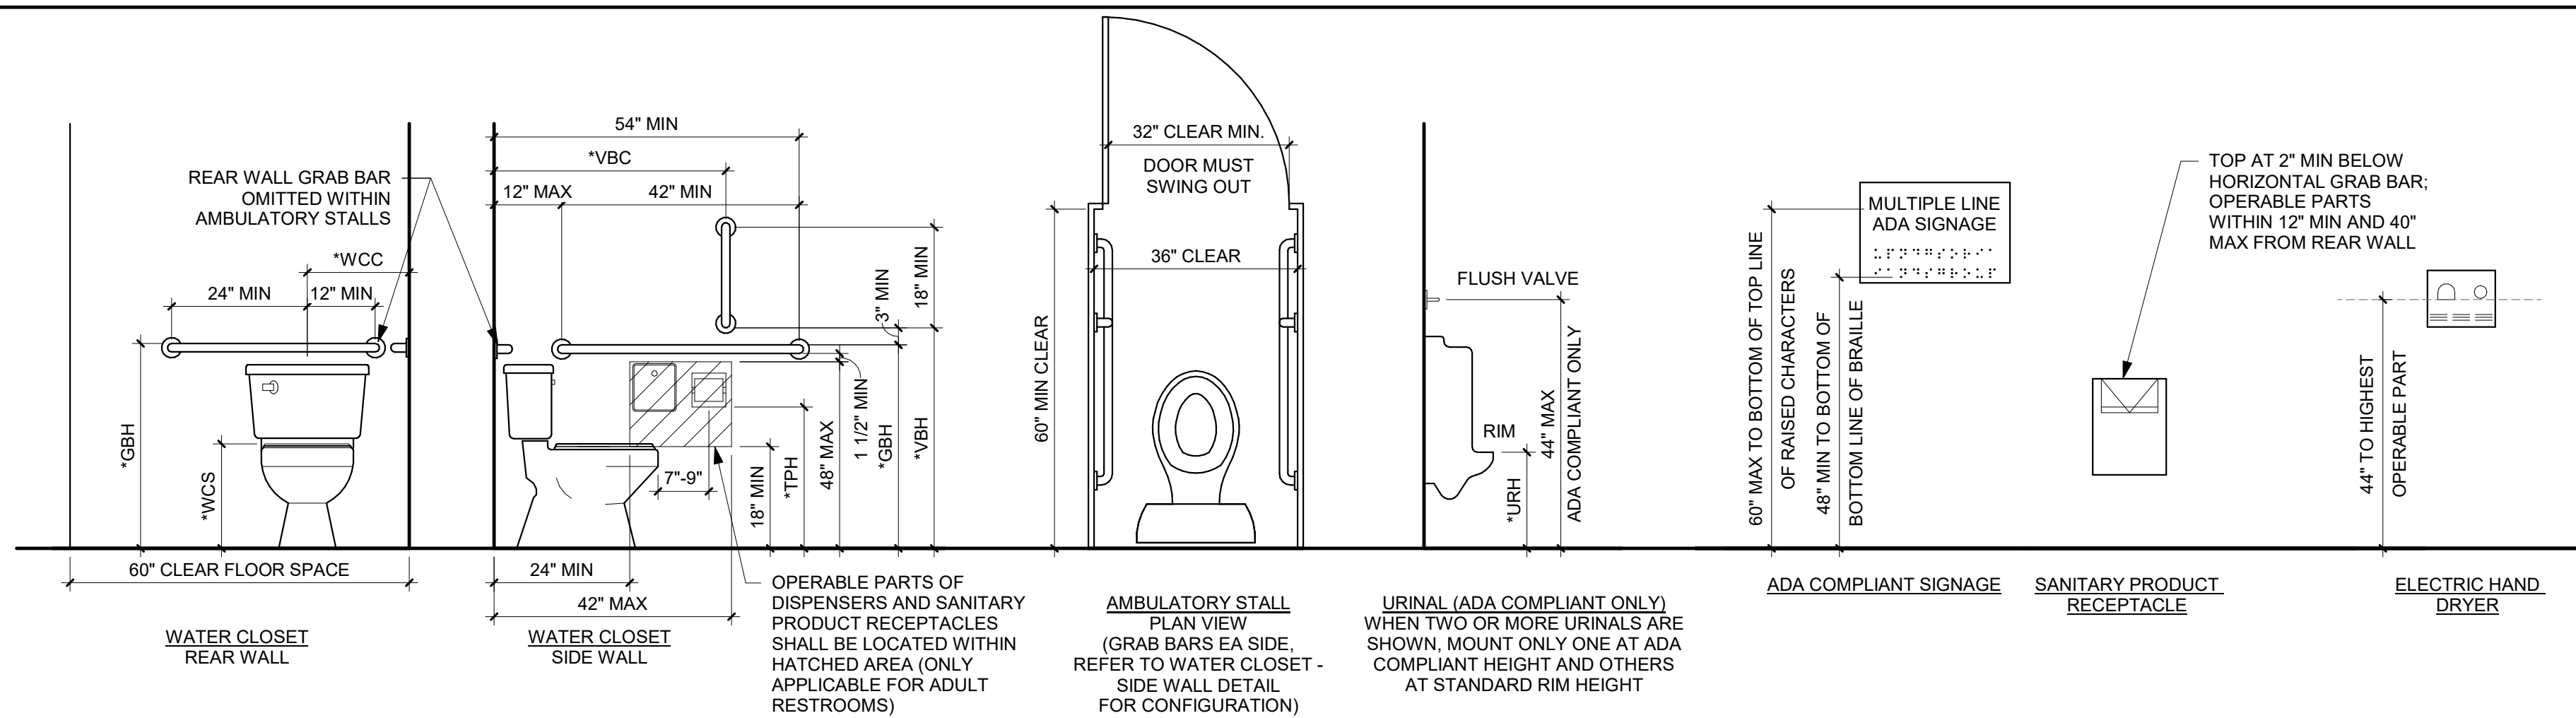[illegible][illegible]

	BATT INSULATION
	BRICK
	CONCRETE (SECTION)
	CMU (SECTION)
	EARTH
	GRANULAR FILL
	GRAVEL
	GYPSUM BOARD OR SHEATHING
	RIGID INSULATION
	PLYWOOD
	SAND
	STEEL
	SYNTHETIC STUCCO
	WOOD
	SPRAY IN PLACE INSULATION

SECTION

SECTION NUMBER

SHEET NUMBER

INTERIOR / EXTERIOR ELEVATION

ELEVATION NUMBER

SHEET NUMBER

DENOTES ANNOTATION IS REFERENCING ANOTHER VIEW

DETAIL CALLOUT

DETAIL NUMBER

SHEET NUMBER

AREA OF DETAIL

DRAWING TITLE



VIEW NAME

$1/8" = 1'-0"$


ELEVATION

LEVEL 1

100'-0"

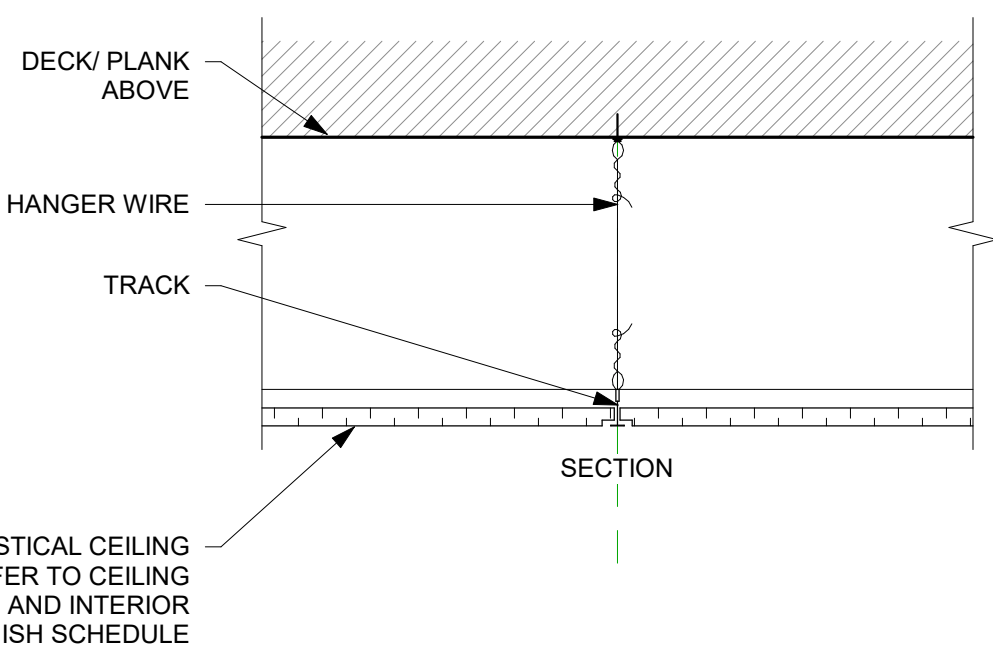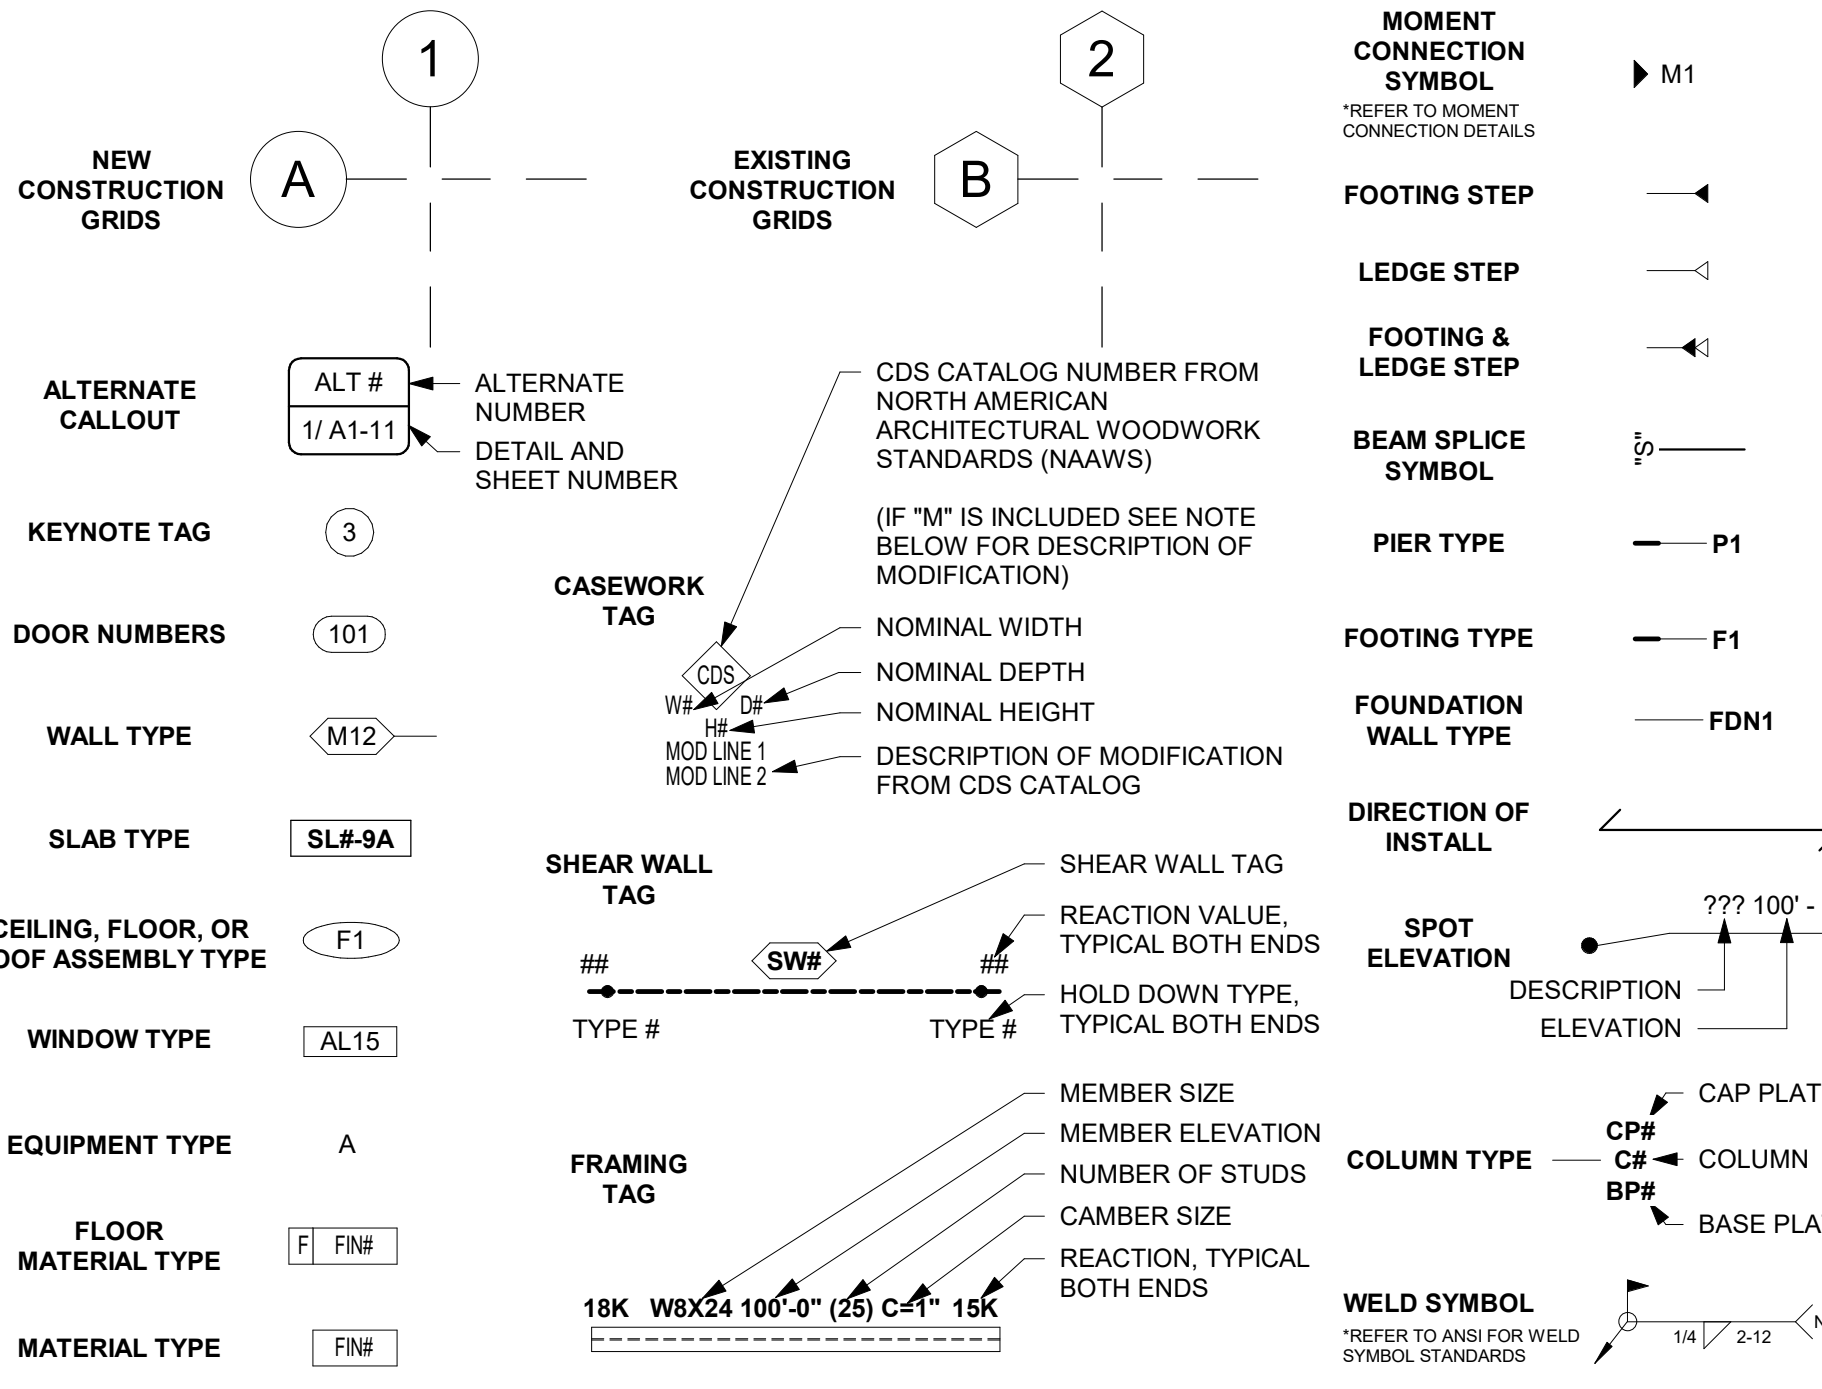

CEILING ASSEMBLY ACT-1
NOT TO SCALE

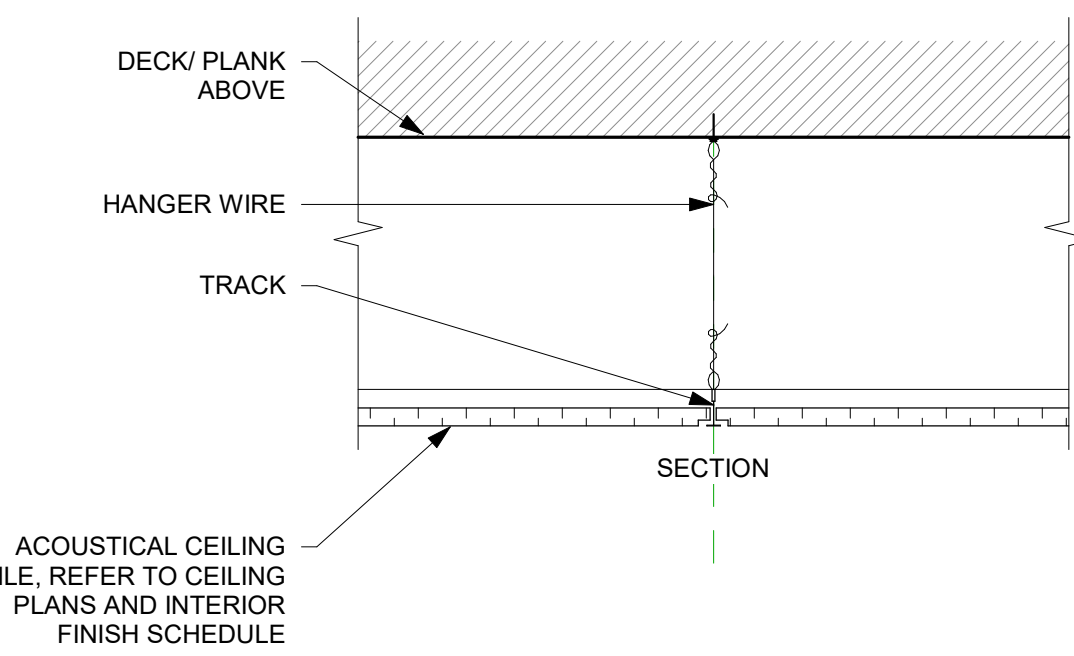

CEILING ASSEMBLY ACT-2
NOT TO SCALE

PROJECT

IOWA ARMY NATIONAL GUARD S54 FINISH UPGRADES

CAMP DODGE, JOHNSTON	IOWA
----------------------	------

[illegible]


PROJECT NO.	26-34920
FILE NAME	34920 Arch R26
DRAWN BY	MJT
DESIGNED BY	GMP
REVIEWED BY	GMP
ORIGINAL ISSUE DATE	09/08/26
CLIENT PROJECT NO.	19083733

TITLE

MOUNTING HEIGHTS, ABBREVIATIONS AND SYMBOLS, HORIZONTAL ASSEMBLIES


SHEET

G1-12

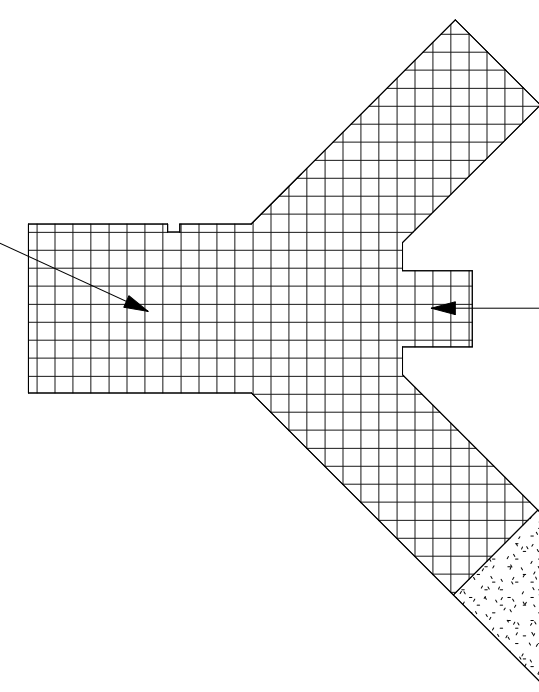


BUILDING C: 2020 ADDITION (NO WORK THIS AREA)
GROUP R-1
TYPE V-B CONSTRUCTION
NFPA 13R AUTO SPRINKLER THROUGHOUT
2 STORIES
3,150 SF/FLOOR

3 CODE KEY
NOT TO SCALE

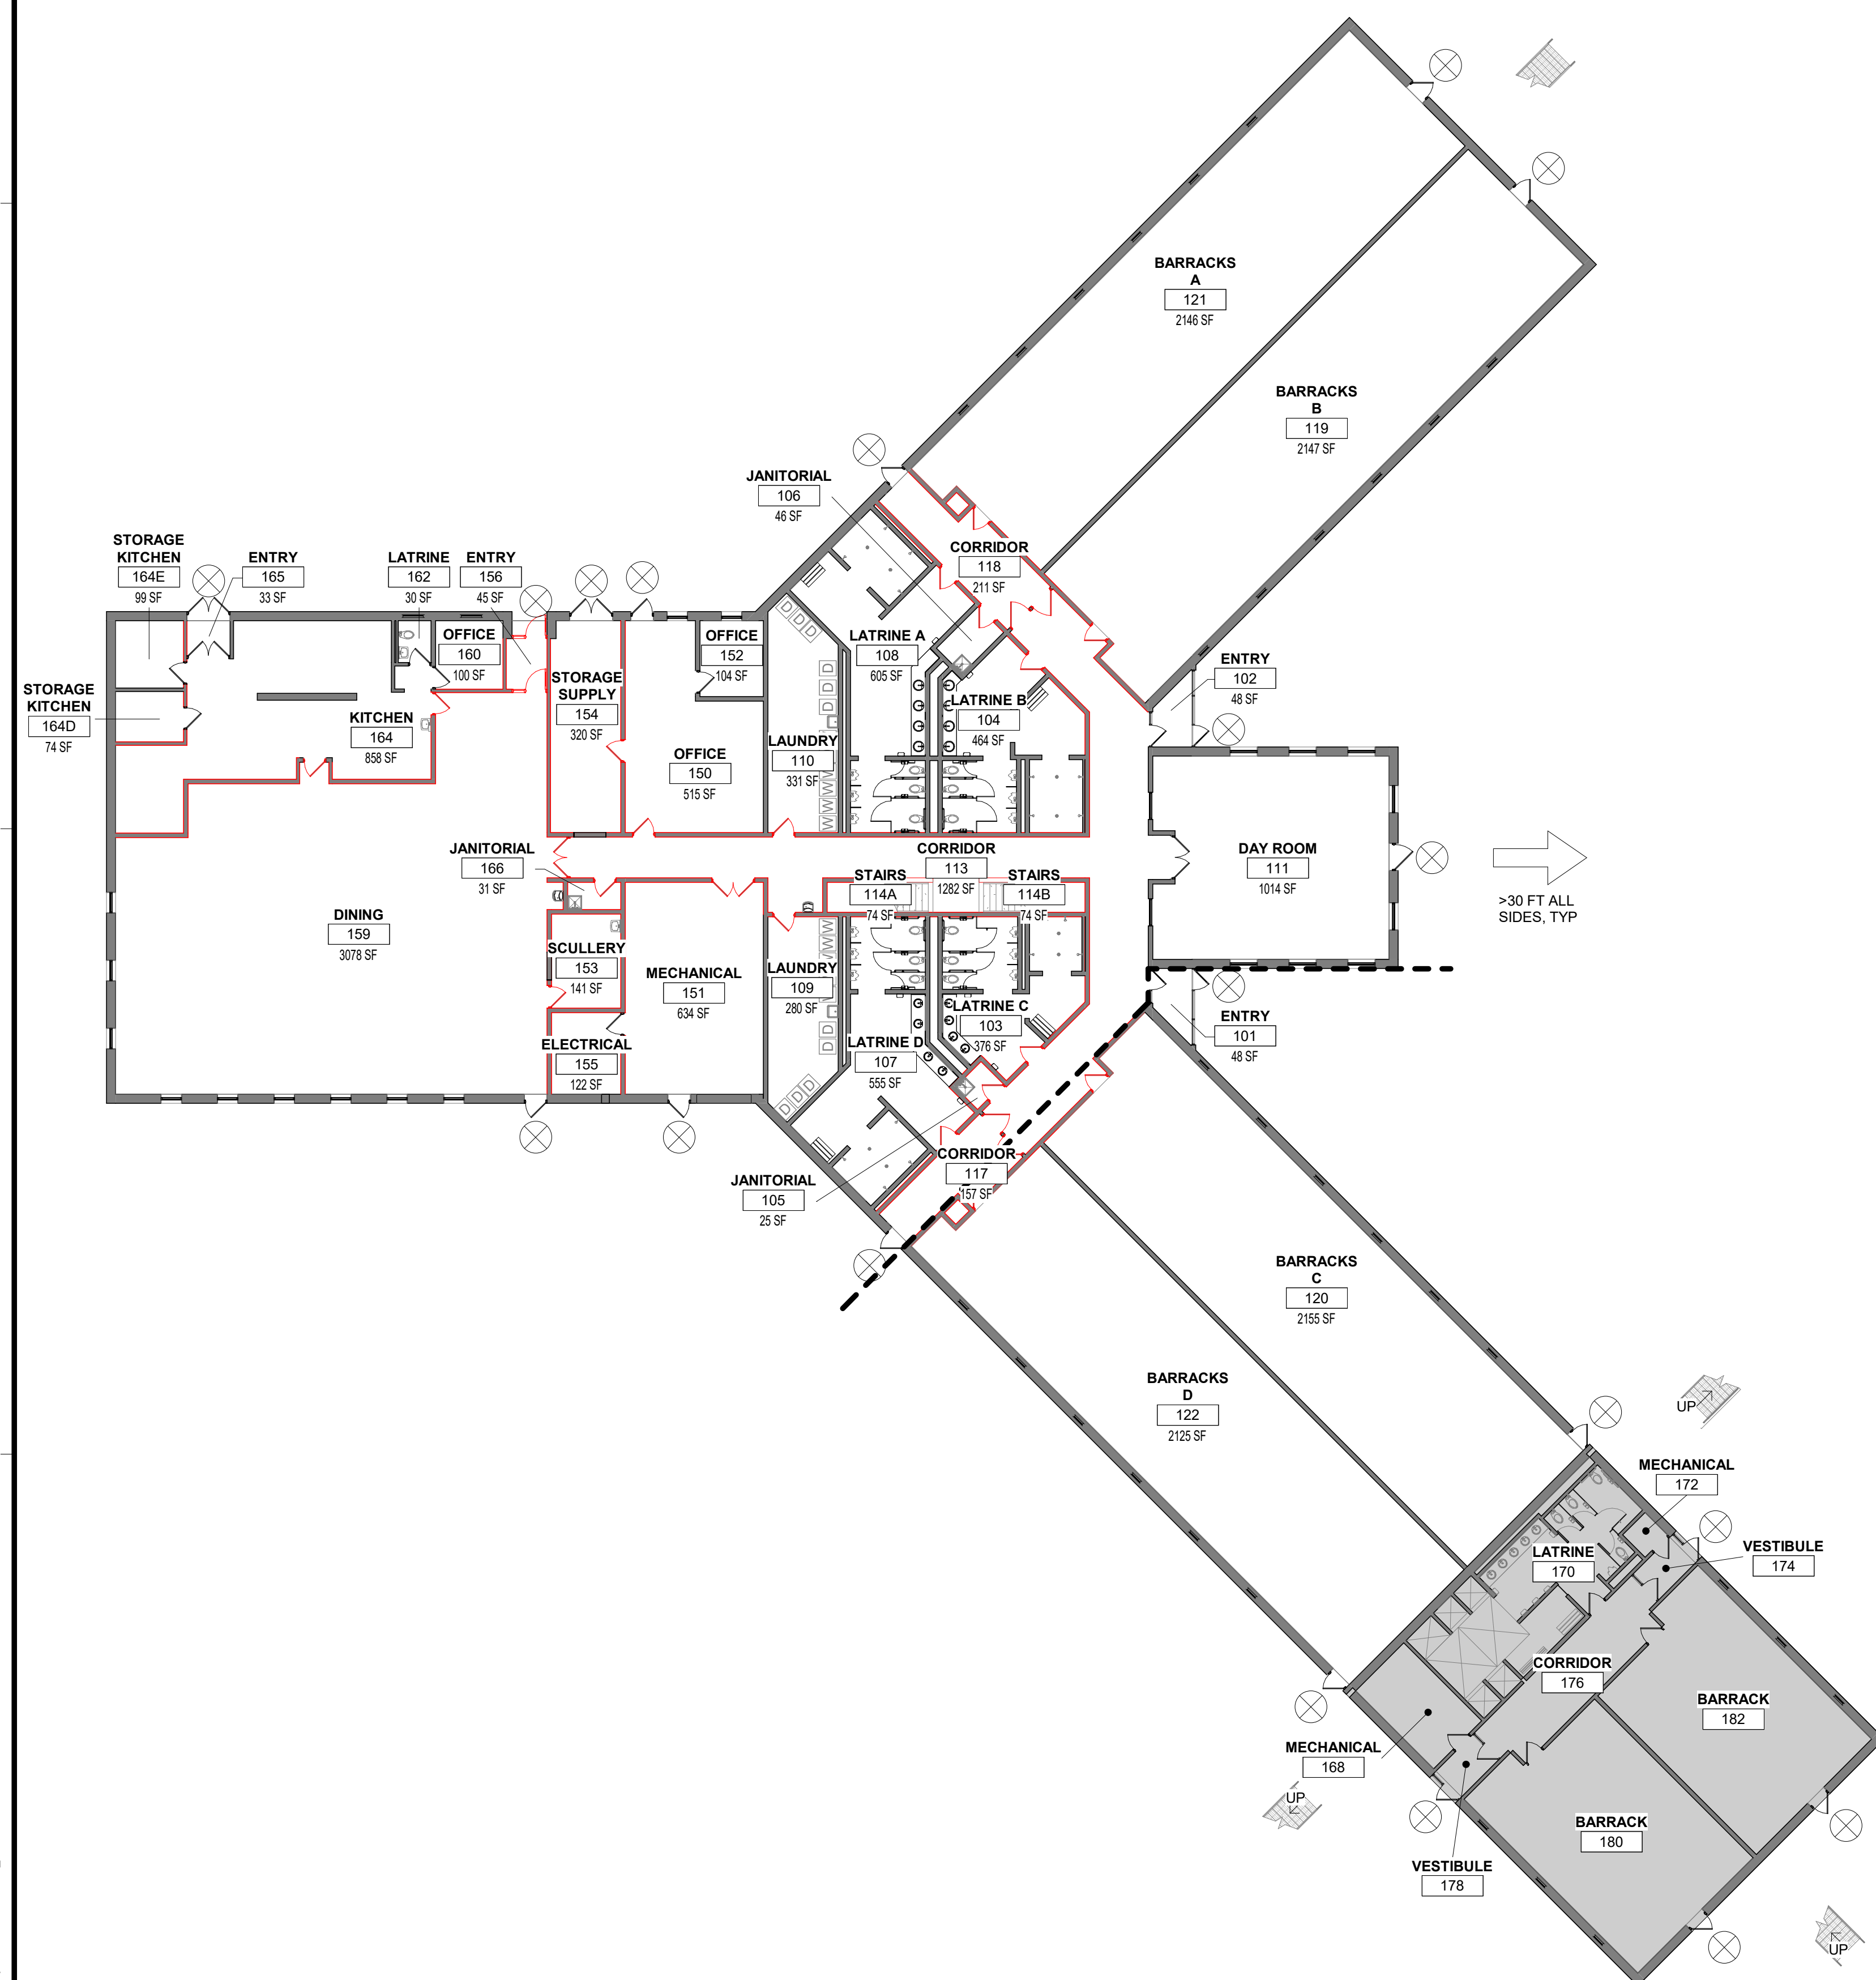

1 CODE D
1/16" = 1'-0"

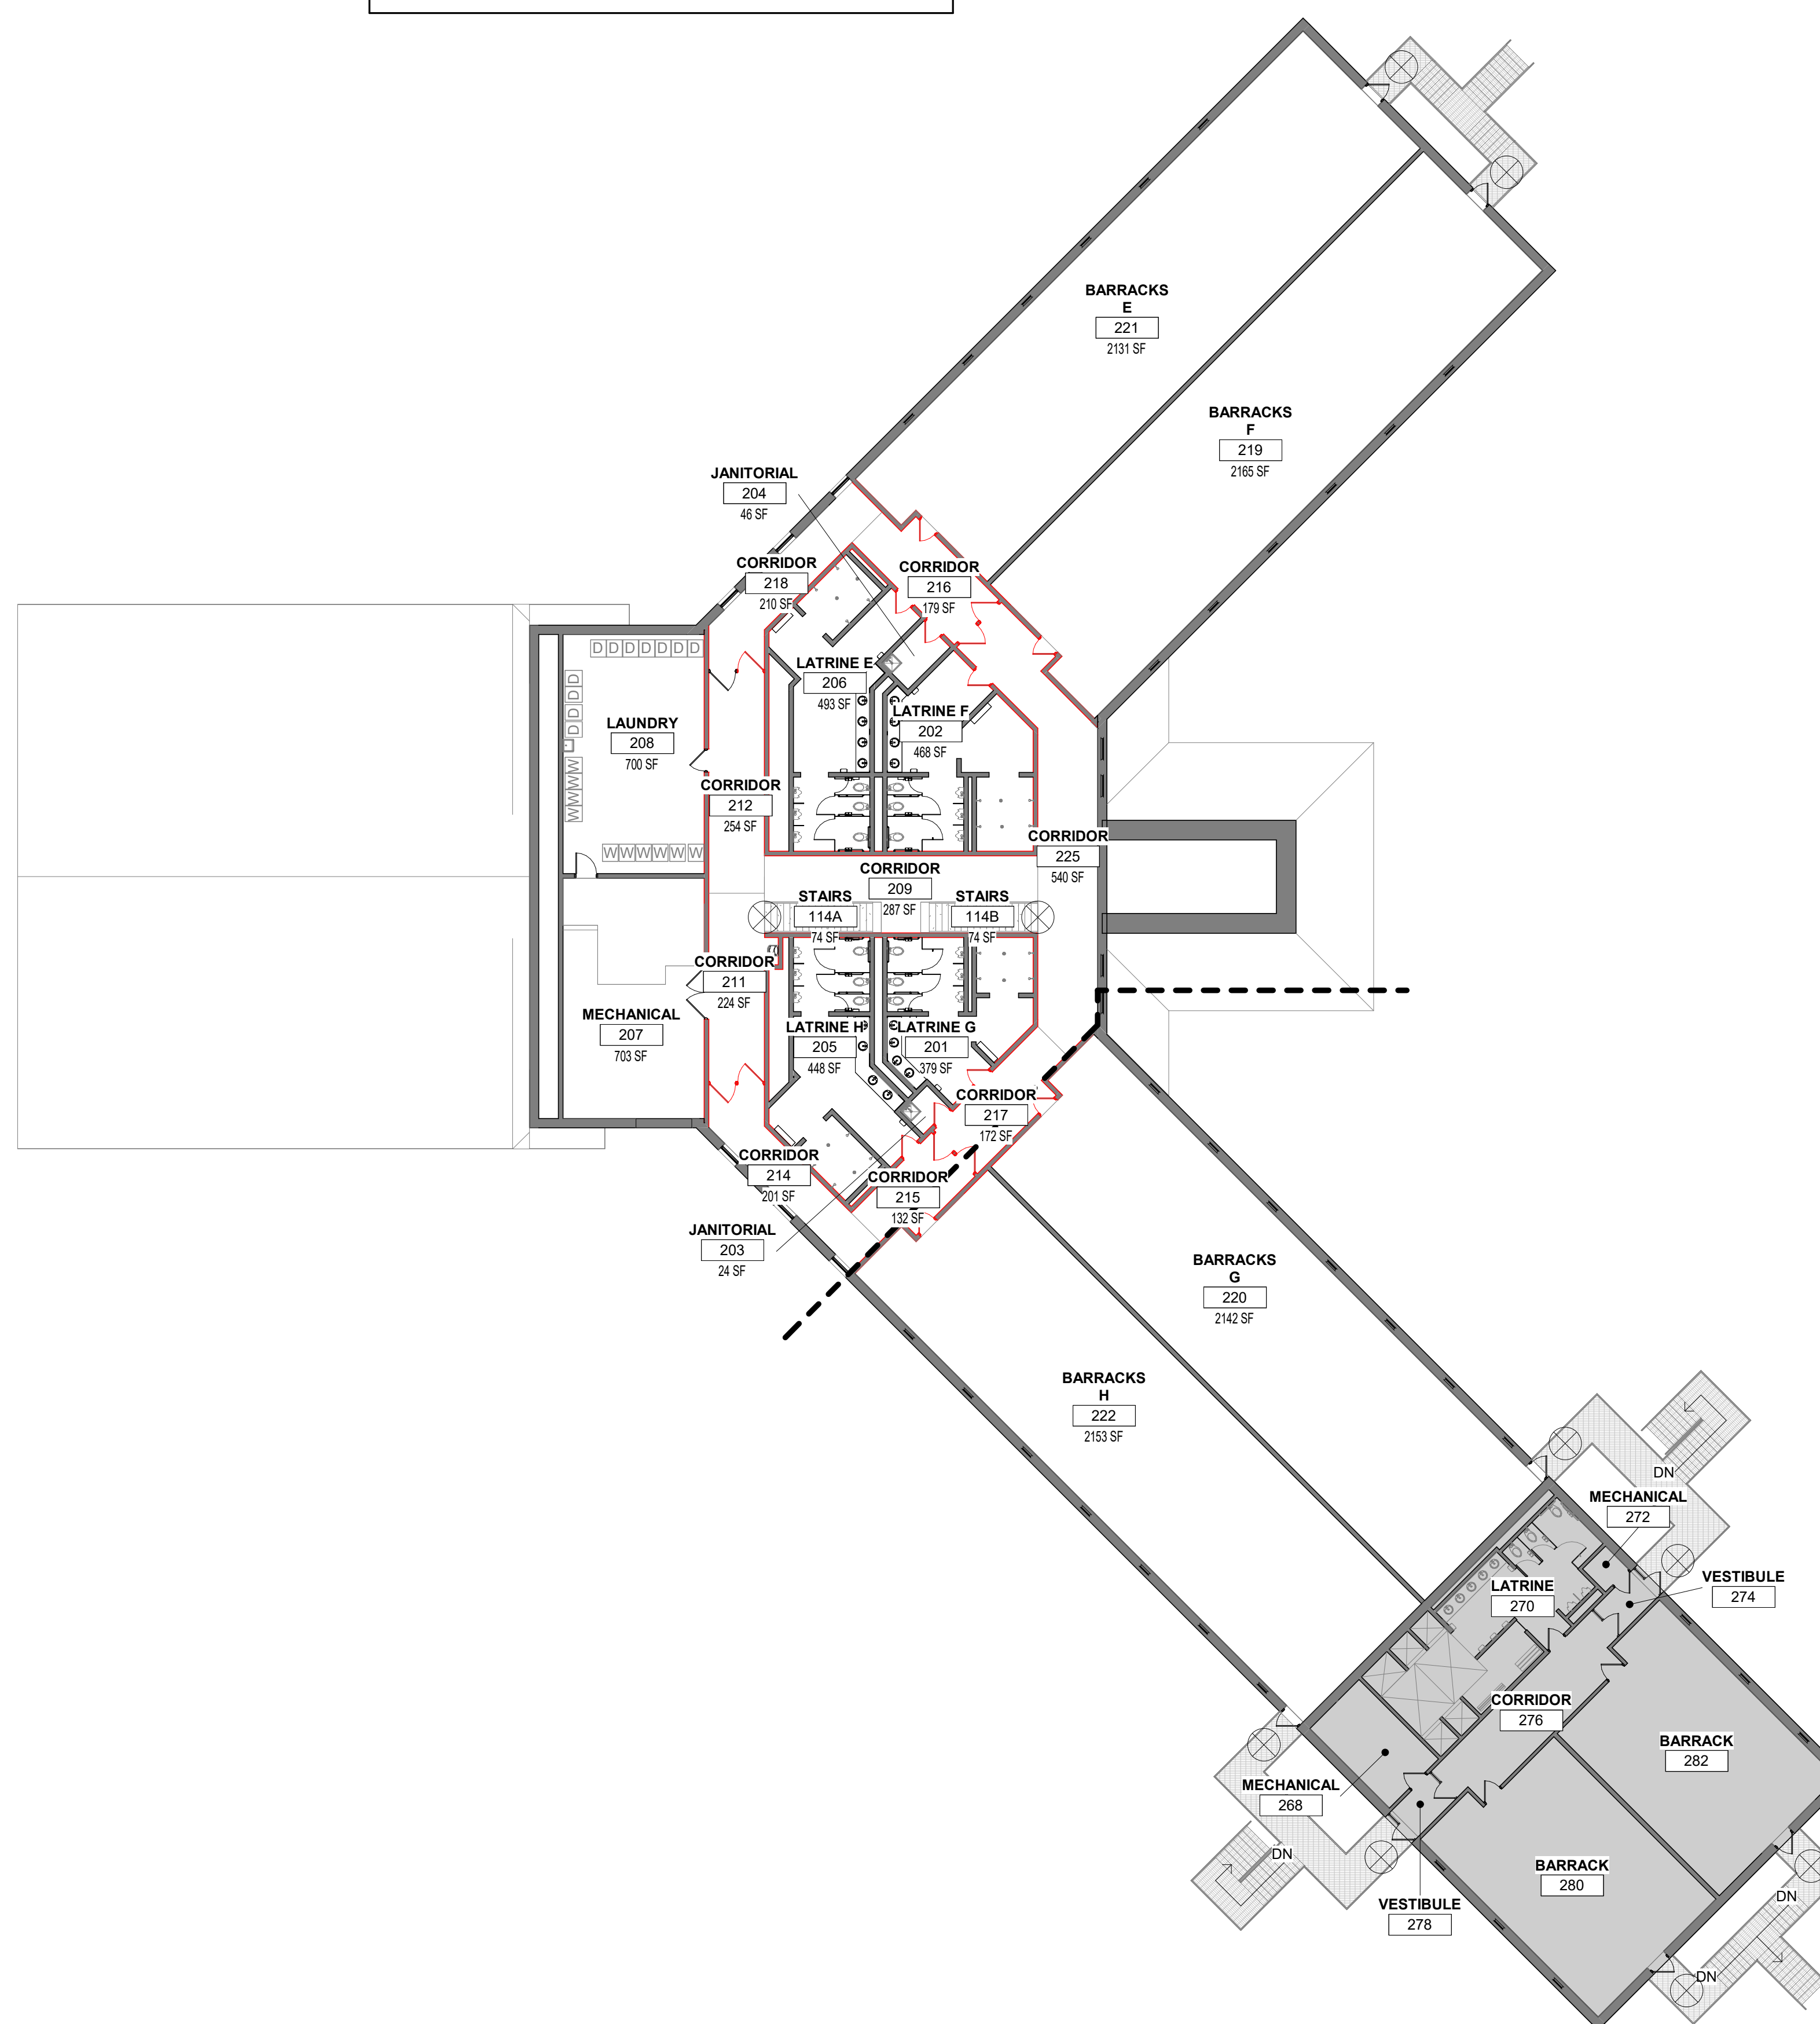

2 CODE D
1/16" = 1'-0"

ADOPTED BUILDING CODES

UFC 1-200-01 UNIFIED FACILITIES CRITERIA (UFC) DEPARTMENT OF
 DEFENSE BUILDING CODE
 BASED ON 2004 INTERNATIONAL BUILDING CODE
 2024 INTERNATIONAL BUILDING CODE AS ADOPTED BY IOWA
 ADMINISTRATIVE RULE CHAPTERS 481-280 AND 481-301
 2024 INTERNATIONAL FIRE CODE AS ADOPTED BY IOWA ADMINISTRATIVE
 RULE CHAPTER 481-280
 2012 INTERNATIONAL ENERGY CONSERVATION CODE AS ADOPTED BY
 IOWA ADMINISTRATIVE RULE CHAPTER 481-280
 2012 NFPA 101 LIFE SAFETY CODE AS ADOPTED BY IOWA ADMINISTRATIVE
 RULE CHAPTER 481-280
 2012 NFPA 101 LIFE SAFETY CODE AS ADOPTED BY IOWA ADMINISTRATIVE
 RULE CHAPTER 481-280
 CARBON MONOXIDE ALARMS AS ADOPTED BY IOWA ADMINISTRATIVE
 RULE CHAPTER 481-280
 STATE MECHANICAL CODE AS ADOPTED BY THE DEPARTMENT OF PUBLIC
 HEALTH IOWA ADMINISTRATIVE RULE CHAPTER 481-426
 2012 IOWA MECHANICAL CODE AS ADOPTED BY THE DEPARTMENT OF PUBLIC
 HEALTH IOWA ADMINISTRATIVE RULE CHAPTER 481-426
 STATE ELECTRICAL CODE AS ADOPTED BY THE STATE ELECTRICAL
 BOARD IOWA ADMINISTRATIVE RULE CHAPTERS 481-404 AND 481-404A

ACCESSIBILITY CODES AND STANDARDS

UFC 1-200-01 UNIFIED FACILITIES CRITERIA (UFC) DEPARTMENT OF
DEFENSE BUILDING CODE
(BASED ON 2024 INTERNATIONAL BUILDING CODE)
ABA STANDARDS AND DEPARTMENT OF DEFENSE POLICY MEMORANDUM
ACCESSIBILITY STANDARDS FOR DEPARTMENT OF DEFENSE FACILITIES
2010 AMERICANS WITH DISABILITIES ACT AS ADOPTED BY IOWA
ADMINISTRATIVE RULE CHAPTER 481-301

OCCUPANCY CLASSIFICATION AND USE

RESIDENTIAL R-1

FIRE PROTECTION SYSTEMS


NONSPRINKLERED

CONSTRUCTION TYPE

TYPE VB

EXISTING BUILDING ALTERATION: LEVEL 1 ALTERNATION


WORK IS LIMITED TO REPLACEMENT OF INTERIOR FINISHES, PLUMBING FIXTURES, TOILET PARTITIONS, TOILET ACCESSORIES, COUNTERTOPS, CEILING, SIGNAGE, AND RELATED INCIDENTAL WORK. NO CHANGE IN OCCUPANCY CLASSIFICATION, OCCUPANT LOAD, BUILDING AREA, BUILDING HEIGHT, MEANS OF EGRESS, OR FIRE-RESISTANCE-RATED CONSTRUCTION IS PROPOSED. WORK IS CLASSIFIED AS A LEVEL 1 ALTERATION UNDER THE 2024 INTERNATIONAL EXISTING BUILDING CODE (IEBC) AND SHALL BE CONSIDERED A TYPE III ALTERATION WHERE SPECIFICALLY REQUIRED BY THE IEBC. NEW MATERIALS AND ALTERED ELEMENTS SHALL COMPLY WITH THE CURRENTLY ADOPTED CODES AND ACCESSIBILITY STANDARDS WITHIN THE SCOPE OF WORK.

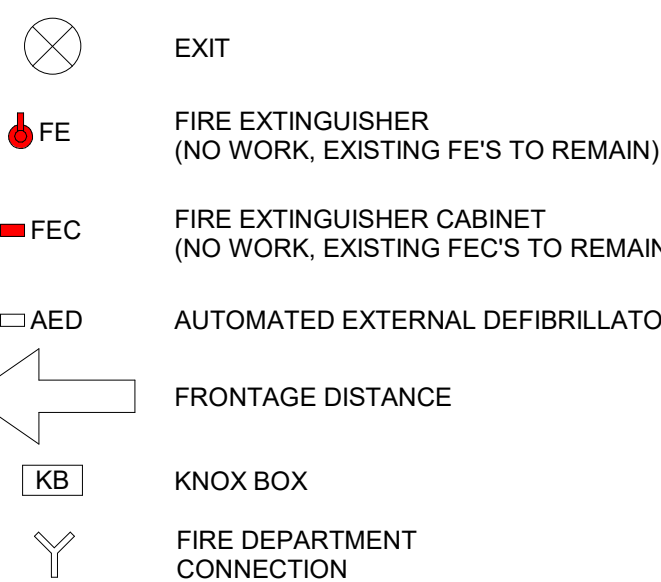

FIRE WALLS, FIRE BARRIERS, FIRE PARTITIONS, SMOKE BARRIERS AND SMOKE PARTITIONS OR ANY OTHER WALL REQUIRED TO HAVE PROTECTED OPENINGS OR PENETRATIONS SHALL BE EFFECTIVELY AND PERMANENTLY IDENTIFIED WITH SIGNS OR STENCILING. SUCH IDENTIFICATION SHALL:



- 1. BE LOCATED IN ACCESSIBLE CONCEALED FLOOR, CEILING OR AT SPACES**
- 2. BE LOCATED WITHIN 15 FEET OF THE END OF EACH WALL, AND AT INTERVALS NOT EXCEEDING 30 FEET MEASURED HORIZONTALLY ALONG THE WALL OR PARTITION, AND**
- 3. INCLUDE LETTERING NOT LESS THAN 3 INCHES IN HEIGHT WITH A MINIMUM 3/8" STROKE IN A CONTRASTING COLOR INDICATING THE PROTECTED WORKING FIRE AND/OR SMOKE BARRIER - PROTECT ALL OPENINGS" OR OTHER SIMILAR WORDING.**

 EXISTING CONSTRUCTION TO REMAIN

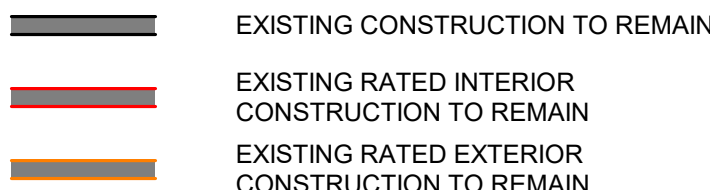

CONTRACTOR TO VERIFY EXISTING RATED WALL
CONSTRUCTION IN FIELD AND REPORT ANY
DISCREPANCIES TO THE PROJECT ARCHITECT.

 SHADED REGION INDICATES AREA OF PLANS THAT

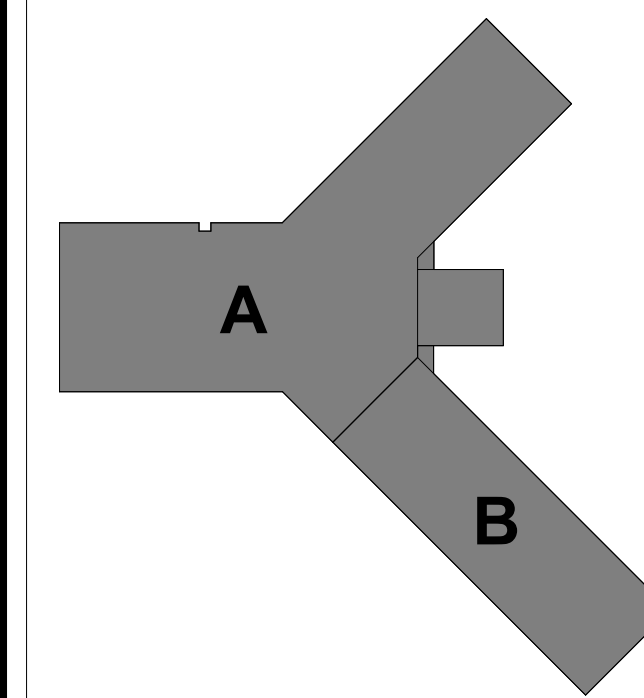

SHEET NOT VALID UNLESS THIS TEXT IS COLORED

THIS DOCUMENT IS THE PROPERTY OF I & S GROUP, INC. AND MAY NOT BE USED, COPIED OR DUPLICATED WITHOUT PRIOR WRITTEN CONSENT.
© 2024 I & S GROUP, INC.

PROJECT

CAMP DODGE, JOHNSTON IOWA

[illegible]

PROJECT NO.	26-34920
-------------	----------

FILE NAME	34920 Arch R26
-----------	----------------

DRAWN BY MJT

DESIGNED BY	GM
-------------	----

REVIEWED BY	GM
-------------	----

ORIGINAL ISSUE DATE 09/08/26

CLIENT PROJECT NO. 19083733


TITLE

SHEE

G2-20

REFERENCE SCALE
1" = 1'-0"
0 1/4" 1/2" 1" 2"


1 FIRST FLOOR DEMOLITION PLAN - OVERALL
3/32" = 1'-0"

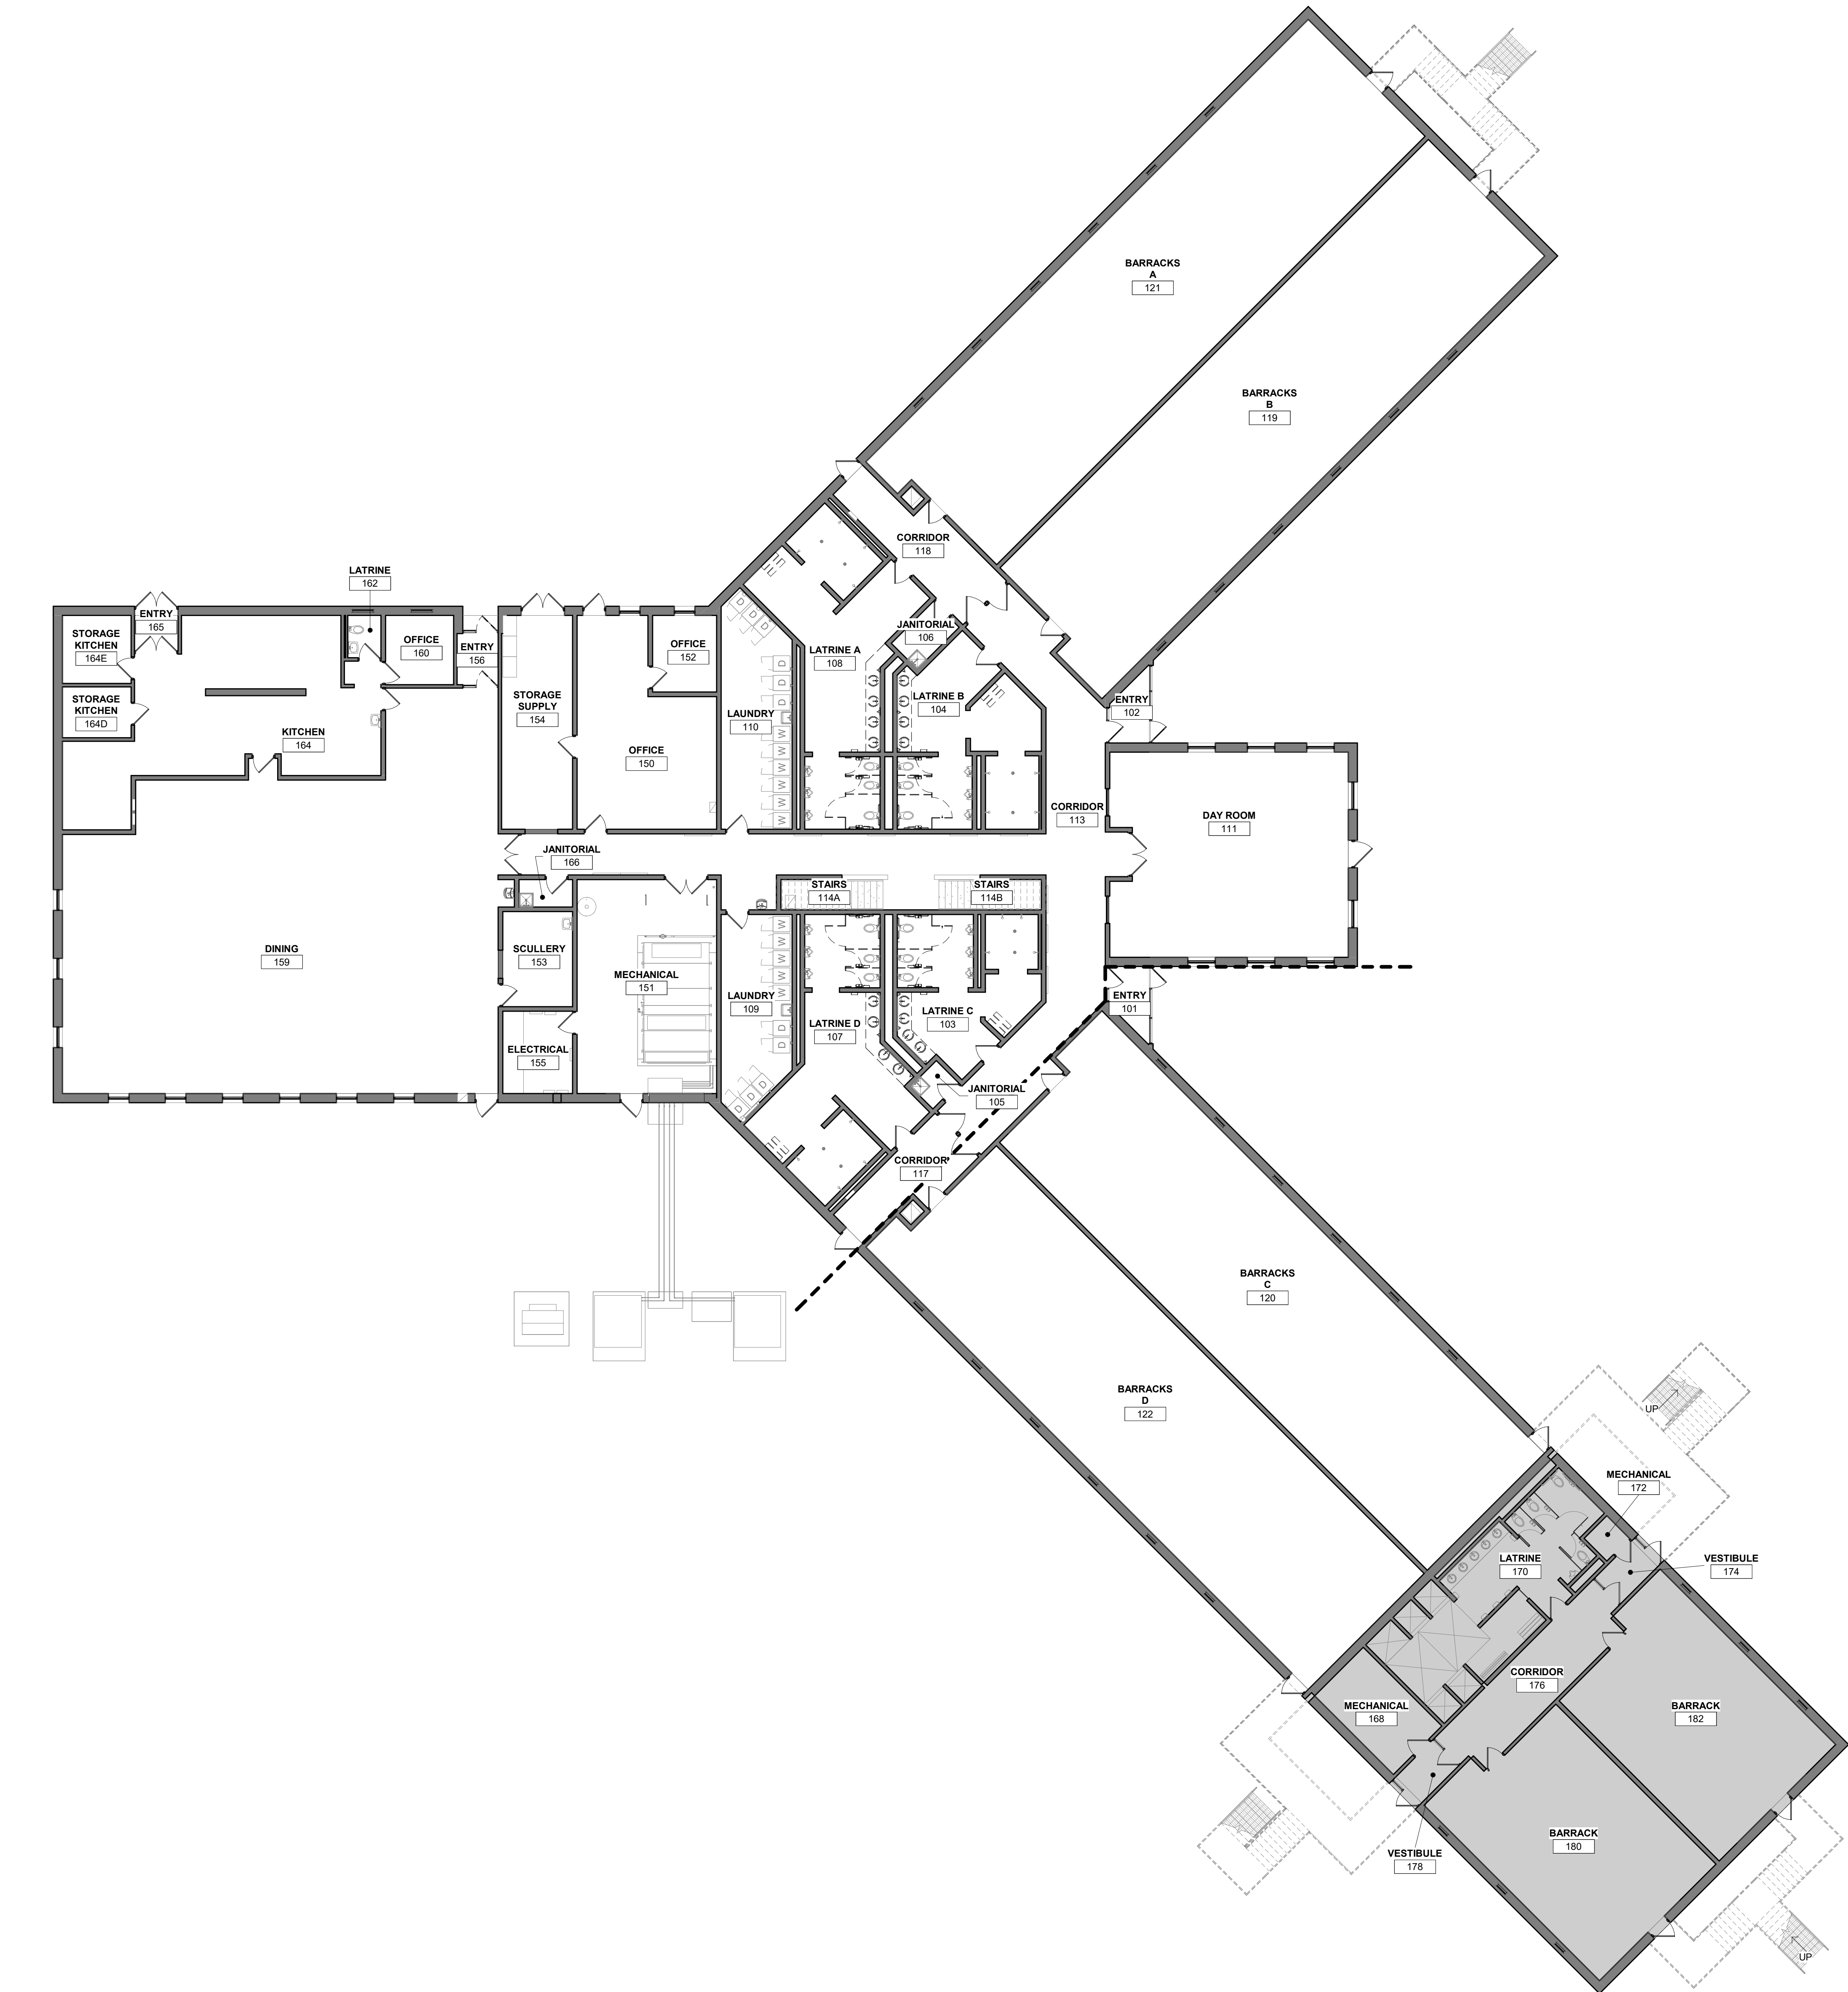

FLOOR PLAN LEGEND

SHADED REGION INDICATES AREA OF PLANS THAT ARE NOT INCLUDED IN SCOPE OF WORK.

ISG

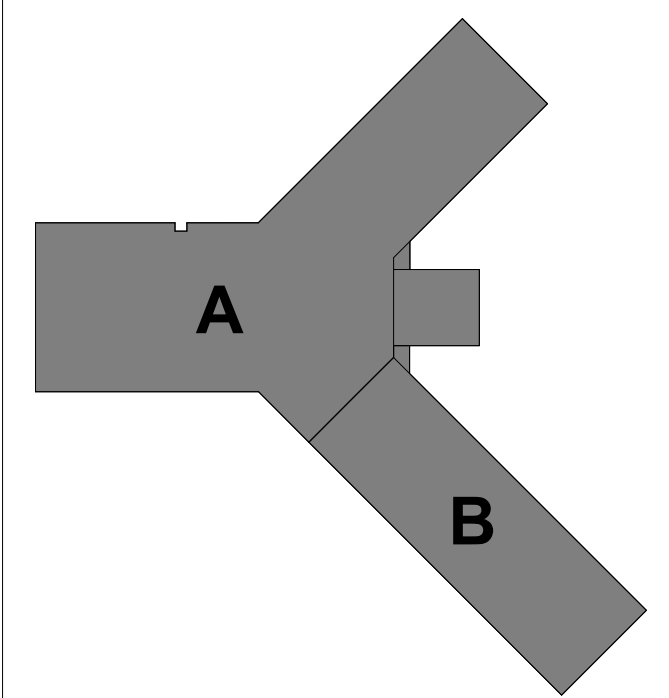

KEYPLAN

THIS DOCUMENT IS THE PROPERTY OF I & S GROUP, INC. AND MAY NOT BE USED, COPIED OR DUPLICATED WITHOUT PRIOR WRITTEN CONSENT.
© 2024 I & S GROUP, INC.

PROJECT

IOWA ARMY
NATIONAL GUARD
S54 FINISH
UPGRADES

CAMP DODGE, JOHNSTON IOWA

REVISION SCHEDULE		
DATE	DESCRIPTION	BY


PROJECT NO.	26-34920
FILE NAME	34920 Arch R26
DRAWN BY	MJT
DESIGNED BY	GMP
REVIEWED BY	GMP
ORIGINAL ISSUE DATE	09/08/26
CLIENT PROJECT NO.	19083733


TITLE

FIRST FLOOR
DEMOLITION
PLAN - OVERALL

SHEET

A1-11

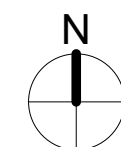

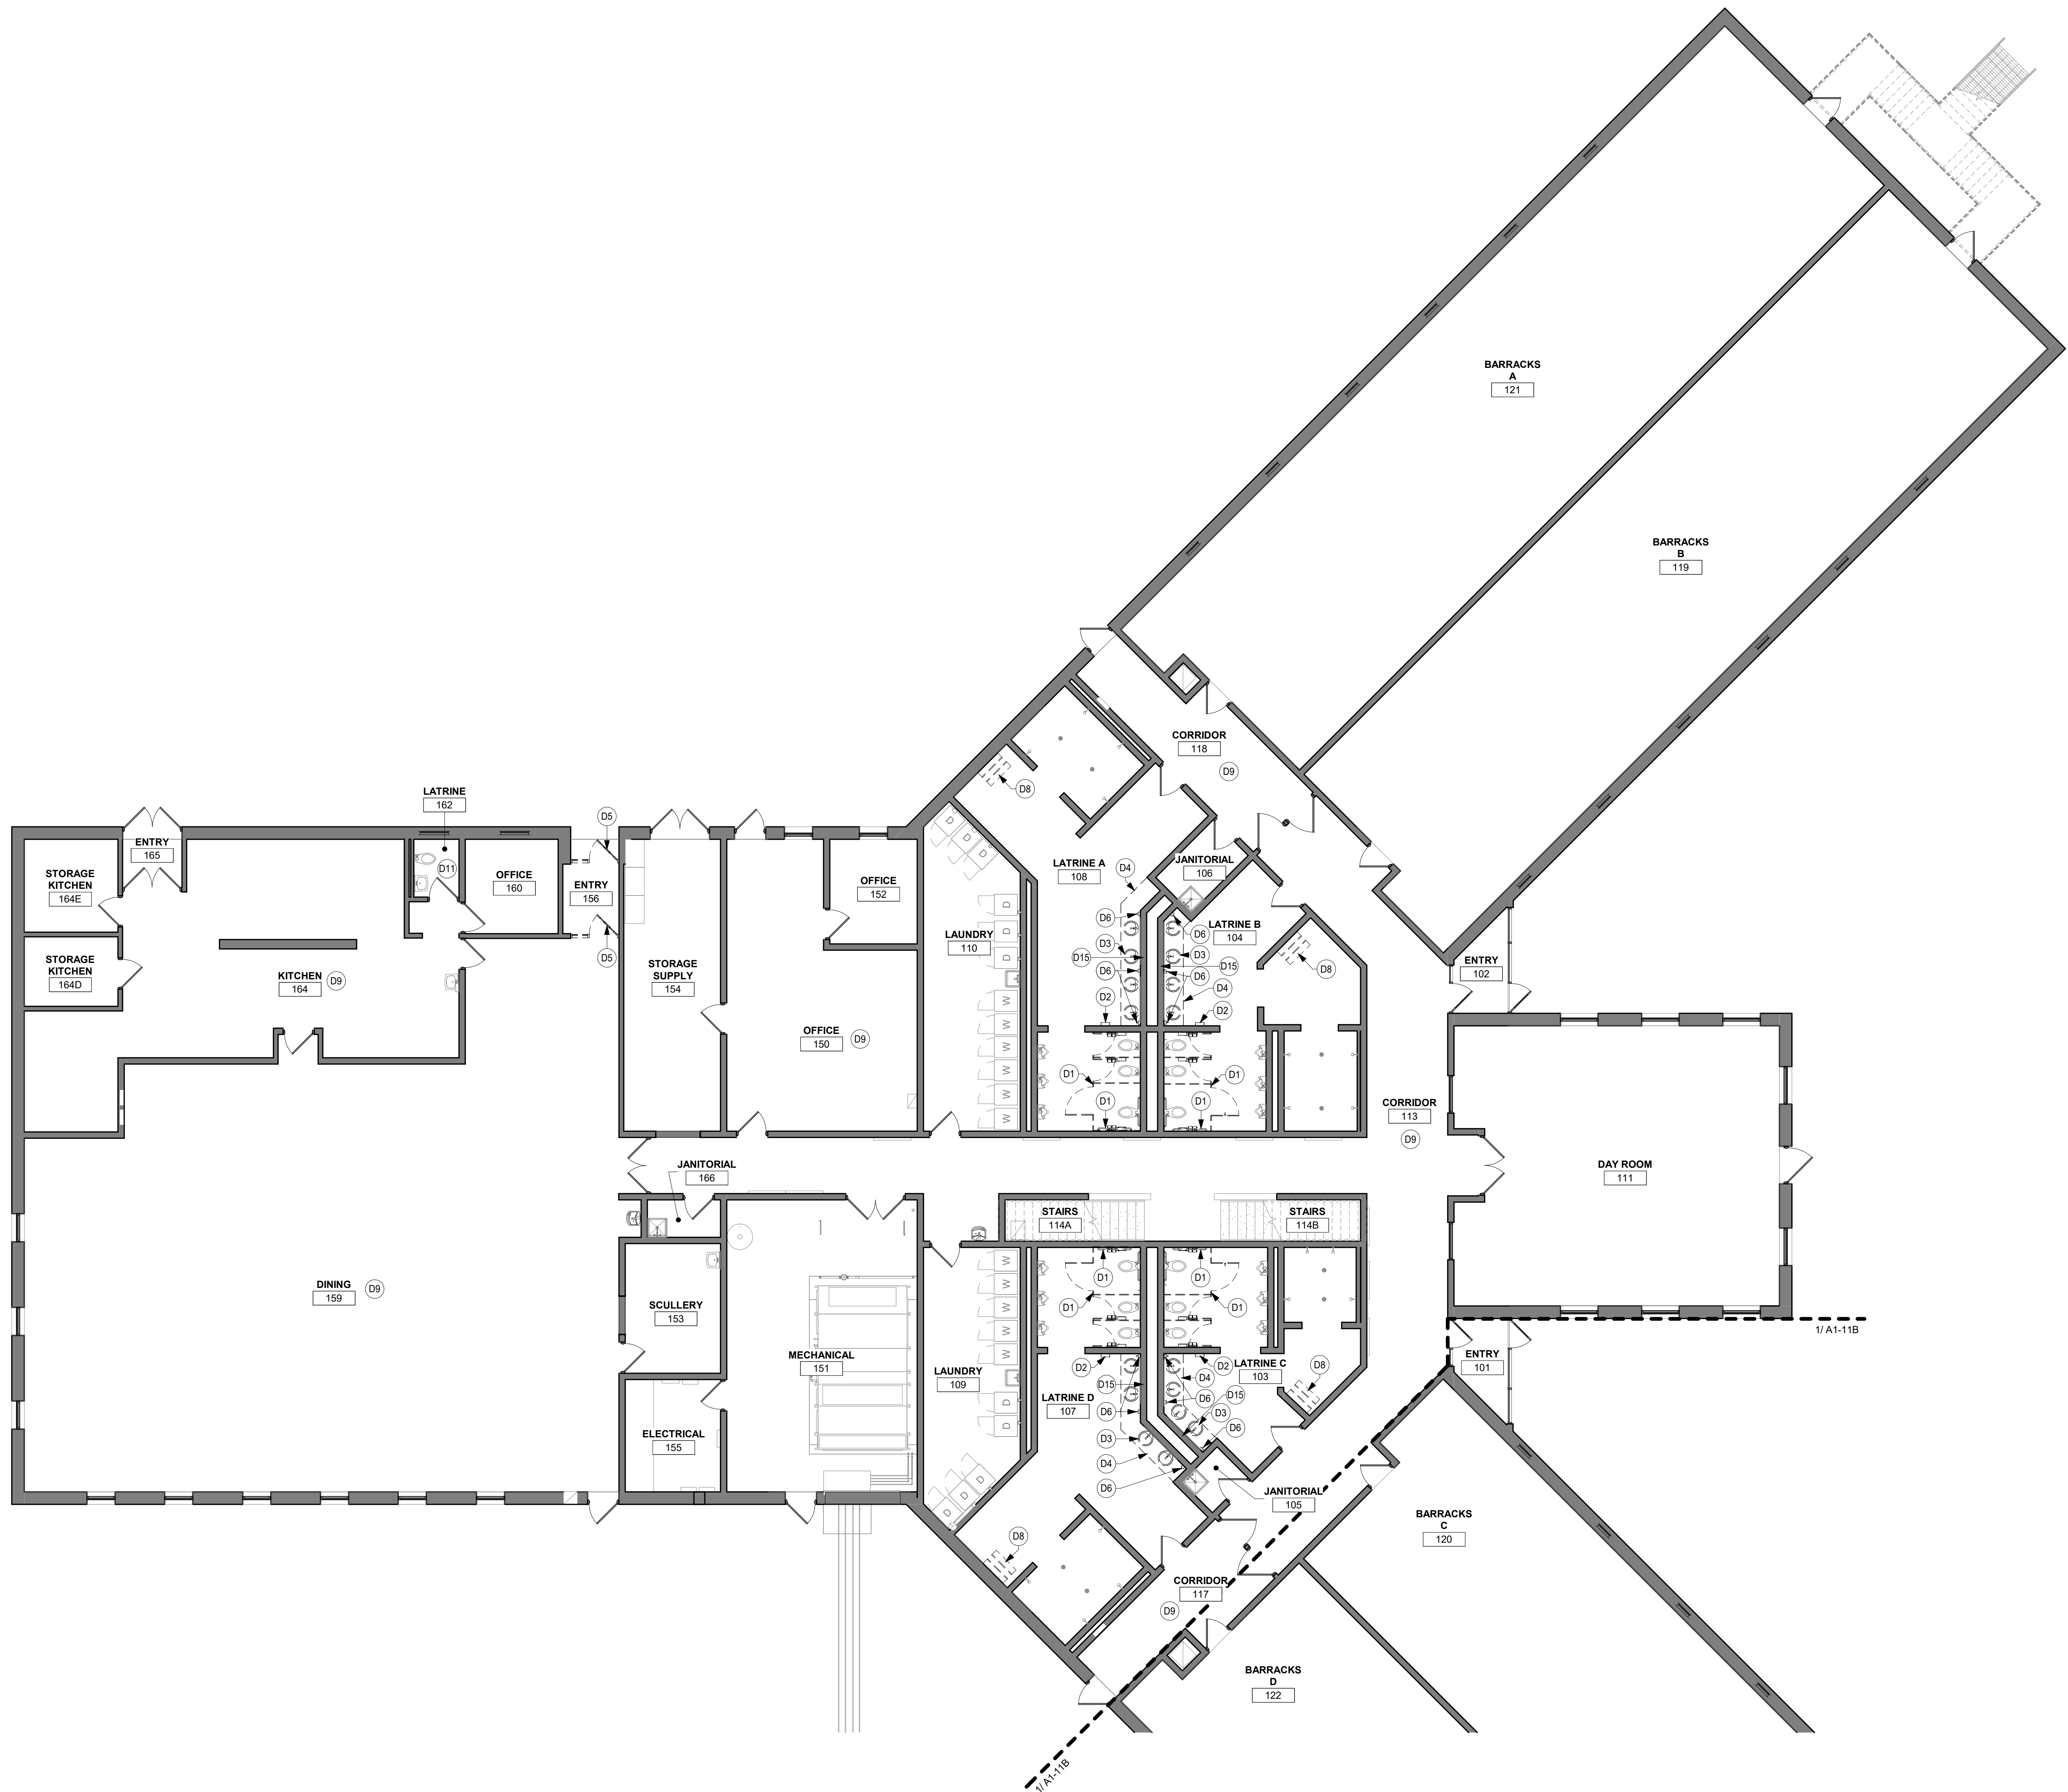

WALL LEGEND

EXISTING CONSTRUCTION TO REMAIN
DEMOLITION

DEMOLITION SHEET NOTES

- A. EXISTING CONDITIONS SHOWN ON DRAWINGS REPRESENT CURRENT BUILDING. IT IS THE RESPONSIBILITY OF THE CONTRACTOR TO EXAMINE THE DRAWINGS AND FIELD VERIFY EXISTING CONDITIONS TO DETERMINE SCOPE OF DEMOLITION WORK REQUIRED TO COMPLETE THE REMODELING WORK INDICATED ON THE DRAWINGS PRIOR TO PERFORMING WORK. ADDITIONAL WORK THAT IS REQUIRED, WAS VISIBLE, AND COULD HAVE BEEN IDENTIFIED DURING BIDDING SHALL BE COMPLETED BY THE RESPONSIBLE TRADE CONTRACTOR(S) AT NO ADDITIONAL COST TO THE OWNER.
- B. REPORT ANY DISCREPANCIES TO THE ARCHITECT FOR REVIEW. WORK DONE WITHOUT RESOLUTION OF DISCREPANCIES MUST BE REDONE AT THE REQUEST OF THE ARCHITECT AT NO ADDITIONAL COST TO THE CONTRACT.
- C. DEMOLITION OF ANY EXISTING CONSTRUCTION SHALL INCLUDE WHAT IS NECESSARY AND REQUIRED TO ACCOMMODATE THE REQUIREMENTS OF NEW CONSTRUCTION.
- D. CONTRACTOR TO BE RESPONSIBLE FOR PROTECTING ANY LOOSE FURNISHINGS (CHAIRS, TABLES, DESKS, ETC.) AND MOVING AS NEEDED. CONTRACTOR TO BE RESPONSIBLE FOR DISCONNECTING ALL UTILITY CONNECTIONS TO WASHING MACHINES AND DRYERS TO MOVE THE MACHINES AS NECESSARY FOR PAINTING WORK.
- E. VERIFY WITH OWNER FOR ITEMS TO BE SALVAGED BEFORE STARTING DEMOLITION WORK.
- F. CONSTRUCT DUST PROOF PARTITIONS TO SEPARATE AREAS OF CONSTRUCTION FROM ADJACENT OCCUPIED AREAS OUTSIDE SCOPE OF CONSTRUCTION.
- G. REQUIRED MEANS OF EGRESS FROM THE BUILDING SHALL BE MAINTAINED AT ALL TIMES DURING CONSTRUCTION WHEN THE BUILDING REMAINS OCCUPIED. IN THE EVENT THAT AN EXISTING MEANS OF EGRESS CANNOT BE MAINTAINED, THE GENERAL CONTRACTOR SHALL PROVIDE AN APPROVED TEMPORARY MEANS OF EGRESS.
- H. MAINTAIN THE INTEGRITY OF ALL EXISTING RATED ELEMENTS. FIRE SEAL ANY PENETRATIONS WITH U.L. APPROVED ASSEMBLY.
- I. CONTRACTOR IS TO VERIFY THE EXACT LOCATION OF ALL EXISTING UTILITIES PRIOR TO DEMOLITION ACTIVITIES. DO NOT INTERRUPT EXISTING UTILITIES, EXCEPT WHEN AUTHORIZED IN WRITING BY A.H.J. PROVIDE TEMPORARY SERVICES DURING INTERRUPTIONS TO EXISTING UTILITIES, AS ACCEPTABLE TO GOVERNING AUTHORITIES.
- K. WHEN UTILITY SERVICES ARE REQUIRED TO BE REMOVED, RELOCATED, OR ABANDONED, PROVIDE BYPASS CONNECTIONS TO MAINTAIN CONTINUITY OF SERVICE BEFORE PROCEEDING WITH REMOVAL.
- L. PREP SURFACES FOR NEW FINISHES IN EVERY ROOM.

KEYNOTE LEGEND

- D1 DEMOLISH ALL EXISTING BATHROOM PARTITIONS, ACCESSORIES, AND MOUNTING HARDWARE.
- D2 DEMOLISH ALL EXISTING PAPER TOWEL DISPENSERS AND MOUNTING HARDWARE.
- D3 DEMOLISH ALL EXISTING SINKS AND FAUCETS.
- D4 DEMOLISH ALL EXISTING COUNTERTOPS, BACKSPLASH, AND SUPPORT BRACKETS. REPAIR WALL AS REQUIRED FROM DEMO OF ALL BACKSPLASH. PREP SURFACE FOR NEW FINISHES.
- D5 DEMOLISH EXISTING DOOR FRAME, DOOR PANEL, SIDELITES AND ACCESSORIES. SAVE EXISTING HARDWARE TO REUSE FOR NEW DOOR. PATCH AND REPAIR ADJACENT SURFACES AS NECESSARY.
- D6 DEMOLISH ALL EXISTING SOAP DISPENSERS AND MOUNTING HARDWARE.
- D8 DEMOLISH EXISTING WALL MOUNTED SHOWER BENCH. PATCH/REPAIR WALL AS REQUIRED. PREP FOR NEW FINISHES.
- D9 REMOVE ALL ROOM, WAYFINDING, AND DOOR NUMBER SIGNAGE THROUGHOUT BUILDING. PATCH/REPAIR SURFACES AS REQUIRED FOR NEW FINISHES.
- D11 ALL EXISTING RESTROOM ACCESSORIES AND FIXTURES TO REMAIN. REMOVE AND REINSTALL AS REQUIRED FOR PAINTING WORK.
- D15 EXISTING MIRRORS TO REMAIN. PROTECT DURING CONSTRUCTION.

ISG

KEYPLAN

THIS DOCUMENT IS THE PROPERTY OF I & S GROUP, INC. AND MAY NOT BE USED, COPIED OR DUPLICATED WITHOUT PRIOR WRITTEN CONSENT.
© 2024 I & S GROUP, INC.

PROJECT

IOWA ARMY NATIONAL GUARD S54 FINISH UPGRADES

CAMP DODGE, JOHNSTON IOWA

REVISION SCHEDULE

DATE	DESCRIPTION	BY


PROJECT NO. 26-34920
FILE NAME 34920 Arch R26
DRAWN BY MJT
DESIGNED BY GMP
REVIEWED BY GMP
ORIGINAL ISSUE DATE 09/08/26
CLIENT PROJECT NO. 19083733

TITLE


FIRST FLOOR DEMOLITION PLAN - AREA A

SHEET

A1-11A

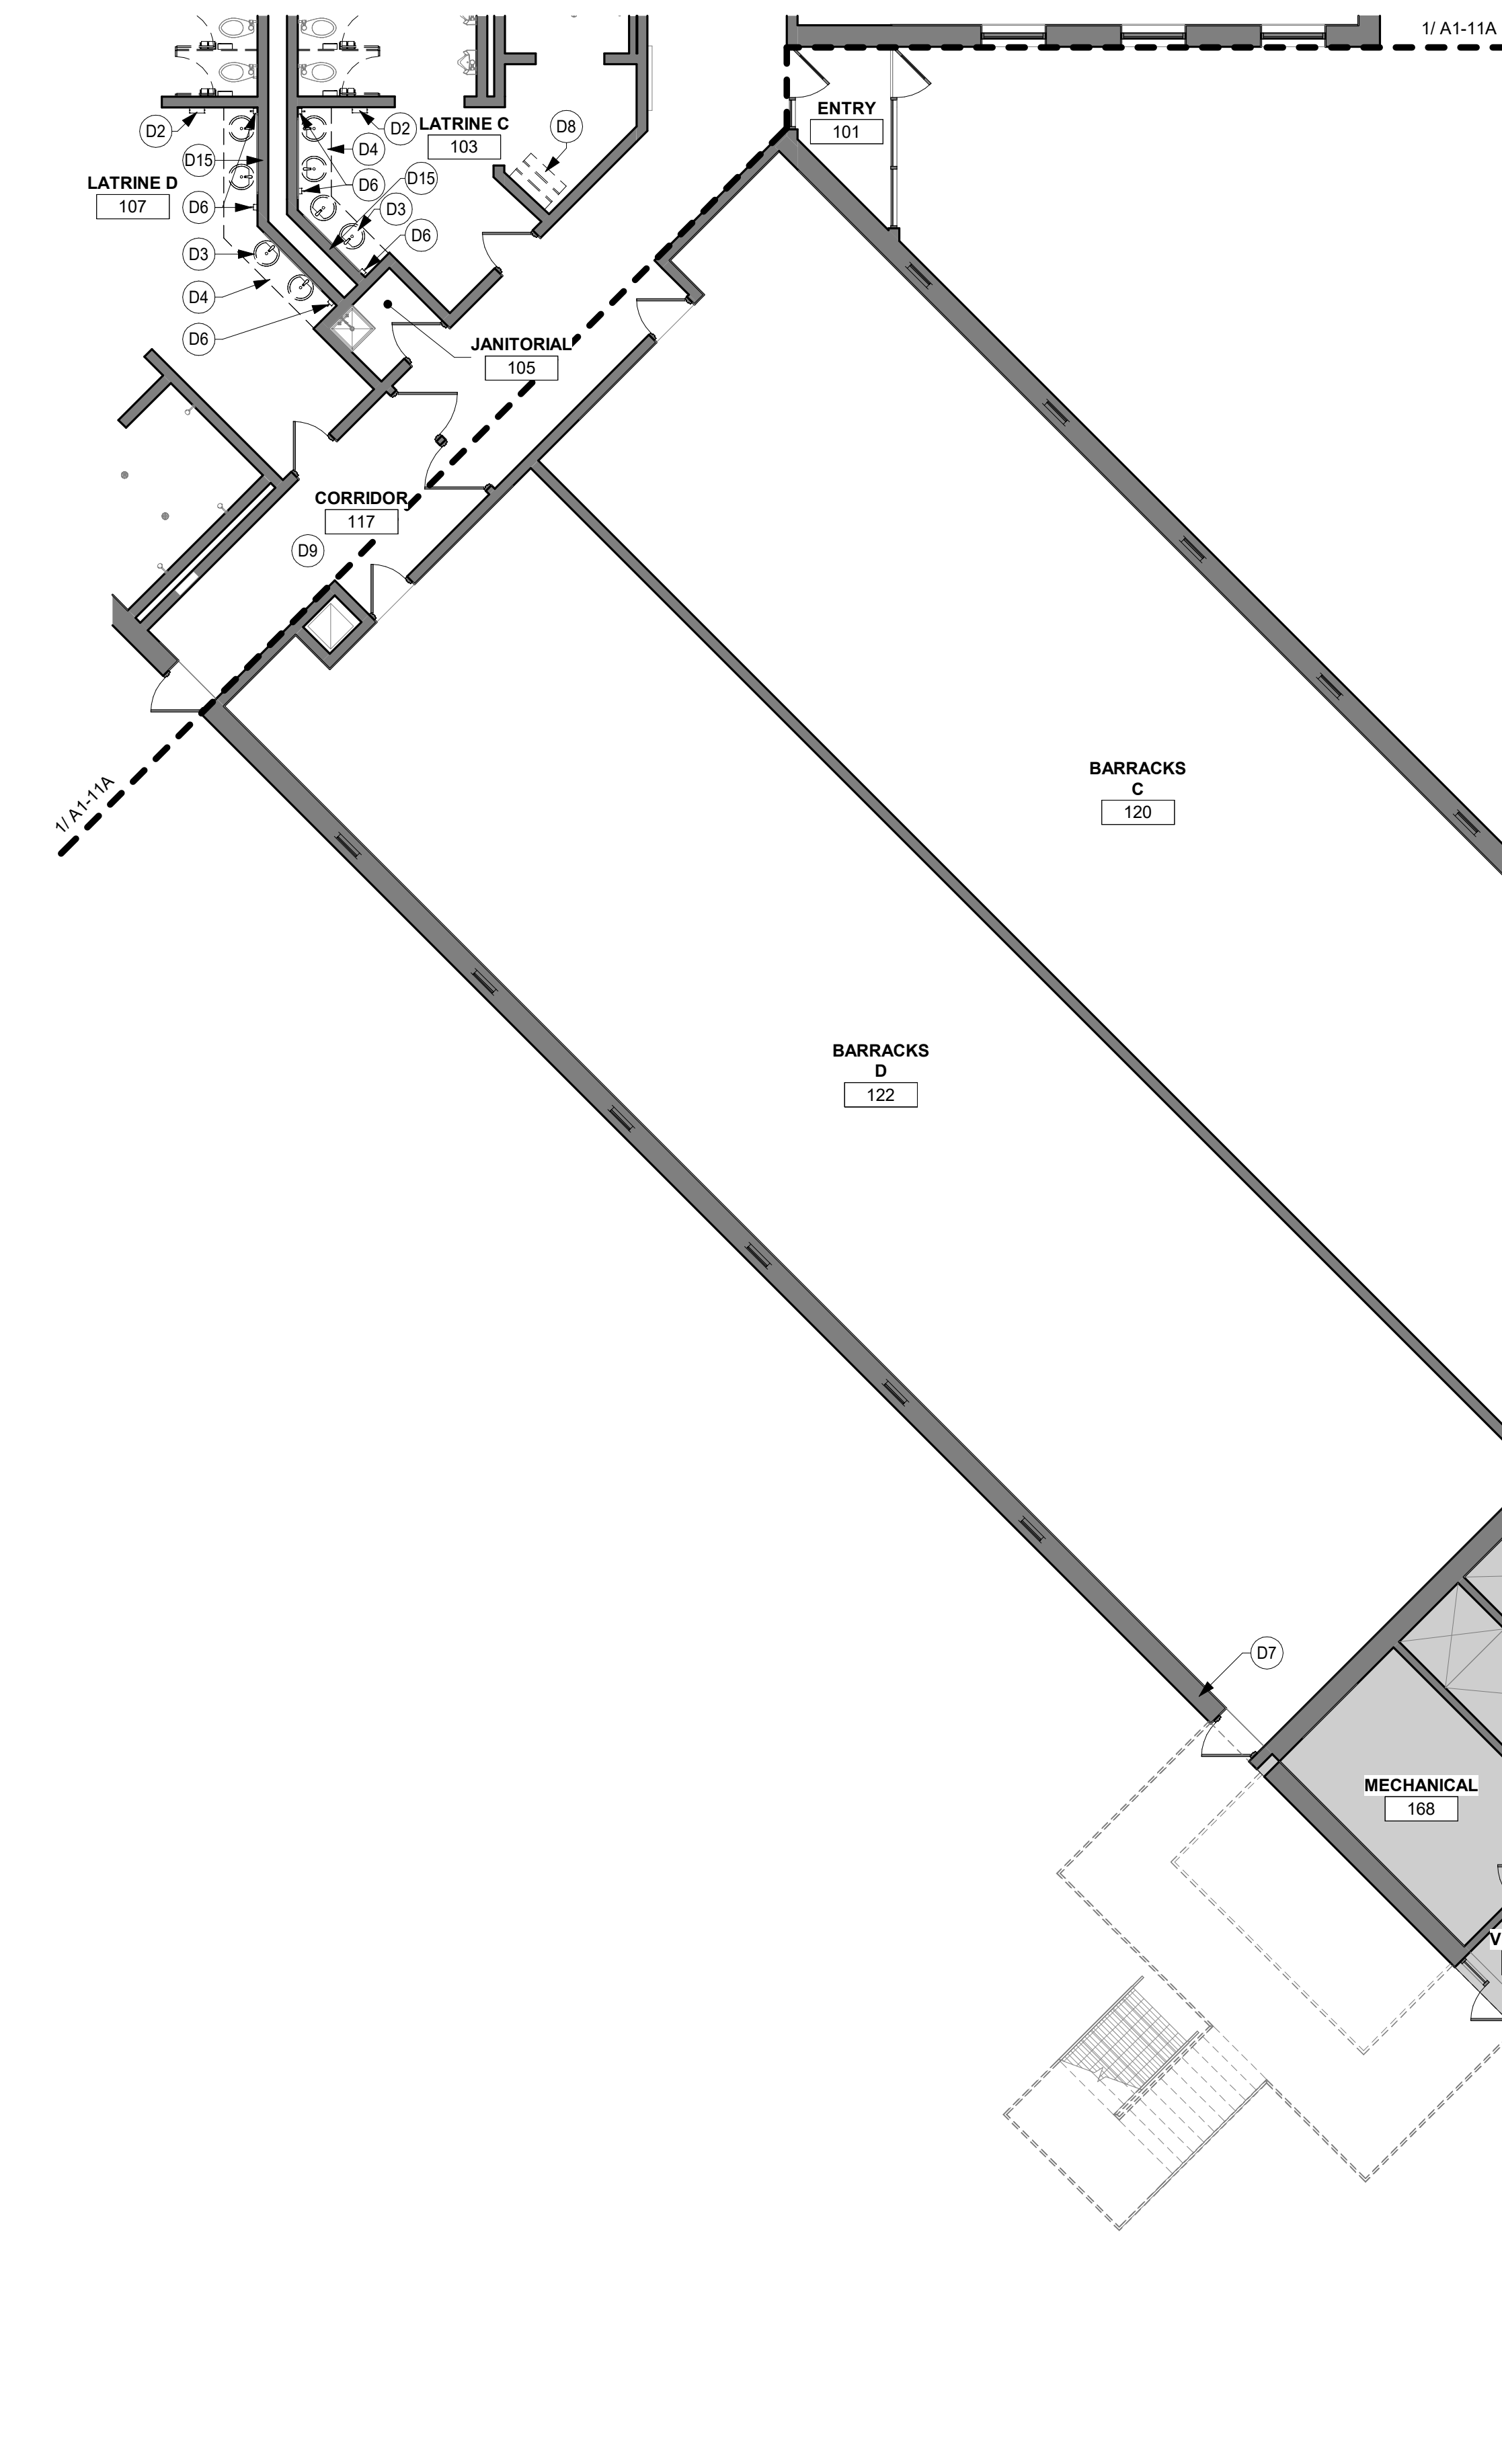

1 FIRST FLOOR DEMOLITION PLAN - AREA B
1/8" = 1'-0"

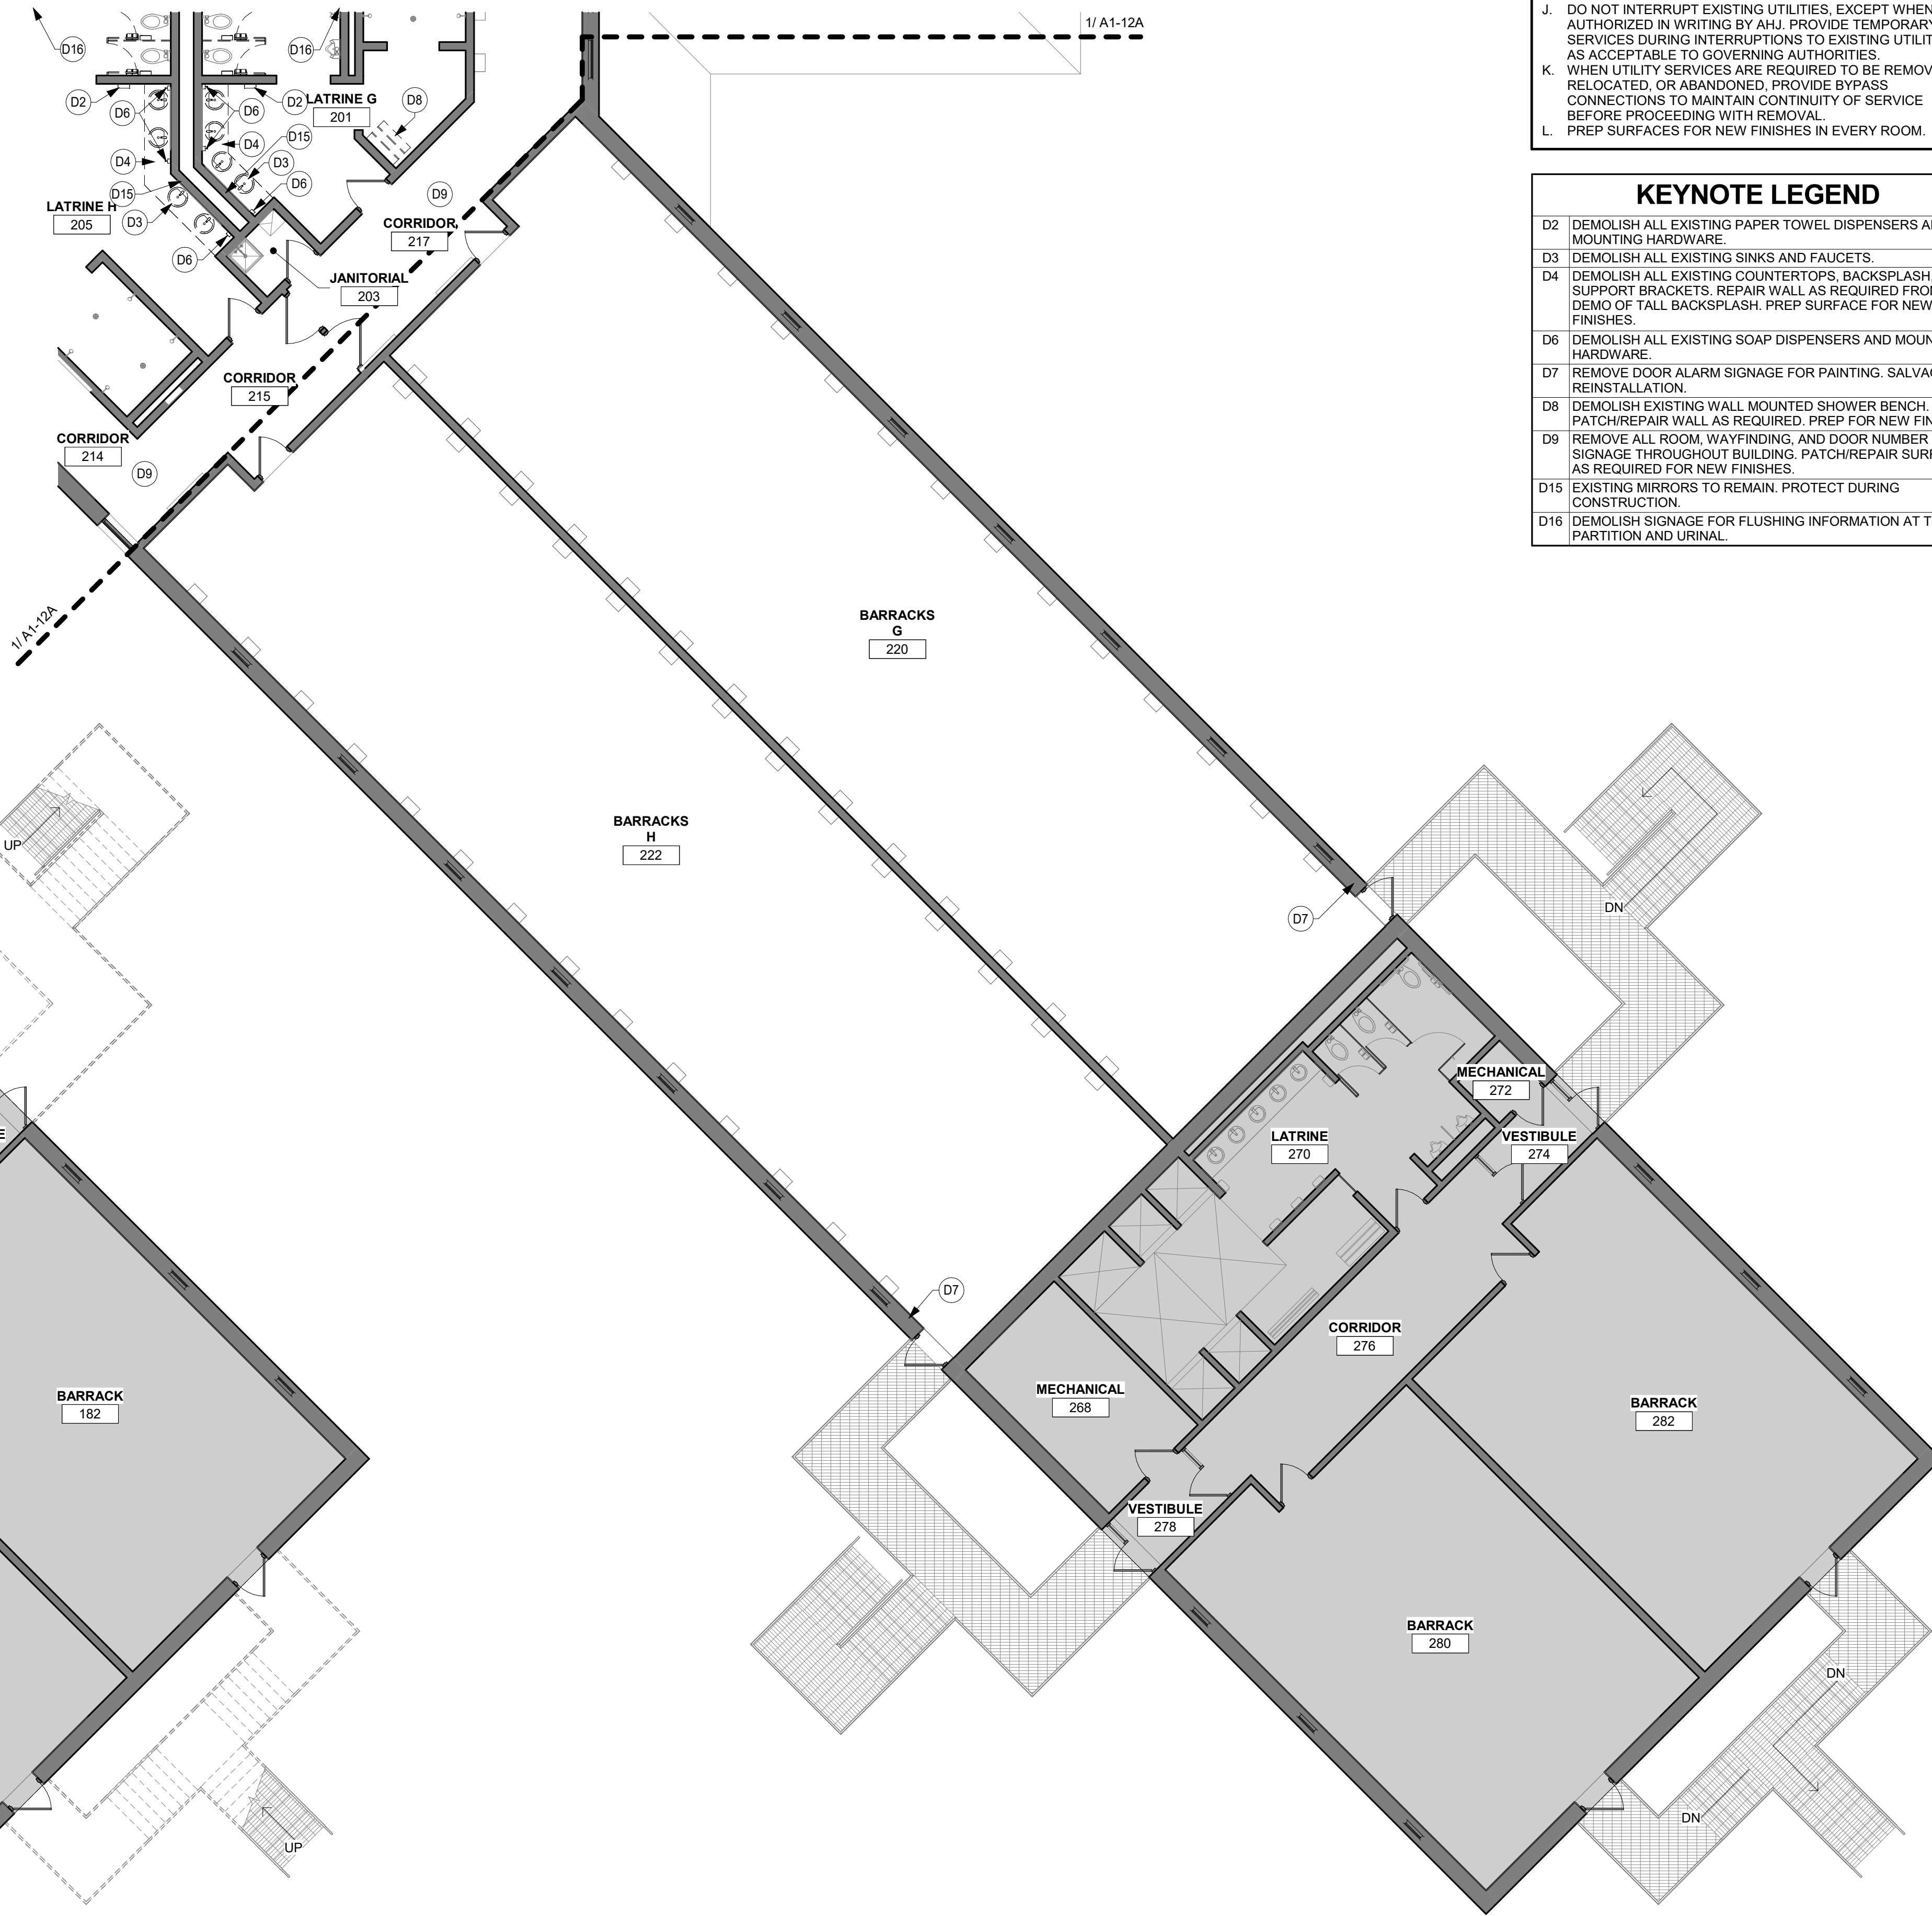

2 SECOND FLOOR DEMOLITION PLAN - AREA B
1/8" = 1'-0"

FLOOR PLAN LEGEND

SHADED REGION INDICATES AREA OF PLANS THAT ARE NOT INCLUDED IN SCOPE OF WORK.

WALL LEGEND


EXISTING CONSTRUCTION TO REMAIN
DEMOLITION

DEMOLITION SHEET NOTES

- EXISTING CONDITIONS SHOWN ON DRAWINGS REPRESENT CURRENT BUILDING. IT IS THE RESPONSIBILITY OF THE CONTRACTOR TO EXAMINE THE DRAWINGS AND FIELD VERIFY EXISTING CONDITIONS TO DETERMINE SCOPE OF DEMOLITION WORK REQUIRED TO COMPLETE THE REMODELING WORK INDICATED ON THE DRAWINGS PRIOR TO PERFORMING WORK. ADDITIONAL WORK THAT IS REQUIRED, WAS VISIBLE, AND COULD HAVE BEEN IDENTIFIED DURING BIDDING SHALL BE COMPLETED BY THE RESPONSIBLE TRADE CONTRACTOR(S) AT NO ADDITIONAL COST TO THE OWNER.
- REPORT ANY DISCREPANCIES TO THE ARCHITECT FOR REVIEW. WORK DONE WITHOUT RESOLUTION OF DISCREPANCIES MUST BE REDONE AT THE REQUEST OF THE ARCHITECT AT NO ADDITIONAL COST TO THE CONTRACT.
- DEMOLITION OF ANY EXISTING CONSTRUCTION SHALL INCLUDE WHAT IS NECESSARY AND REQUIRED TO ACCOMMODATE THE REQUIREMENTS OF NEW CONSTRUCTION.
- CONTRACTOR TO BE RESPONSIBLE FOR PROTECTING ANY LOOSE FURNISHINGS (CHAIRS, TABLES, DESKS, ETC.) AND MOVING AS NEEDED. CONTRACTOR TO BE RESPONSIBLE FOR DISCONNECTING ALL UTILITY CONNECTIONS TO WASHING MACHINES AND DRYERS TO MOVE THE MACHINES AS NECESSARY FOR PAINTING WORK.
- VERIFY WITH OWNER FOR ITEMS TO BE SALVAGED BEFORE STARTING DEMOLITION WORK.
- CONSTRUCT DUST PROOF PARTITIONS TO SEPARATE AREAS OF CONSTRUCTION FROM ADJACENT OCCUPIED AREAS OUTSIDE SCOPE OF CONSTRUCTION.
- REQUIRED MEANS OF EGRESS FROM THE BUILDING SHALL BE MAINTAINED AT ALL TIMES DURING CONSTRUCTION WHEN THE BUILDING REMAINS OCCUPIED. IN THE EVENT THAT AN EXISTING MEANS OF EGRESS CANNOT BE MAINTAINED, THE GENERAL CONTRACTOR SHALL PROVIDE AN APPROVED TEMPORARY MEANS OF EGRESS.
- MAINTAIN THE INTEGRITY OF ALL EXISTING RATED ELEMENTS. FIRE SEAL ANY PENETRATIONS WITH ULL APPROVED ASSEMBLY.
- CONTRACTOR IS TO VERIFY THE EXACT LOCATION OF ALL EXISTING UTILITIES PRIOR TO DEMOLITION ACTIVITIES. DO NOT INTERRUPT EXISTING UTILITIES, EXCEPT WHEN AUTHORIZED IN WRITING BY AHJ. PROVIDE TEMPORARY SERVICES DURING INTERRUPTIONS TO EXISTING UTILITIES, AS ACCEPTABLE TO GOVERNING AUTHORITIES.
- WHEN UTILITY SERVICES ARE REQUIRED TO BE REMOVED, RELOCATED, OR ABANDONED, PROVIDE BYPASS CONNECTIONS TO MAINTAIN CONTINUITY OF SERVICE BEFORE PROCEEDING WITH REMOVAL.
- PREP SURFACES FOR NEW FINISHES IN EVERY ROOM.

KEYNOTE LEGEND

- D2 DEMOLISH ALL EXISTING PAPER TOWEL DISPENSERS AND MOUNTING HARDWARE.
- D3 DEMOLISH ALL EXISTING SINKS AND FAUCETS.
- D4 DEMOLISH ALL EXISTING COUNTERTOPS, BACKSPLASH, AND SUPPORT BRACKETS. REPAIR WALL AS REQUIRED FROM DEMO OF TALL BACKSPLASH. PREP SURFACE FOR NEW FINISHES.
- D6 DEMOLISH ALL EXISTING SOAP DISPENSERS AND MOUNTING HARDWARE.
- D7 REMOVE DOOR ALARM SIGNAGE FOR PAINTING. SALVAGE FOR REINSTALLATION.
- D8 DEMOLISH EXISTING WALL MOUNTED SHOWER BENCH. PATCH/REPAIR WALL AS REQUIRED. PREP FOR NEW FINISHES.
- D9 REMOVE ALL ROOM, WAYFINDING, AND DOOR NUMBER SIGNAGE THROUGHOUT BUILDING. PATCH/REPAIR SURFACES AS REQUIRED FOR NEW FINISHES.
- D15 EXISTING MIRRORS TO REMAIN. PROTECT DURING CONSTRUCTION.
- D16 DEMOLISH SIGNAGE FOR FLUSHING INFORMATION AT TOILET PARTITION AND URINAL.

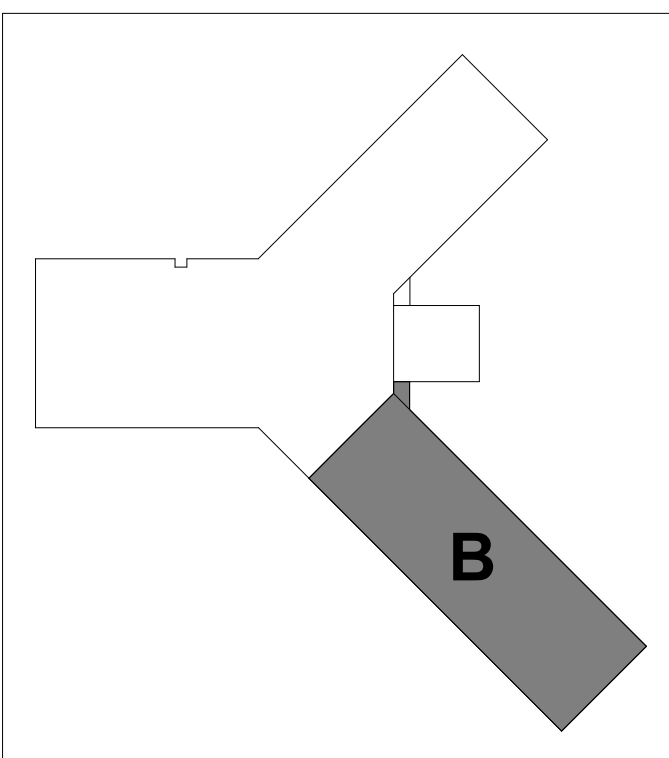

KEYPLAN

THIS DOCUMENT IS THE PROPERTY OF I & S GROUP, INC. AND MAY NOT BE USED, COPIED OR DUPLICATED WITHOUT PRIOR WRITTEN CONSENT.
© 2024 I & S GROUP, INC.

PROJECT

IOWA ARMY NATIONAL GUARD S54 FINISH UPGRADES

CAMP DODGE, JOHNSTON IOWA

REVISION SCHEDULE		
DATE	DESCRIPTION	BY

PROJECT NO.	26-34920
FILE NAME	34920 Arch R26
DRAWN BY	MJT
DESIGNED BY	GMP
REVIEWED BY	GMP
ORIGINAL ISSUE DATE	09/08/26
CLIENT PROJECT NO.	19083733

TITLE


FIRST AND SECOND FLOOR DEMOLITION PLAN - AREA B

SHEET

A1-11B


REFERENCE SCALE
1" = 1'-0"
0 1/4" 1/2" 1" 2"

1 SECOND FLOOR DEMOLITION PLAN - OVERALL
3/32" = 1'-0"

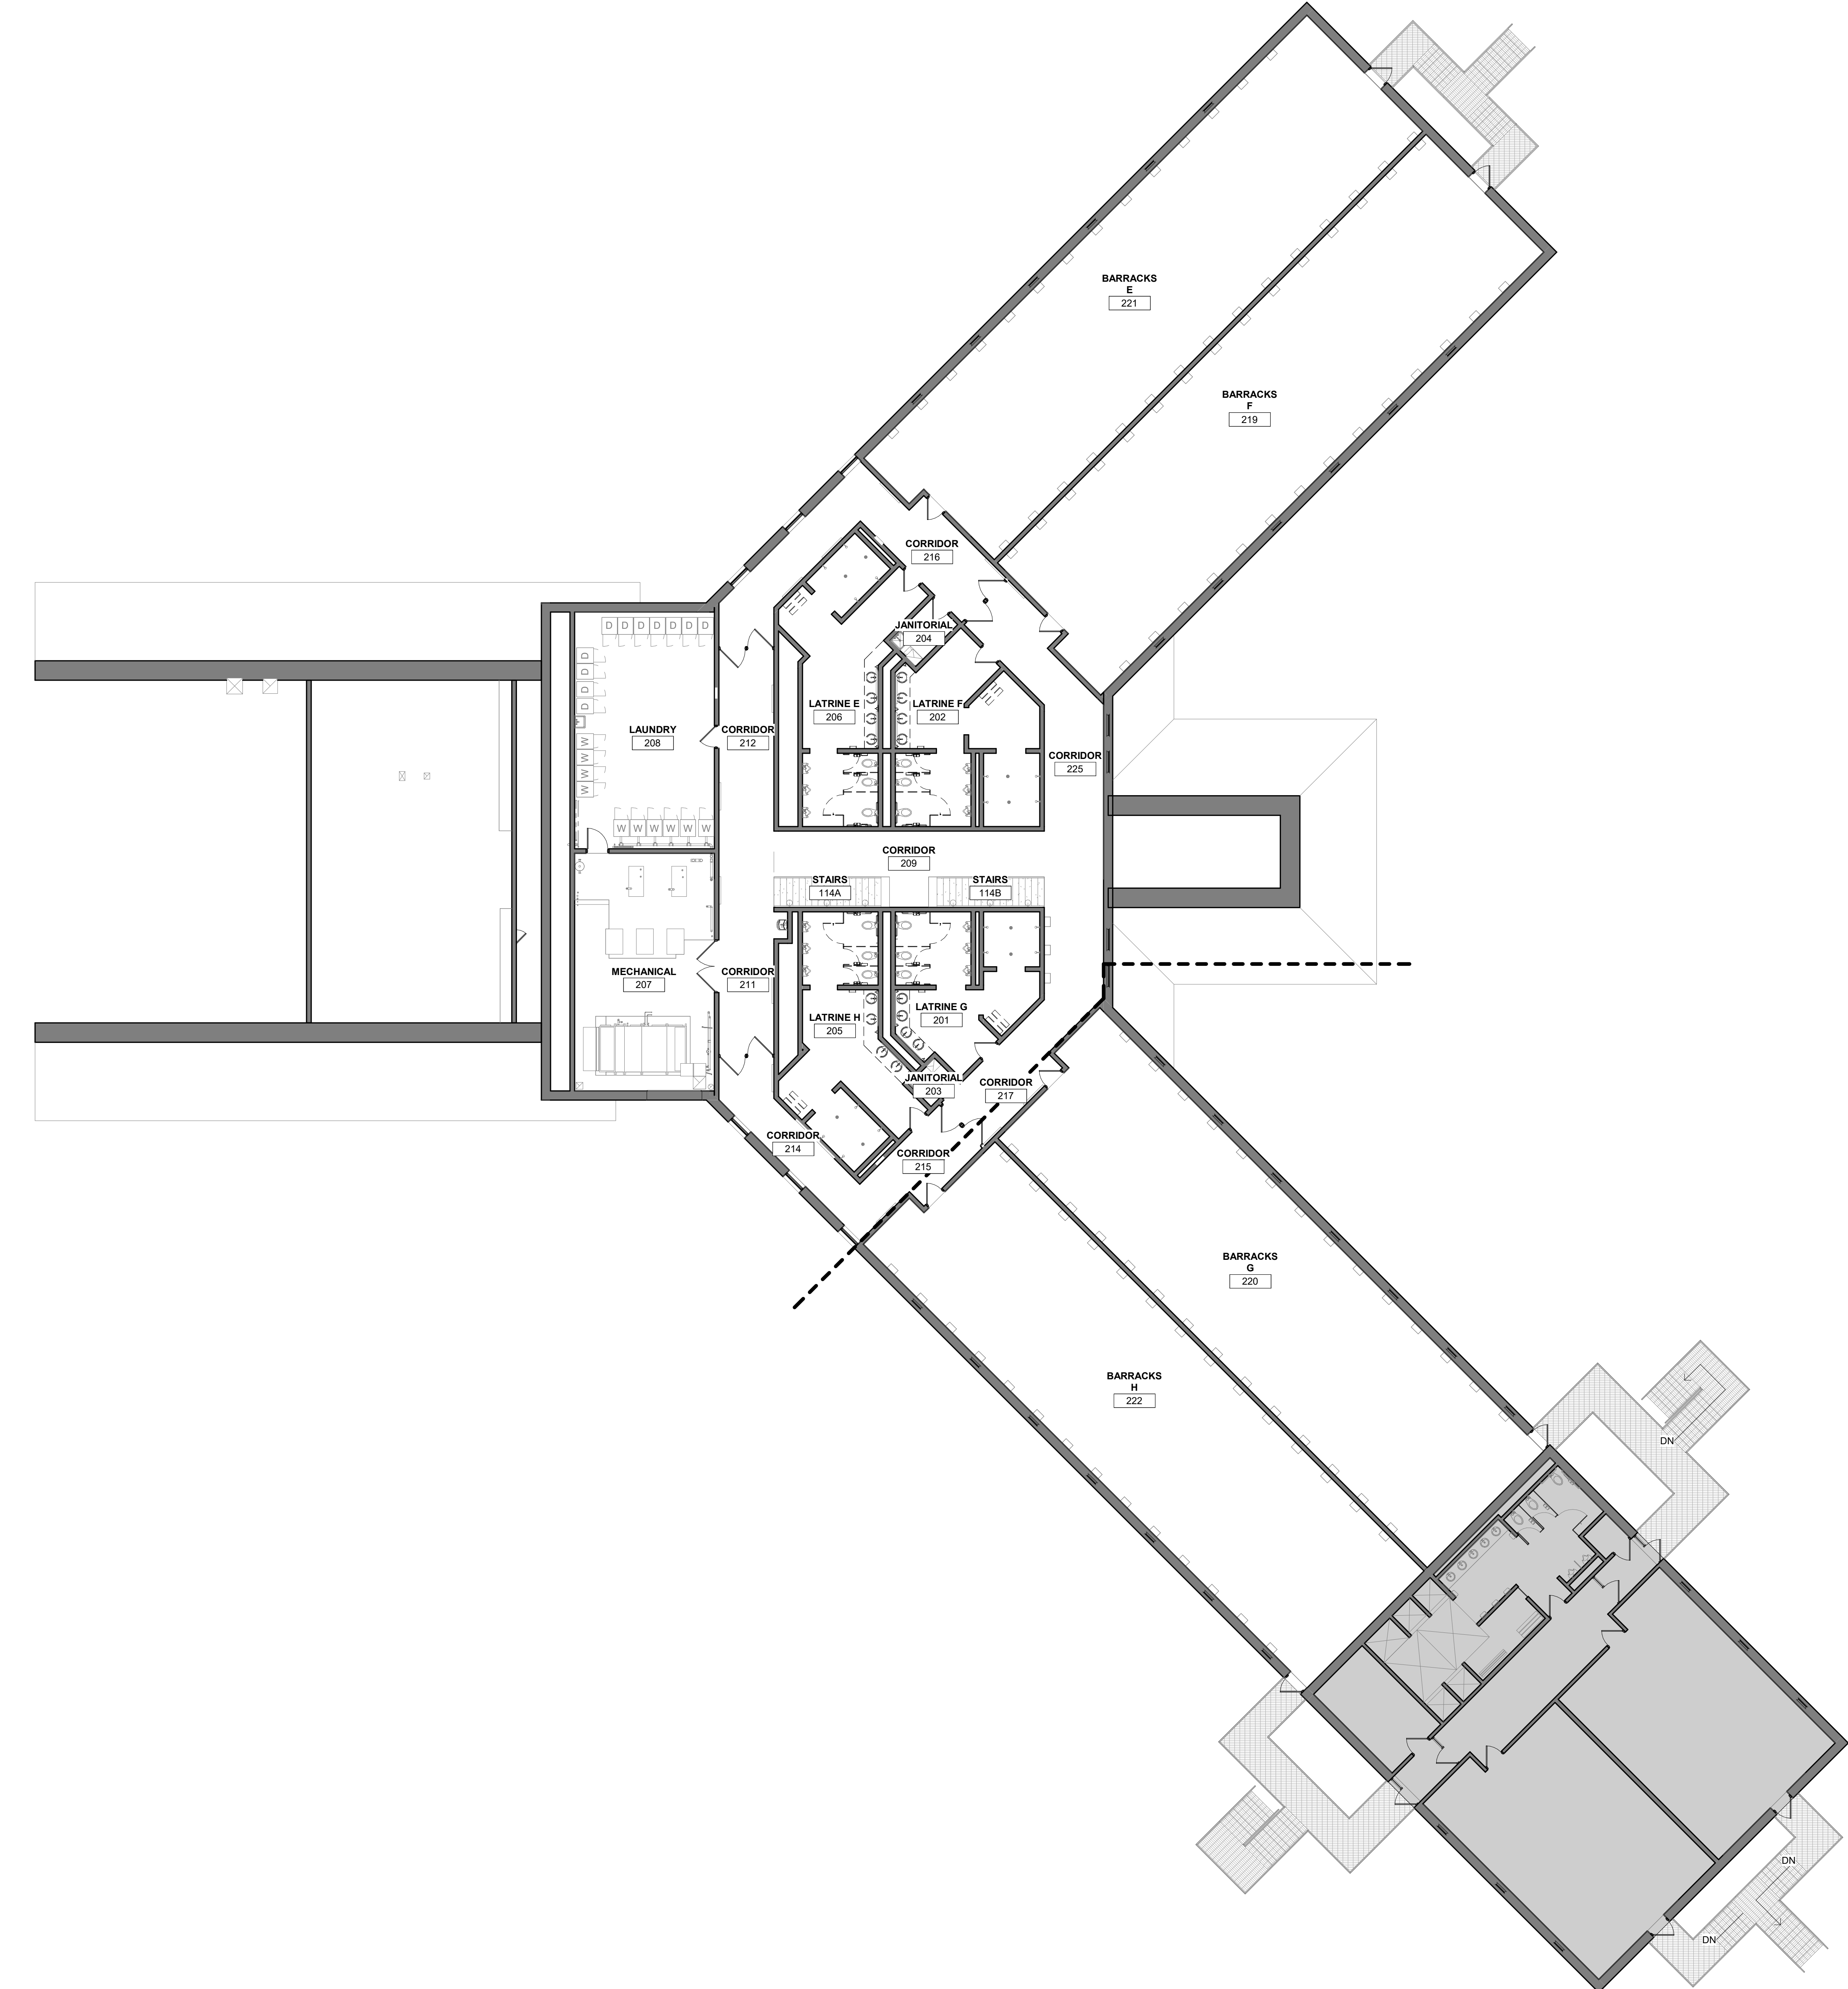

FLOOR PLAN LEGEND

SHADED REGION INDICATES AREA OF PLANS THAT ARE NOT INCLUDED IN SCOPE OF WORK.

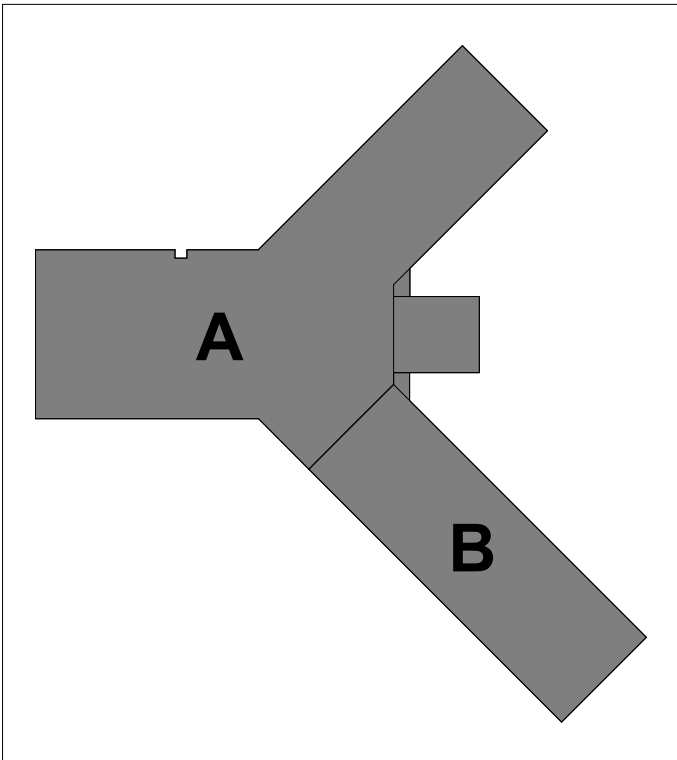

KEYPLAN

THIS DOCUMENT IS THE PROPERTY OF I & S GROUP, INC. AND MAY NOT BE USED, COPIED OR DUPLICATED WITHOUT PRIOR WRITTEN CONSENT.
© 2024 I & S GROUP, INC.

PROJECT

**IOWA ARMY
NATIONAL GUARD
S54 FINISH
UPGRADES**

CAMP DODGE, JOHNSTON IOWA


REVISION SCHEDULE		
DATE	DESCRIPTION	BY


PROJECT NO.	26-34920
FILE NAME	34920 Arch R26
DRAWN BY	MJT
DESIGNED BY	GMP
REVIEWED BY	GMP
ORIGINAL ISSUE DATE	09/08/26
CLIENT PROJECT NO.	19083733

TITLE

**SECOND FLOOR
DEMOLITION
PLAN - OVERALL**

 SHEET
A1-12



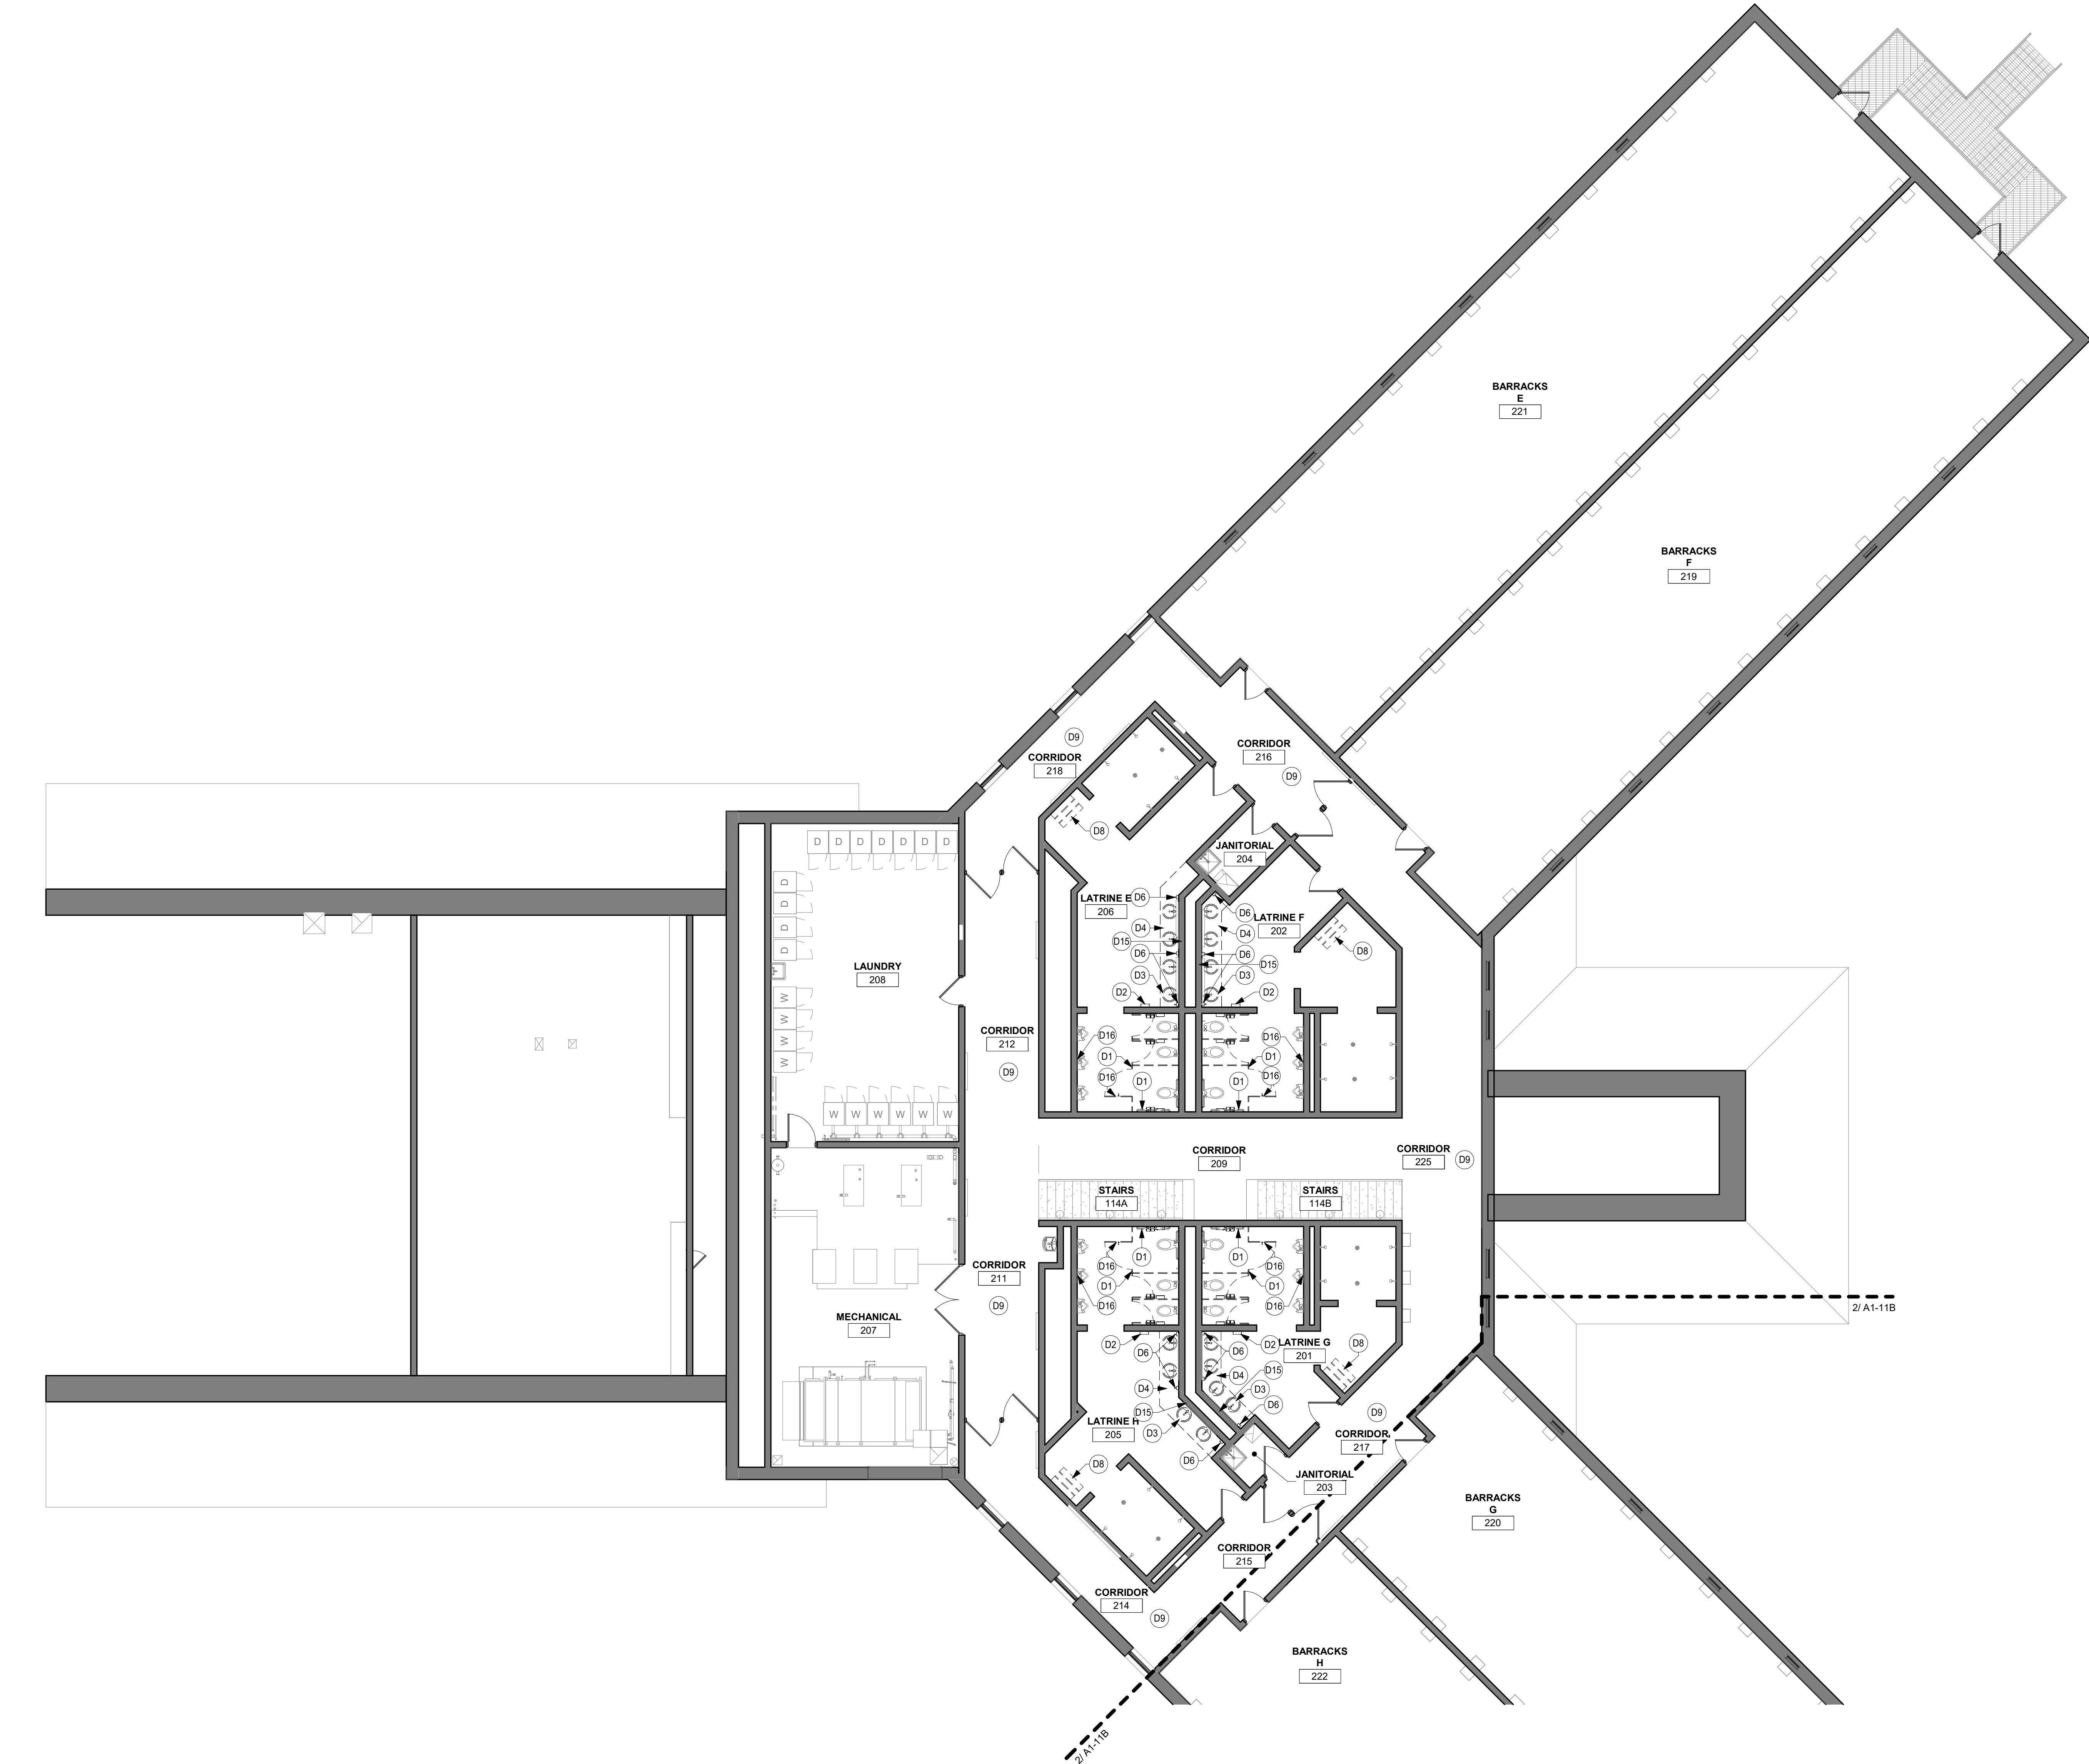

WALL LEGEND

EXISTING CONSTRUCTION TO REMAIN
DEMOLITION

DEMOLITION SHEET NOTES

- A. EXISTING CONDITIONS SHOWN ON DRAWINGS REPRESENT CURRENT BUILDING. IT IS THE RESPONSIBILITY OF THE CONTRACTOR TO EXAMINE THE DRAWINGS AND FIELD VERIFY EXISTING CONDITIONS TO DETERMINE SCOPE OF DEMOLITION WORK REQUIRED TO COMPLETE THE REMODELING WORK INDICATED ON THE DRAWINGS PRIOR TO PERFORMING WORK. ADDITIONAL WORK THAT IS REQUIRED, WAS VISIBLE, AND COULD HAVE BEEN IDENTIFIED DURING BIDDING SHALL BE COMPLETED BY THE RESPONSIBLE TRADE CONTRACTOR(S) AT NO ADDITIONAL COST TO THE OWNER.
- B. REPORT ANY DISCREPANCIES TO THE ARCHITECT FOR REVIEW. WORK DONE WITHOUT RESOLUTION OF DISCREPANCIES MUST BE REDONE AT THE REQUEST OF THE ARCHITECT AT NO ADDITIONAL COST TO THE CONTRACT.
- C. DEMOLITION OF ANY EXISTING CONSTRUCTION SHALL INCLUDE WHAT IS NECESSARY AND REQUIRED TO ACCOMMODATE THE REQUIREMENTS OF NEW CONSTRUCTION.
- D. CONTRACTOR TO BE RESPONSIBLE FOR PROTECTING ANY LOOSE FURNISHINGS (CHAIRS, TABLES, DESKS, ETC.) AND MOVING AS NEEDED. CONTRACTOR TO BE RESPONSIBLE FOR DISCONNECTING ALL UTILITY CONNECTIONS TO WASHING MACHINES AND DRYERS TO MOVE THE MACHINES AS NECESSARY FOR PAINTING WORK.
- E. VERIFY WITH OWNER FOR ITEMS TO BE SALVAGED BEFORE STARTING DEMOLITION WORK.
- F. CONSTRUCT DUST PROOF PARTITIONS TO SEPARATE AREAS OF CONSTRUCTION FROM ADJACENT OCCUPIED AREAS OUTSIDE SCOPE OF CONSTRUCTION.
- G. REQUIRED MEANS OF EGRESS FROM THE BUILDING SHALL BE MAINTAINED AT ALL TIMES DURING CONSTRUCTION WHEN THE BUILDING REMAINS OCCUPIED. IN THE EVENT THAT AN EXISTING MEANS OF EGRESS CANNOT BE MAINTAINED, THE GENERAL CONTRACTOR SHALL PROVIDE AN APPROVED TEMPORARY MEANS OF EGRESS.
- H. MAINTAIN THE INTEGRITY OF ALL EXISTING RATED ELEMENTS, FIRE SEAL, ANY PENETRATIONS WITH U.L. APPROVED ASSEMBLY.
- I. CONTRACTOR IS TO VERIFY THE EXACT LOCATION OF ALL EXISTING UTILITIES PRIOR TO DEMOLITION ACTIVITIES.
- J. DO NOT INTERRUPT EXISTING UTILITIES, EXCEPT WHEN AUTHORIZED IN WRITING BY AHJ. PROVIDE TEMPORARY SERVICES DURING INTERRUPTIONS TO EXISTING UTILITIES, AS ACCEPTABLE TO GOVERNING AUTHORITIES.
- K. WHEN UTILITY SERVICES ARE REQUIRED TO BE REMOVED, RELOCATED, OR ABANDONED, PROVIDE BYPASS CONNECTIONS TO MAINTAIN CONTINUITY OF SERVICE BEFORE PROCEEDING WITH REMOVAL.
- L. PREP SURFACES FOR NEW FINISHES IN EVERY ROOM.

KEYNOTE LEGEND

- D1 DEMOLISH ALL EXISTING BATHROOM PARTITIONS, ACCESSORIES, AND MOUNTING HARDWARE.
- D2 DEMOLISH ALL EXISTING PAPER TOWEL DISPENSERS AND MOUNTING HARDWARE.
- D3 DEMOLISH ALL EXISTING SINKS AND FAUCETS.
- D4 DEMOLISH ALL EXISTING COUNTERTOPS, BACKSPLASH, AND SUPPORT BRACKETS. REPAIR WALL AS REQUIRED FROM DEMO OF TALL BACKSPLASH. PREP SURFACE FOR NEW FINISHES.
- D6 DEMOLISH ALL EXISTING SOAP DISPENSERS AND MOUNTING HARDWARE.
- D8 DEMOLISH EXISTING WALL MOUNTED SHOWER BENCH. PATCH/REPAIR WALL AS REQUIRED. PREP FOR NEW FINISHES.
- D9 REMOVE ALL ROOM, WAYFINDING, AND DOOR NUMBER SIGNAGE THROUGHOUT BUILDING. PATCH/REPAIR SURFACES AS REQUIRED FOR NEW FINISHES.
- D15 EXISTING MIRRORS TO REMAIN. PROTECT DURING CONSTRUCTION.
- D16 DEMOLISH SIGNAGE FOR FLUSHING INFORMATION AT TOILET PARTITION AND URINAL.

ISG

A

KEYPLAN

THIS DOCUMENT IS THE PROPERTY OF I & S GROUP, INC. AND MAY NOT BE USED, COPIED OR DUPLICATED WITHOUT PRIOR WRITTEN CONSENT.
© 2024 I & S GROUP, INC.

PROJECT

IOWA ARMY NATIONAL GUARD S54 FINISH UPGRADES

CAMP DODGE, JOHNSTON IOWA

REVISION SCHEDULE

DATE	DESCRIPTION	BY

PROJECT NO.	26-34920
FILE NAME	34920 Arch R26
DRAWN BY	MJT
DESIGNED BY	GMP
REVIEWED BY	GMP
ORIGINAL ISSUE DATE	09/08/26
CLIENT PROJECT NO.	19083733

TITLE



SECOND FLOOR DEMOLITION PLAN - AREA A

SHEET

A1-12A

FLOOR PLAN LEGEND

SHADED REGION INDICATES AREA OF PLANS THAT ARE NOT INCLUDED IN SCOPE OF WORK.

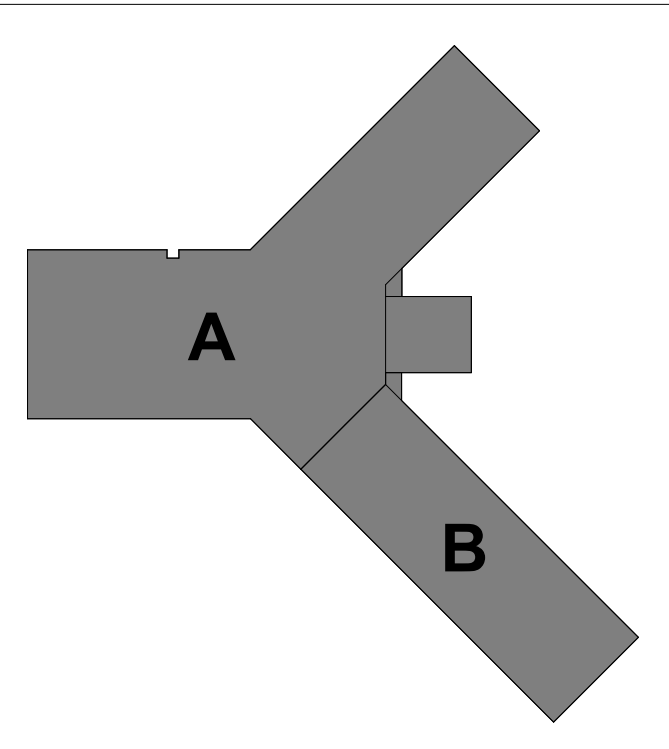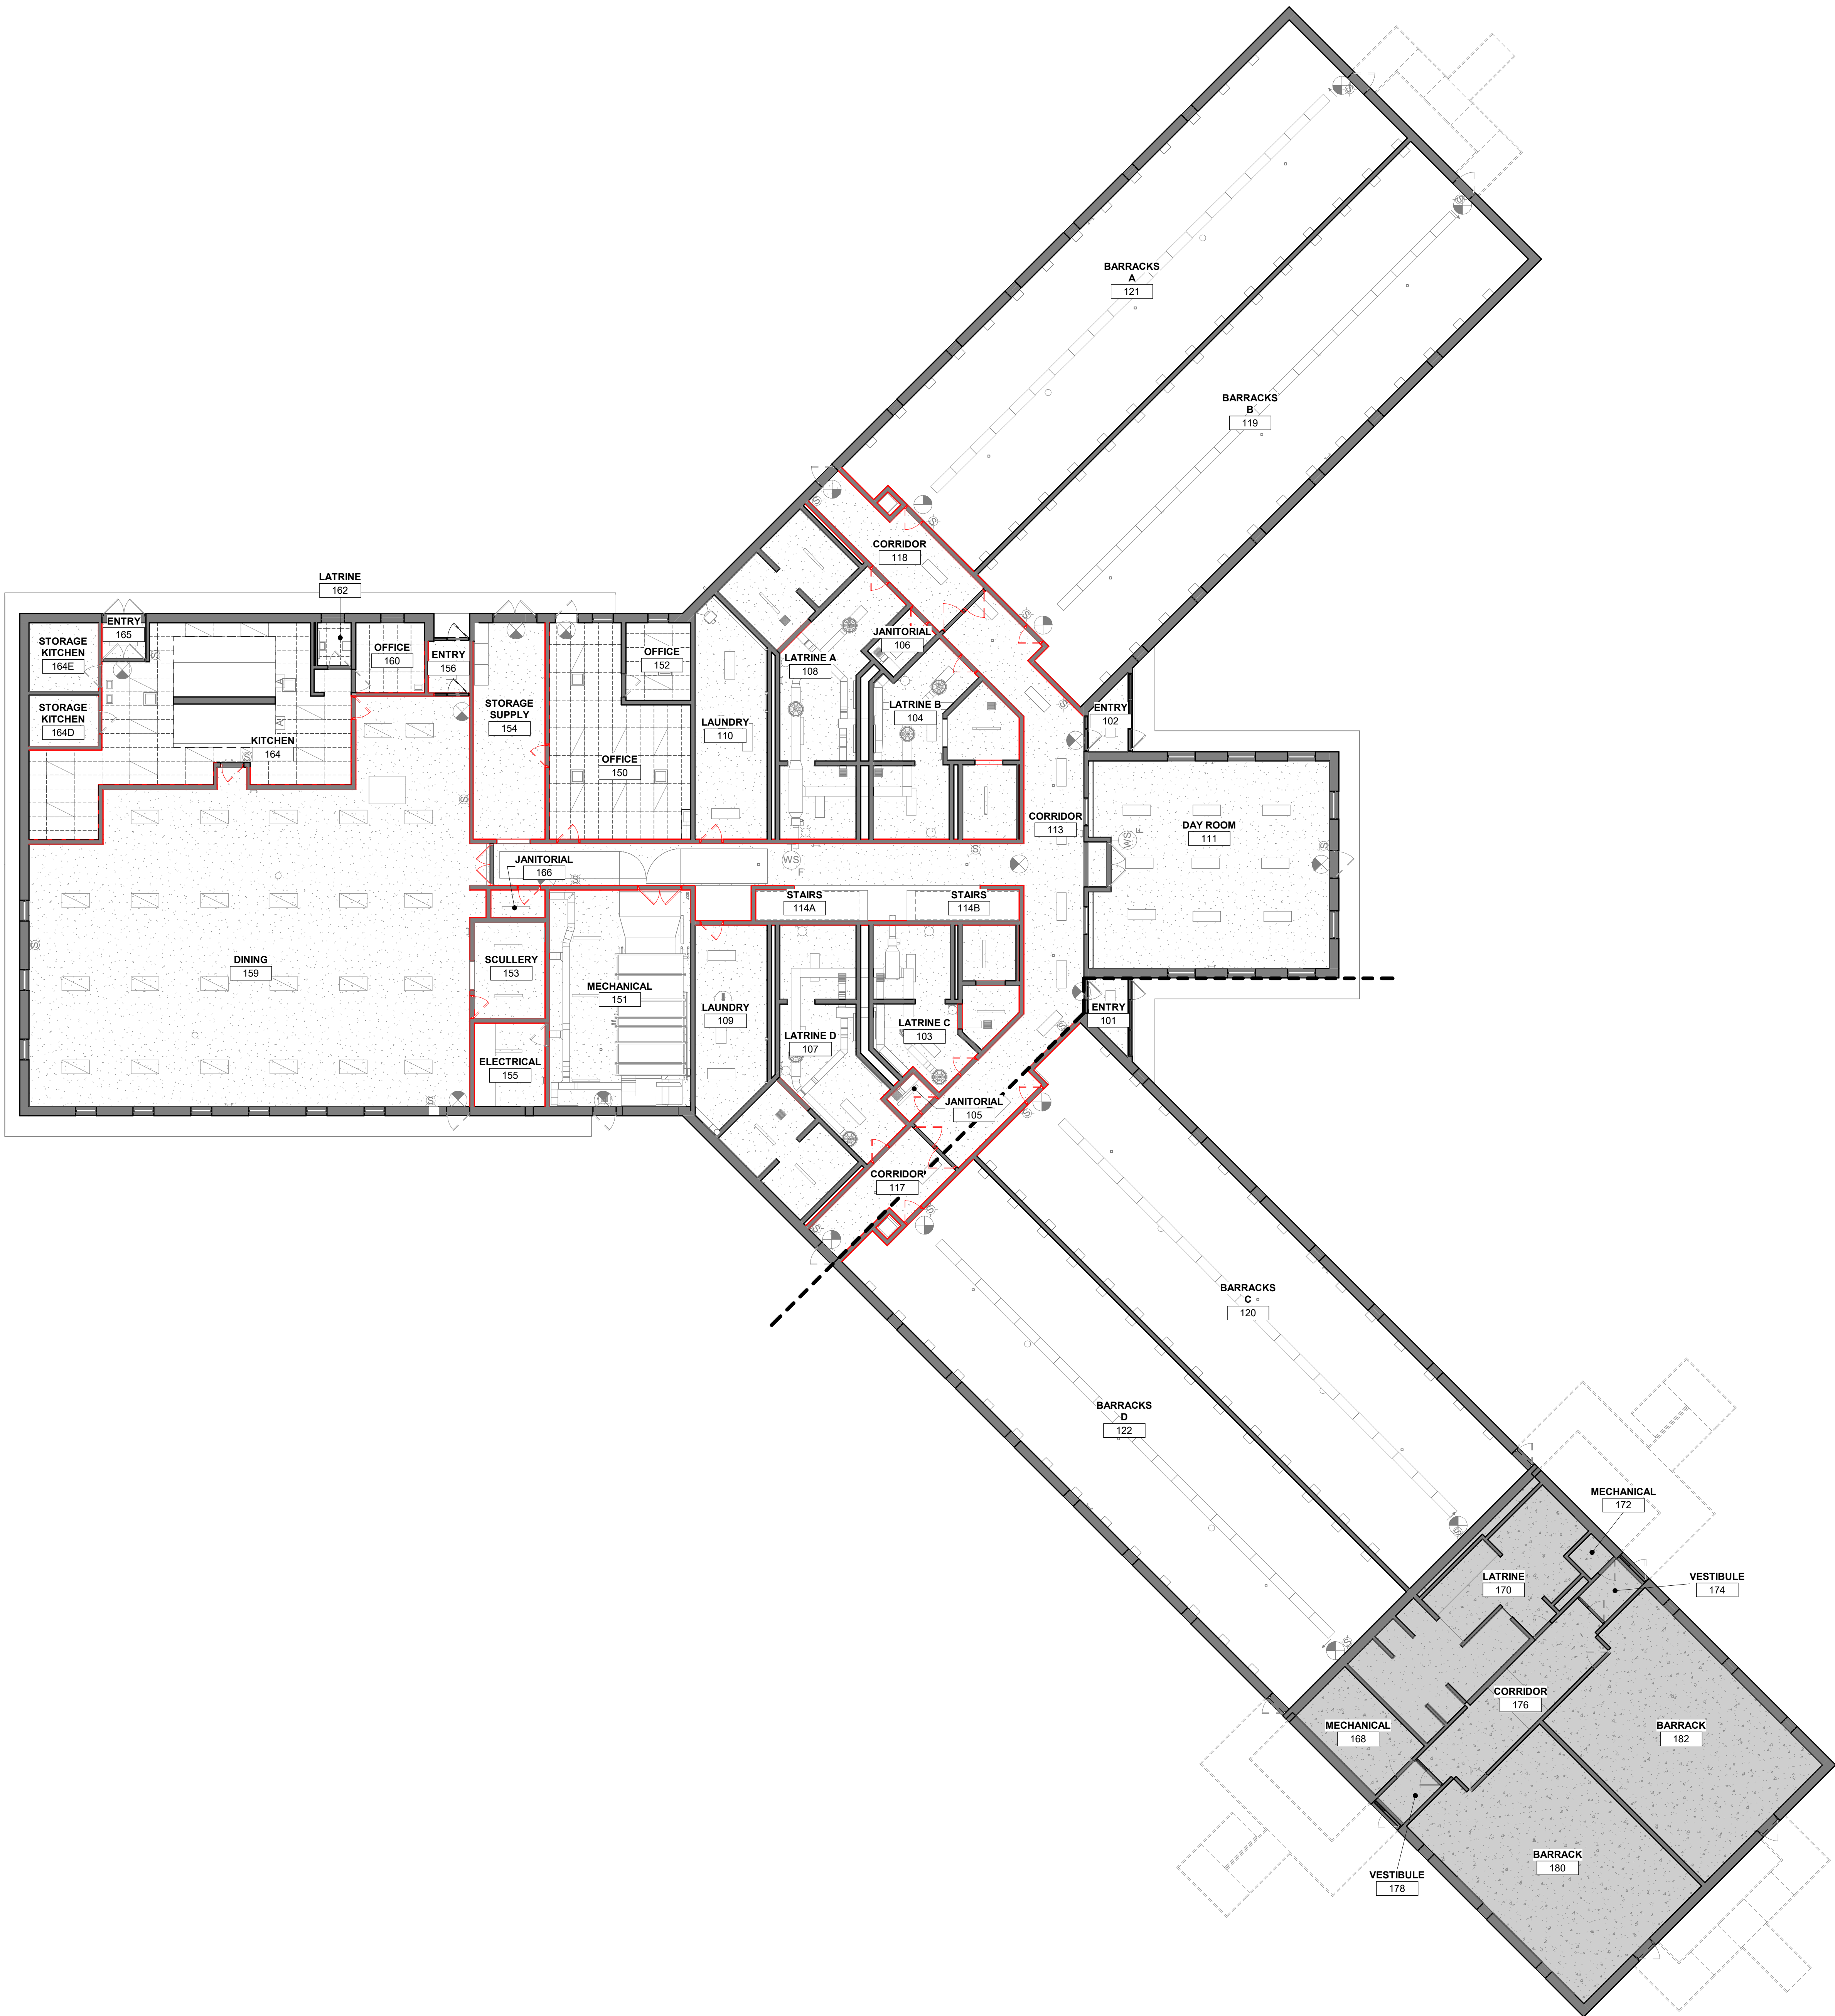

KEYPLAN

THIS DOCUMENT IS THE PROPERTY OF I & S GROUP, INC. AND MAY NOT BE USED, COPIED OR DUPLICATED WITHOUT PRIOR WRITTEN CONSENT.
© 2024 I & S GROUP, INC.

PROJECT

**IOWA ARMY
NATIONAL GUARD
S54 FINISH
UPGRADES**

CAMP DODGE, JOHNSTON IOWA

REVISION SCHEDULE		
DATE	DESCRIPTION	BY

PROJECT NO.	26-34920
FILE NAME	34920 Arch R26
DRAWN BY	MJT
DESIGNED BY	GMP
REVIEWED BY	GMP
ORIGINAL ISSUE DATE	09/08/26
CLIENT PROJECT NO.	19083733

TITLE

 
**FIRST FLOOR
REFLECTED
CEILING
DEMOLITION
PLAN - OVERALL**

SHEET

A1-13



1 FIRST FLOOR REFLECTED CEILING DEMOLITION PLAN - OVERALL
3/32" = 1'-0"






CEILING DEMOLITION SHEET NOTES

A. REPAIR CRACKING, HOLES, DEFECTS, ETC. AT ALL EXISTING GYPSUM BOARD CEILINGS IN ROOMS THAT WORK IS OCCURRING.

KEYNOTE LEGEND

17	EXISTING CEILING TO REMAIN. DO NOT PAINT CEILING. NO ADDITIONAL WORK REQUIRED.
D10	DEMO/REMOVE ACOUSTIC CEILING TILE AND GRID IN ITS ENTIRETY. EXISTING LIGHTING AND MECHANICAL EQUIPMENT (SUPPLY/RETURN GRILLES) TO BE REUSED. REMOVE AND SALVAGE FOR REINSTALLATION.
D12	DEMOLISH EXISTING ACOUSTIC CEILING TILE BULKHEAD & SOFFIT. DEMOLISH EXISTING CEILING GRID AND/OR FRAMING AROUND MECHANICAL/PLUMBING EQUIPMENT. PAINT EQUIPMENT TO MATCH ADJACENT WALL COLOR. REFER TO FINISH PLANS.
D13	REMOVE EXISTING WINDOW TREATMENTS. SALVAGE FOR REUSE.
D14	REPAIR ALL EXISTING CRACKING IN GYPSUM BOARD CEILING. PREPARE FOR NEW PAINT. REFER TO FINISH PLANS AND REFLECTED CEILING PLANS.
D18	REPAIR ANY CRACKING IN EXISTING PRECAST PANEL CEILING. PREPARE FOR NEW PAINT. REFER TO FINISH PLANS AND REFLECTED CEILING PLANS.

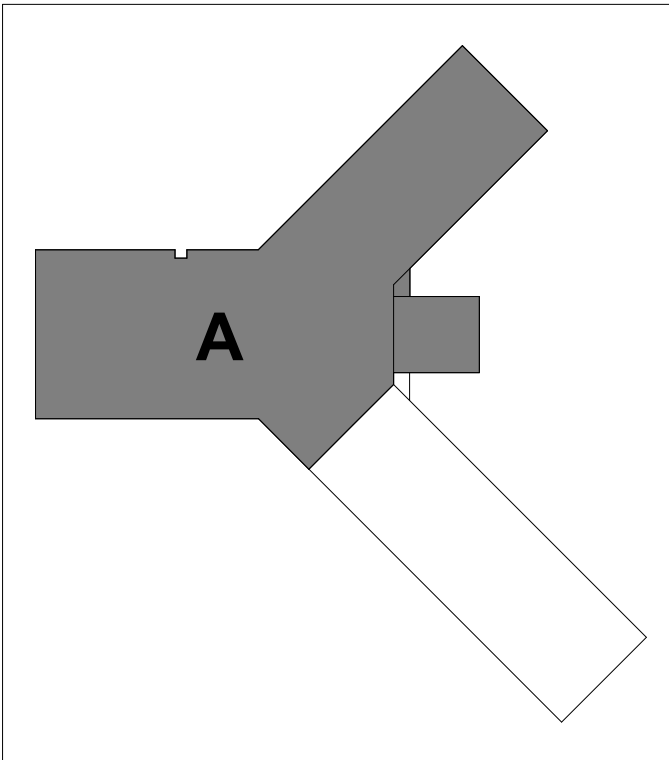

KEYPLAN

THIS DOCUMENT IS THE PROPERTY OF I & S GROUP, INC. AND MAY NOT BE USED, COPIED OR DUPLICATED WITHOUT PRIOR WRITTEN CONSENT.
© 2024 I & S GROUP, INC.

PROJECT

IOWA ARMY
NATIONAL GUARD
S54 FINISH
UPGRADES

CAMP DODGE, JOHNSTON IOWA

REVISION SCHEDULE		
DATE	DESCRIPTION	BY



PROJECT NO.	26-34920
FILE NAME	34920 Arch R26
DRAWN BY	MJT
DESIGNED BY	GMP
REVIEWED BY	GMP
ORIGINAL ISSUE DATE	09/08/26
CLIENT PROJECT NO.	19083733

TITLE

FIRST FLOOR
REFLECTED
CEILING
DEMOLITION
PLAN - AREA A

SHEET

 A1-13A

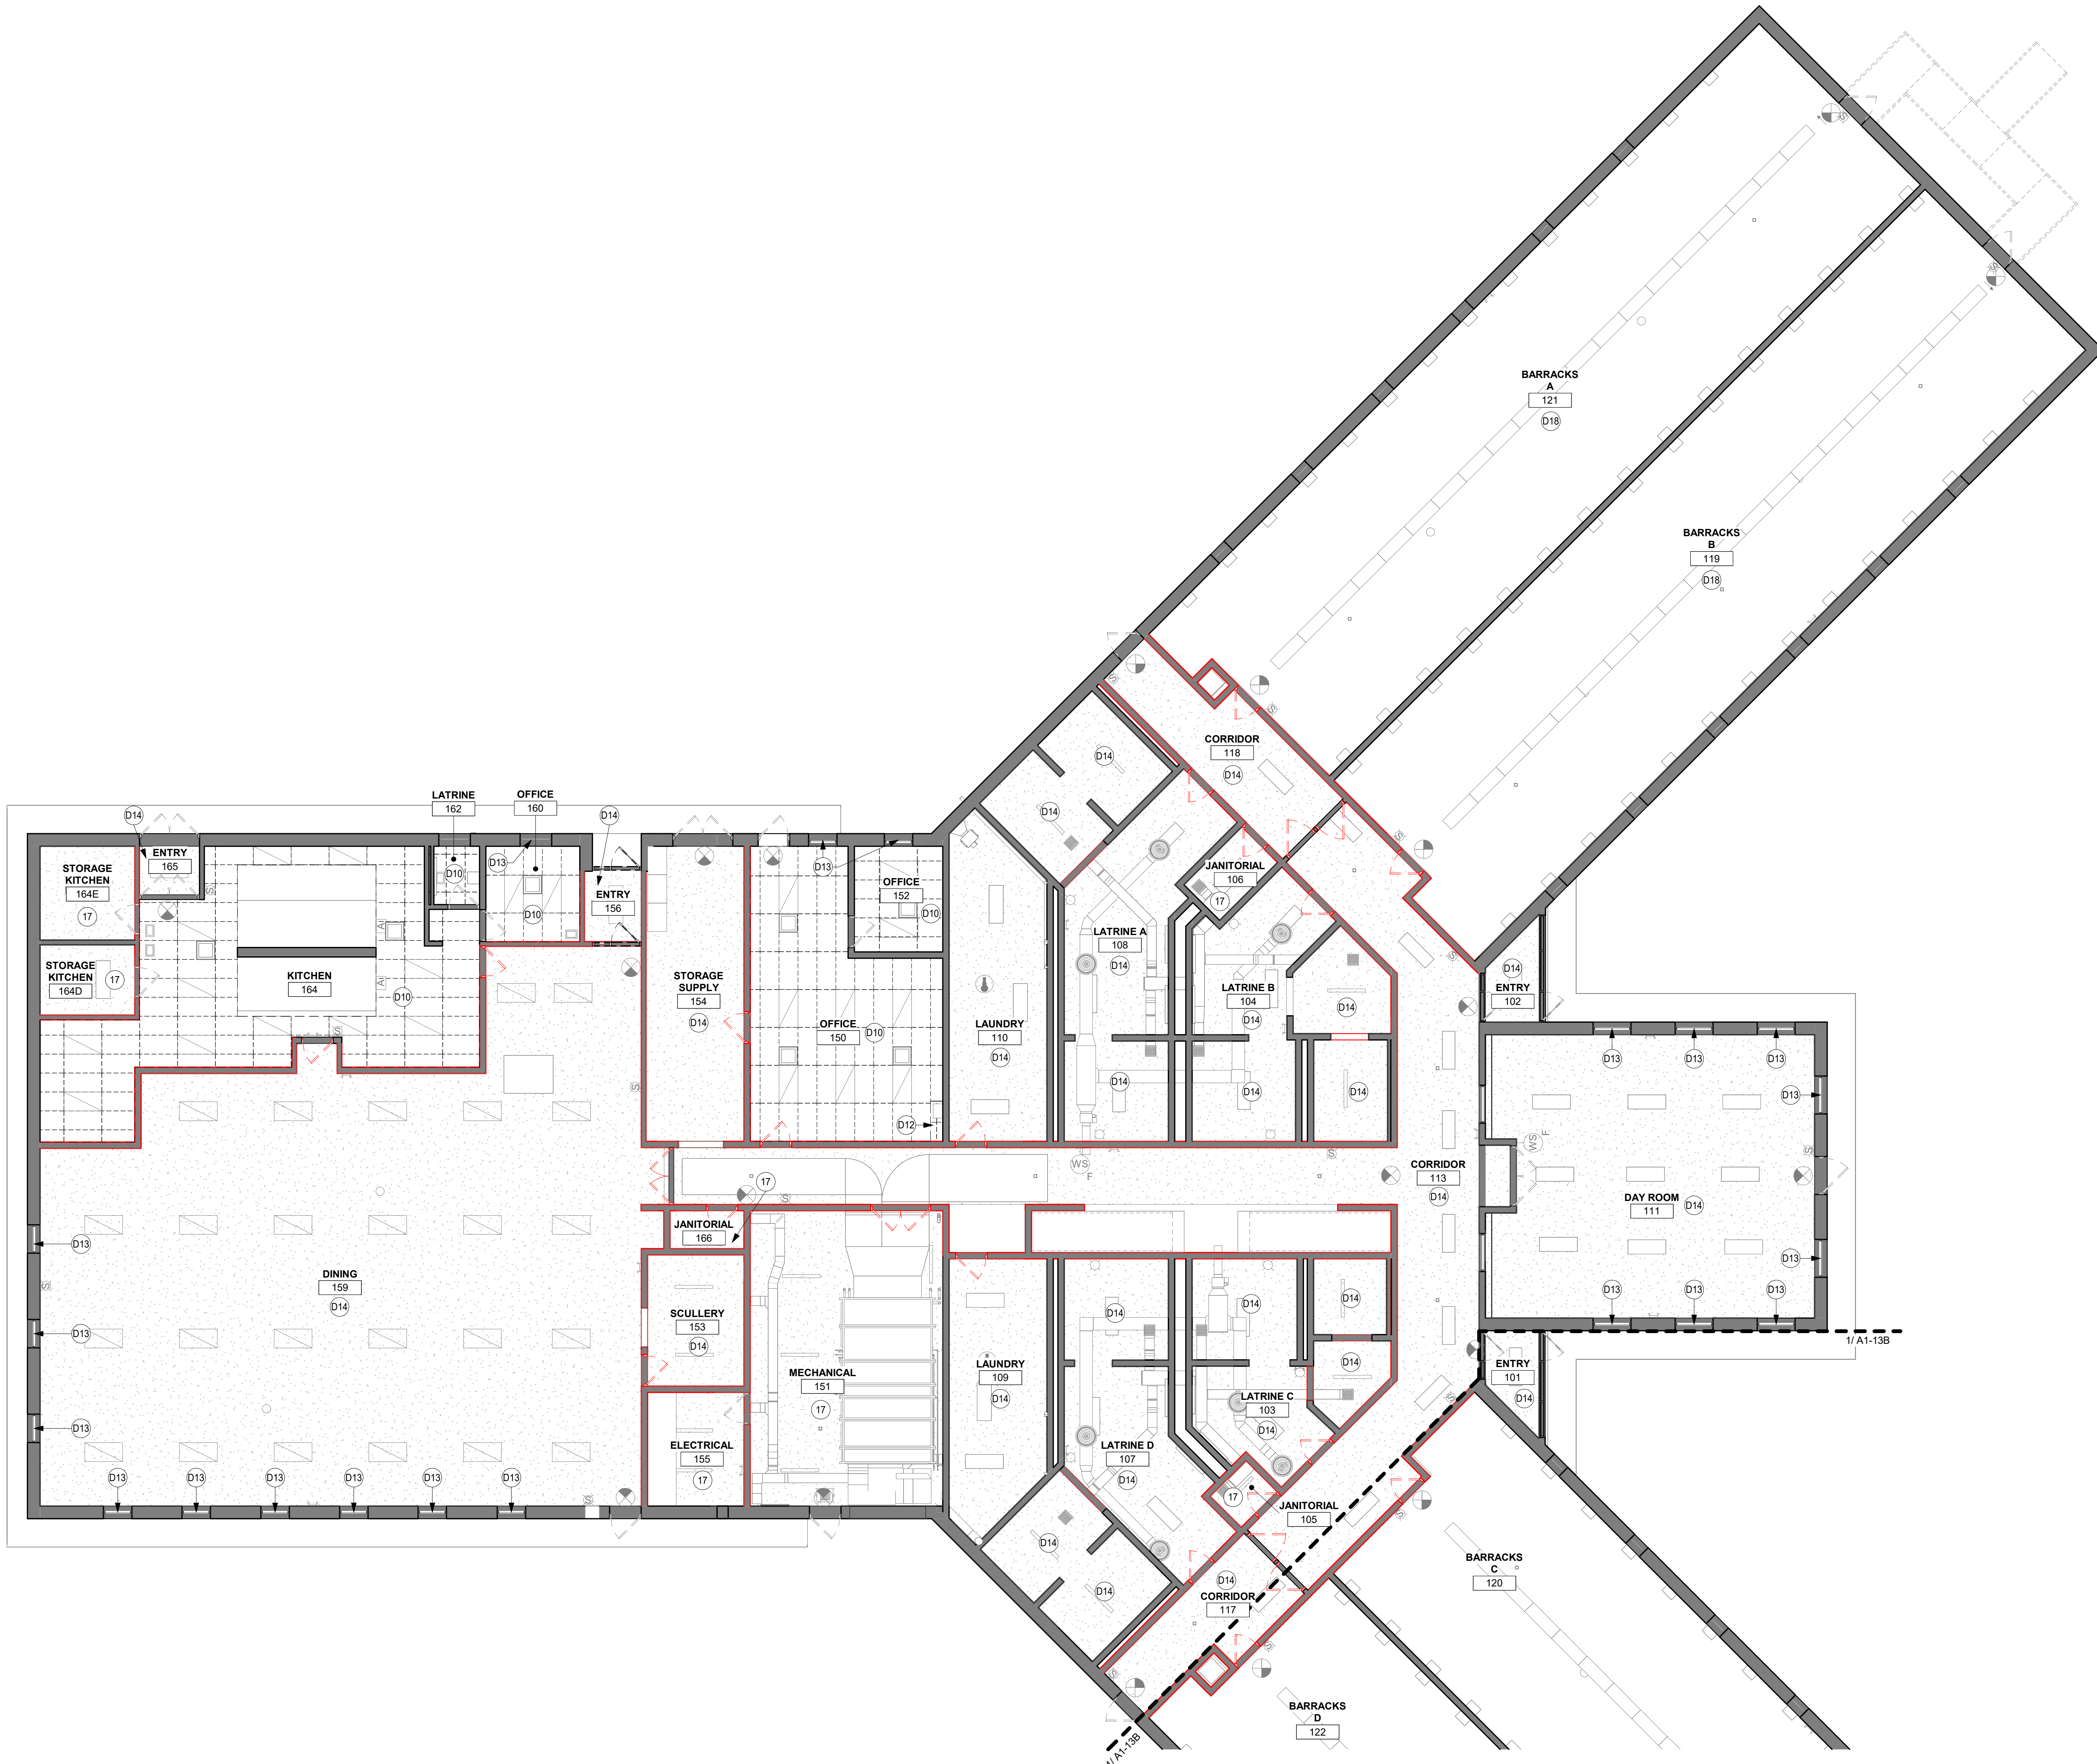


1 FIRST FLOOR REFLECTED CEILING DEMOLITION PLAN - AREA A
1/8" = 1'-0"



FLOOR PLAN LEGEND
SHADED REGION INDICATES AREA OF PLANS THAT ARE NOT INCLUDED IN SCOPE OF WORK.

CEILING DEMOLITION SHEET NOTES
A. REPAIR CRACKING, HOLES, DEFECTS, ETC. AT ALL EXISTING GYPSUM BOARD CEILINGS IN ROOMS THAT WORK IS OCCURRING.

KEYNOTE LEGEND
D14 | REPAIR ALL EXISTING CRACKING IN GYPSUM BOARD CEILING. PREPARE FOR NEW PAINT. REFER TO FINISH PLANS AND REFLECTED CEILING PLANS.
D18 | REPAIR ANY CRACKING IN EXISTING PRECAST PANEL CEILING. PREPARE FOR NEW PAINT. REFER TO FINISH PLANS AND REFLECTED CEILING PLANS.

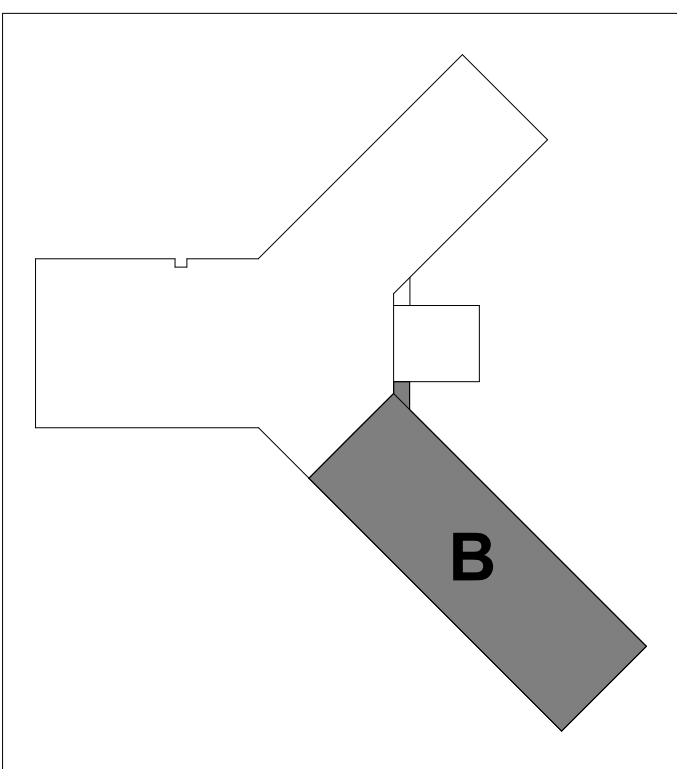

KEYPLAN

THIS DOCUMENT IS THE PROPERTY OF I & S GROUP, INC. AND MAY NOT BE USED, COPIED OR DUPLICATED WITHOUT PRIOR WRITTEN CONSENT.
© 2024 I & S GROUP, INC.

PROJECT

**IOWA ARMY
NATIONAL GUARD
S54 FINISH
UPGRADES**

CAMP DODGE, JOHNSTON IOWA

REVISION SCHEDULE		
DATE	DESCRIPTION	BY


PROJECT NO.	26-34920
FILE NAME	34920 Arch R26
DRAWN BY	MJT
DESIGNED BY	GMP
REVIEWED BY	GMP
ORIGINAL ISSUE DATE	09/08/26
CLIENT PROJECT NO.	19083733

TITLE

**FIRST AND
SECOND FLOOR
REFLECTED
CEILING
DEMOLITION
PLANS - AREA B**


SHEET

A1-13B

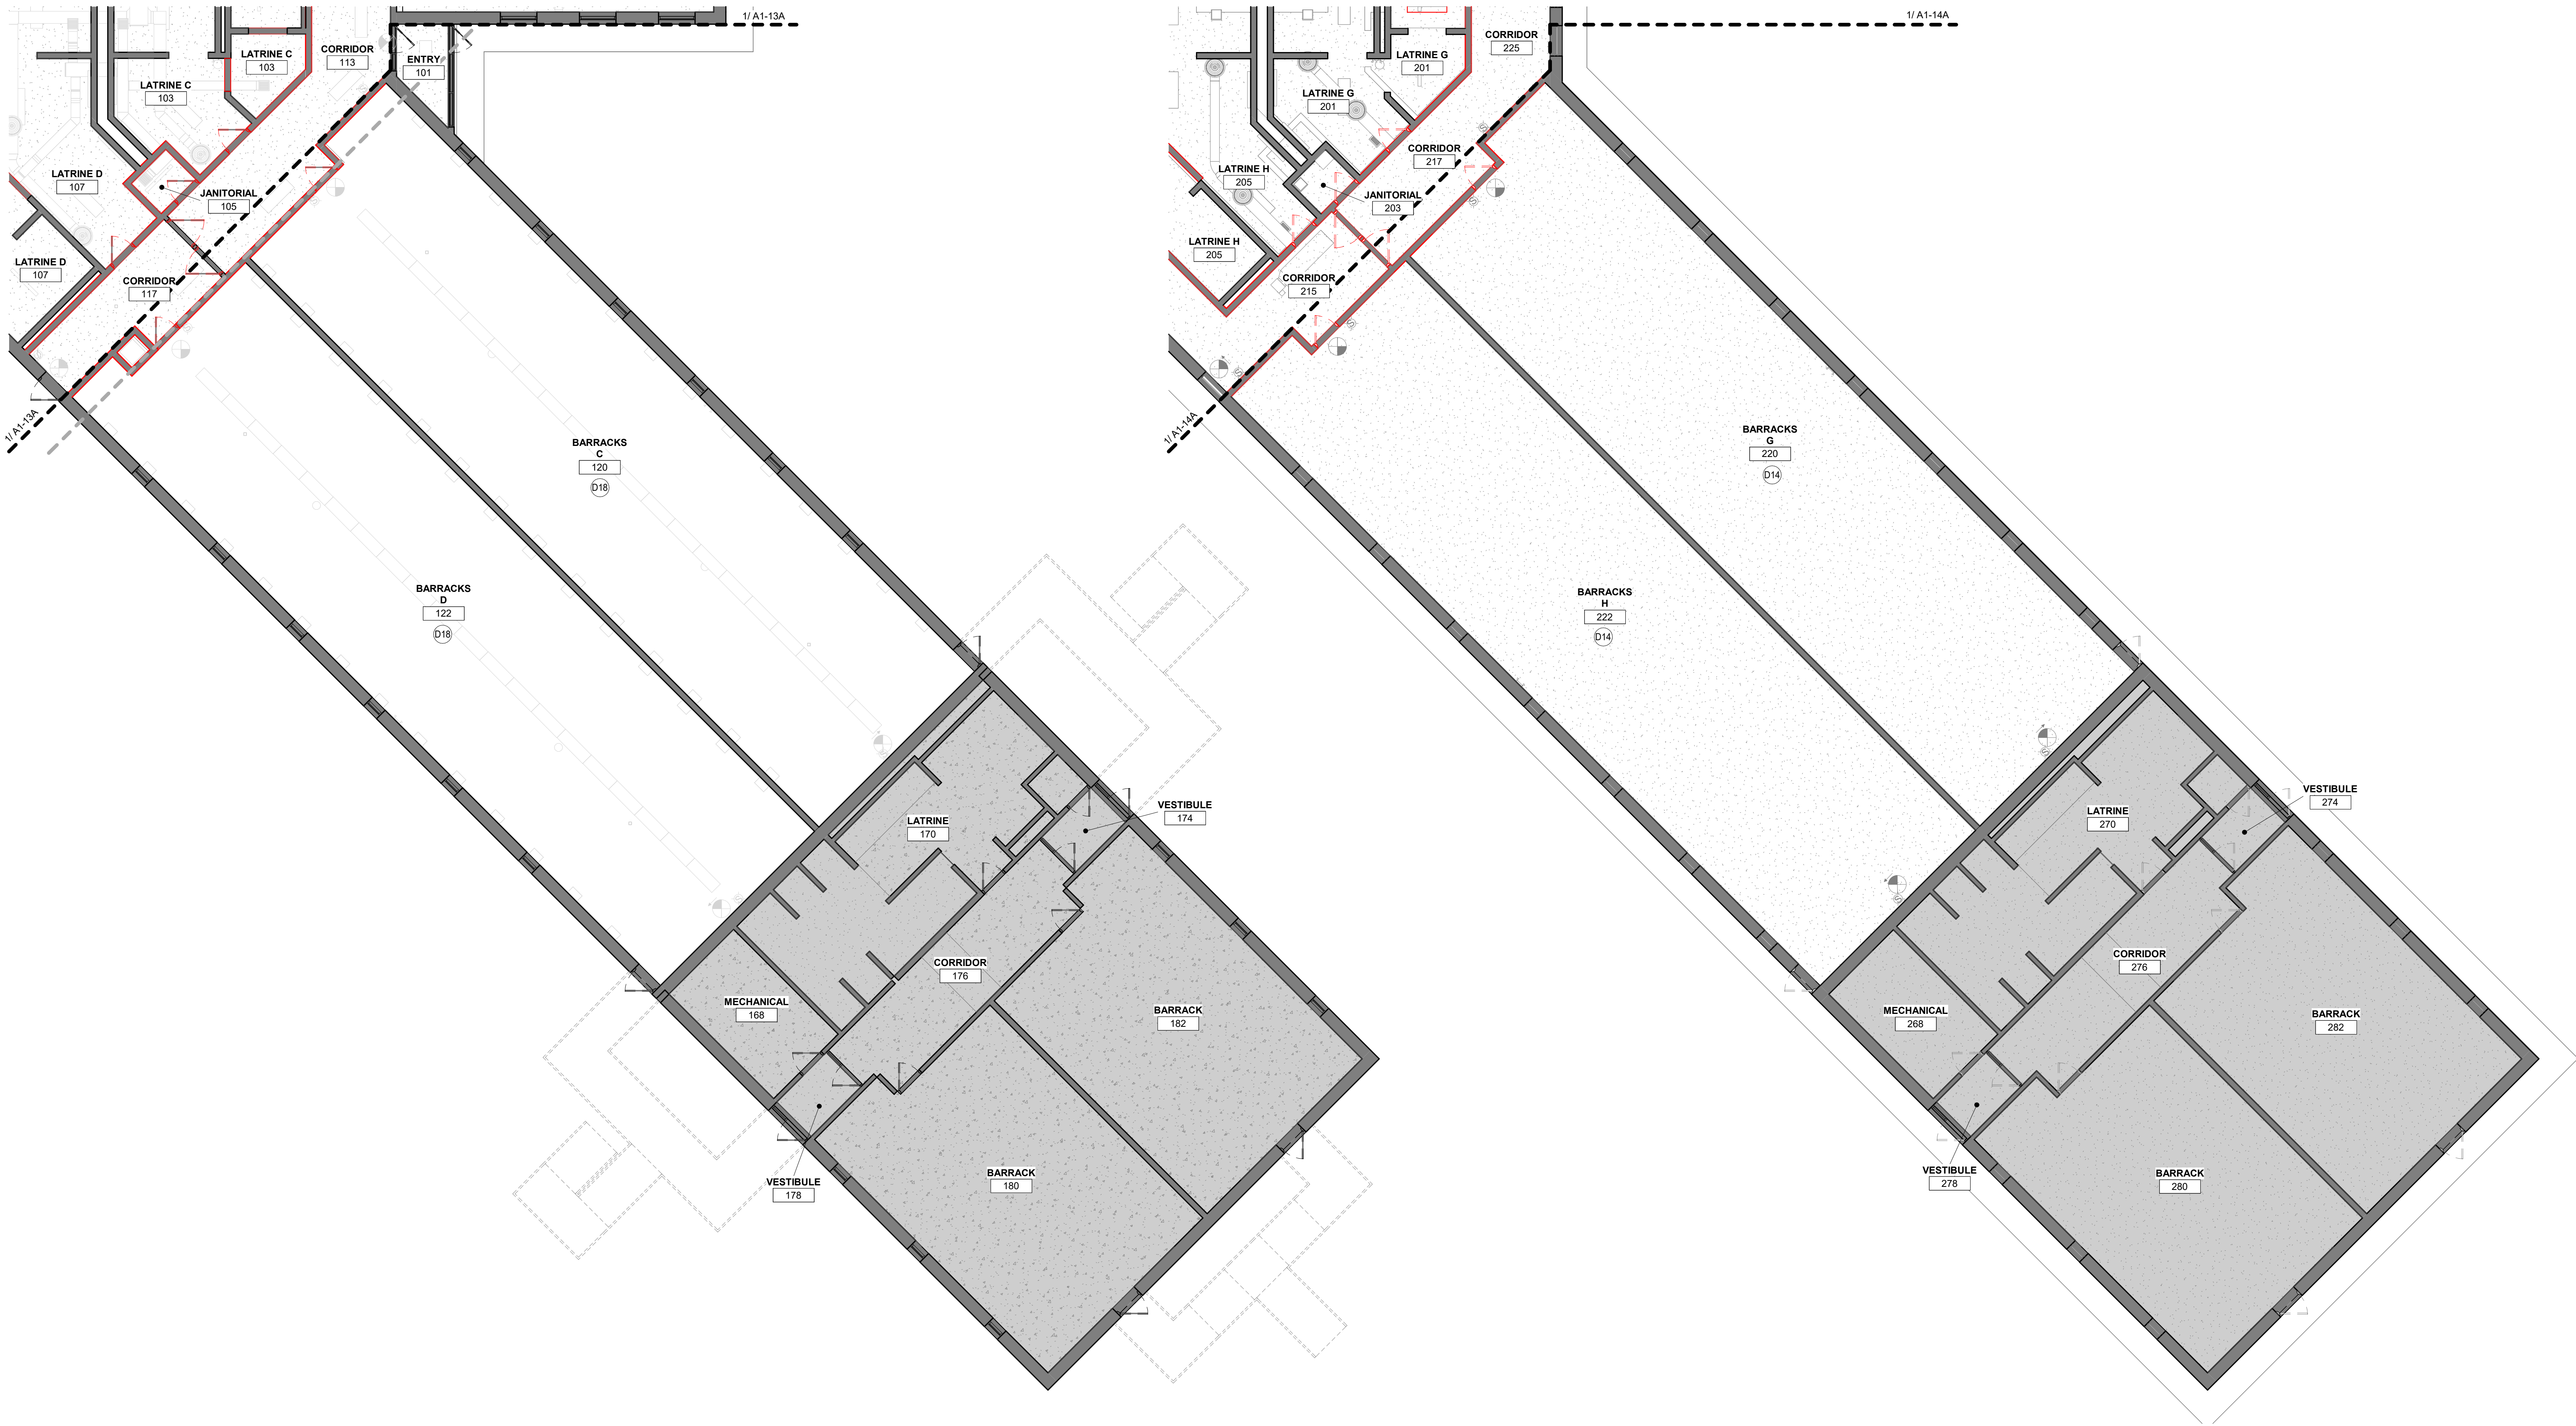

1 FIRST FLOOR REFLECTED CEILING DEMOLITION PLAN - AREA B
1/8" = 1'-0"

 2 SECOND FLOOR REFLECTED CEILING DEMOLITION PLAN - AREA B
1/8" = 1'-0"



REFERENCE SCALE
1" = 1'-0"
0 1/4" 1/2" 1" 2"


1

SECOND FLOOR REFLECTED CEILING DEMOLITION PLAN - OVERALL
3/32" = 1'-0"

9/8/2028 3:13:37 PM

FLOOR PLAN LEGEND

SHADED REGION INDICATES AREA OF PLANS THAT ARE NOT INCLUDED IN SCOPE OF WORK.

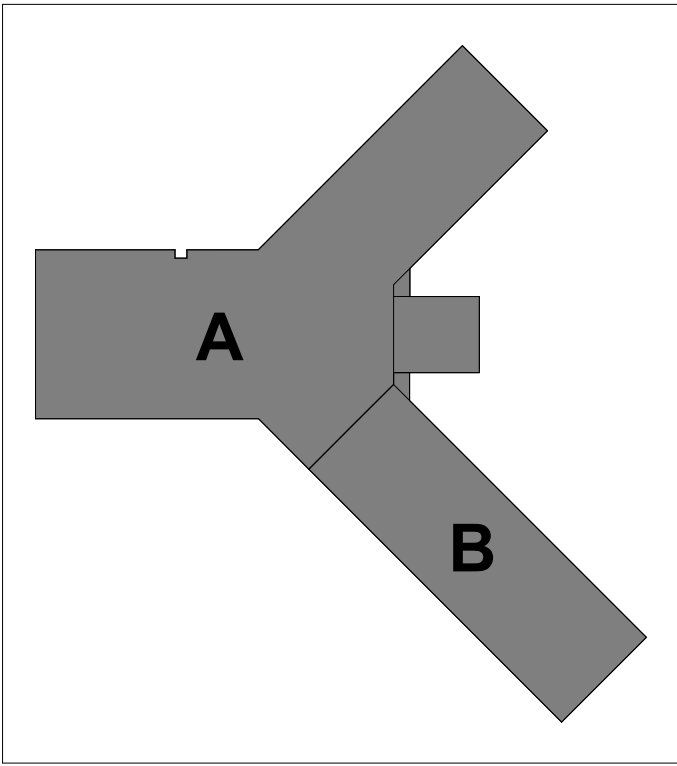

KEYPLAN

THIS DOCUMENT IS THE PROPERTY OF I & S GROUP, INC. AND MAY NOT BE USED, COPIED OR DUPLICATED WITHOUT PRIOR WRITTEN CONSENT.
© 2024 I & S GROUP, INC.

PROJECT

**IOWA ARMY
NATIONAL GUARD
S54 FINISH
UPGRADES**

CAMP DODGE, JOHNSTON IOWA

REVISION SCHEDULE		
DATE	DESCRIPTION	BY


PROJECT NO.	26-34920
FILE NAME	34920 Arch R26
DRAWN BY	MJT
DESIGNED BY	GMP
REVIEWED BY	GMP
ORIGINAL ISSUE DATE	09/08/26
CLIENT PROJECT NO.	19083733

TITLE

**SECOND FLOOR
REFLECTED
CEILING
DEMOLITION
PLAN - OVERALL**

SHEET

 A1-14




CEILING DEMOLITION SHEET NOTES

A. REPAIR CRACKING, HOLES, DEFECTS, ETC. AT ALL EXISTING GYPSUM BOARD CEILINGS IN ROOMS THAT WORK IS OCCURRING.

KEYNOTE LEGEND

17 EXISTING CEILING TO REMAIN. DO NOT PAINT CEILING. NO ADDITIONAL WORK REQUIRED.
D14 REPAIR ALL EXISTING CRACKING IN GYPSUM BOARD CEILING. PREPARE FOR NEW PAINT. REFER TO FINISH PLANS AND REFLECTED CEILING PLANS.

ISG

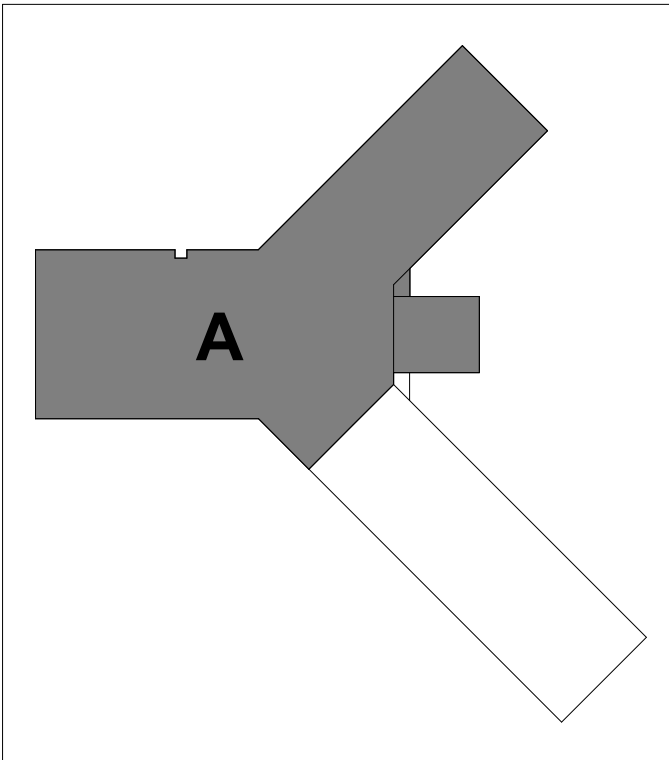

KEYPLAN

THIS DOCUMENT IS THE PROPERTY OF I & S GROUP, INC. AND MAY NOT BE USED, COPIED OR DUPLICATED WITHOUT PRIOR WRITTEN CONSENT.
© 2024 I & S GROUP, INC.

PROJECT

IOWA ARMY
NATIONAL GUARD
S54 FINISH
UPGRADES

CAMP DODGE, JOHNSTON IOWA

REVISION SCHEDULE		
DATE	DESCRIPTION	BY


PROJECT NO.	26-34920
FILE NAME	34920 Arch R26
DRAWN BY	MJT
DESIGNED BY	GMP
REVIEWED BY	GMP
ORIGINAL ISSUE DATE	09/08/26
CLIENT PROJECT NO.	19083733

TITLE

SECOND FLOOR
REFLECTED
CEILING
DEMOLITION
PLAN - AREA A


SHEET

A1-14A

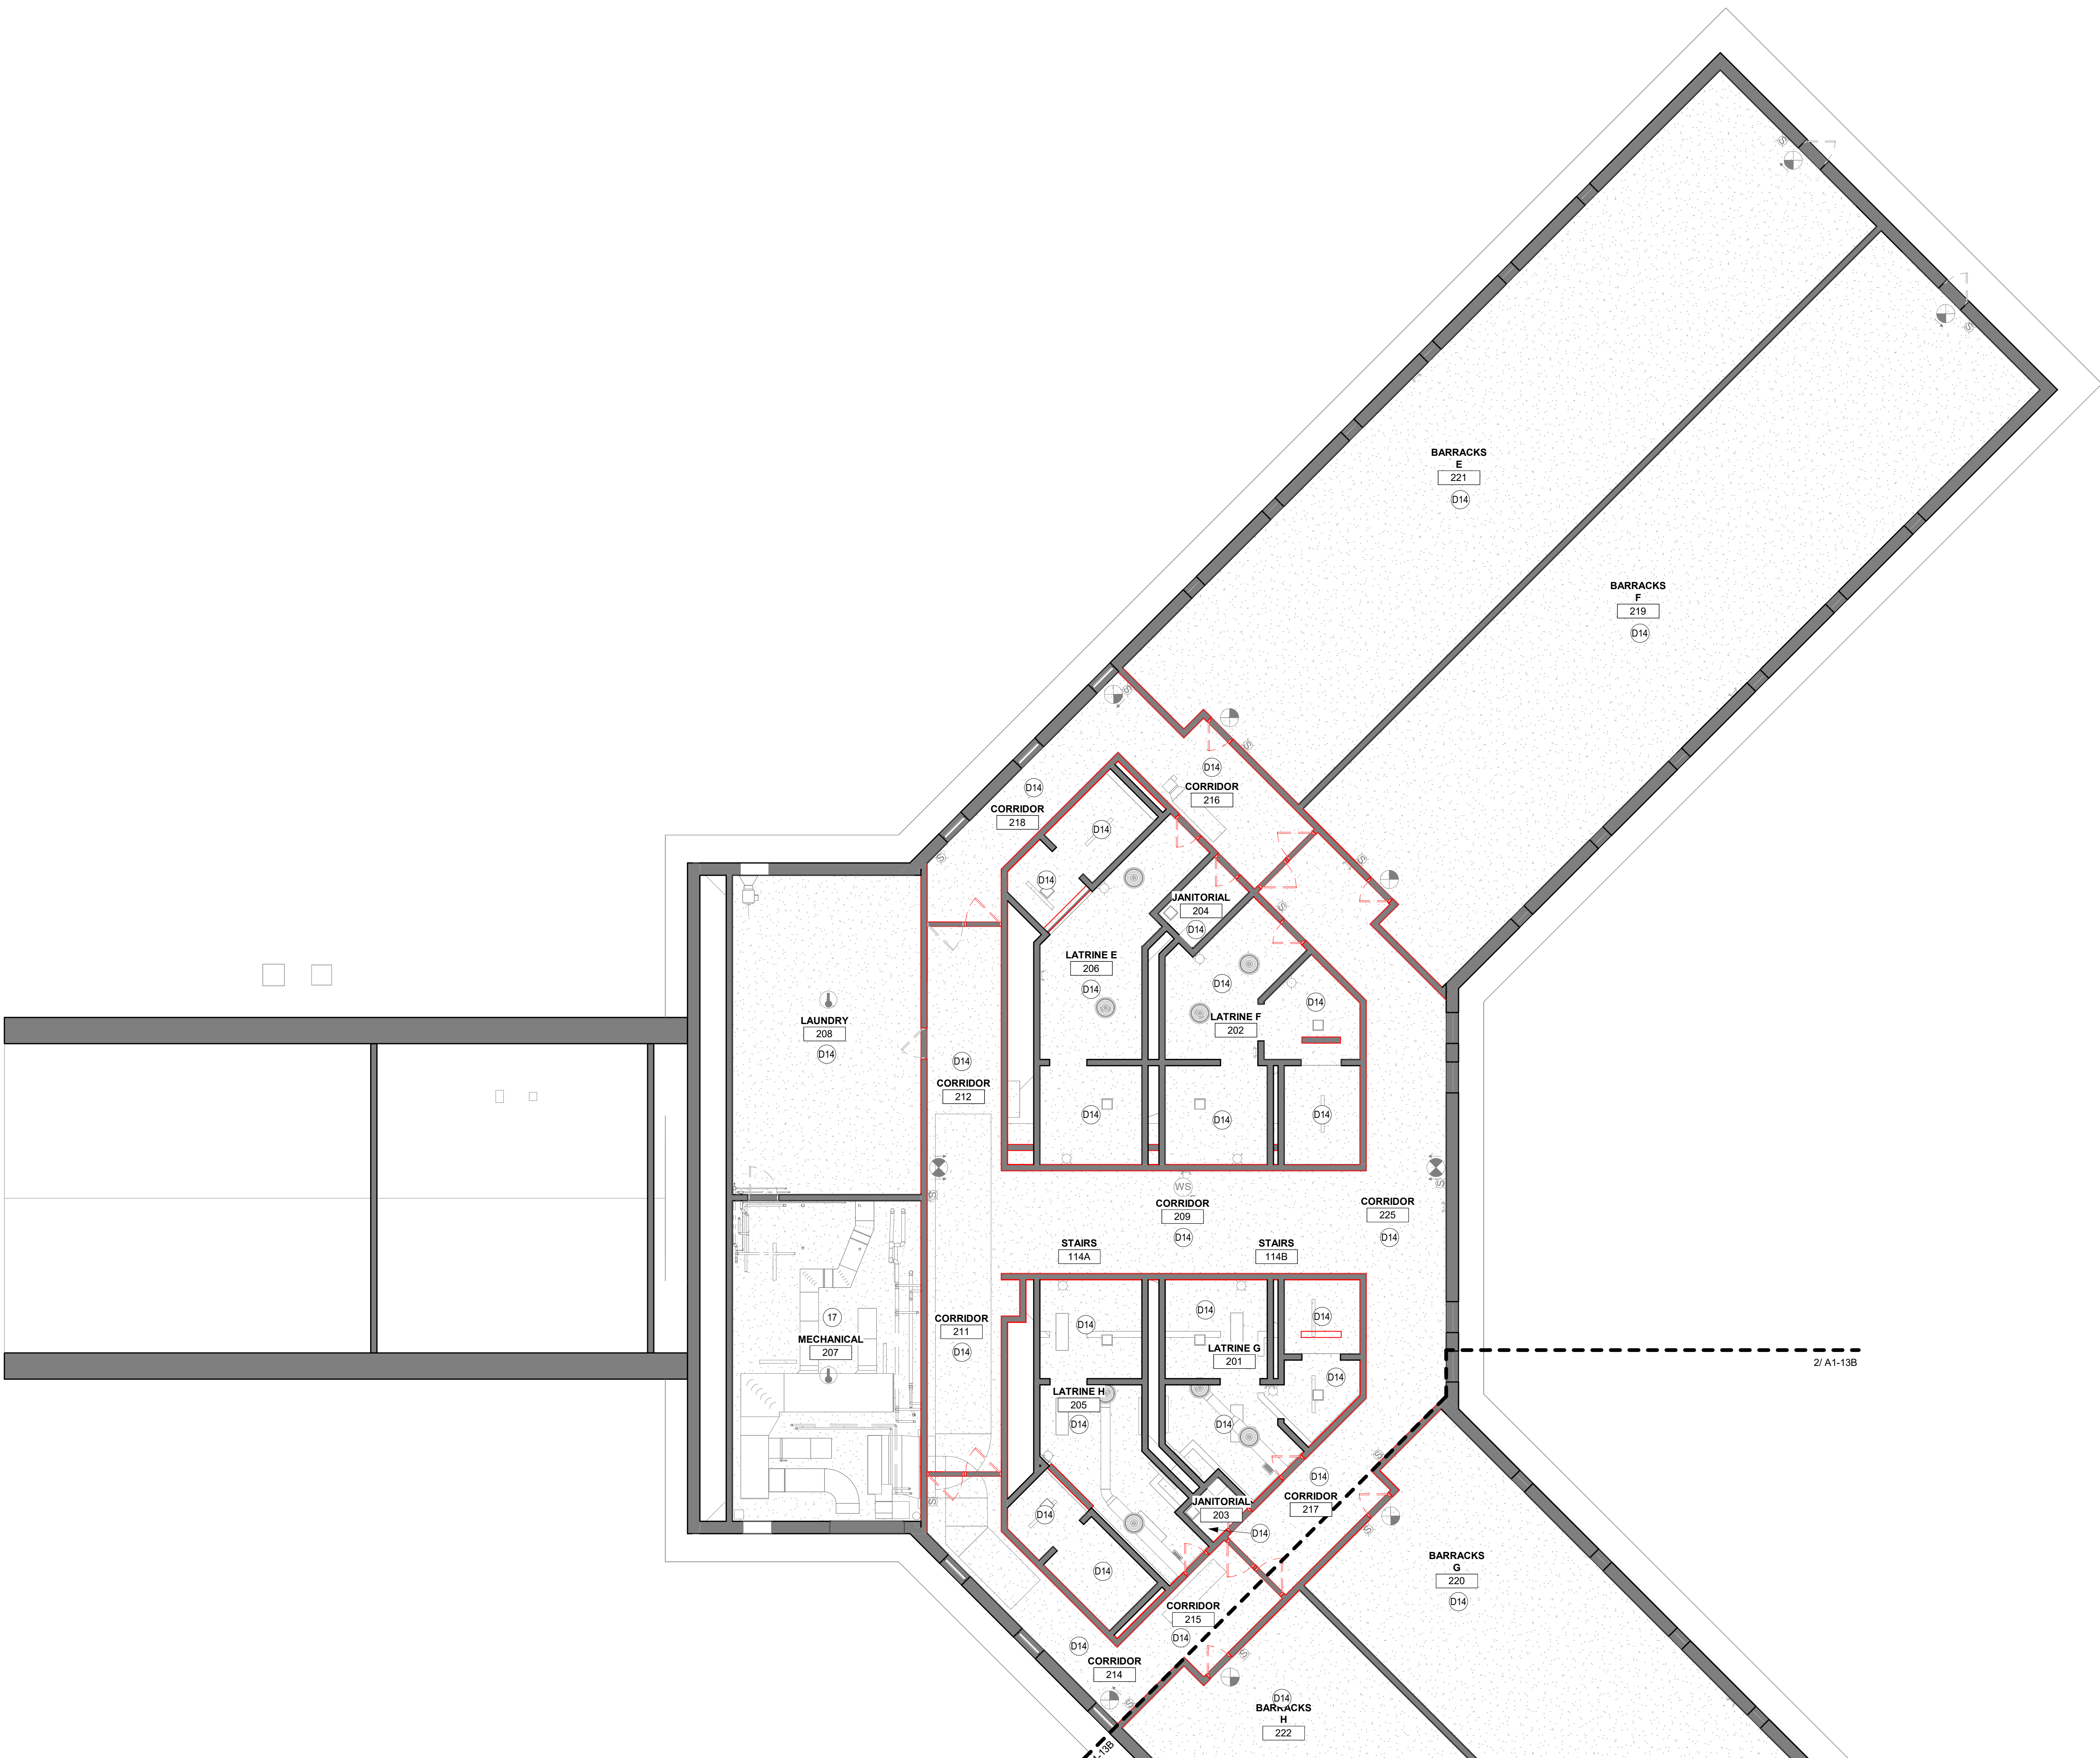

1 SECOND FLOOR REFLECTED CEILING DEMOLITION PLAN - AREA A
1/8" = 1'-0"



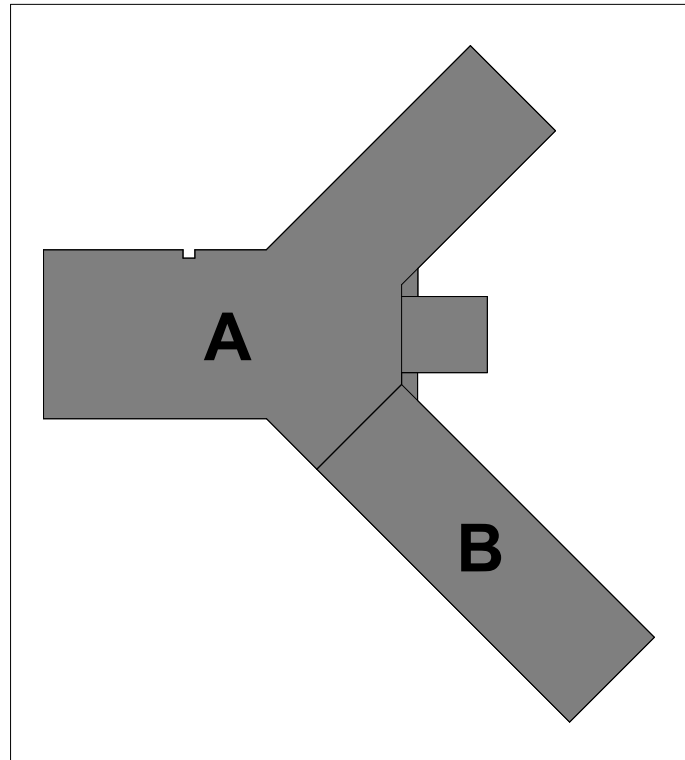

KEYPLAN

THIS DOCUMENT IS THE PROPERTY OF I & S GROUP, INC. AND MAY NOT BE USED, COPIED OR DUPLICATED WITHOUT PRIOR WRITTEN CONSENT.
© 2024 I & S GROUP, INC.

PROJECT

**IOWA ARMY
NATIONAL GUARD
S54 FINISH
UPGRADES**

CAMP DODGE, JOHNSTON IOWA

REVISION SCHEDULE		
DATE	DESCRIPTION	BY

PROJECT NO.	26-34920
FILE NAME	34920 Arch R26
DRAWN BY	MJT
DESIGNED BY	GMP
REVIEWED BY	GMP
ORIGINAL ISSUE DATE	09/08/26
CLIENT PROJECT NO.	19083733

TITLE

**FIRST FLOOR
PLAN - OVERALL**

SHEET

A1-21

FLOOR PLAN LEGEND

SHADED REGION INDICATES AREA OF PLANS THAT ARE NOT INCLUDED IN SCOPE OF WORK.


WALL LEGEND

EXISTING CONSTRUCTION TO REMAIN

NEW CONSTRUCTION

FLOOR PLAN SHEET NOTES

- ALL WALL MOUNTED ITEMS TO SIT FLUSH ON A WALL SURFACE. IN INSTANCES WHERE A WALL MOUNTED ITEM IS TO BE INSTALLED ON TWO DIFFERENT FINISH THICKNESSES, PROVIDE A HARDBOARD BACKER FOR THE ITEM TO SIT FLUSH. PROVIDE SEALANT AROUND ALL EDGES OF BACKER AND PAINT TO MATCH ADJACENT SURFACE.


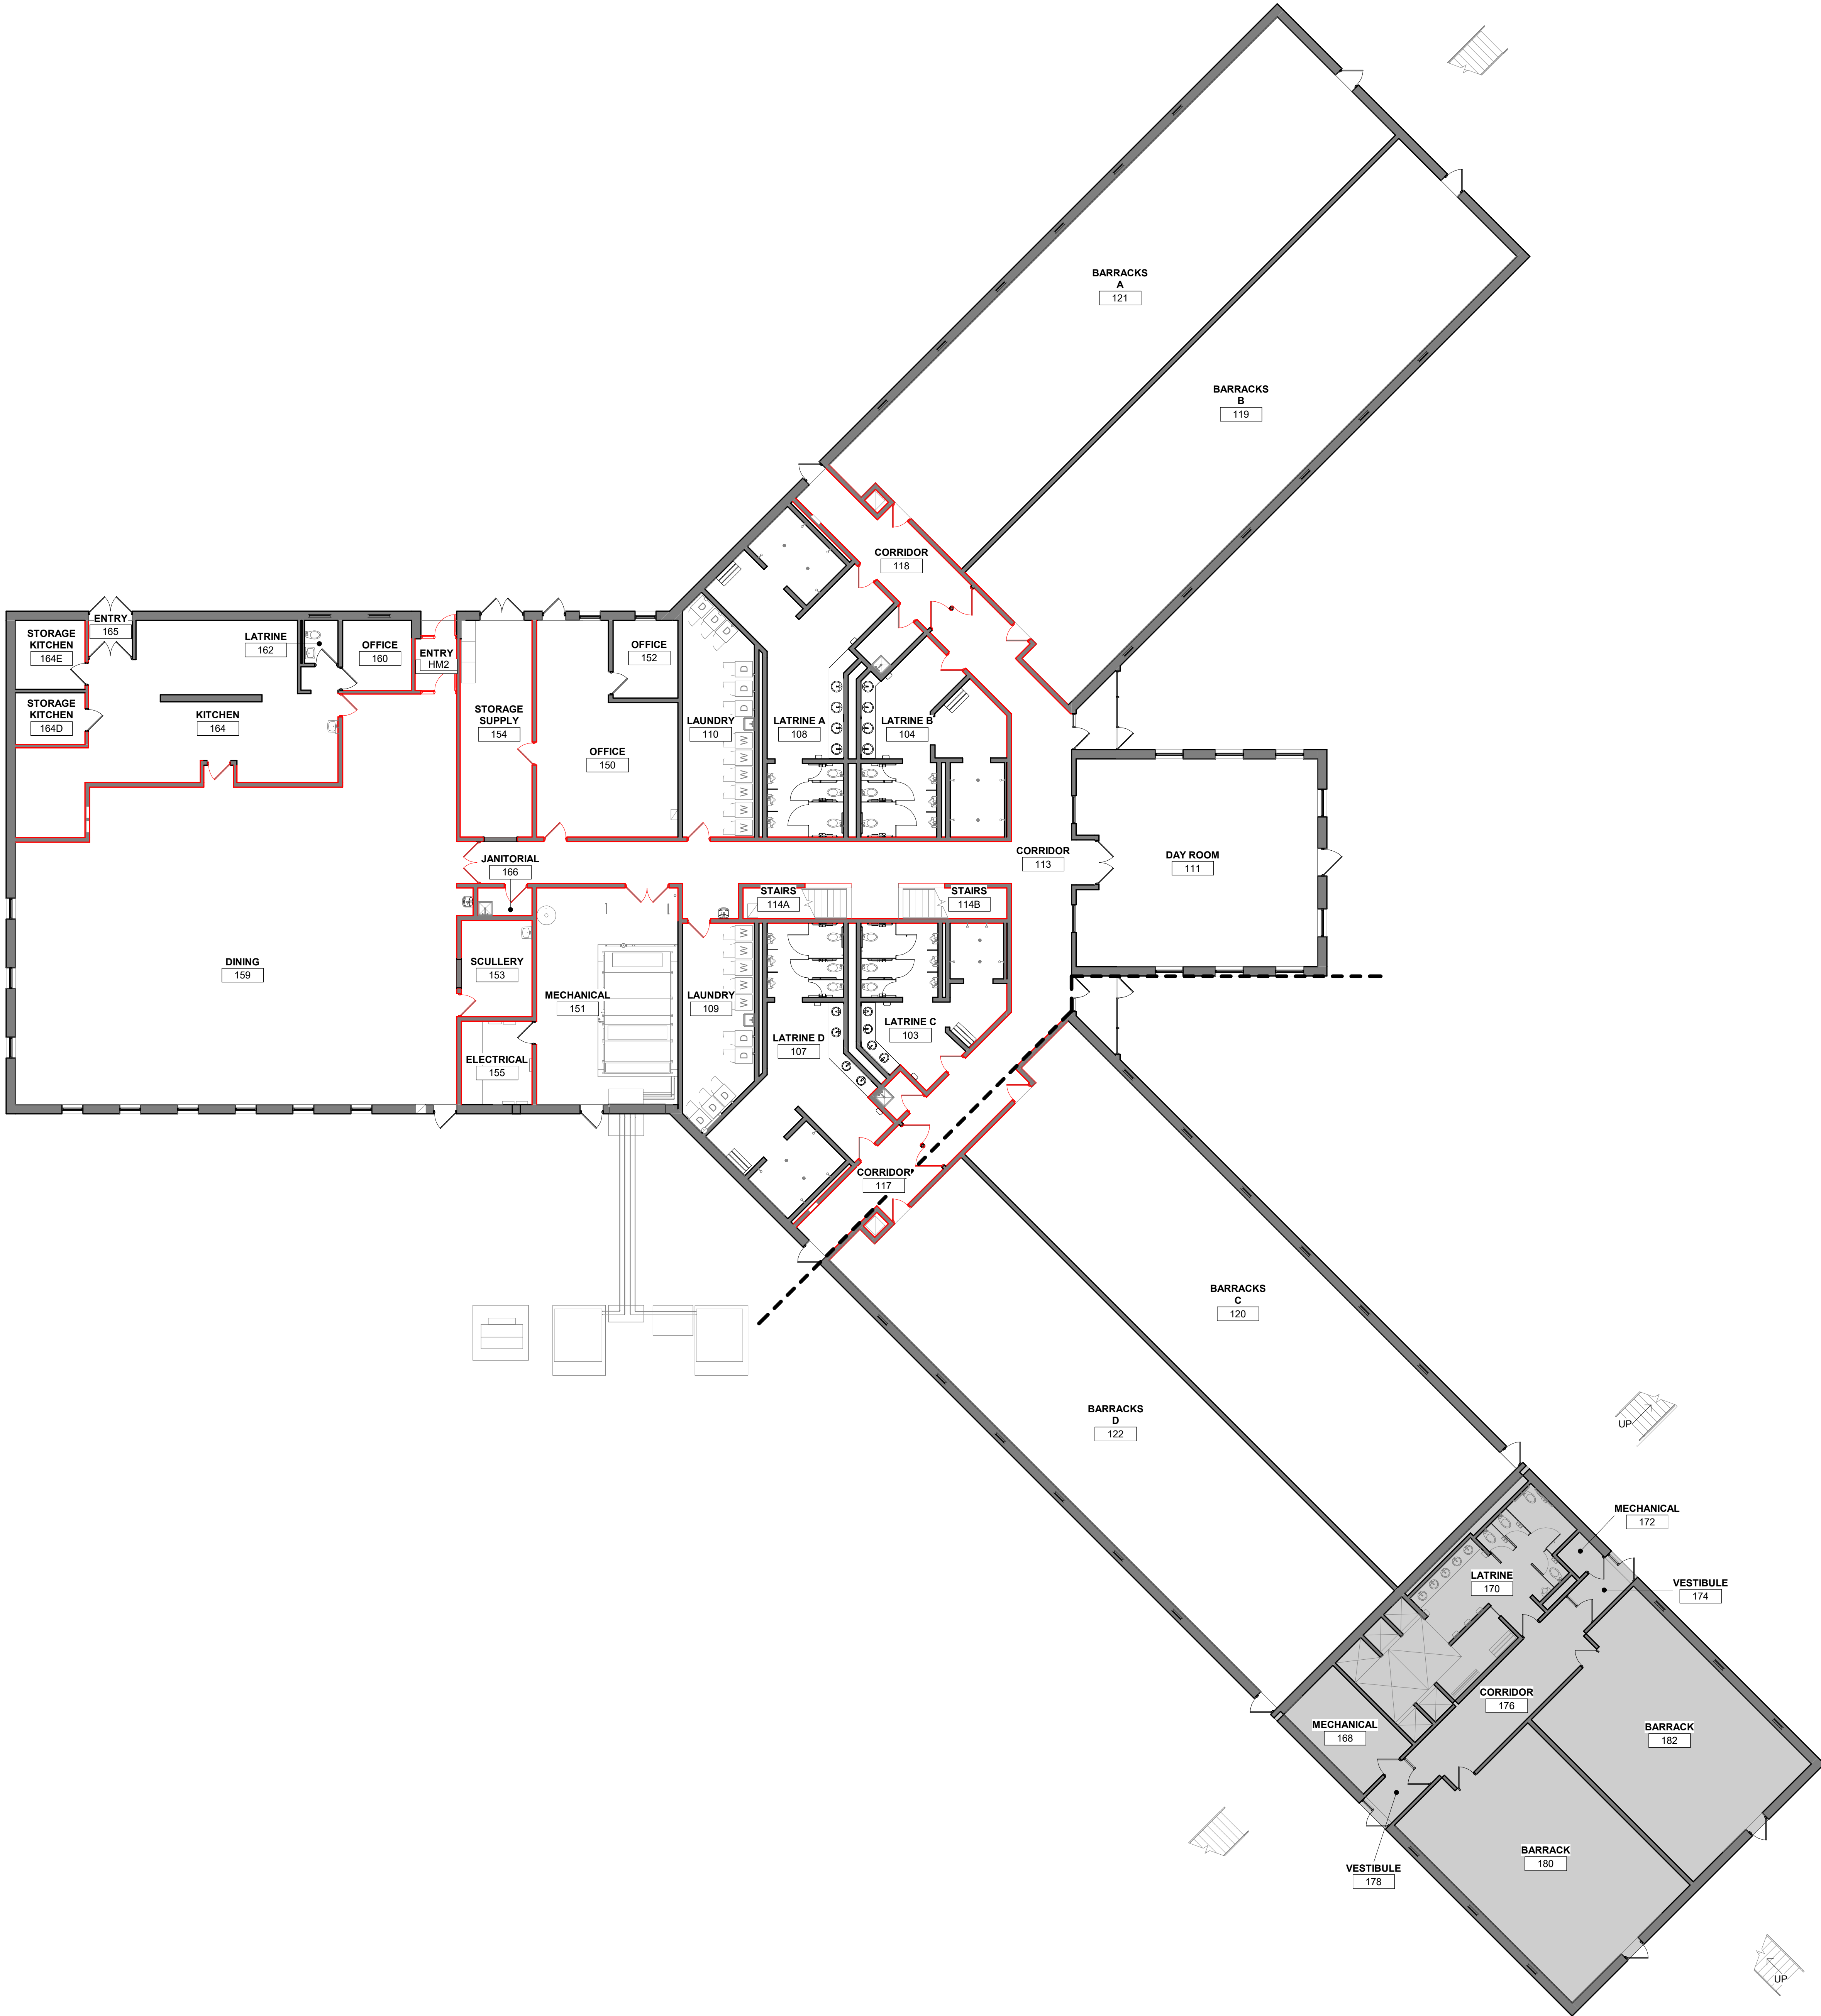


REFERENCE SCALE
1" = 1'-0"
0 1/4" 1/2" 1" 2"

1 FIRST FLOOR PLAN - OVERALL
3/32" = 1'-0"

9/8/2026 3:13:45 PM

FRAME TYPES DOOR TYPES

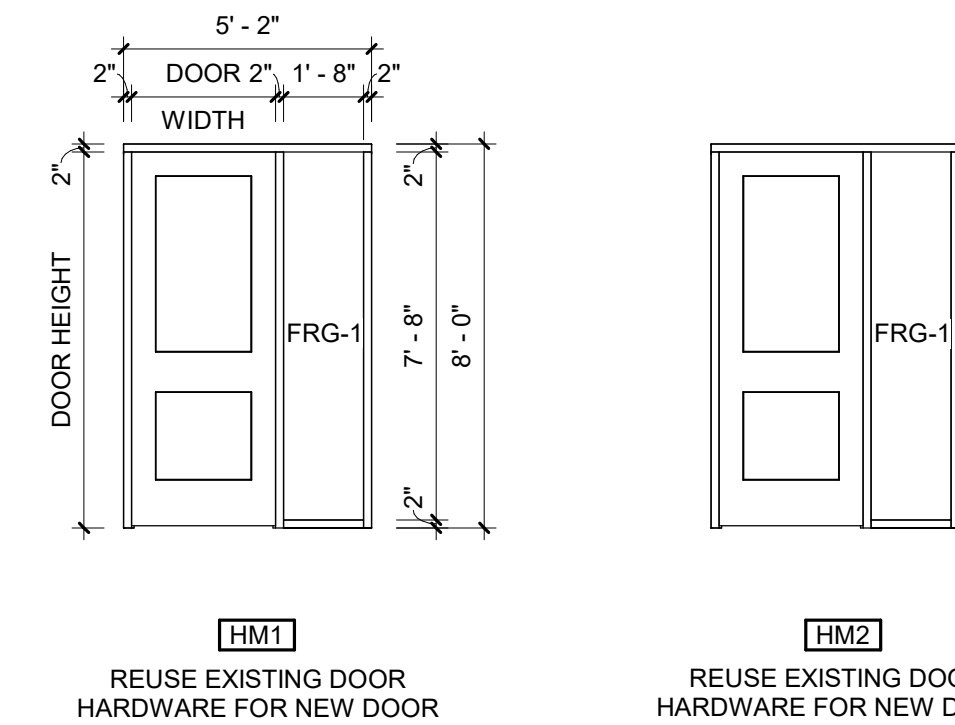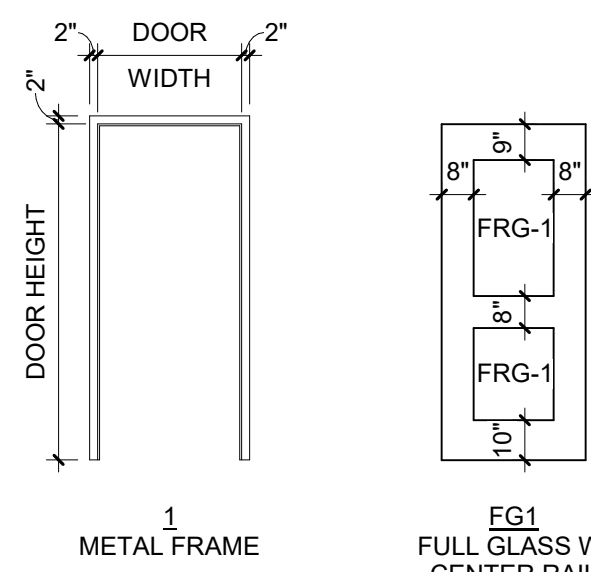


GLAZING SCHEDULE			
MARK	MATERIAL	THICKNESS	COMMENTS
OTHER			
FRG-1	FIRE RESISTANCE RATED GLAZING UNIT		

DOOR SCHEDULE										
MARK	ROOM NAME	WIDTH	HEIGHT	PANEL THICKNESS	DOOR TYPE	DOOR MATERIAL	FRAME TYPE	FRAME MATERIAL	FIRE RATING	HARDWARE GROUP
156A	ENTRY	3'-0"	7'-10"	0'-1 3/4"	FG1	HOLLOW METAL	1	HOLLOW METAL	60 MIN	
156B	ENTRY	3'-0"	7'-10"	0'-1 3/4"	FG1	HOLLOW METAL	1	HOLLOW METAL	60 MIN	

WALL LEGEND	
	EXISTING CONSTRUCTION TO REMAIN
	NEW CONSTRUCTION

FLOOR PLAN SHEET NOTES	
ALL WALL MOUNTED ITEMS TO SIT FLUSH ON A WALL SURFACE. IN INSTANCES WHERE A WALL MOUNTED ITEM IS TO BE INSTALLED ON TWO DIFFERENT FINISH THICKNESSES, PROVIDE A HARDBOARD BACKER FOR THE ITEM TO SIT FLUSH. PROVIDE SEALANT AROUND ALL EDGES OF BACKER AND PAINT TO MATCH ADJACENT SURFACE.	

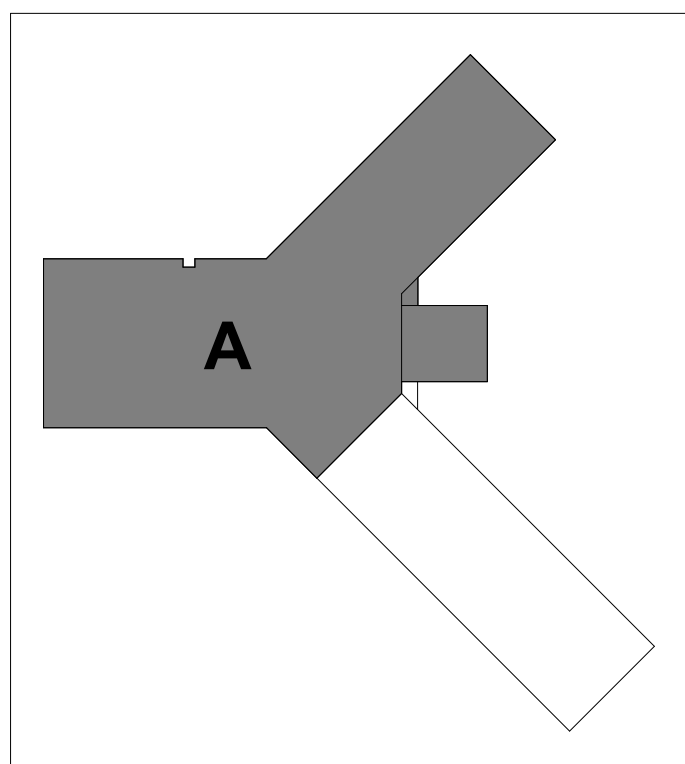

KEYPLAN

THIS DOCUMENT IS THE PROPERTY OF I & S GROUP, INC. AND MAY NOT BE USED, COPIED OR DUPLICATED WITHOUT PRIOR WRITTEN CONSENT.
© 2024 I & S GROUP, INC.

PROJECT

IOWA ARMY NATIONAL GUARD
S54 FINISH UPGRADES

CAMP DODGE, JOHNSTON IOWA

REVISION SCHEDULE		
DATE	DESCRIPTION	BY



PROJECT NO.	26-34920
FILE NAME	34920 Arch R26
DRAWN BY	MJT
DESIGNED BY	GMP
REVIEWED BY	GMP
ORIGINAL ISSUE DATE	09/08/26
CLIENT PROJECT NO.	19083733

TITLE

FIRST FLOOR
PLAN - AREA A &
DOOR SCHEDULE,
DOOR AND FRAME
TYPES

SHEET

 A1-21A

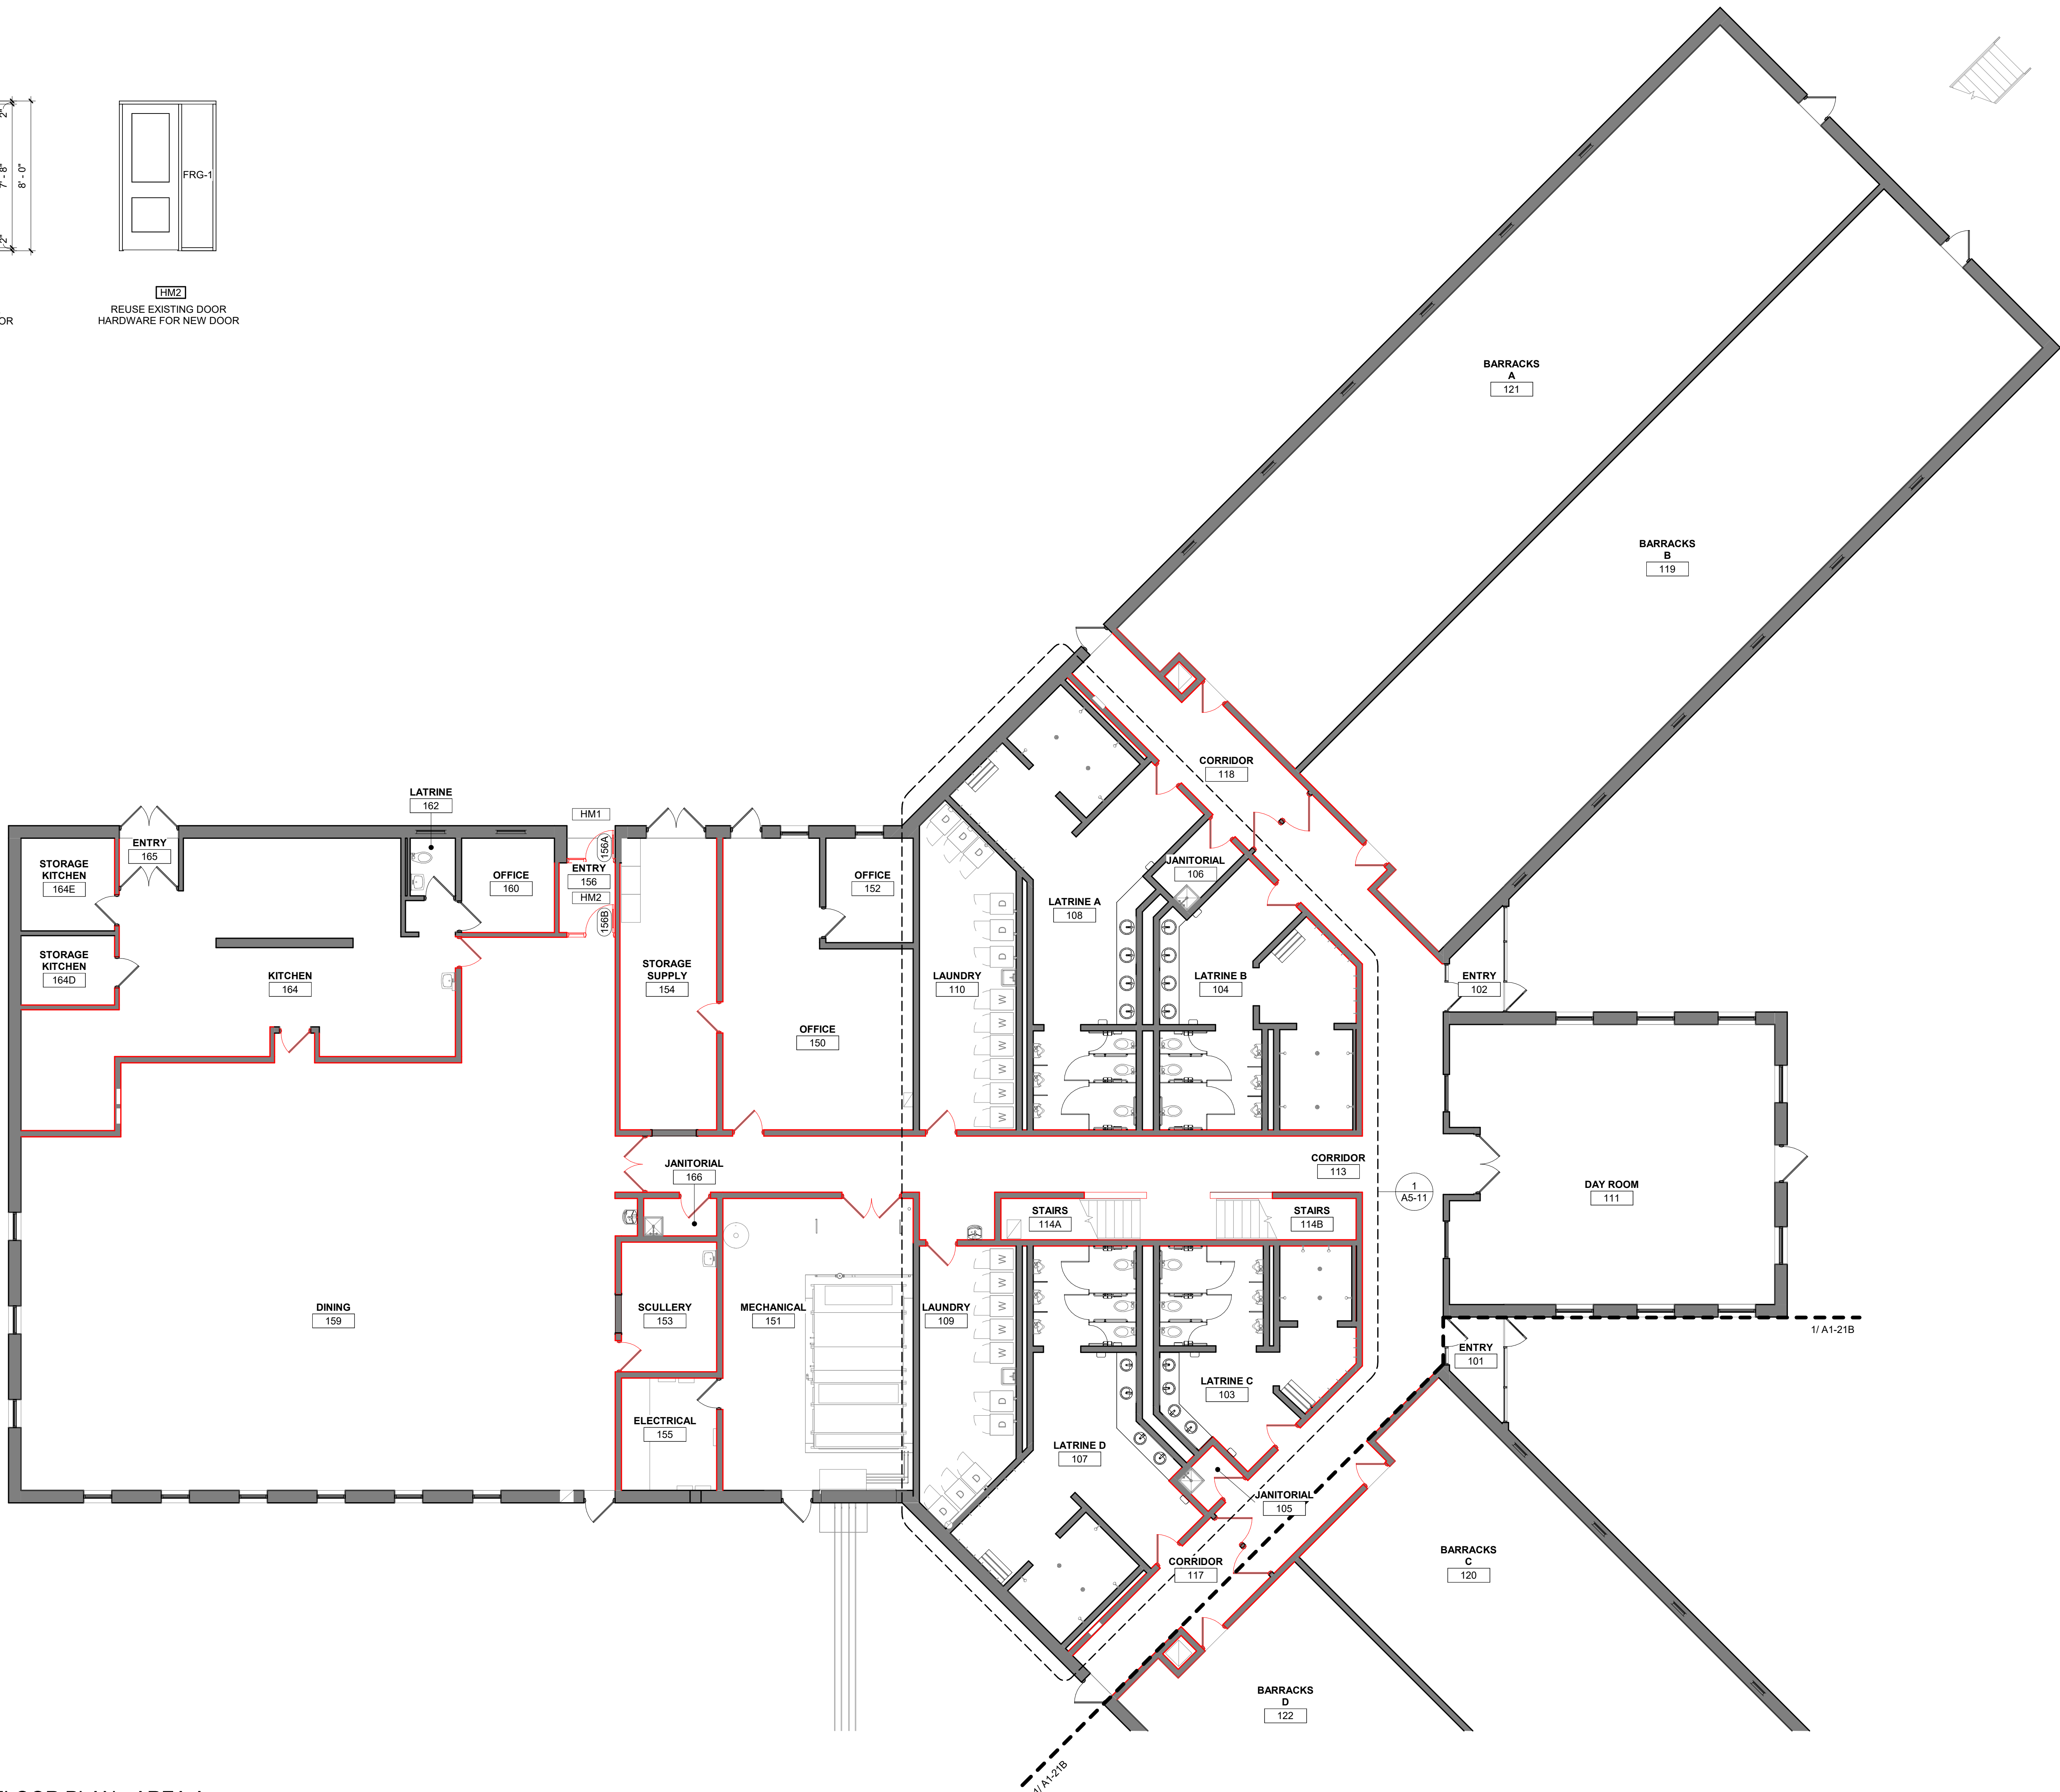

1 FIRST FLOOR PLAN - AREA A
1/8" = 1'-0"



FLOOR PLAN LEGEND

SHADED REGION INDICATES AREA OF PLANS THAT ARE NOT INCLUDED IN SCOPE OF WORK.


WALL LEGEND

EXISTING CONSTRUCTION TO REMAIN

NEW CONSTRUCTION

FLOOR PLAN SHEET NOTES

- ALL WALL MOUNTED ITEMS TO SIT FLUSH ON A WALL SURFACE. IN INSTANCES WHERE A WALL MOUNTED ITEM IS TO BE INSTALLED ON TWO DIFFERENT FINISH THICKNESSES, PROVIDE A HARDBOARD BACKER FOR THE ITEM TO SIT FLUSH. PROVIDE SEALANT AROUND ALL EDGES OF BACKER AND PAINT TO MATCH ADJACENT SURFACE.

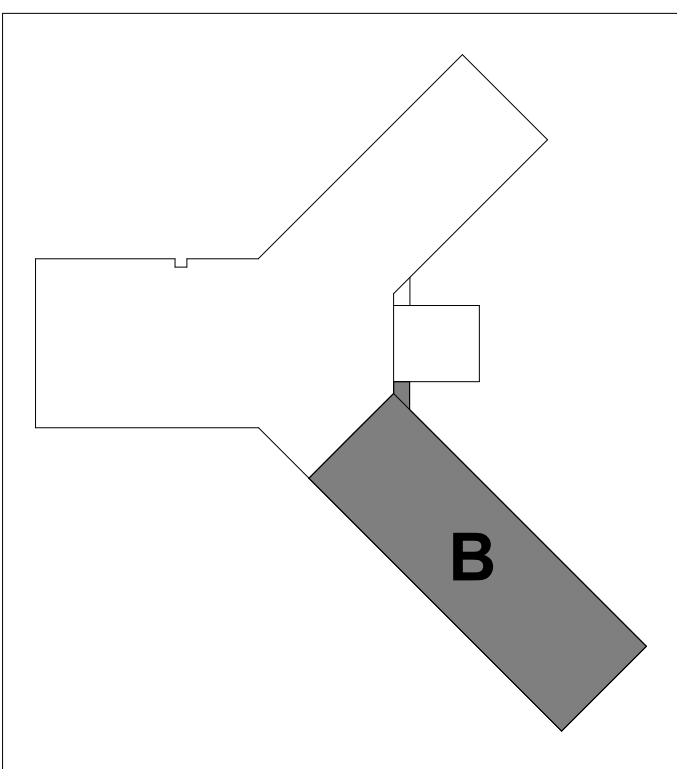

KEYPLAN

THIS DOCUMENT IS THE PROPERTY OF I & S GROUP, INC. AND MAY NOT BE USED, COPIED OR DUPLICATED WITHOUT PRIOR WRITTEN CONSENT.
© 2024 I & S GROUP, INC.

PROJECT

**IOWA ARMY
NATIONAL GUARD
S54 FINISH
UPGRADES**

CAMP DODGE, JOHNSTON IOWA

REVISION SCHEDULE		
DATE	DESCRIPTION	BY


PROJECT NO.	26-34920
FILE NAME	34920 Arch R26
DRAWN BY	MJT
DESIGNED BY	GMP
REVIEWED BY	GMP
ORIGINAL ISSUE DATE	09/08/26
CLIENT PROJECT NO.	19083733

TITLE

**FIRST AND
SECOND FLOOR
PLAN - AREA B**

SHEET

A1-21B

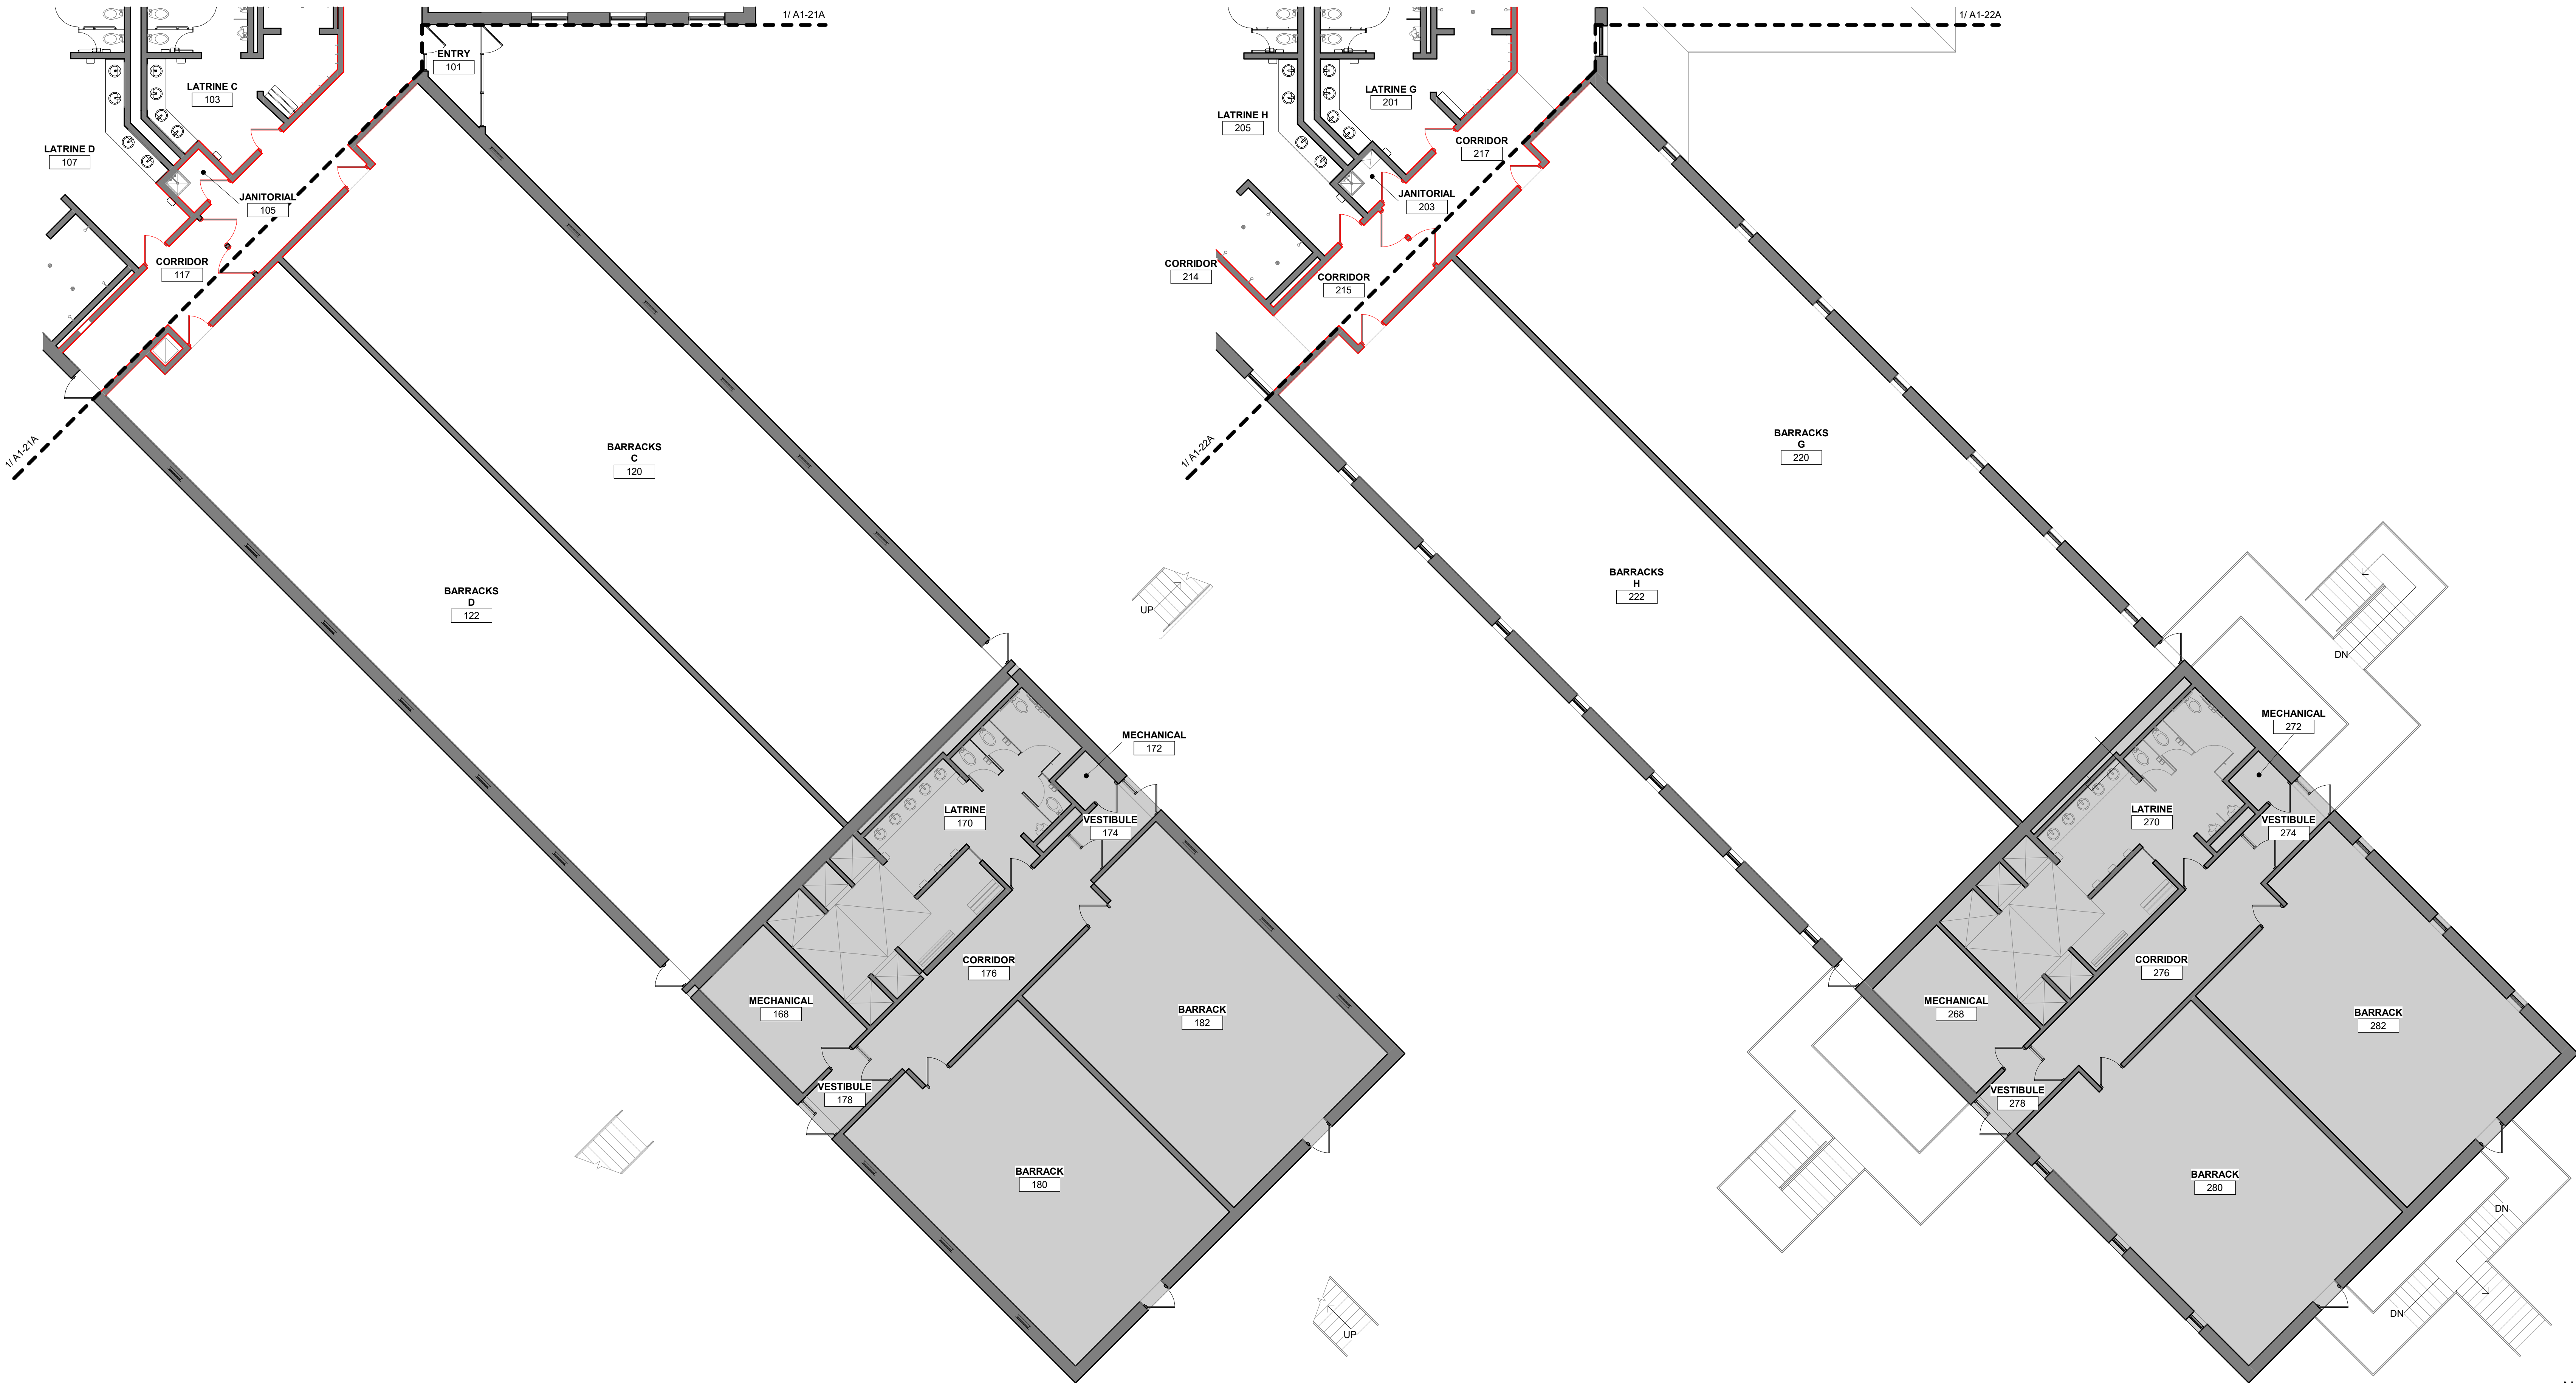

1 FIRST FLOOR PLAN - AREA B
1/8" = 1'-0"

2 SECOND FLOOR PLAN - AREA B
1/8" = 1'-0"

REFERENCE SCALE
1" = 1'-0"
0 1/4" 1/2" 1" 2"


REFERENCE SCALE
1" = 1'-0"
0 1/4" 1/2" 1" 2"

1 SECOND FLOOR PLAN - OVERALL
3/32" = 1'-0"

9/8/2026 3:14:02 PM

FLOOR PLAN LEGEND

SHADED REGION INDICATES AREA OF PLANS THAT ARE NOT INCLUDED IN SCOPE OF WORK.

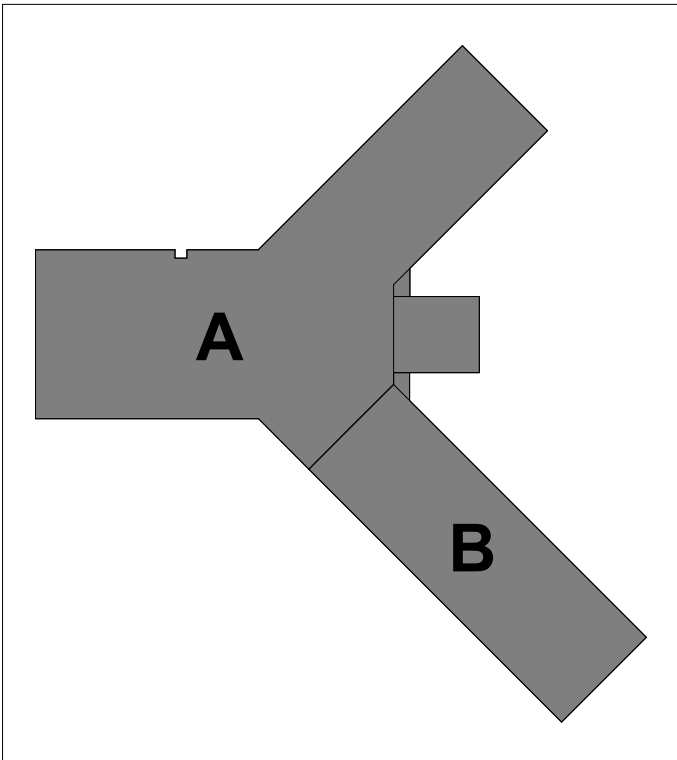

KEYPLAN

THIS DOCUMENT IS THE PROPERTY OF I & S GROUP, INC. AND MAY NOT BE USED, COPIED OR DUPLICATED WITHOUT PRIOR WRITTEN CONSENT.
© 2024 I & S GROUP, INC.

PROJECT

IOWA ARMY
NATIONAL GUARD
S54 FINISH
UPGRADES

CAMP DODGE, JOHNSTON IOWA

REVISION SCHEDULE		
DATE	DESCRIPTION	BY



PROJECT NO.	26-34920
FILE NAME	34920 Arch R26
DRAWN BY	MJT
DESIGNED BY	GMP
REVIEWED BY	GMP
ORIGINAL ISSUE DATE	09/08/26
CLIENT PROJECT NO.	19083733

TITLE

SECOND FLOOR
PLAN - OVERALL

SHEET

 A1-22

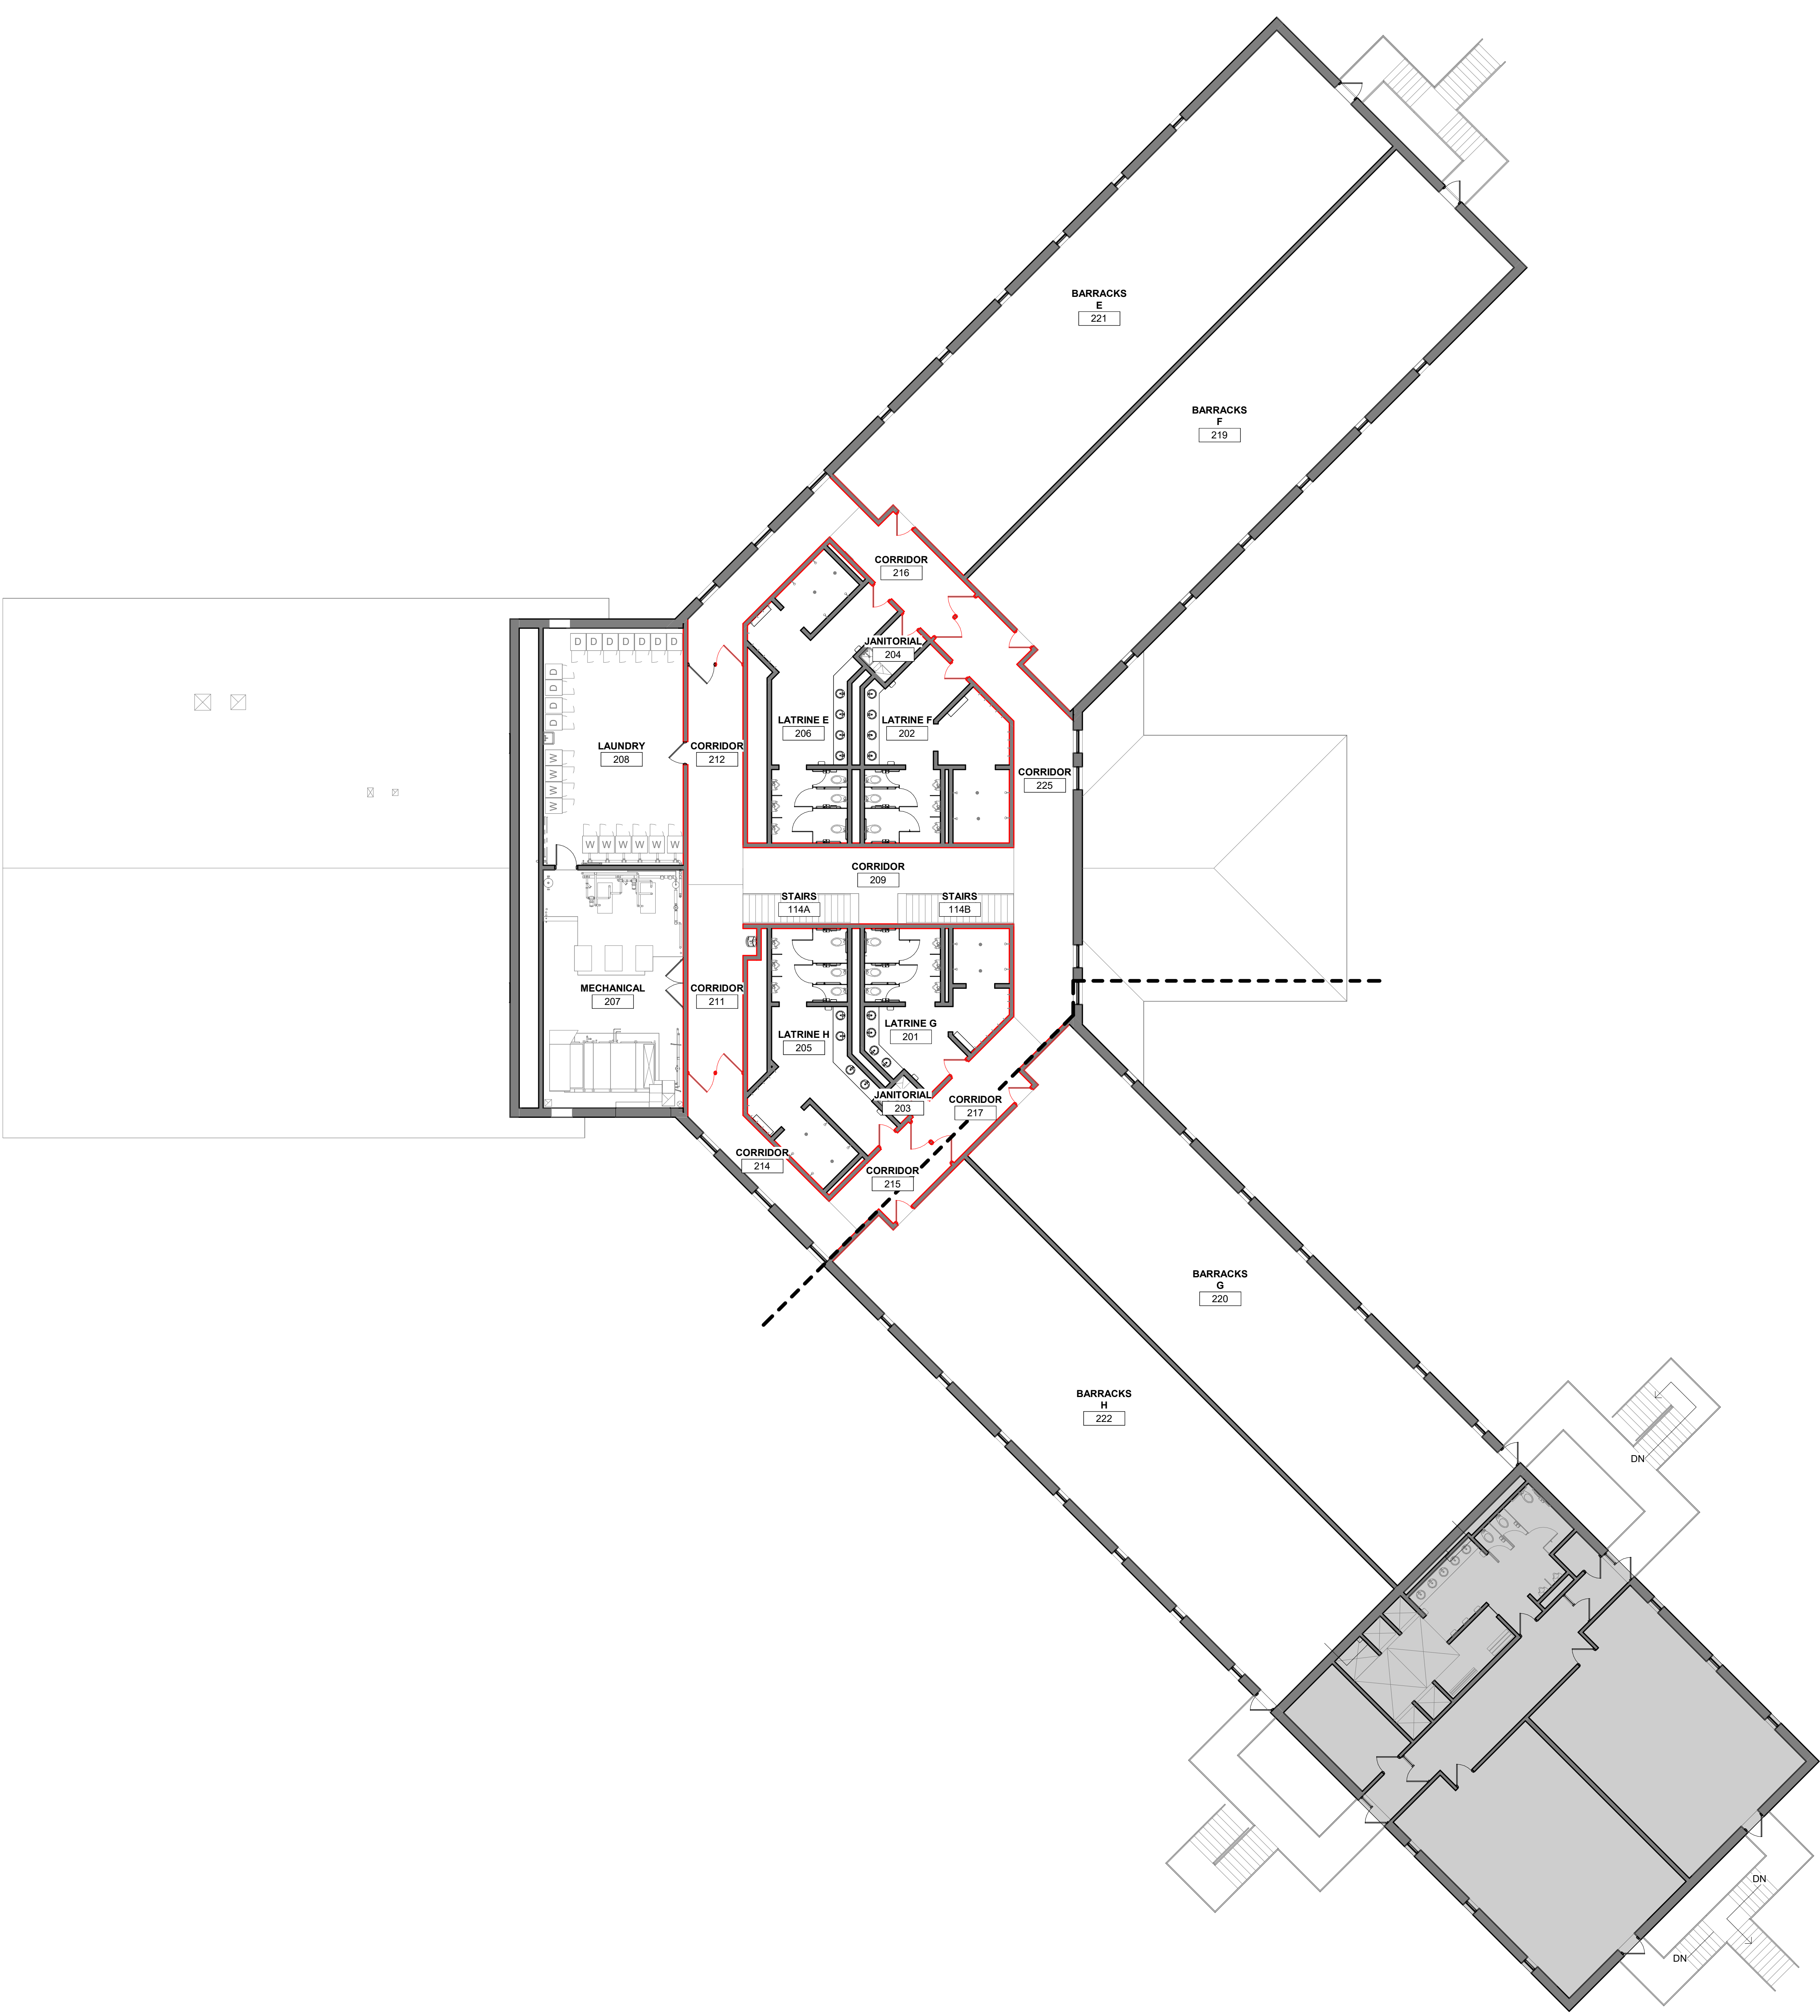


REFERENCE SCALE
1" = 1'-0"
0 1/4" 1/2" 1" 2"

1

SECOND FLOOR PLAN - AREA A
1/8" = 1'-0"

9/8/2026 3:14:04 PM

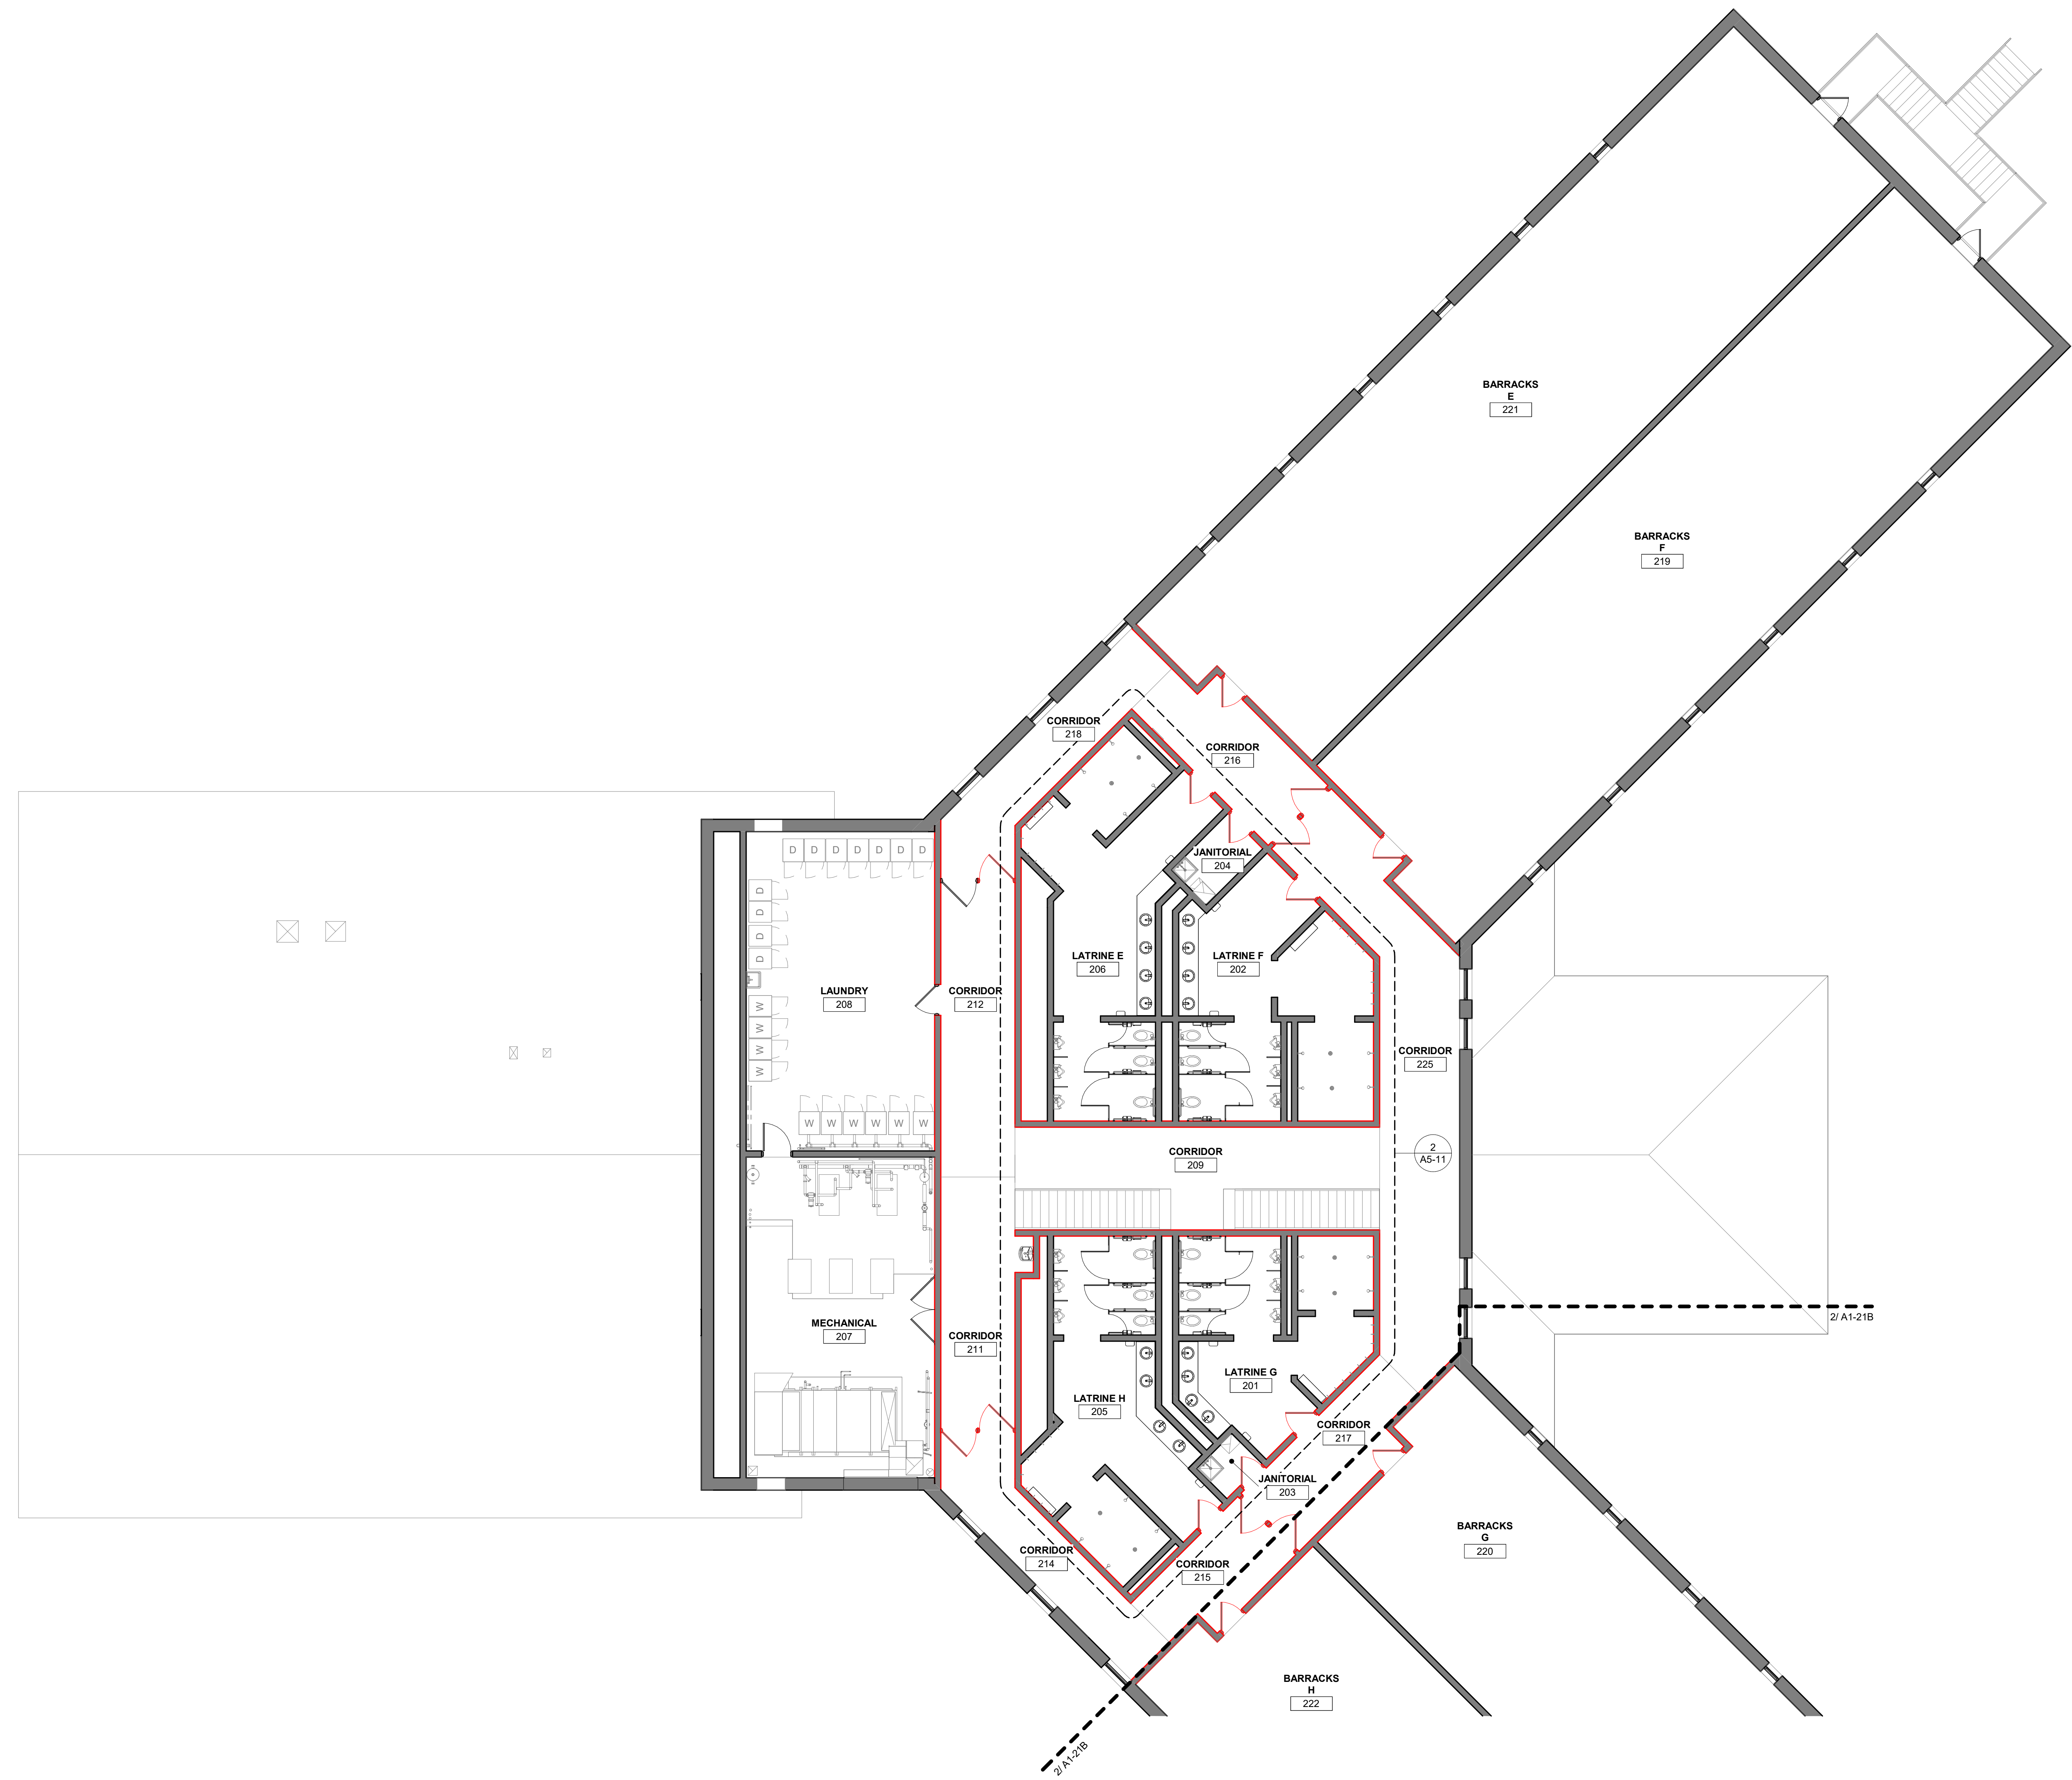

WALL LEGEND

- EXISTING CONSTRUCTION TO REMAIN
NEW CONSTRUCTION

FLOOR PLAN SHEET NOTES

- ALL WALL MOUNTED ITEMS TO SIT FLUSH ON A WALL SURFACE. IN INSTANCES WHERE A WALL MOUNTED ITEM IS TO BE INSTALLED ON TWO DIFFERENT FINISH THICKNESSES, PROVIDE A HARDBOARD BACKER FOR THE ITEM TO SIT FLUSH. PROVIDE SEALANT AROUND ALL EDGES OF BACKER AND PAINT TO MATCH ADJACENT SURFACE.

ISG

KEYPLAN

THIS DOCUMENT IS THE PROPERTY OF I & S GROUP, INC. AND MAY NOT BE USED, COPIED OR DUPLICATED WITHOUT PRIOR WRITTEN CONSENT.
© 2024 I & S GROUP, INC.

PROJECT

IOWA ARMY
NATIONAL GUARD
S54 FINISH
UPGRADES

CAMP DODGE, JOHNSTON IOWA

REVISION SCHEDULE

DATE	DESCRIPTION	BY

PROJECT NO.	26-34920
FILE NAME	34920 Arch R26
DRAWN BY	MJT
DESIGNED BY	GMP
REVIEWED BY	GMP
ORIGINAL ISSUE DATE	09/08/26
CLIENT PROJECT NO.	19083733


TITLE

SECOND FLOOR
PLAN - AREA A

SHEET


A1-22A

REFERENCE SCALE
1" = 1'-0"
0 1/4" 1/2" 1" 2"

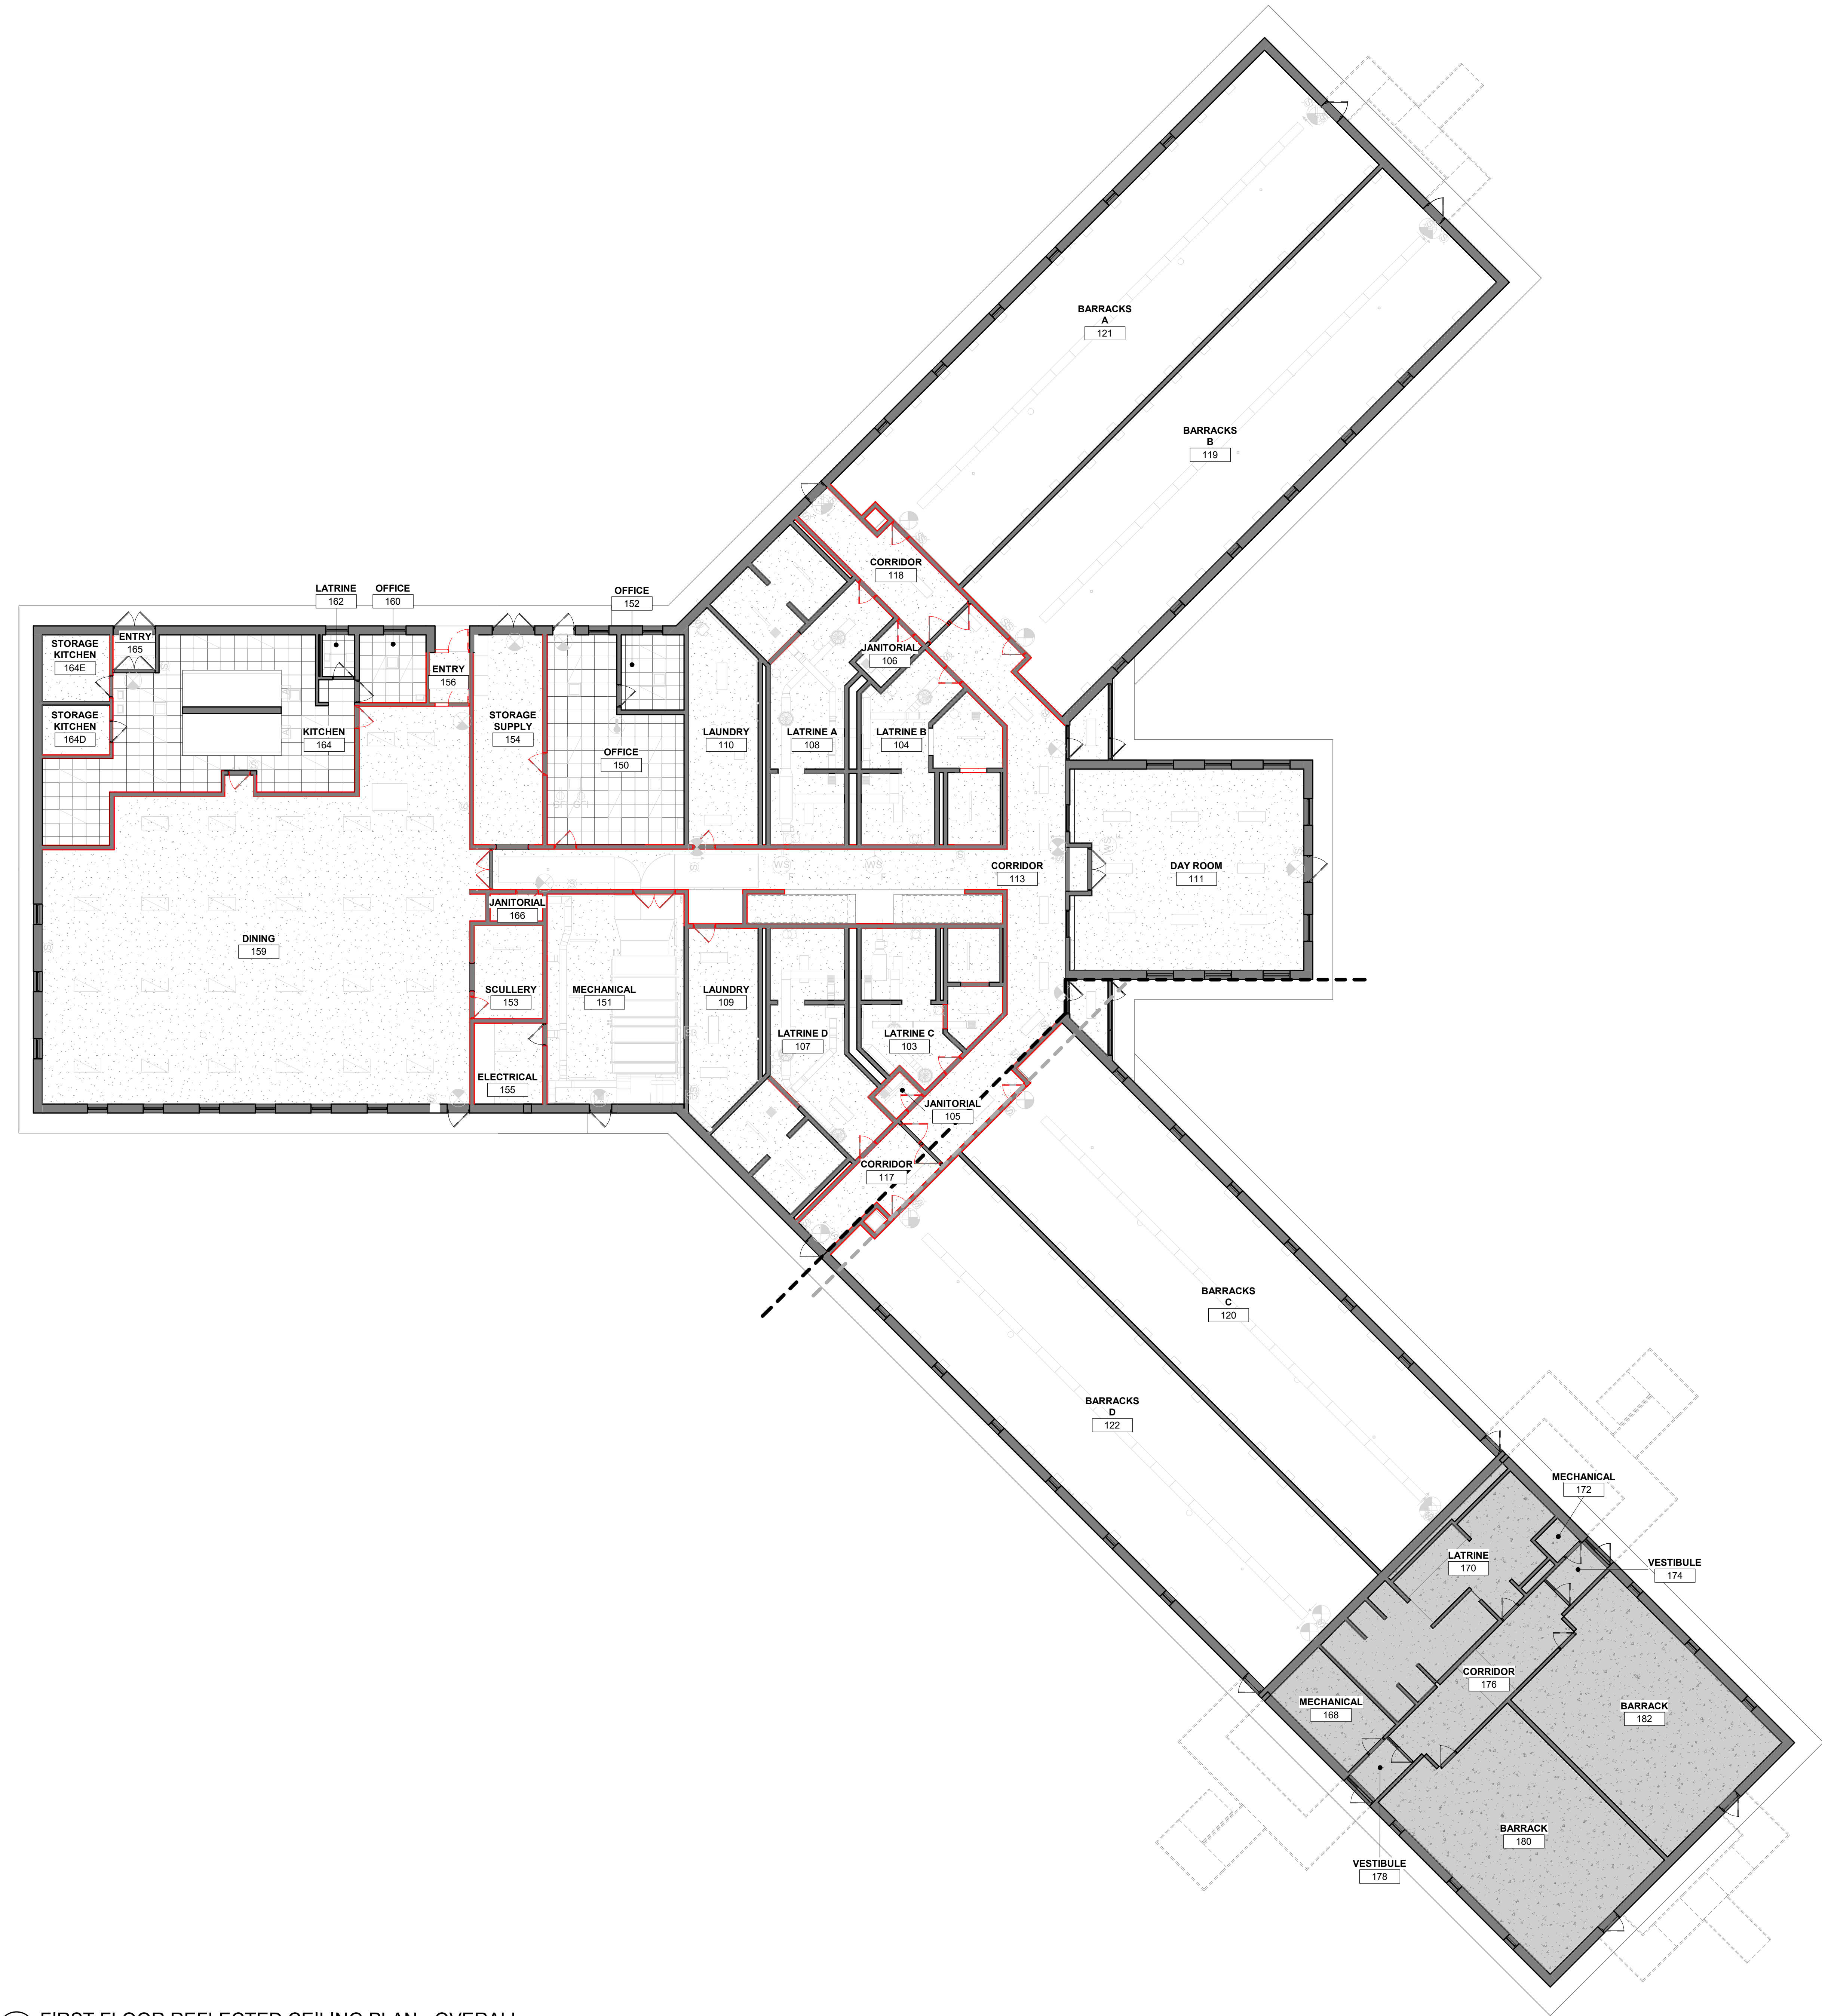

FLOOR PLAN LEGEND
SHADED REGION INDICATES AREA OF PLANS THAT ARE NOT INCLUDED IN SCOPE OF WORK.

- RCP SHEET NOTES**
- COORDINATE WITH MECHANICAL, PLUMBING, FIRE PROTECTION AND ELECTRICAL FOR EXACT LOCATIONS OF CEILING FIXTURES, DIFFUSERS, SPRINKLER HEADS, ETC.
 - REFER TO HVAC PLANS FOR THE LOCATION OF ANY AND ALL PLENUM CEILING SPACES. ALL WALLS AND SOFFITS CREATING THE PLENUM SHALL EXTEND TO THE UNDERSIDE OF STRUCTURE ABOVE AND BE SEALED.
 - BULKHEADS AND SOFFITS: ALL SIDES AND UNDERSIDES TO BE PAINTED AS INDICATED ON REFLECTED CEILING PLANS, UNLESS NOTED OTHERWISE.
 - EXISTING CEILINGS NOTED TO BE PAINTED INCLUDE PAINTING EXPOSED MECHANICAL DUCTWORK, ELECTRICAL CONDUIT, PIPING, ETC. PREP ANY MILDEWMOLD ON EQUIPMENT PRIOR TO PAINT FOR A THOROUGH ADHESION TO EXISTING CEILING/EQUIPMENT UNLESS NOTED OTHERWISE.
 - DO NOT PAINT EXISTING MECHANICAL, ELECTRICAL OR PLUMBING VALVES, SENSORS, RELAYS OR ACTUATORS THAT WILL NEED LOCATED, OPERATED OR SERVICED.

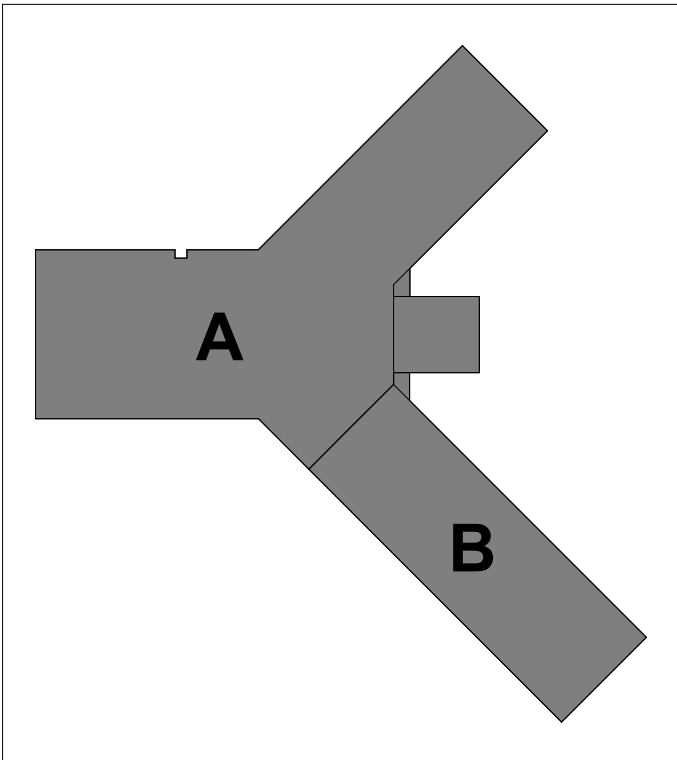

KEYPLAN

THIS DOCUMENT IS THE PROPERTY OF I & S GROUP, INC. AND MAY NOT BE USED, COPIED OR DUPLICATED WITHOUT PRIOR WRITTEN CONSENT.
© 2024 I & S GROUP, INC.

PROJECT

**IOWA ARMY
NATIONAL GUARD
S54 FINISH
UPGRADES**

CAMP DODGE, JOHNSTON IOWA

REVISION SCHEDULE		
DATE	DESCRIPTION	BY

PROJECT NO.	26-34920
FILE NAME	34920 Arch R26
DRAWN BY	MJT
DESIGNED BY	GMP
REVIEWED BY	GMP
ORIGINAL ISSUE DATE	09/08/26
CLIENT PROJECT NO.	19083733

TITLE

**FIRST FLOOR
REFLECTED
CEILING PLAN -
OVERALL**

SHEET

A1-31

1 FIRST FLOOR REFLECTED CEILING PLAN - OVERALL
3/32" = 1'-0"

9/8/2026 3:14:09 PM

RCP SHEET NOTES

- COORDINATE WITH MECHANICAL, PLUMBING, FIRE PROTECTION AND ELECTRICAL FOR EXACT LOCATIONS OF CEILING FIXTURES, DIFFUSERS, SPRINKLER HEADS, ETC.
- REFER TO HVAC PLANS FOR THE LOCATION OF ANY AND ALL PLENUM CEILING SPACES. ALL WALLS AND SOFFITS CREATING THE PLENUM SHALL EXTEND TO THE UNDERSIDE OF STRUCTURE ABOVE AND BE SEALED.
- BULKHEADS AND SOFFITS: ALL SIDES AND UNDERSIDES TO BE PAINTED AS INDICATED ON REFLECTED CEILING PLANS, UNLESS NOTED OTHERWISE.
- EXISTING CEILINGS NOTED TO BE PAINTED INCLUDE PAINTING EXPOSED MECHANICAL DUCTWORK, ELECTRICAL CONDUIT, PIPING, ETC. PREP ANY MILDEWMOLD ON EQUIPMENT PRIOR TO PAINT FOR A THOROUGH ADHESION TO EXISTING CEILING/EQUIPMENT UNLESS NOTED OTHERWISE.
- DO NOT PAINT EXISTING MECHANICAL, ELECTRICAL OR PLUMBING VALVES, SENSORS, RELAYS OR ACTUATORS THAT WILL NEED LOCATED, OPERATED OR SERVICED.

KEYNOTE LEGEND

- 13 REINSTALL EXISTING WINDOW TREATMENTS.
- 15 PAINT ALL EXPOSED DUCTWORK, CONDUIT, ELECTRICAL EQUIPMENT, GRILLES, VENTS, METAL ACCESS PANELS, ETC. TO MATCH ADJACENT SURFACES. ALL VALVES, SENSORS, RELAYS, AND ACTUATORS TO REMAIN UNPAINTED.
- 17 EXISTING CEILING TO REMAIN. DO NOT PAINT CEILING. NO ADDITIONAL WORK REQUIRED.

A

KEYPLAN

THIS DOCUMENT IS THE PROPERTY OF I & S GROUP, INC. AND MAY NOT BE USED, COPIED OR DUPLICATED WITHOUT PRIOR WRITTEN CONSENT.
© 2024 I & S GROUP, INC.

PROJECT

IOWA ARMY NATIONAL GUARD S54 FINISH UPGRADES

CAMP DODGE, JOHNSTON IOWA

REVISION SCHEDULE

DATE	DESCRIPTION	BY

PROJECT NO. 26-34920
FILE NAME 34920 Arch R26
DRAWN BY MJT
DESIGNED BY GMP
REVIEWED BY GMP
ORIGINAL ISSUE DATE 09/08/26
CLIENT PROJECT NO. 19083733

TITLE


FIRST FLOOR REFLECTED CEILING PLAN - AREA A AND CEILING DETAILS

SHEET

A1-31A

1 CEILING TRANSITION AT EXISTING KITCHEN HOOD
1 1/2" = 1'-0"

2 CEILING EDGE AT EXISTING KITCHEN HOOD
1 1/2" = 1'-0"

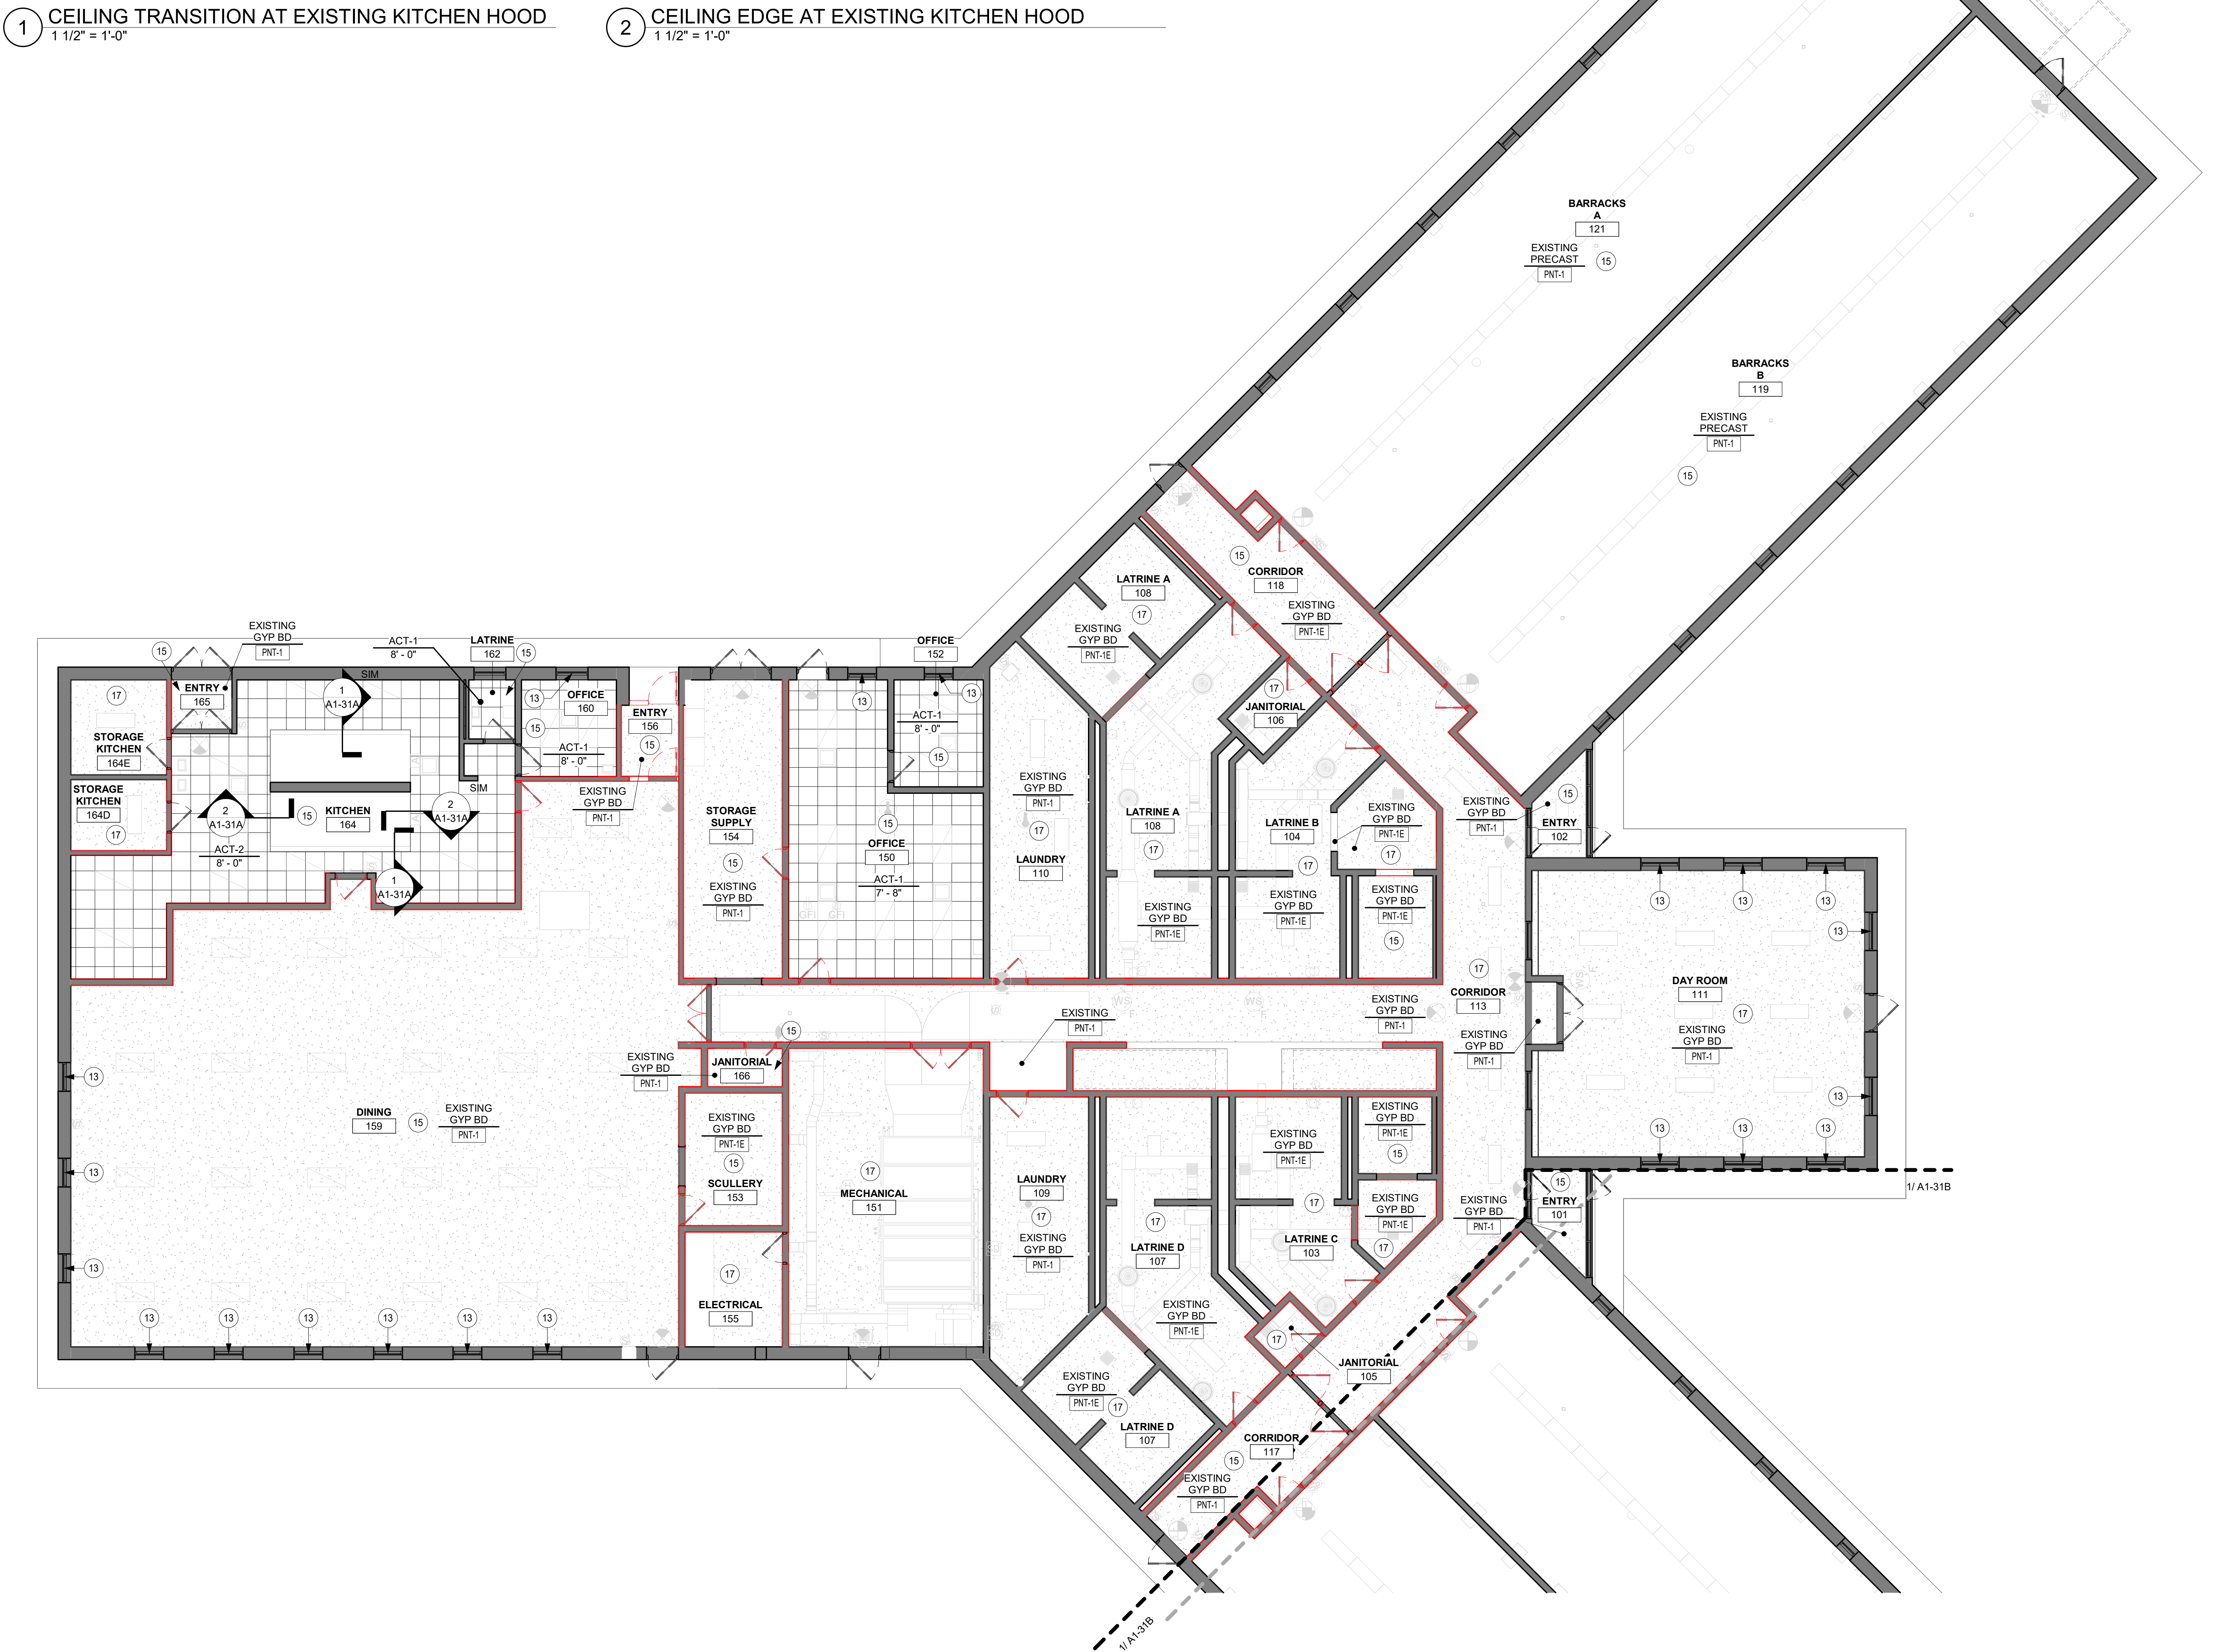

3 FIRST FLOOR REFLECTED CEILING PLAN - AREA A
1/8" = 1'-0"



FLOOR PLAN LEGEND

SHADED REGION INDICATES AREA OF PLANS THAT ARE NOT INCLUDED IN SCOPE OF WORK.

RCP SHEET NOTES


- COORDINATE WITH MECHANICAL, PLUMBING, FIRE PROTECTION AND ELECTRICAL FOR EXACT LOCATIONS OF CEILING FIXTURES, DIFFUSERS, SPRINKLER HEADS, ETC.
- REFER TO HVAC PLANS FOR THE LOCATION OF ANY AND ALL PLENUM CEILING SPACES. ALL WALLS AND SOFFITS CREATING THE PLENUM SHALL EXTEND TO THE UNDERSIDE OF STRUCTURE ABOVE AND BE SEALED.
- BULKHEADS AND SOFFITS: ALL SIDES AND UNDERSIDES TO BE PAINTED AS INDICATED ON REFLECTED CEILING PLANS, UNLESS NOTED OTHERWISE.
- EXISTING CEILINGS NOTED TO BE PAINTED INCLUDE PAINTING EXPOSED MECHANICAL DUCTWORK, ELECTRICAL CONDUIT, PIPING, ETC. PREP ANY MILDEWMOLD ON EQUIPMENT PRIOR TO PAINT FOR A THOROUGH ADHESION TO EXISTING CEILING/EQUIPMENT UNLESS NOTED OTHERWISE.
- DO NOT PAINT EXISTING MECHANICAL, ELECTRICAL OR PLUMBING VALVES, SENSORS, RELAYS OR ACTUATORS THAT WILL NEED LOCATED, OPERATED OR SERVICED.

KEYNOTE LEGEND

13 REINSTALL EXISTING WINDOW TREATMENTS.

15 PAINT ALL EXPOSED DUCTWORK, CONDUIT, ELECTRICAL EQUIPMENT, GRILLES, VENTS, METAL ACCESS PANELS, ETC. TO MATCH ADJACENT SURFACES. ALL VALVES, SENSORS, RELAYS, AND ACTUATORS TO REMAIN UNPAINTED.

17 EXISTING CEILING TO REMAIN. DO NOT PAINT CEILING. NO ADDITIONAL WORK REQUIRED.

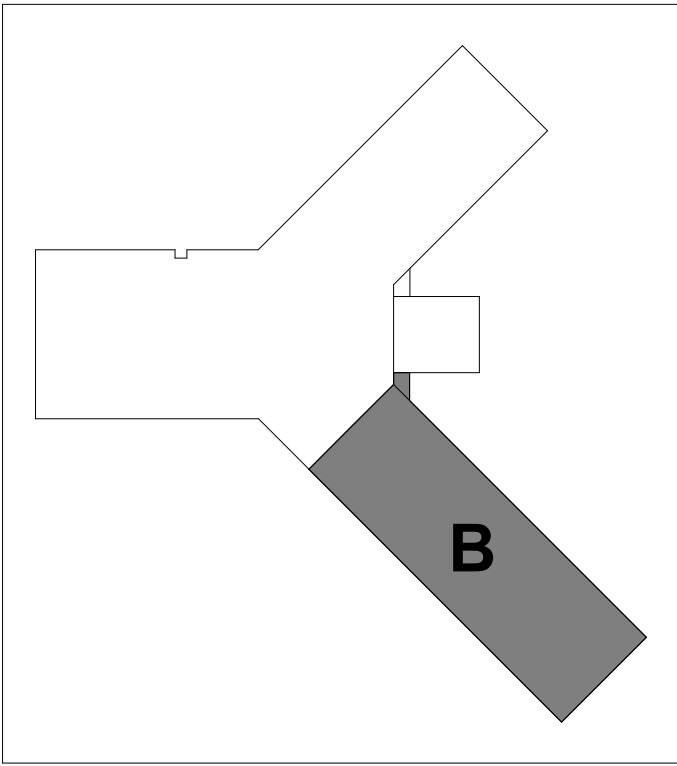

KEYPLAN

THIS DOCUMENT IS THE PROPERTY OF I & S GROUP, INC. AND MAY NOT BE USED, COPIED OR DUPLICATED WITHOUT PRIOR WRITTEN CONSENT.
© 2024 I & S GROUP, INC.

PROJECT

**IOWA ARMY
NATIONAL GUARD
S54 FINISH
UPGRADES**

CAMP DODGE, JOHNSTON IOWA

REVISION SCHEDULE		
DATE	DESCRIPTION	BY


PROJECT NO.	26-34920
FILE NAME	34920 Arch R26
DRAWN BY	MJT
DESIGNED BY	GMP
REVIEWED BY	GMP
ORIGINAL ISSUE DATE	09/08/26
CLIENT PROJECT NO.	19083733

TITLE

**FIRST AND
SECOND FLOOR
REFLECTED
CEILING PLANS -
AREA B**

SHEET


A1-31B

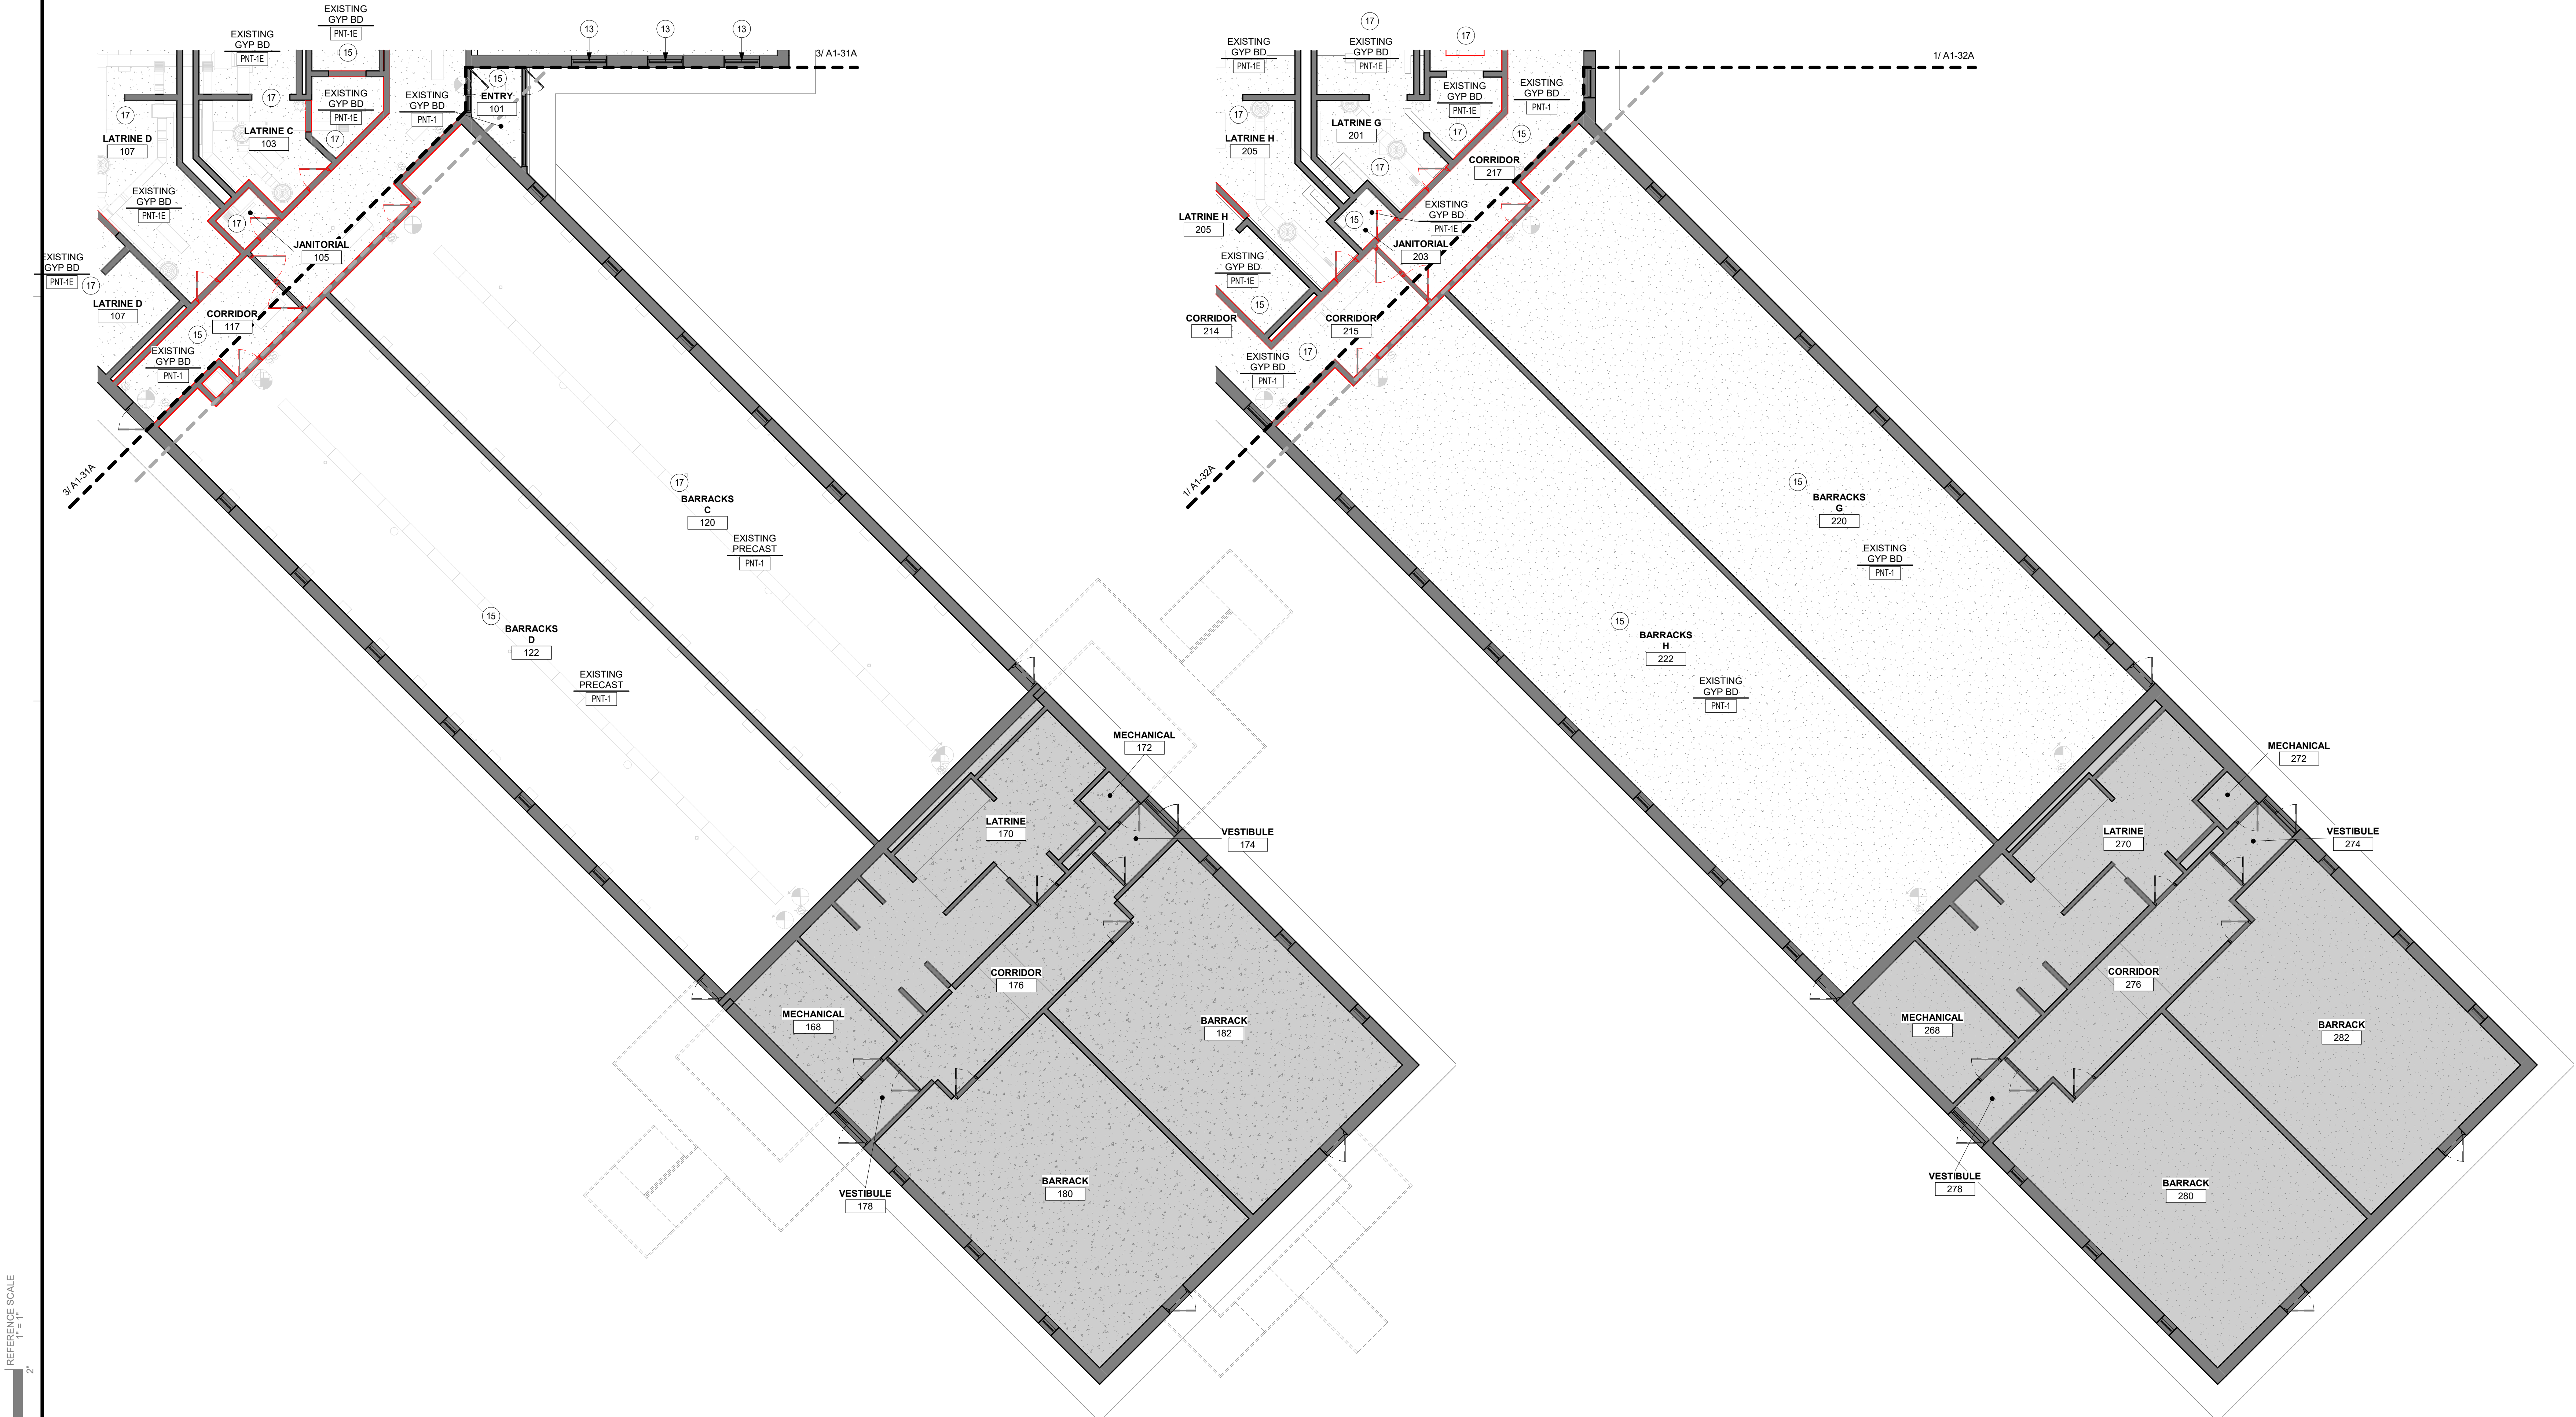

1 FIRST FLOOR REFLECTED CEILING PLAN - AREA B
1/8" = 1'-0"

2 SECOND FLOOR REFLECTED CEILING PLAN - AREA B
1/8" = 1'-0"


REFERENCE SCALE
1" = 1'-0"
0 1/4" 1/2" 1" 2"

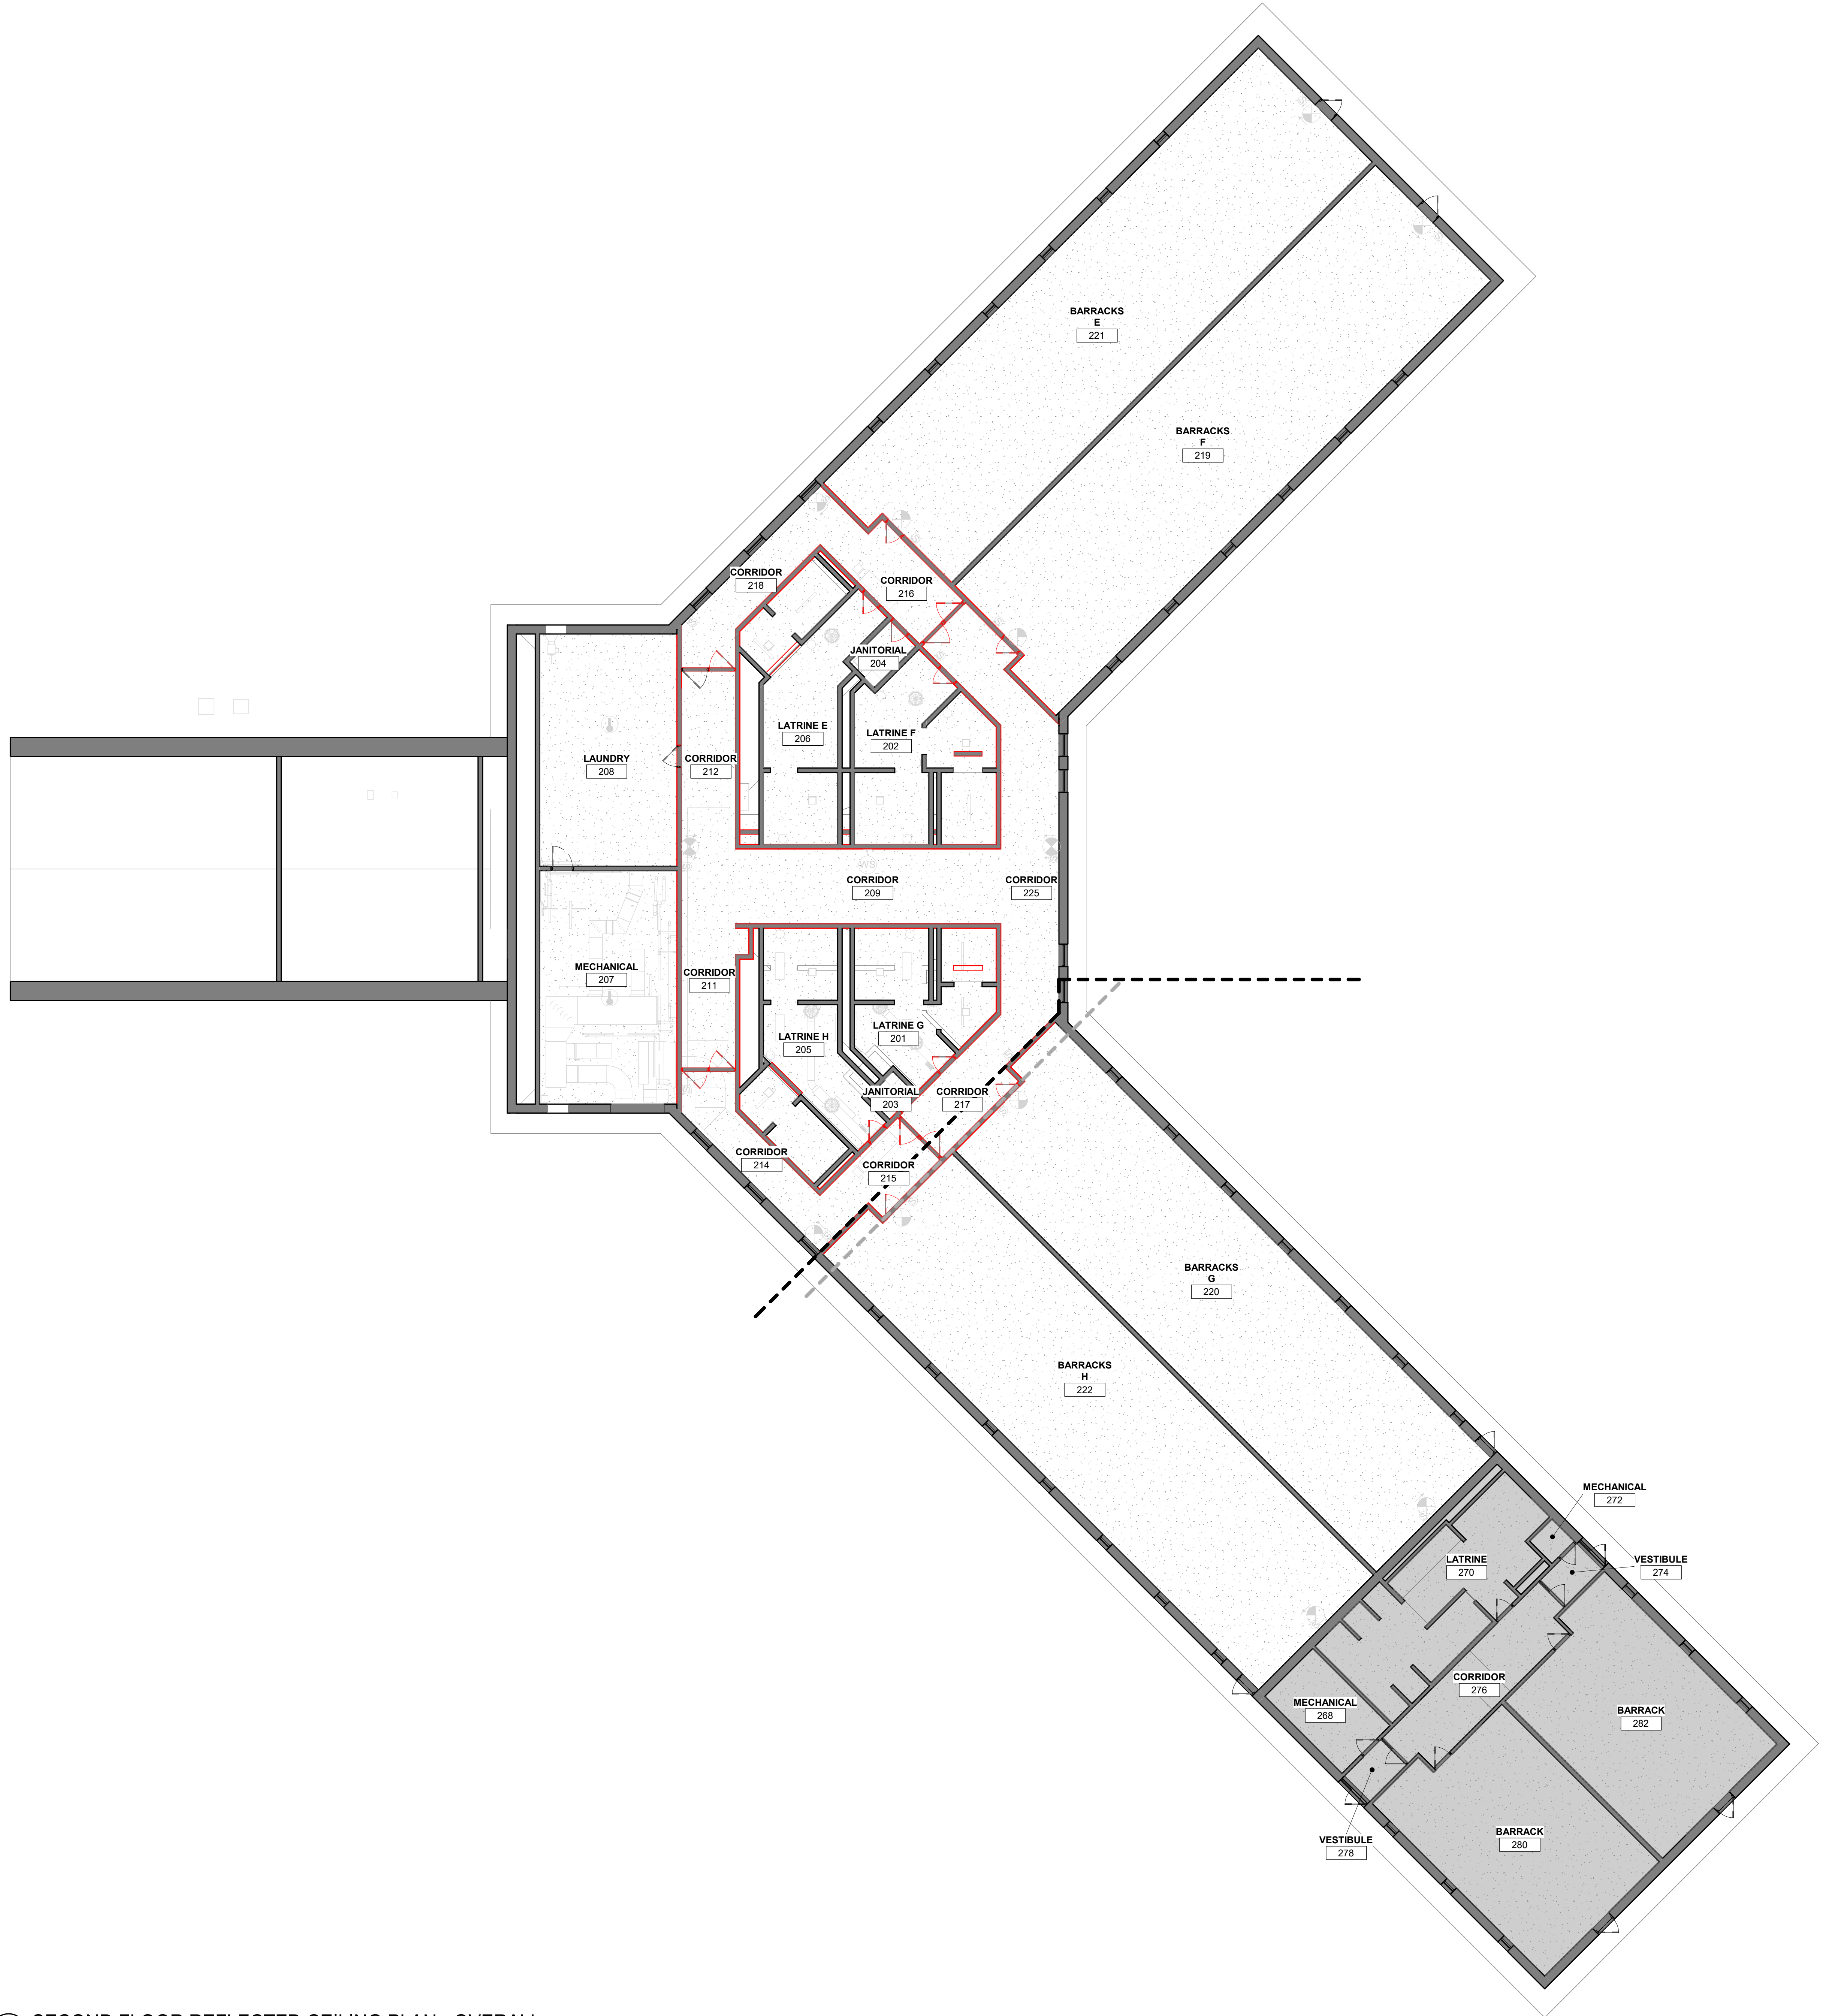

FLOOR PLAN LEGEND

SHADED REGION INDICATES AREA OF PLANS THAT ARE NOT INCLUDED IN SCOPE OF WORK.

- RCP SHEET NOTES**
- COORDINATE WITH MECHANICAL, PLUMBING, FIRE PROTECTION AND ELECTRICAL FOR EXACT LOCATIONS OF CEILING FIXTURES, DIFFUSERS, SPRINKLER HEADS, ETC.
 - REFER TO HVAC PLANS FOR THE LOCATION OF ANY AND ALL PLENUM CEILING SPACES. ALL WALLS AND SOFFITS CREATING THE PLENUM SHALL EXTEND TO THE UNDERSIDE OF STRUCTURE ABOVE AND BE SEALED.
 - BULKHEADS AND SOFFITS: ALL SIDES AND UNDERSIDES TO BE PAINTED AS INDICATED ON REFLECTED CEILING PLANS, UNLESS NOTED OTHERWISE.
 - EXISTING CEILINGS NOTED TO BE PAINTED INCLUDE PAINTING EXPOSED MECHANICAL DUCTWORK, ELECTRICAL CONDUIT, PIPING, ETC. PREP ANY MILDEWMOLD ON EQUIPMENT PRIOR TO PAINT FOR A THOROUGH ADHESION TO EXISTING CEILING/EQUIPMENT UNLESS NOTED OTHERWISE.
 - DO NOT PAINT EXISTING MECHANICAL, ELECTRICAL OR PLUMBING VALVES, SENSORS, RELAYS OR ACTUATORS THAT WILL NEED LOCATED, OPERATED OR SERVICED.

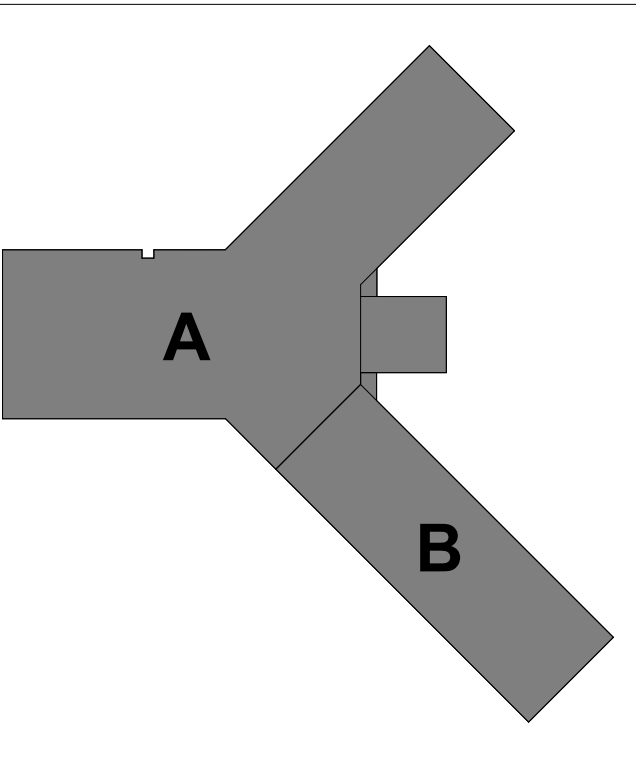

KEYPLAN

THIS DOCUMENT IS THE PROPERTY OF I & S GROUP, INC. AND MAY NOT BE USED, COPIED OR DUPLICATED WITHOUT PRIOR WRITTEN CONSENT.
© 2024 I & S GROUP, INC.

PROJECT

**IOWA ARMY
NATIONAL GUARD
S54 FINISH
UPGRADES**

CAMP DODGE, JOHNSTON IOWA

REVISION SCHEDULE		
DATE	DESCRIPTION	BY

PROJECT NO.	26-34920
FILE NAME	34920 Arch R26
DRAWN BY	MJT
DESIGNED BY	GMP
REVIEWED BY	GMP
ORIGINAL ISSUE DATE	09/08/26
CLIENT PROJECT NO.	19083733

TITLE

**SECOND FLOOR
REFLECTED
CEILING PLAN -
OVERALL**

SHEET


A1-32

REFERENCE SCALE
1" = 1'-0"
0 1/4" 1/2" 1" 2"

1 SECOND FLOOR REFLECTED CEILING PLAN - OVERALL
3/32" = 1'-0"

9/8/2026 3:14:30 PM

REFERENCE SCALE
0 1/4" 1/2" 1" 2"

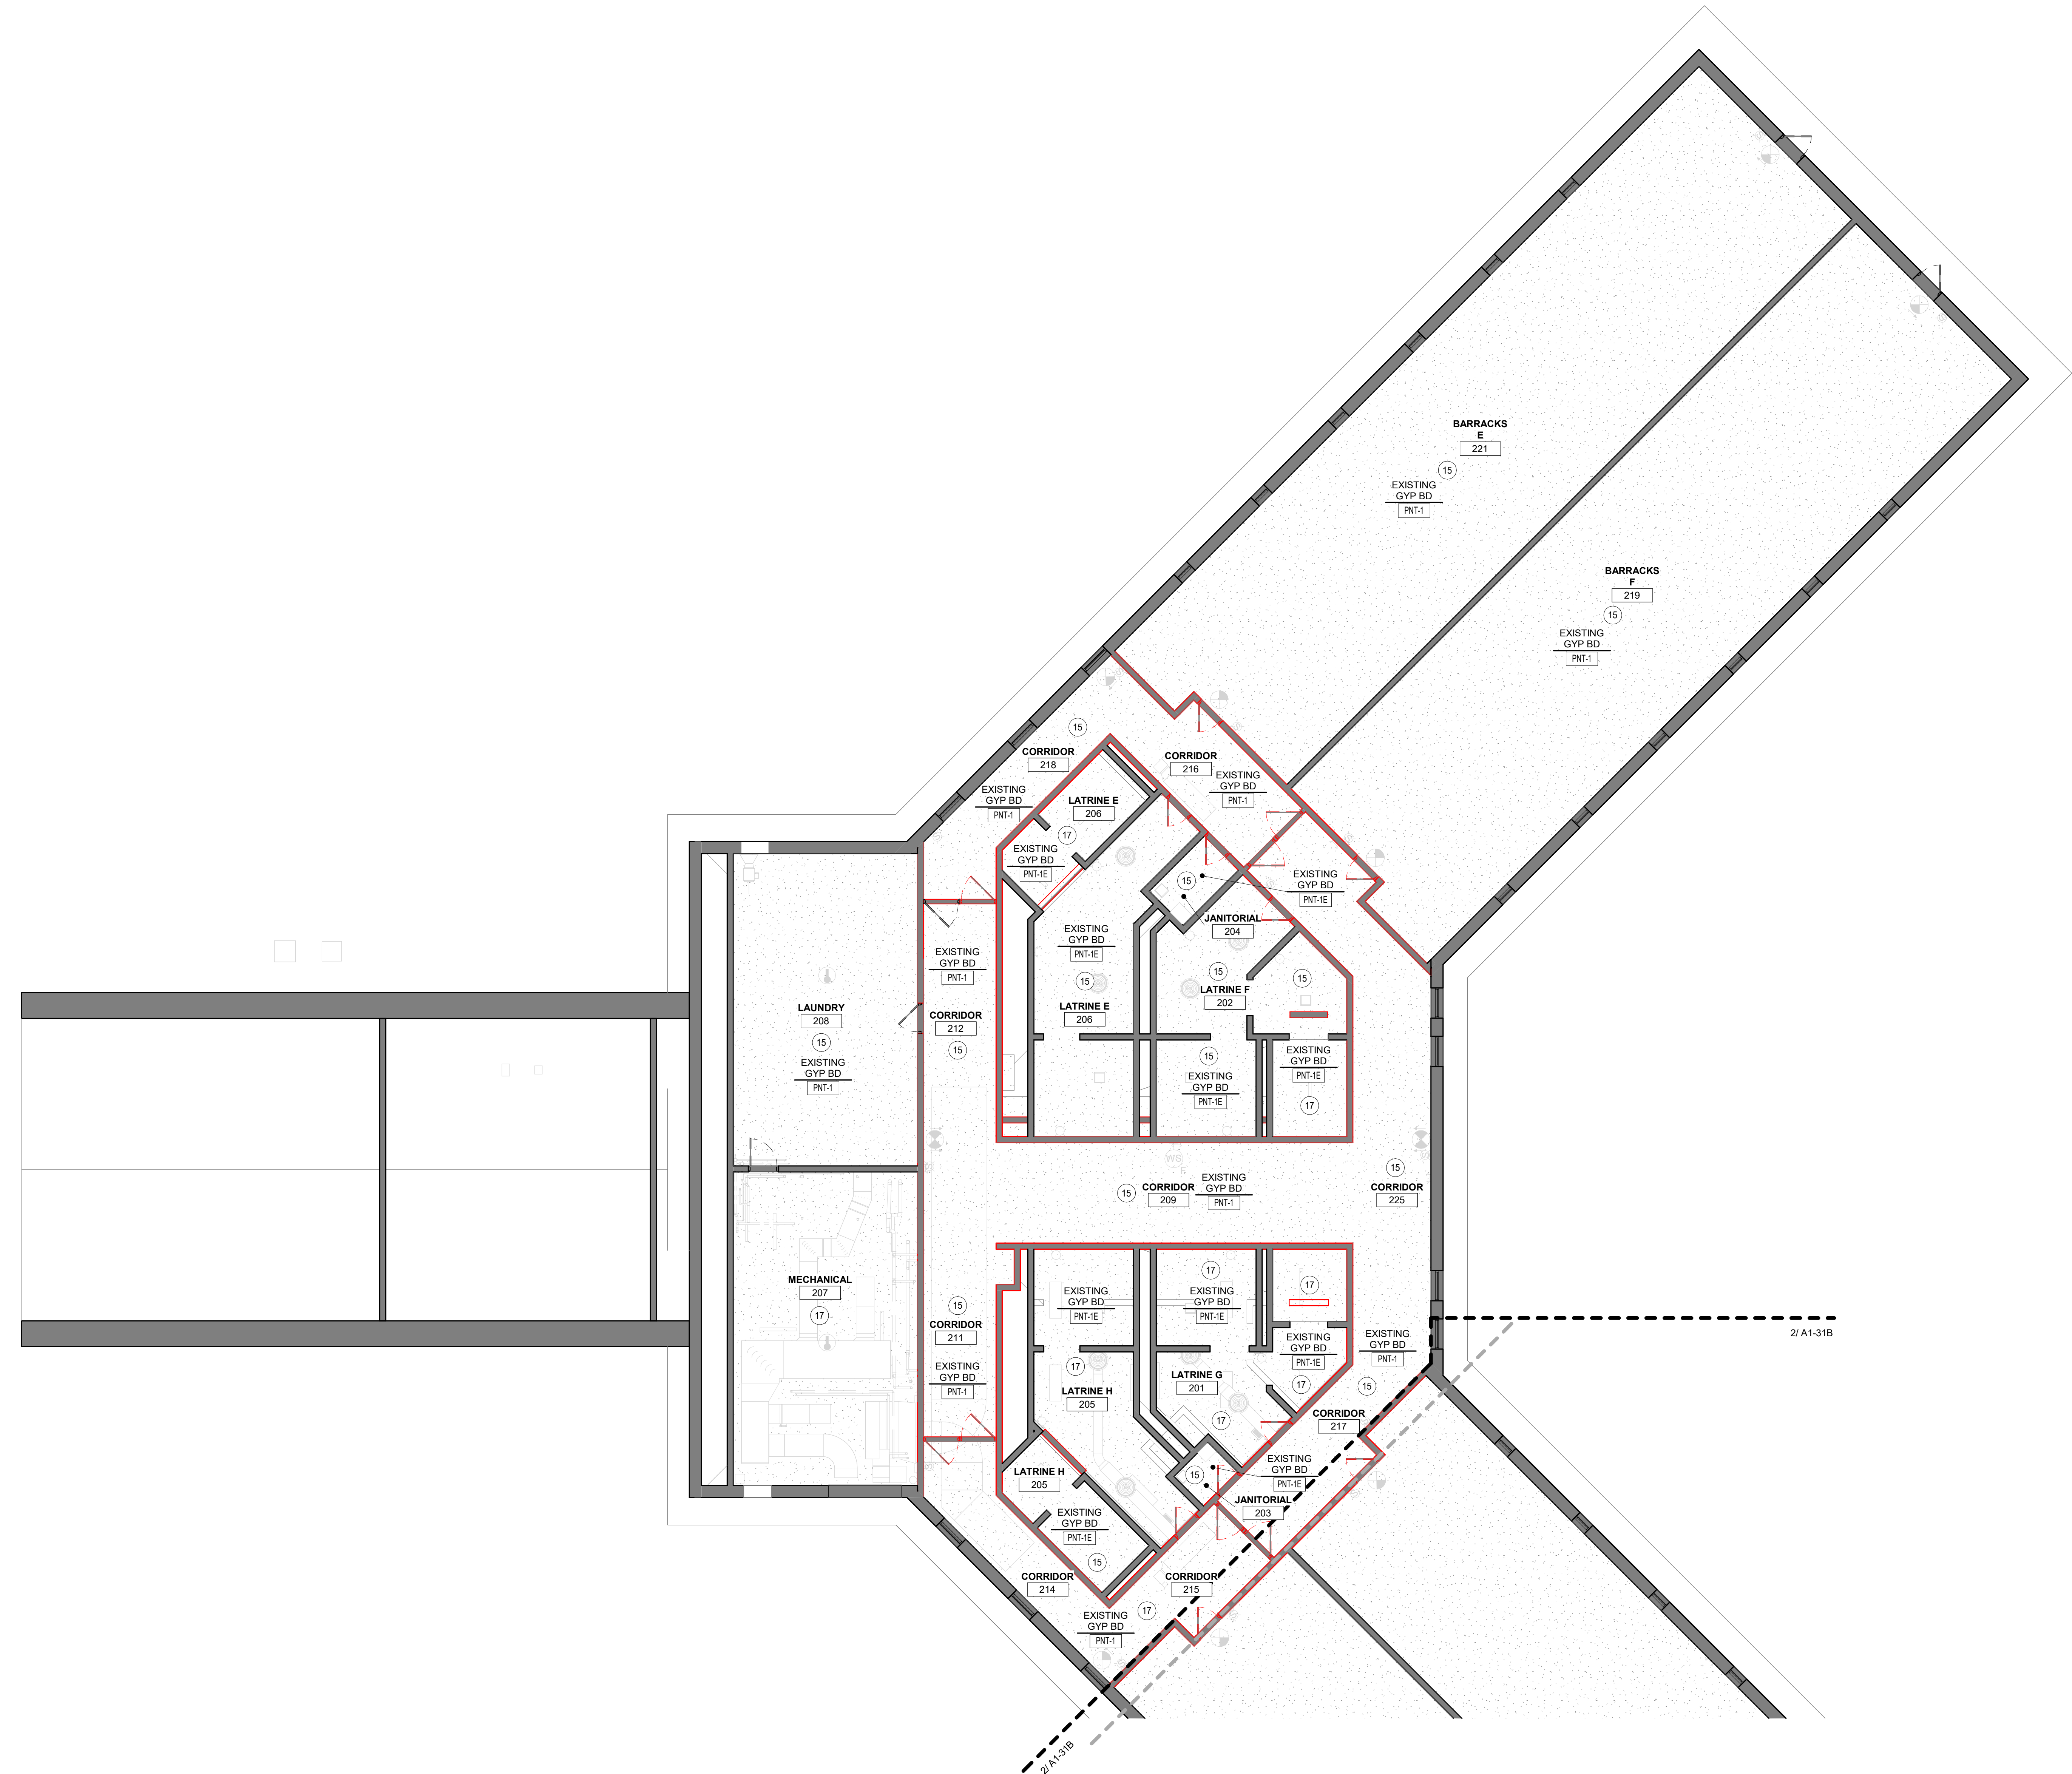

1 SECOND FLOOR REFLECTED CEILING PLAN - AREA A
1/8" = 1'-0"


RCP SHEET NOTES

- COORDINATE WITH MECHANICAL, PLUMBING, FIRE PROTECTION AND ELECTRICAL FOR EXACT LOCATIONS OF CEILING FIXTURES, DIFFUSERS, SPRINKLER HEADS, ETC.
- REFER TO HVAC PLANS FOR THE LOCATION OF ANY AND ALL PLENUM CEILING SPACES. ALL WALLS AND SOFFITS CREATING THE PLENUM SHALL EXTEND TO THE UNDERSIDE OF STRUCTURE ABOVE AND BE SEALED.
- BULKHEADS AND SOFFITS: ALL SIDES AND UNDERSIDES TO BE PAINTED AS INDICATED ON REFLECTED CEILING PLANS, UNLESS NOTED OTHERWISE.
- EXISTING CEILINGS NOTED TO BE PAINTED INCLUDE PAINTING EXPOSED MECHANICAL DUCTWORK, ELECTRICAL CONDUIT, PIPING, ETC. PREP ANY MILDEWMOLD ON EQUIPMENT PRIOR TO PAINT FOR A THOROUGH ADHESION TO EXISTING CEILING/EQUIPMENT UNLESS NOTED OTHERWISE.
- DO NOT PAINT EXISTING MECHANICAL, ELECTRICAL, OR PLUMBING VALVES, SENSORS, RELAYS OR ACTUATORS THAT WILL NEED LOCATED, OPERATED OR SERVICED.

KEYNOTE LEGEND

- 15 PAINT ALL EXPOSED DUCTWORK, CONDUIT, ELECTRICAL EQUIPMENT, GRILLES, VENTS, METAL ACCESS PANELS, ETC. TO MATCH ADJACENT SURFACES. ALL VALVES, SENSORS, RELAYS, AND ACTUATORS TO REMAIN UNPAINTED.
- 17 EXISTING CEILING TO REMAIN. DO NOT PAINT CEILING. NO ADDITIONAL WORK REQUIRED.

ISG

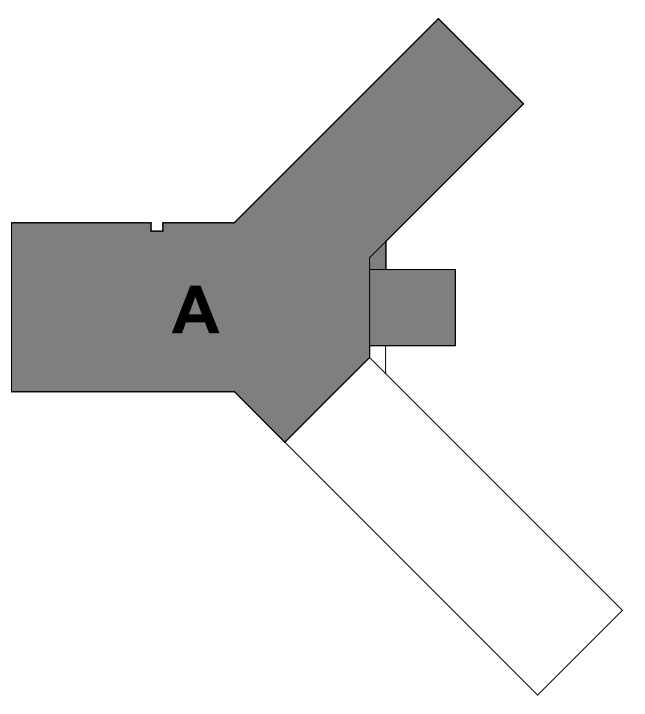

KEYPLAN

THIS DOCUMENT IS THE PROPERTY OF I & S GROUP, INC. AND MAY NOT BE USED, COPIED OR DUPLICATED WITHOUT PRIOR WRITTEN CONSENT.
© 2024 I & S GROUP, INC.

PROJECT

IOWA ARMY
NATIONAL GUARD
S54 FINISH
UPGRADES

CAMP DODGE, JOHNSTON IOWA

REVISION SCHEDULE		
DATE	DESCRIPTION	BY


PROJECT NO.	26-34920
FILE NAME	34920 Arch R26
DRAWN BY	MJT
DESIGNED BY	GMP
REVIEWED BY	GMP
ORIGINAL ISSUE DATE	09/08/26
CLIENT PROJECT NO.	19083733

TITLE


SECOND FLOOR
REFLECTED
CEILING PLAN -
AREA A

SHEET

 
A1-32A



1 ENLARGED FIRST FLOOR PLAN - RESTROOMS
1/4" = 1'-0"

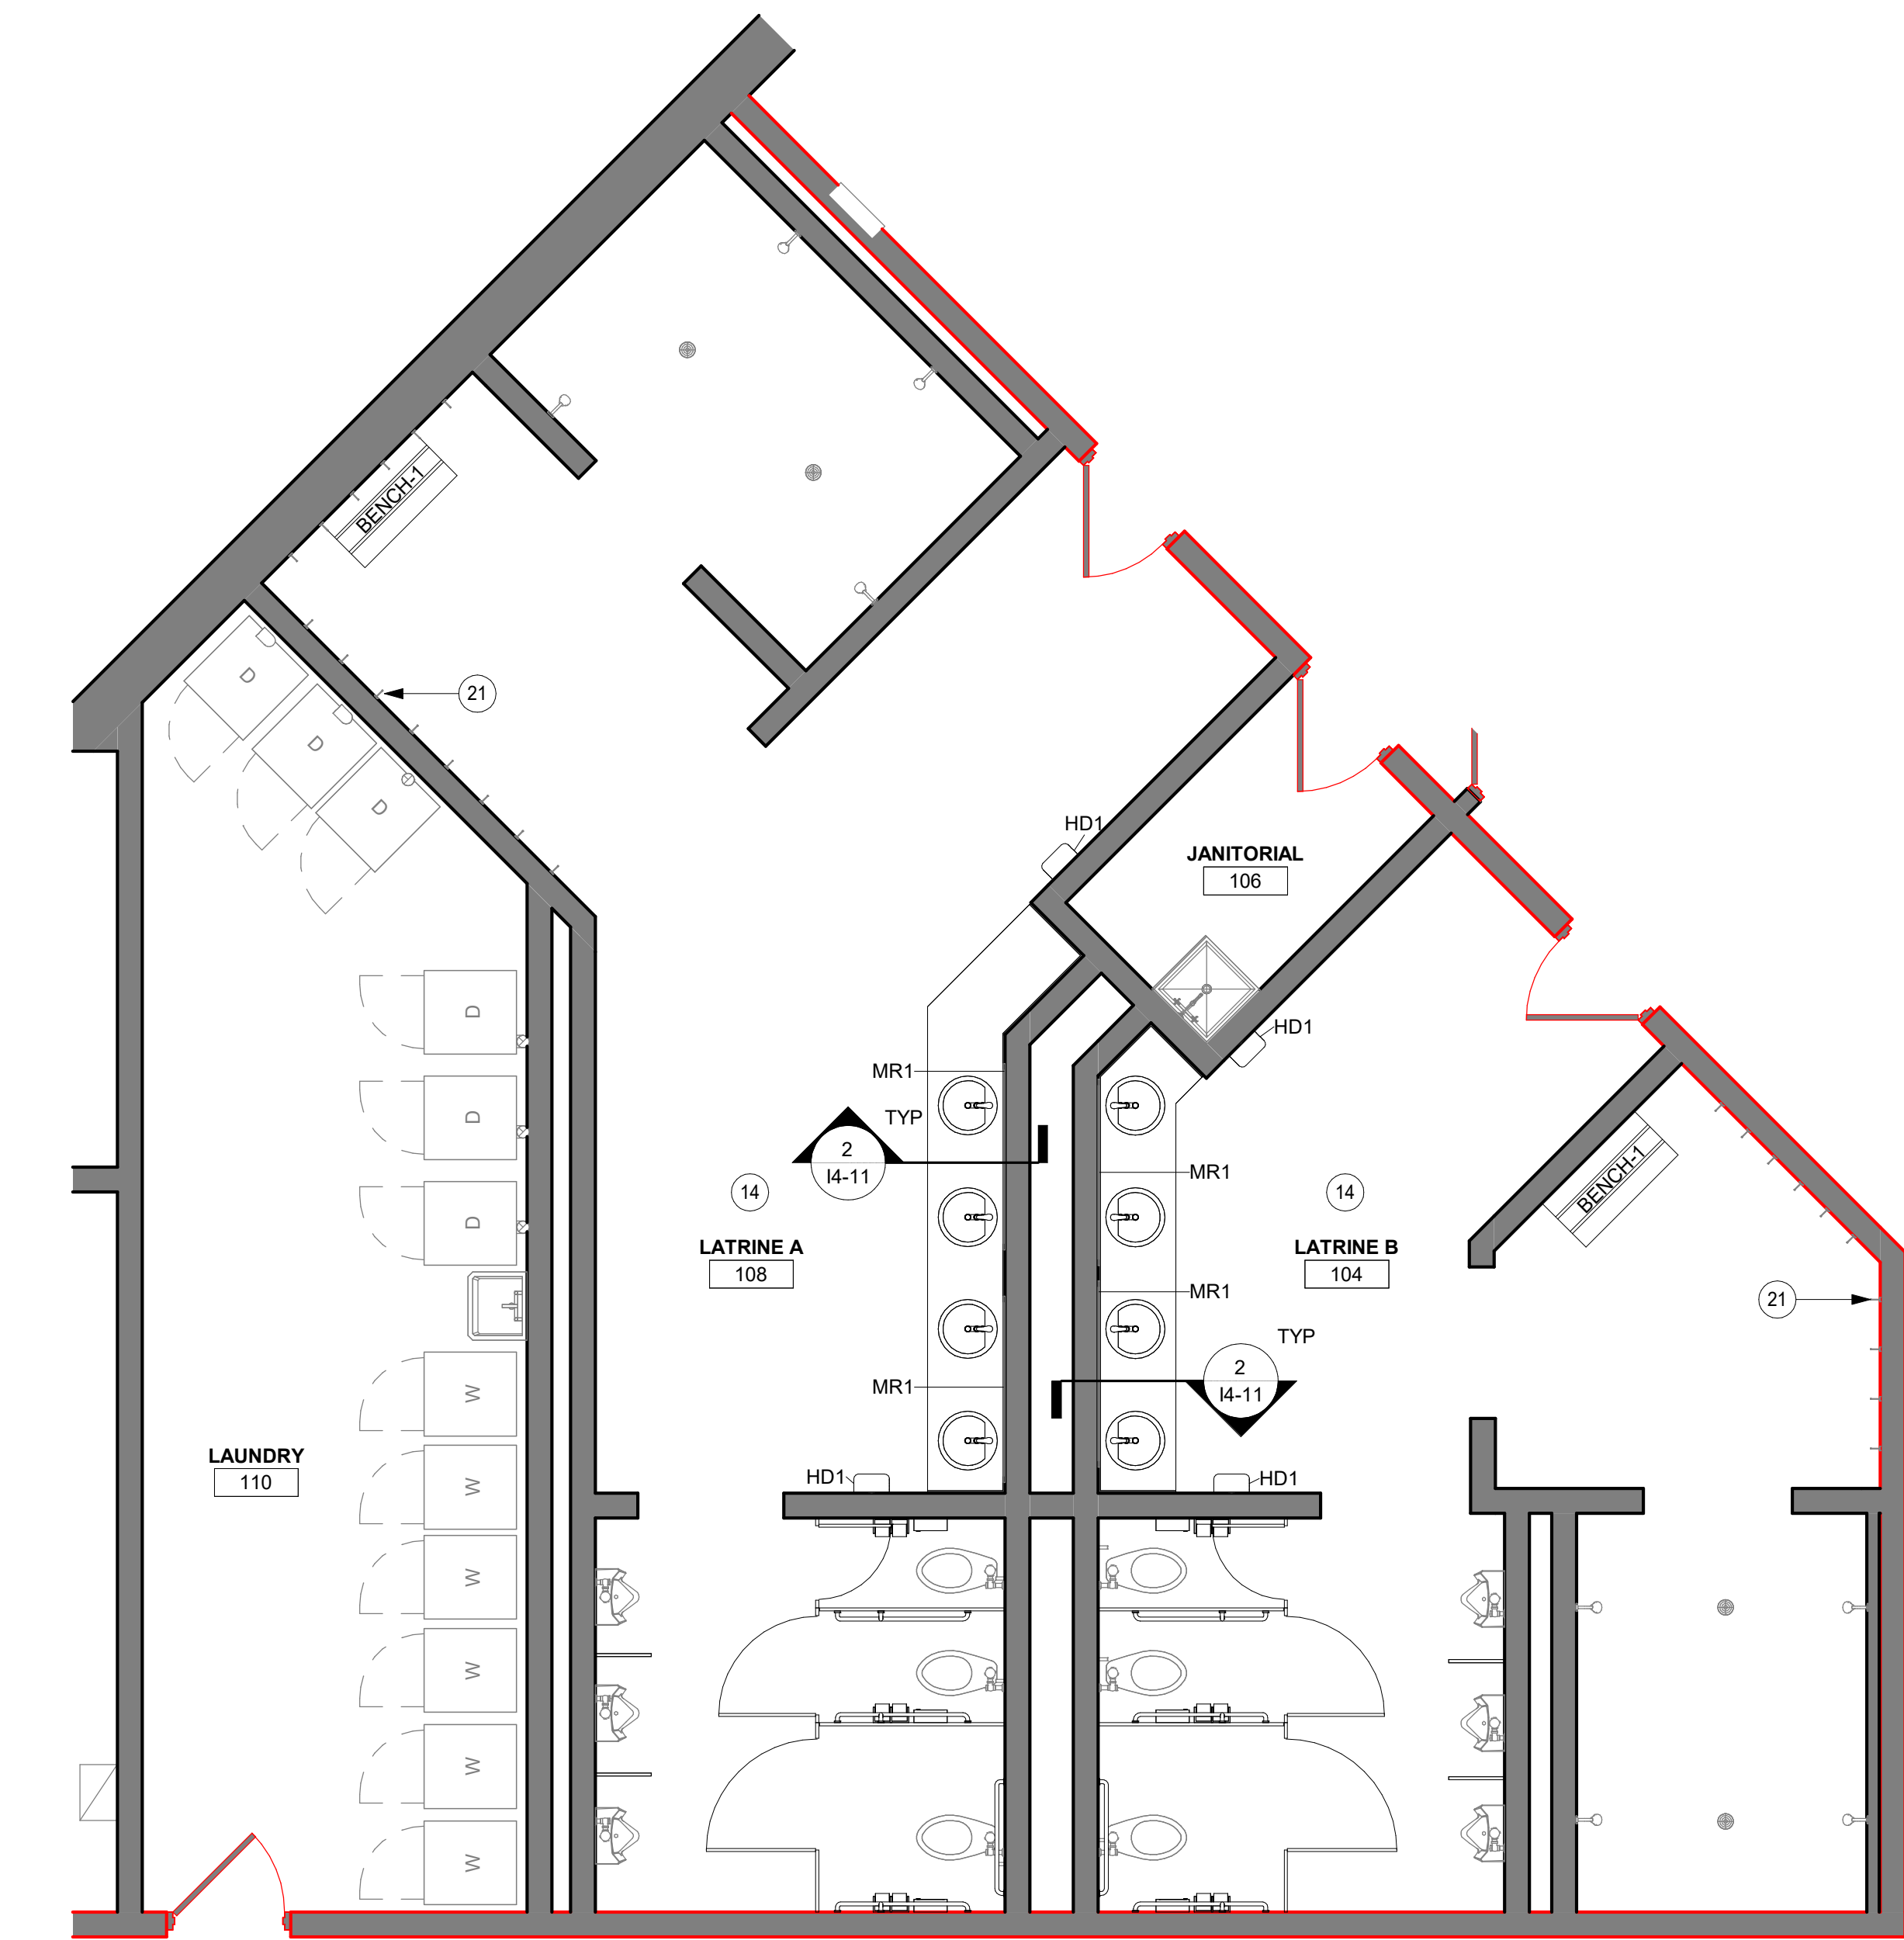

2 ENLARGED 2ND FLOOR PLAN - RESTROOMS
1/4" = 1'-0"

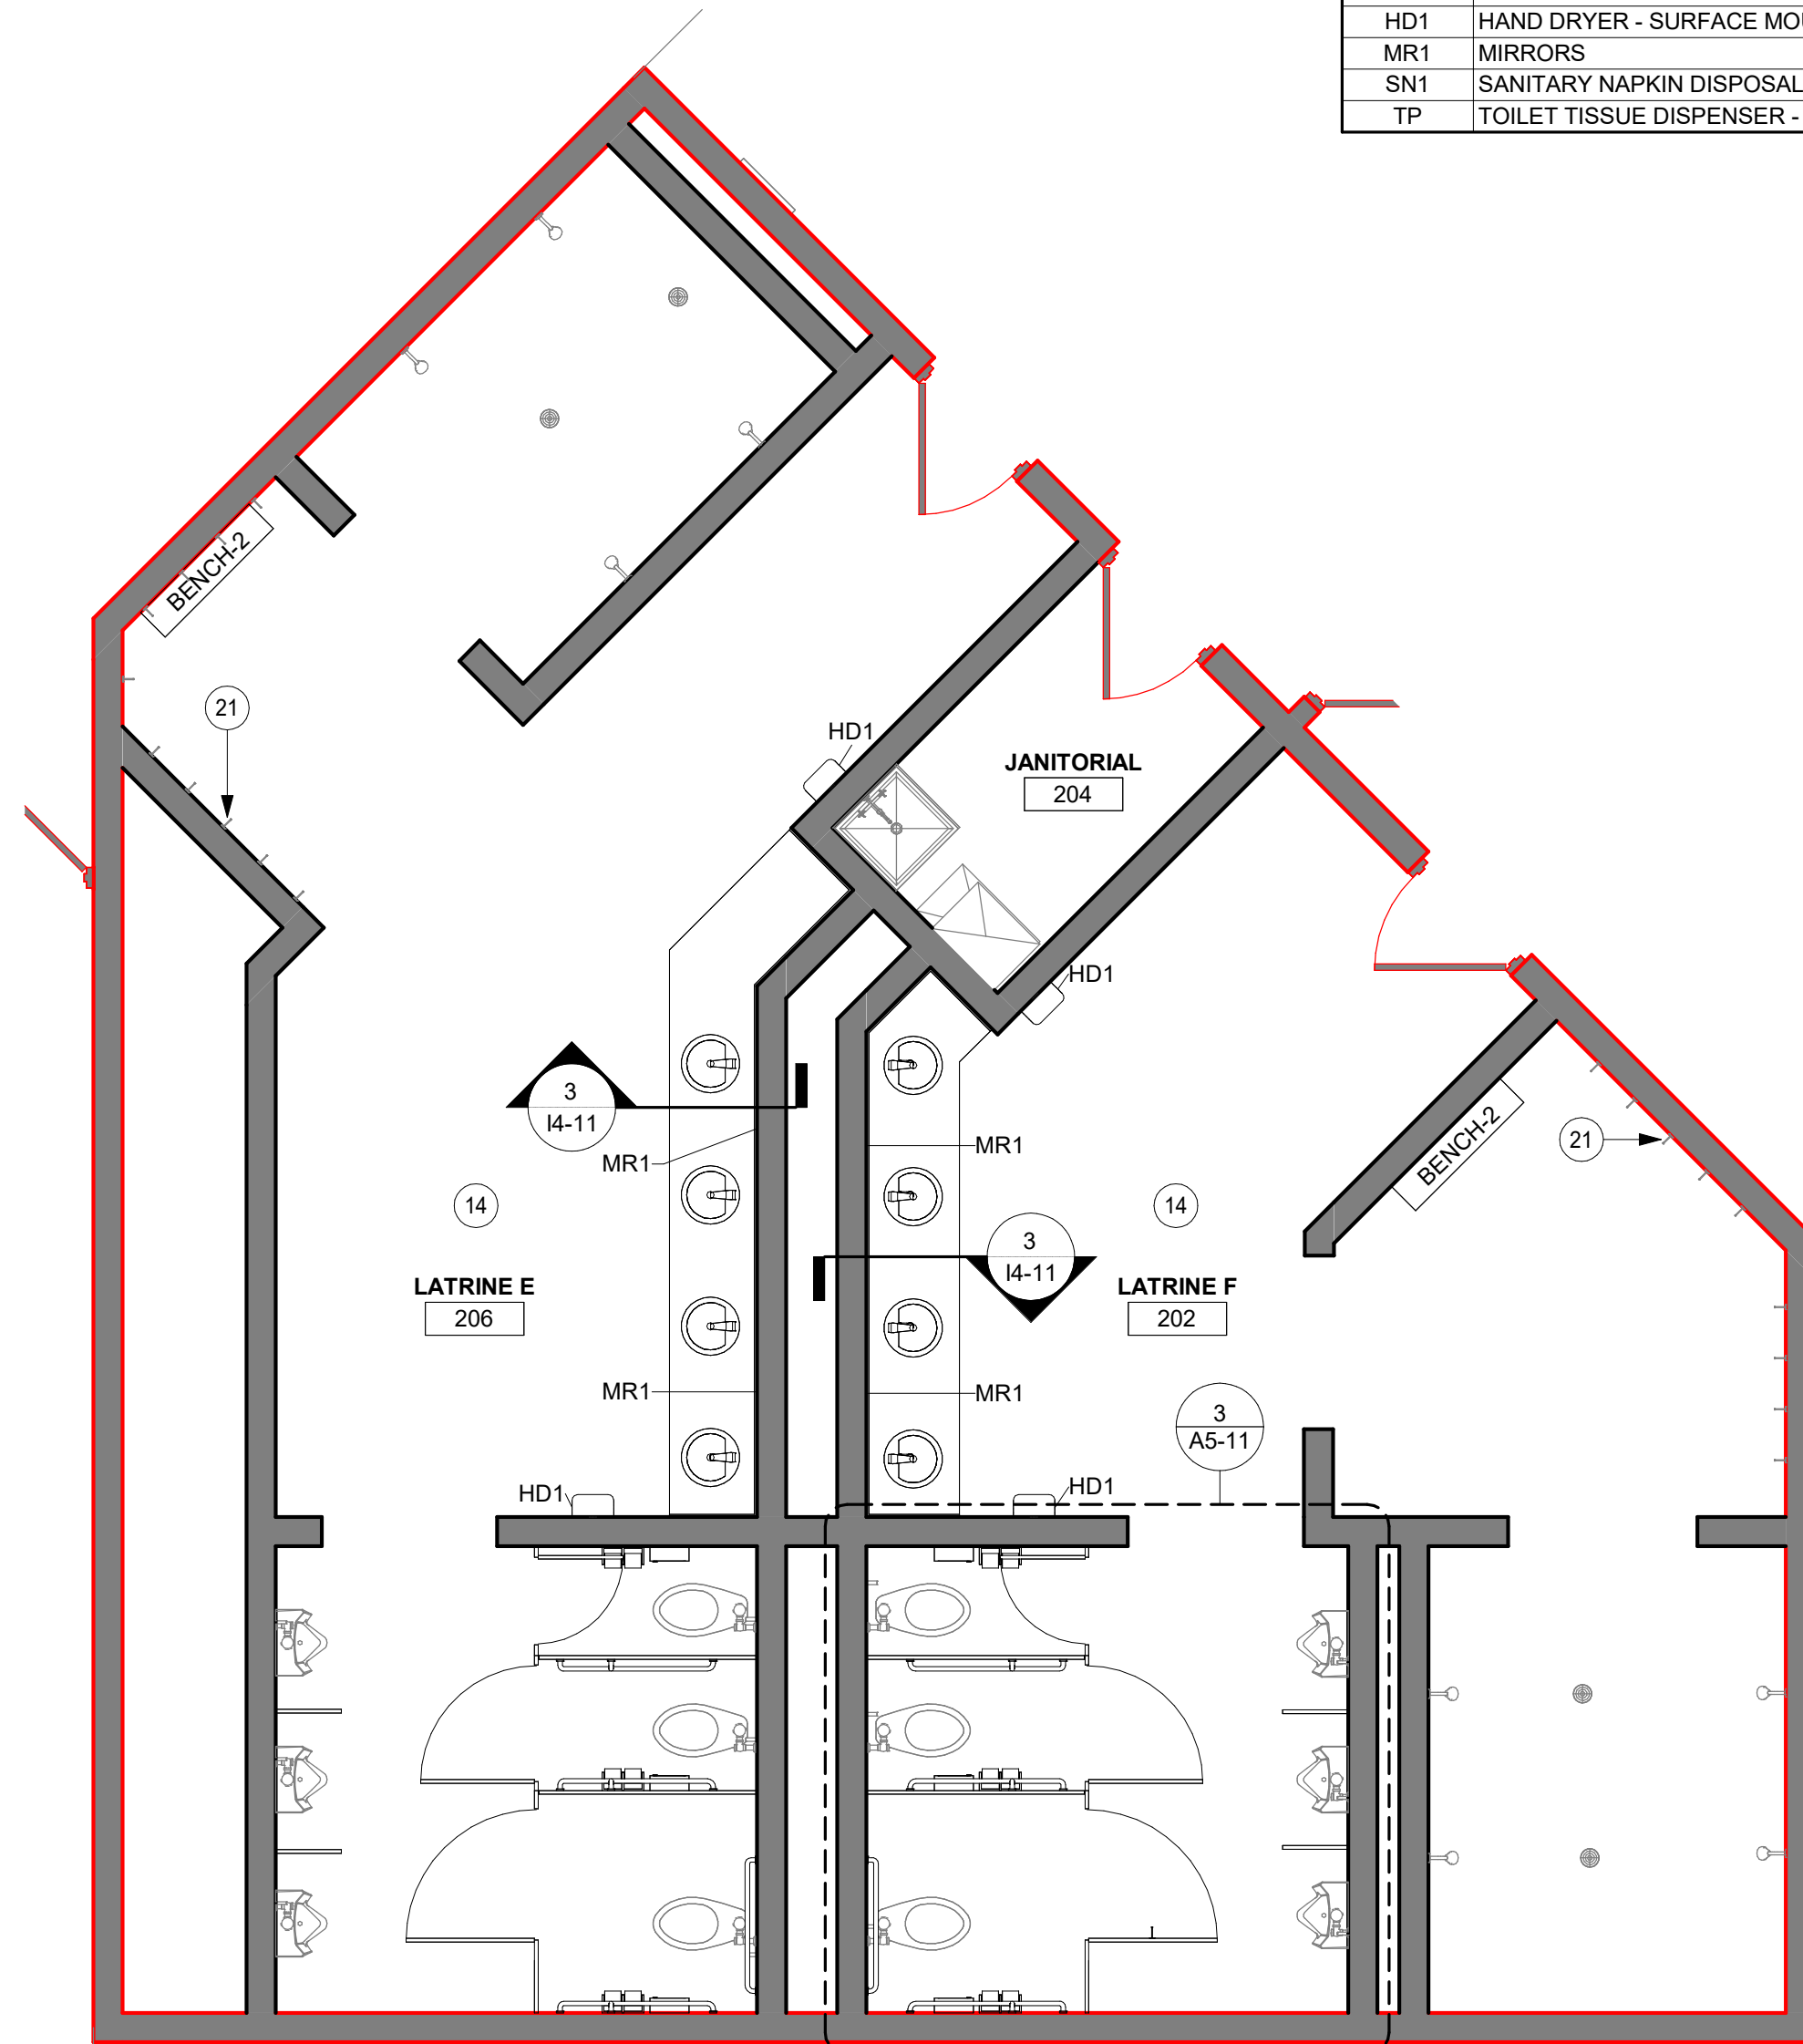


RESTROOM ACCESSORY SCHEDULE				
MARK	DESCRIPTION	COMMENTS	PROVIDED BY	INSTALLED BY
CH	COAT HOOK		CONTRACTOR	CONTRACTOR
GB1	36" HORIZONTAL GRAB BAR		CONTRACTOR	CONTRACTOR
GB2	42" HORIZONTAL GRAB BAR		CONTRACTOR	CONTRACTOR
GB3	18" VERTICAL GRAB BAR		CONTRACTOR	CONTRACTOR
HD1	HAND DRYER - SURFACE MOUNTED		CONTRACTOR	CONTRACTOR
MR1	MIRRORS	EXISTING MIRRORS TO REMAIN	-	-
SN1	SANITARY NAPKIN DISPOSAL - SURFACE MOUNTED		CONTRACTOR	CONTRACTOR
TP	TOILET TISSUE DISPENSER - DOUBLE		CONTRACTOR	CONTRACTOR


WALL LEGEND	
	EXISTING CONSTRUCTION TO REMAIN
	NEW CONSTRUCTION

FLOOR PLAN SHEET NOTES	
• ALL WALL MOUNTED ITEMS TO SIT FLUSH ON A WALL SURFACE. IN INSTANCES WHERE A WALL MOUNTED ITEM IS TO BE INSTALLED ON TWO DIFFERENT FINISH THICKNESSES, PROVIDE A HARDBOARD BACKER FOR THE ITEM TO SIT FLUSH. PROVIDE SEALANT AROUND ALL EDGES OF BACKER AND PAINT TO MATCH ADJACENT SURFACE.	

KEYNOTE LEGEND	
14	LATRINES ON FIRST FLOOR WILL BE ADA ACCESSIBLE WITH COUNTER AND TOILET ACCESSORY HEIGHTS PER ADA GUIDELINES. SECOND FLOOR LATRINES WILL BE INSTALLED TO MATCH EXISTING HEIGHTS / DISTANCES AND PER STANDARD GUIDELINES. REFER TO MOUNTING HEIGHT STANDARDS ON SHEET G1-12.
21	EXISTING HOOKS TO REMAIN.

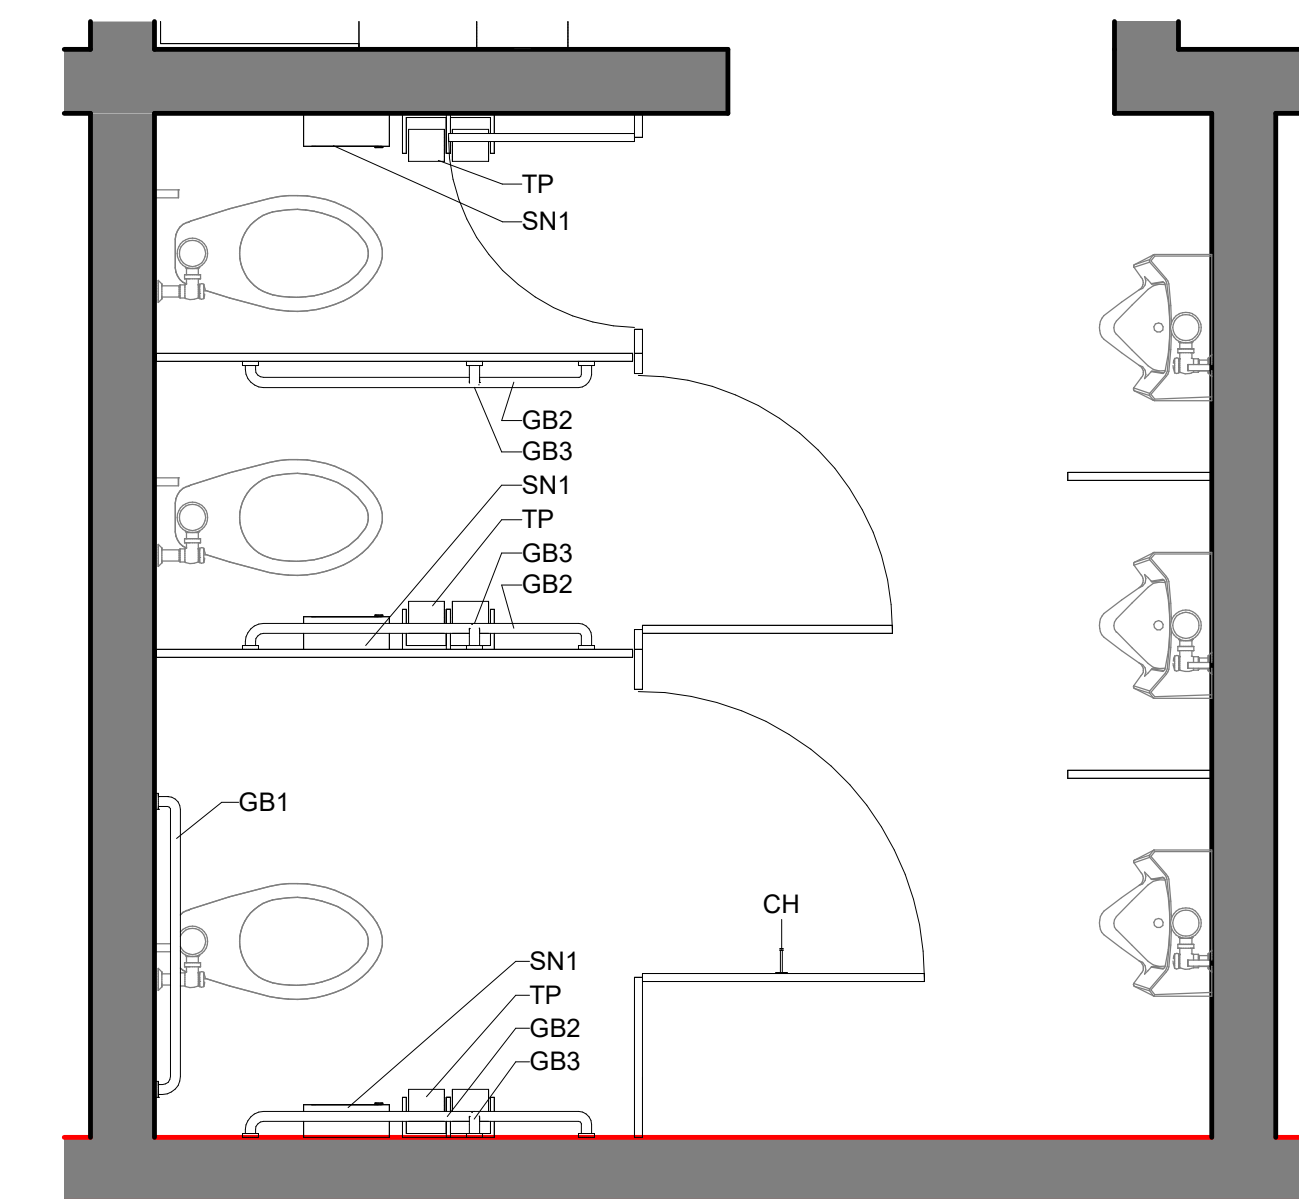

3 TYPICAL ENLARGED RESTROOM PLAN
1/2" = 1'-0"

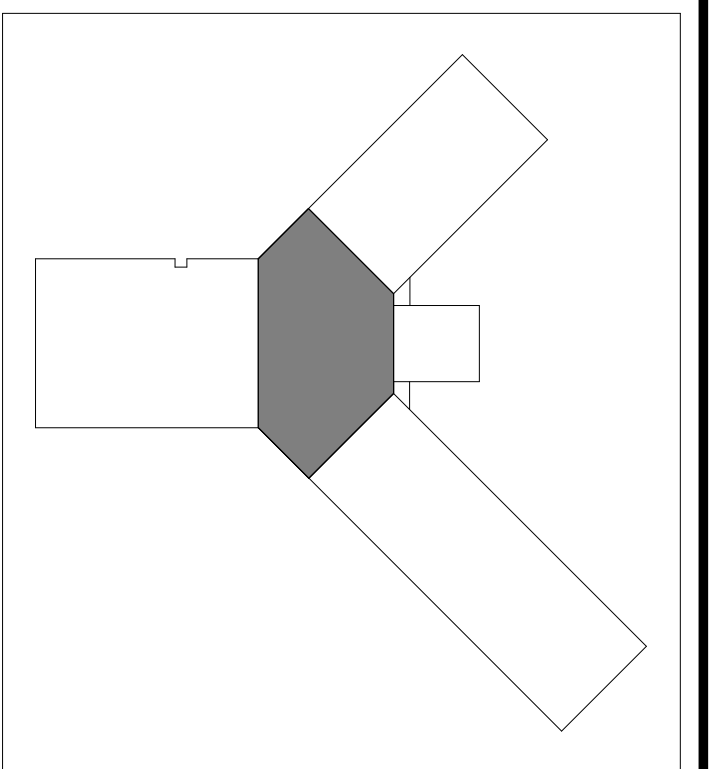

KEYPLAN

THIS DOCUMENT IS THE PROPERTY OF I & S GROUP, INC. AND MAY NOT BE USED, COPIED OR DUPLICATED WITHOUT PRIOR WRITTEN CONSENT.
© 2024 I & S GROUP, INC.

PROJECT

IOWA ARMY NATIONAL GUARD S54 FINISH UPGRADES

CAMP DODGE, JOHNSTON IOWA

REVISION SCHEDULE		
DATE	DESCRIPTION	BY


PROJECT NO.	26-34920
FILE NAME	34920 Arch R26
DRAWN BY	MJT
DESIGNED BY	GMP
REVIEWED BY	GMP
ORIGINAL ISSUE DATE	09/08/26
CLIENT PROJECT NO.	19083733

TITLE

ENLARGED FLOOR PLANS

SHEET


A5-11

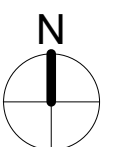



FLOOR PLAN LEGEND

SHADED REGION INDICATES AREA OF PLANS THAT ARE NOT INCLUDED IN SCOPE OF WORK.

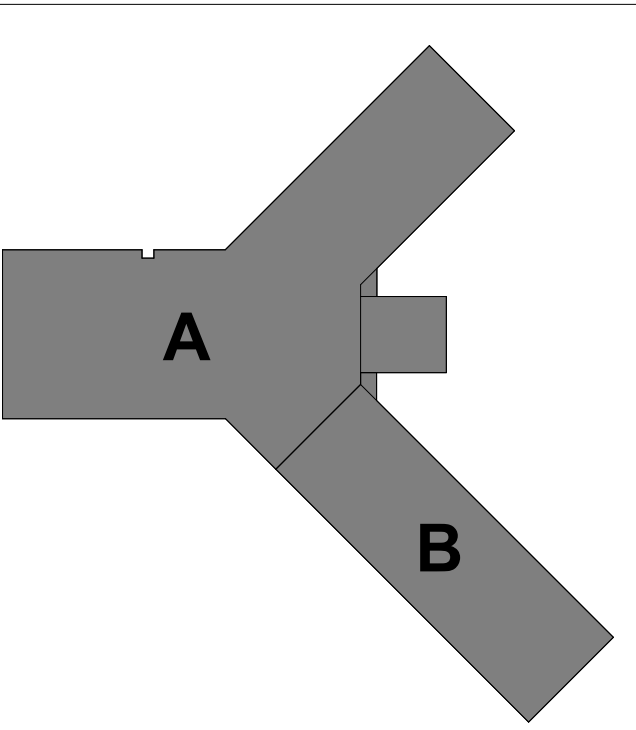

KEYPLAN

THIS DOCUMENT IS THE PROPERTY OF I & S GROUP, INC. AND MAY NOT BE USED, COPIED OR DUPLICATED WITHOUT PRIOR WRITTEN CONSENT.
© 2024 I & S GROUP, INC.

PROJECT

IOWA ARMY
NATIONAL GUARD
S54 FINISH
UPGRADES

CAMP DODGE, JOHNSTON IOWA

REVISION SCHEDULE		
DATE	DESCRIPTION	BY


PROJECT NO.	26-34920
FILE NAME	34920 Arch R26
DRAWN BY	LAD
DESIGNED BY	LAD
REVIEWED BY	LDB
ORIGINAL ISSUE DATE	09/08/26
CLIENT PROJECT NO.	19083733

TITLE

FIRST FLOOR
FINISH PLAN -
OVERALL

SHEET


11-21

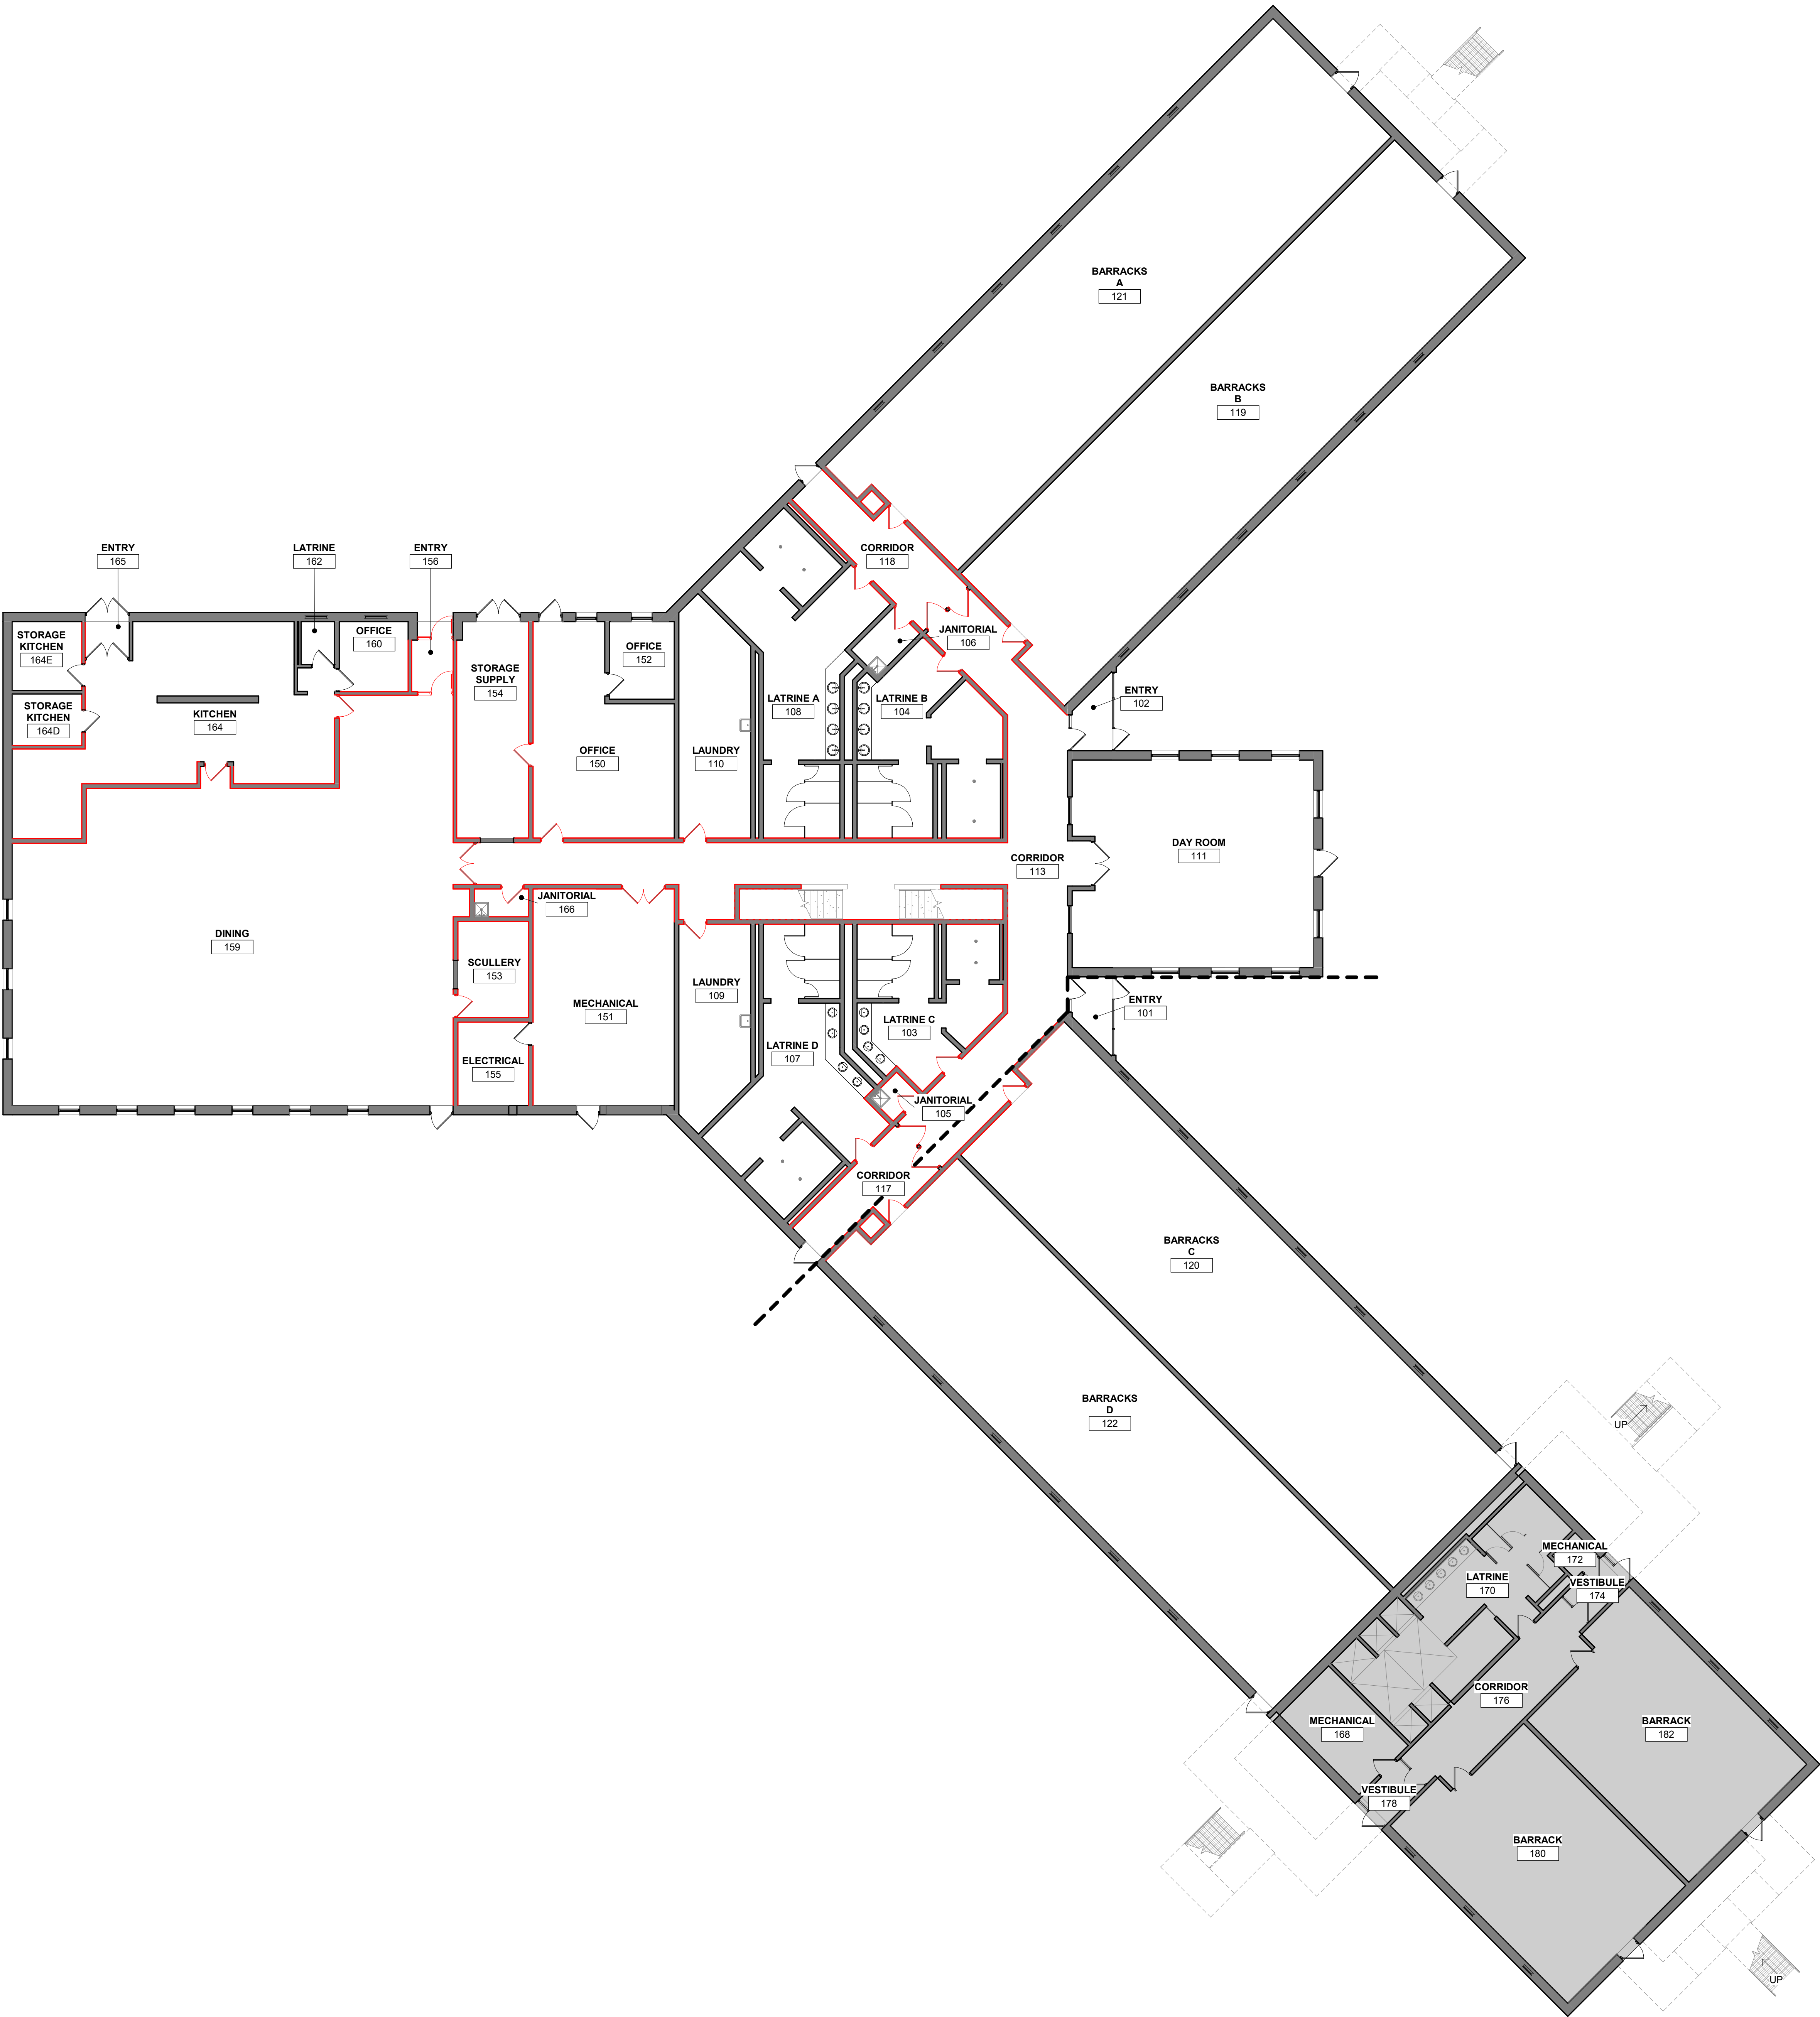

1 FIRST FLOOR FINISH PLAN - OVERALL
3/32" = 1'-0"



1 FIRST FLOOR FINISH PLAN - AREA A
1/8" = 1'-0"

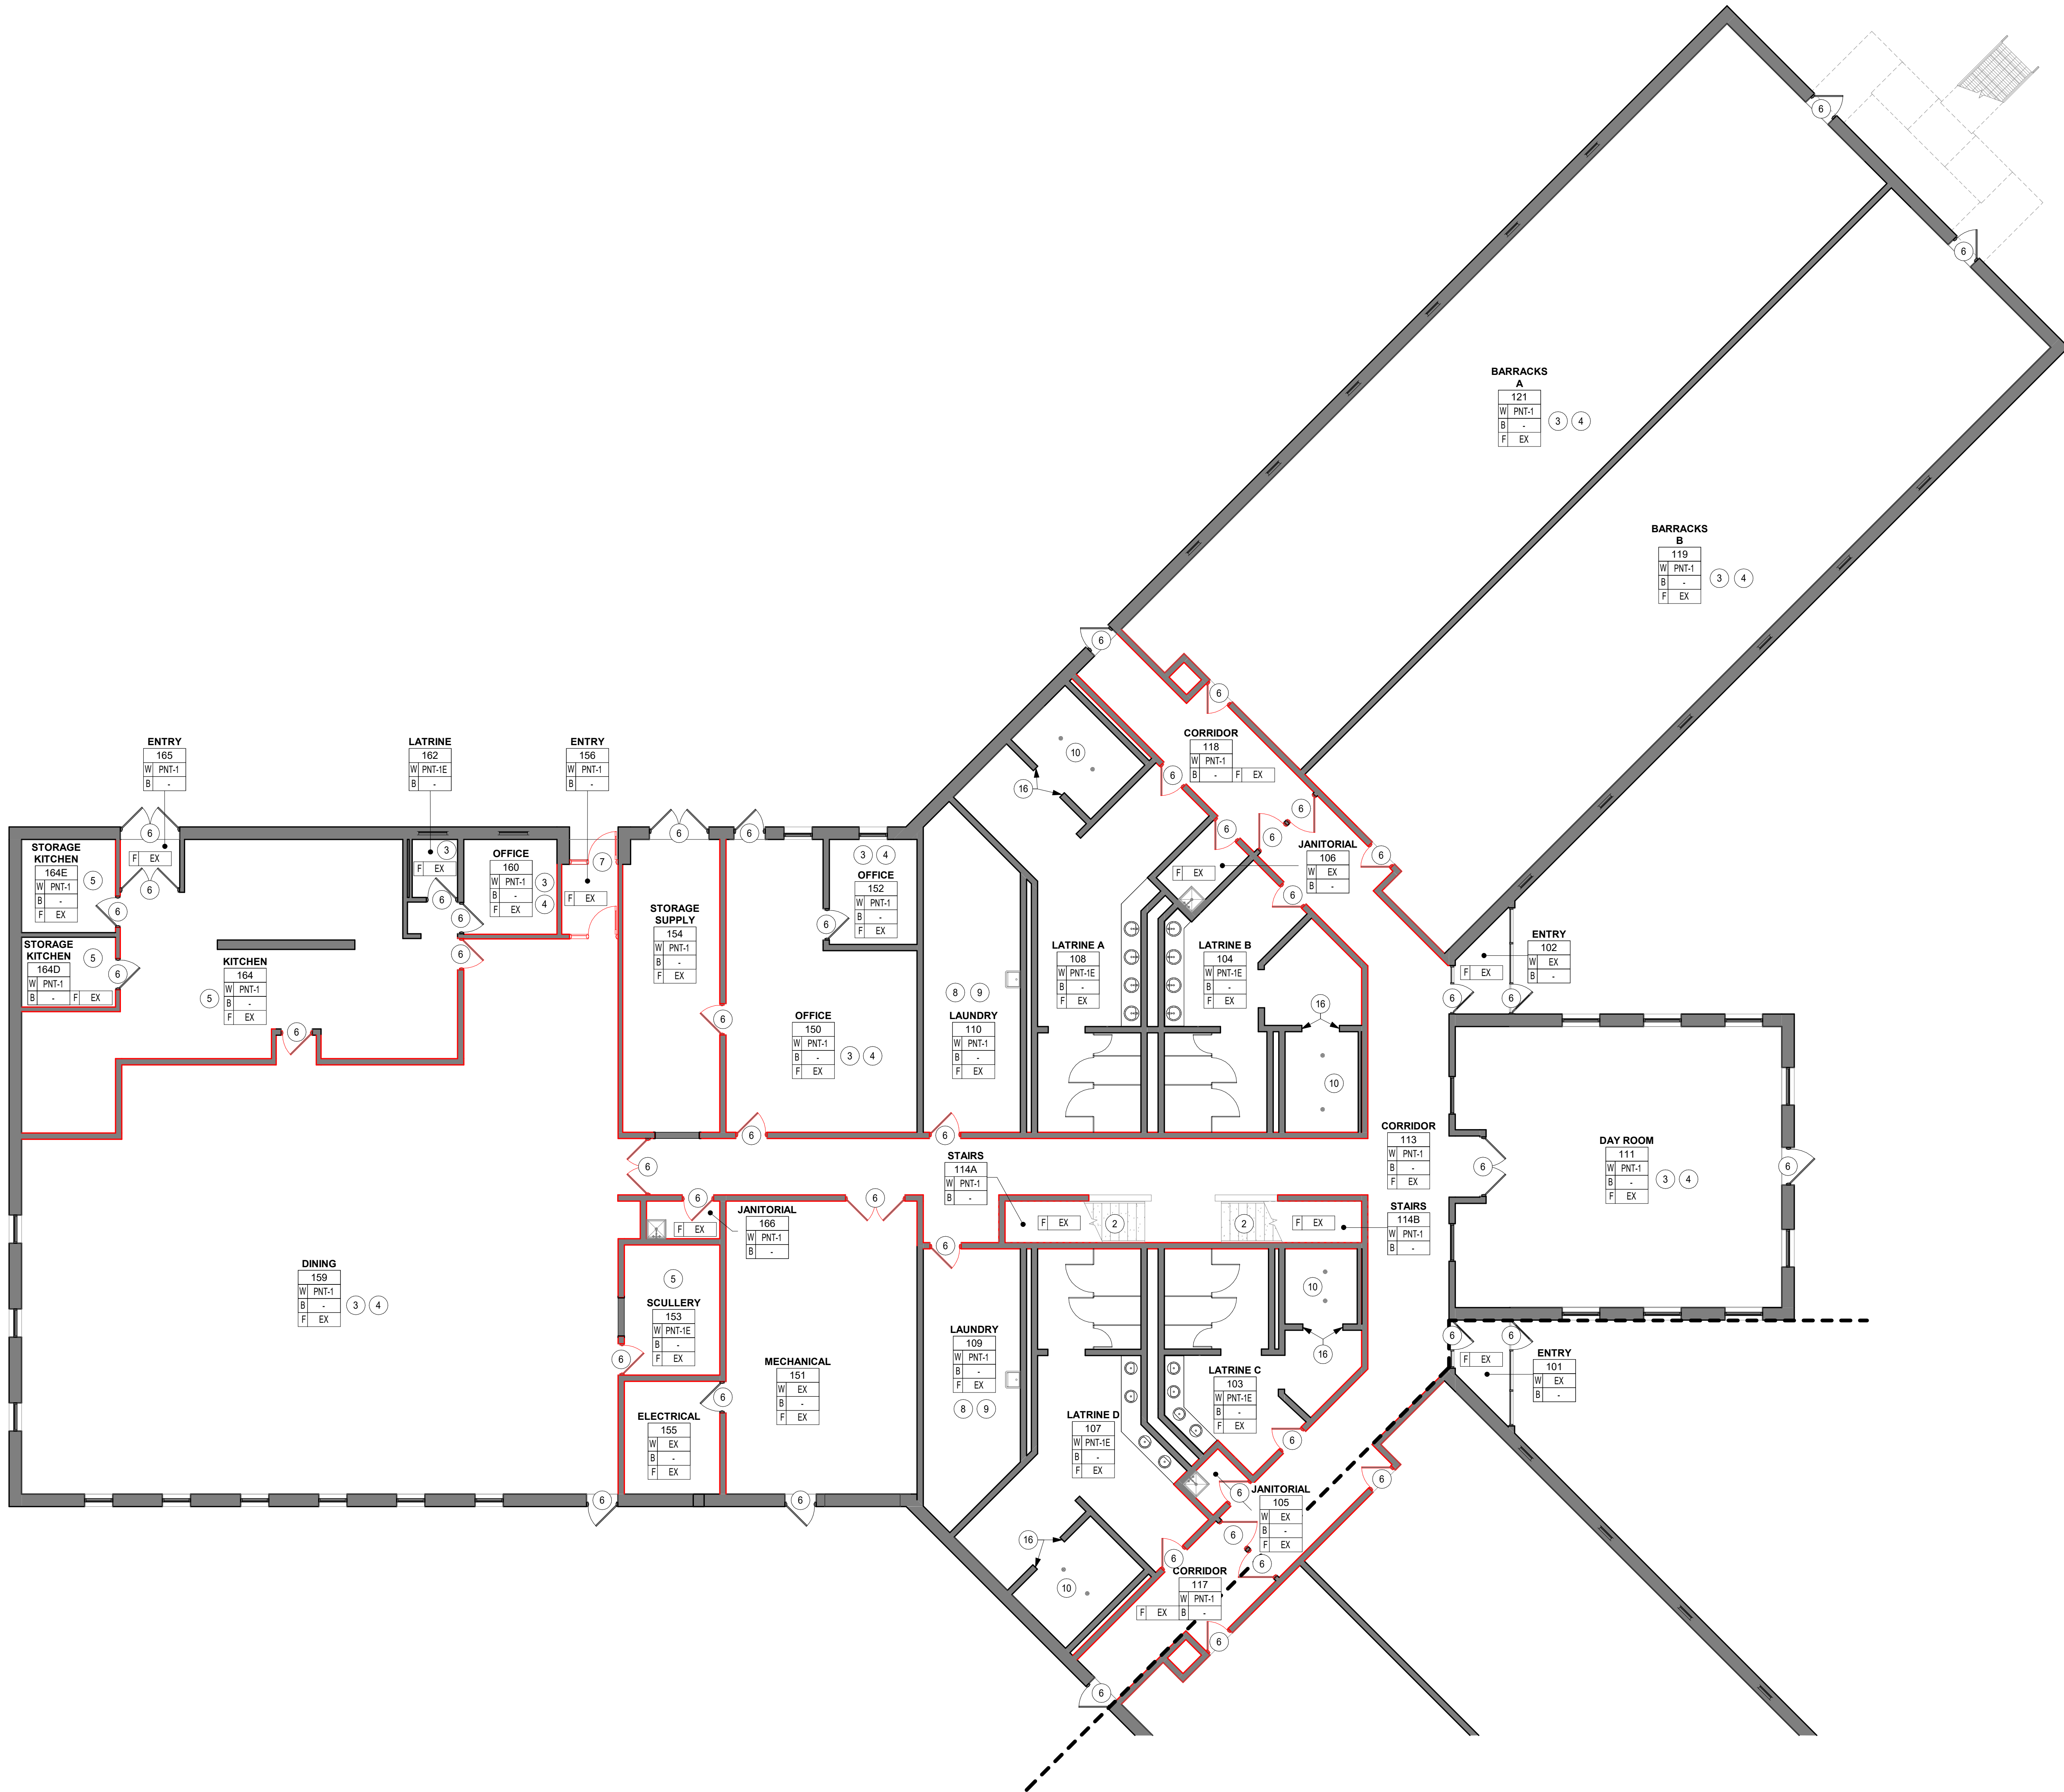


- FINISH NOTES**
- A. SOME SPECIFIED PRODUCTS AND FINISHES MAY HAVE SUBSTANTIAL LEAD TIMES. THE CONTRACTOR SHALL BE RESPONSIBLE FOR PLACING ORDERS IN A MANNER TO ENSURE THEIR TIMELY ARRIVAL. THE CONTRACTOR SHALL BE RESPONSIBLE FOR EXPENSES, INCLUDING DESIGN FEES, RELATED TO ANY RESELECTION REQUIRED DUE TO FAILURE TO ORDER PRODUCTS IN A TIMELY MANNER.
- B. ALL FINISH WORK SHALL BE PERFORMED IN COMPLIANCE WITH DRAWINGS AND SPECIFICATIONS. SHOP DRAWINGS, SAMPLES, AND PRODUCT DATA SHALL BE SUBMITTED TO THE ARCHITECT FOR THEIR REVIEW & APPROVAL PRIOR TO BEGINNING WORK.
- C. ALL WALLS TO RECEIVE PNT-1, UNLESS NOTED OTHERWISE.
- D. BULKHEADS AND SOFFITS: ALL SIDES AND UNDERSIDES TO BE PAINTED AS INDICATED ON REFLECTED CEILING PLANS, UNLESS NOTED OTHERWISE.
- E. REFER TO REFLECTED CEILING PLANS FOR CEILING/SOFFT FINISHES AND LOCATIONS.
- F. PAINT ALL EXPOSED DUCTWORK, CONDUIT, ELECTRICAL EQUIPMENT, GRILLES, VENTS, METAL ACCESS PANELS, ETC., TO MATCH ADJACENT SURFACES, UNLESS NOTED OTHERWISE.
- G. DO NOT PAINT VALVES, SENSORS, RELAYS, OR ACTUATORS.
- H. EXISTING SURFACES TO BE PATCHED AND PREPPED FOR PAINTING AS REQUIRED.
- I. MECHANICAL/ELECTRICAL ROOMS WILL NOT RECEIVE ANY NEW PAINTING ON WALLS OR CEILINGS.
- J. FIRE EXTINGUISHER CABINETS WILL NOT RECEIVE ANY NEW PAINTING.
- K. REMOVE AND REINSTALL SIGNAGE AS REQUIRED FOR PAINTING SCOPE.
- L. WALL MOUNTED ITEMS MAY BE PAINTED AROUND, UNLESS NOTED OTHERWISE.
- M. IN-WALL OR WALL SUPPORT BRACKETS TO BE PAINTED TO MATCH WALL FINISH, UNLESS NOTED OTHERWISE.
- N. PLUMBING FIXTURES HAVE BEEN REMOVED FROM FINISH PLAN FOR VIEWING CLARITY. REFER TO THE RESPECTIVE PLANS AND DOCUMENTS FOR PLUMBING CRITERIA.
- O. UNLESS OTHERWISE INDICATED, PROVIDE PRODUCTS OF QUALITY SPECIFIED BY AWI/AWMAC/WI ARCHITECTURAL WOODWORK STANDARDS FOR CUSTOM GRADE.
- P. HOLLOW METAL DOORS, FRAMES, AND HANDRAILS TO BE PAINTED PNT-3.
- Q. 'E' AT END OF PAINT TAG DESIGNATES TO USE EPOXY PAINT AT THIS LOCATION.
- R. COORDINATE ALL BRACKETS WITH OUTLET LOCATIONS UNDER COUNTER.
- S. WINDOW TREATMENTS ARE INDICATED ON REFLECTED CEILING PLANS.
- T. PAINT ALL EXPOSED METALS INCLUDING, BUT NOT LIMITED TO COLUMNS, RISERS, STRINGERS, HANDRAILS, GUARDRAILS, EXPOSED LINTELS AND FLOOR EDGES, UNLESS NOTED OTHERWISE.
- U. FOR ALL DOORS & FRAMES RECEIVING NEW PAINT, REMOVE/DISCARD ROOM SIGNAGE ATTACHED TO ALL DOOR FRAMES. REMOVE/CLEAN ASSOCIATED ADHESIVES AND ATTACHMENT. REMOVE & INSTALL DOOR HARDWARE AS REQUIRED FOR PAINTING. AT LOCATIONS WHERE FRAMES SHOW SIGNS OF DETERIORATION, FILE SMOOTH PRIOR TO PAINTING. PREP ALL FRAMES FOR PAINT.

ROOM / FINISH TAG	
ROOM NAME	
ROOM #	
W WALL	
B BASE	
F FLOOR	

FINISHES LISTED IN ROOM TAG APPLY TO ALL ELEMENTS IN ROOM, UNLESS NOTED OTHERWISE

- KEYNOTE LEGEND**
- 2 PAINT ALL STAIR HANDRAILS, GUARDRAILS, RISERS AND STRINGERS PNT-3.
- 3 PAINT ALL HOLLOW METAL INTERIOR WINDOW FRAMES PNT-3.
- 4 CONTRACTOR TO COORDINATE MOVING FURNITURE WITH OWNER. PROTECT ALL FURNITURE DURING CONSTRUCTION.
- 5 CONTRACTOR TO COORDINATE MOVING KITCHEN EQUIPMENT WITH OWNER. CONTRACTOR TO DISCONNECT, REMOVE AND REINSTALL ALL KITCHEN EQUIPMENT AS REQUIRED. PROTECT ALL EQUIPMENT DURING CONSTRUCTION.
- 6 PAINT BOTH SIDES OF HOLLOW METAL DOORS AND FRAMES. REFER TO INTERIOR FINISH SCHEDULE. REFER TO FINISH NOTES ON REQUIRED DOOR PREP.
- 7 NEW DOOR AND FRAME. REFER TO DOOR SCHEDULE. PAINT BOTH SIDES OF HOLLOW METAL DOOR AND FRAME. REFER TO INTERIOR FINISH SCHEDULE FOR PAINT COLOR.
- 8 LAUNDRY DRYER DUCTWORK TO REMAIN UNPAINTED.
- 9 CONTRACTOR/PLUMBER TO TURN OFF GAS AND DISCONNECT LAUNDRY MACHINES/EQUIPMENT FOR MOVING. CONTRACTOR TO COORDINATE MOVING OF LAUNDRY MACHINES/EQUIPMENT WITH OWNER. PROTECT ITEMS DURING CONSTRUCTION.
- 10 NO FINISH WORK EXCEPT CEILING PAINTING IN SHOWERS.
- 16 NEW PAINT WORK TO STOP AT EXISTING PAINT LINE, CENTERED IN OPENING.

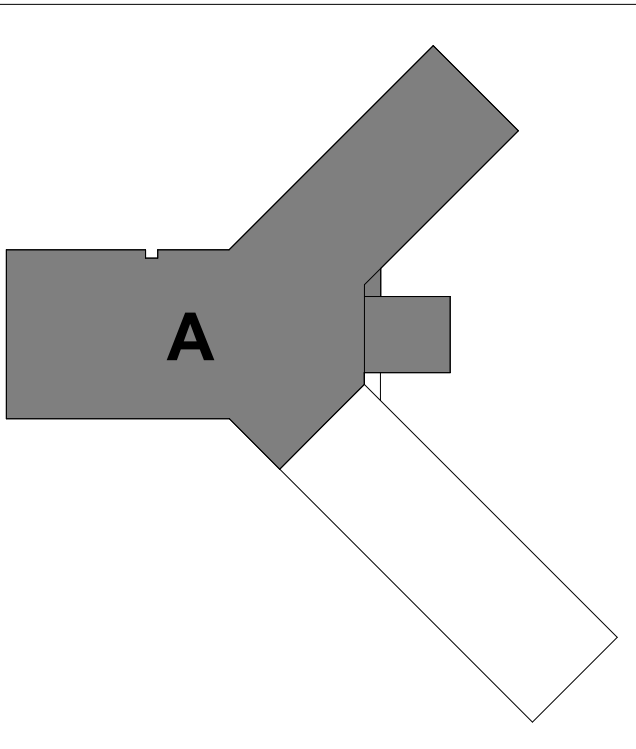

KEYPLAN

THIS DOCUMENT IS THE PROPERTY OF I & S GROUP, INC. AND MAY NOT BE USED, COPIED OR DUPLICATED WITHOUT PRIOR WRITTEN CONSENT.
© 2024 I & S GROUP, INC.

PROJECT

**IOWA ARMY
NATIONAL GUARD
S54 FINISH
UPGRADES**

CAMP DODGE, JOHNSTON IOWA

REVISION SCHEDULE		
DATE	DESCRIPTION	BY


PROJECT NO.	26-34920
FILE NAME	34920 Arch R26
DRAWN BY	LAD
DESIGNED BY	LAD
REVIEWED BY	LDB
ORIGINAL ISSUE DATE	09/08/26
CLIENT PROJECT NO.	19083733

TITLE

**FIRST FLOOR
FINISH PLAN -
AREA A**

SHEET

11-21A

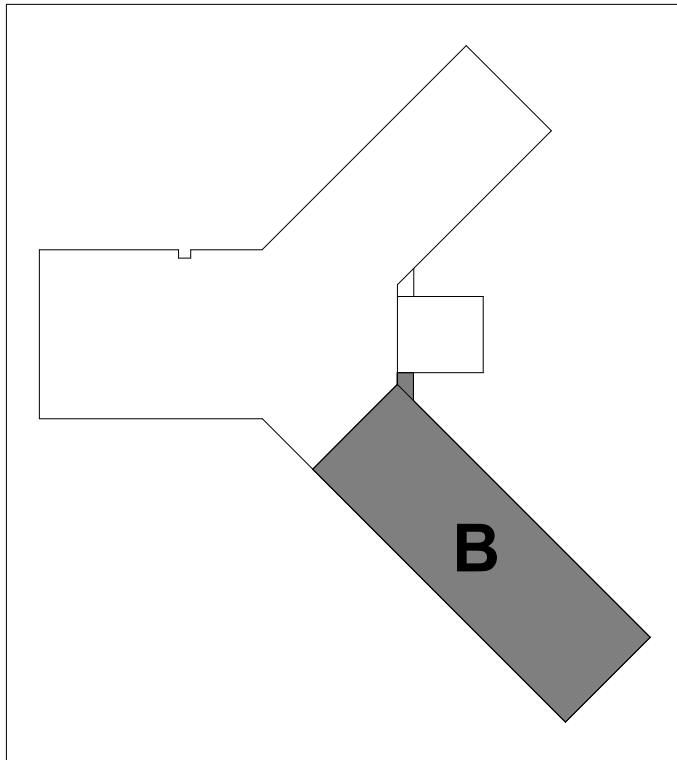

KEYPLAN

THIS DOCUMENT IS THE PROPERTY OF I & S GROUP, INC. AND MAY NOT BE USED, COPIED OR DUPLICATED WITHOUT PRIOR WRITTEN CONSENT.
© 2024 I & S GROUP, INC.

PROJECT

**IOWA ARMY
NATIONAL GUARD
S54 FINISH
UPGRADES**

CAMP DODGE, JOHNSTON IOWA

REVISION SCHEDULE		
DATE	DESCRIPTION	BY

PROJECT NO.	26-34920
FILE NAME	34920 Arch R26
DRAWN BY	LAD
DESIGNED BY	LAD
REVIEWED BY	LDB
ORIGINAL ISSUE DATE	09/08/26
CLIENT PROJECT NO.	19083733

TITLE

**FIRST AND
SECOND FLOOR
FINISH PLAN -
AREA B**

SHEET

11-21B

KEYNOTE LEGEND

- PAINT ALL HOLLOW METAL INTERIOR WINDOW FRAMES PNT-3.
- CONTRACTOR TO COORDINATE MOVING FURNITURE WITH OWNER. PROTECT ALL FURNITURE DURING CONSTRUCTION.
- PAINT BOTH SIDES OF HOLLOW METAL DOORS AND FRAMES. REFER TO INTERIOR FINISH SCHEDULE. REFER TO FINISH NOTES ON REQUIRED DOOR PREP.
- NO FINISH WORK EXCEPT CEILING PAINTING IN SHOWERS.
- NEW PAINT WORK TO STOP AT EXISTING PAINT LINE, CENTERED IN OPENING.

FLOOR PLAN LEGEND

- SHADED REGION INDICATES AREA OF PLANS THAT ARE NOT INCLUDED IN SCOPE OF WORK.



ROOM / FINISH TAG

ROOM NAME
ROOM #
W WALL
B BASE
F FLOOR

FINISHES LISTED IN ROOM TAG APPLY TO ALL ELEMENTS IN ROOM, UNLESS NOTED OTHERWISE


FINISH NOTES

- SOME SPECIFIED PRODUCTS AND FINISHES MAY HAVE SUBSTANTIAL LEAD TIMES. THE CONTRACTOR SHALL BE RESPONSIBLE FOR PLACING ORDERS IN A MANNER TO ENSURE THEIR TIMELY ARRIVAL. THE CONTRACTOR SHALL BE RESPONSIBLE FOR EXPENSES, INCLUDING DESIGN FEES, RELATED TO ANY RESELECTION REQUIRED DUE TO FAILURE TO ORDER PRODUCTS IN A TIMELY MANNER.
- ALL FINISH WORK SHALL BE PERFORMED IN COMPLIANCE WITH DRAWINGS AND SPECIFICATIONS. SHOP DRAWINGS, SAMPLES, AND PRODUCT DATA SHALL BE SUBMITTED TO THE ARCHITECT FOR THEIR REVIEW & APPROVAL PRIOR TO BEGINNING WORK.
- ALL WALLS TO RECEIVE PNT-1, UNLESS NOTED OTHERWISE.
- BULKHEADS AND SOFFITS: ALL SIDES AND UNDERSIDES TO BE PAINTED AS INDICATED ON REFLECTED CEILING PLANS, UNLESS NOTED OTHERWISE.
- REFER TO REFLECTED CEILING PLANS FOR CEILINGS/OFFIT FINISHES AND LOCATIONS.
- PAINT ALL EXPOSED DUCTWORK, CONDUIT, ELECTRICAL EQUIPMENT, GRILLES, VENTS, METAL ACCESS PANELS, ETC. TO MATCH ADJACENT SURFACES, UNLESS NOTED OTHERWISE.
- DO NOT PAINT VALVES, SENSORS, RELAYS, OR ACTUATORS.
- EXISTING SURFACES TO BE PATCHED AND PREPPED FOR PAINTING AS REQUIRED.
- MECHANICAL/ELECTRICAL ROOMS WILL NOT RECEIVE ANY NEW PAINTING ON WALLS OR CEILINGS.
- FIRE EXTINGUISHER CABINETS WILL NOT RECEIVE ANY NEW PAINTING.
- REMOVE AND REINSTALL SIGNAGE AS REQUIRED FOR PAINTING SCOPE.
- WALL MOUNTED ITEMS MAY BE PAINTED AROUND, UNLESS NOTED OTHERWISE.
- IN-WALL OR WALL SUPPORT BRACKETS TO BE PAINTED TO MATCH WALL FINISH, UNLESS NOTED OTHERWISE.
- PLUMBING FIXTURES HAVE BEEN REMOVED FROM FINISH PLAN FOR VIEWING CLARITY. REFER TO THE RESPECTIVE PLANS AND DOCUMENTS FOR PLUMBING CRITERIA.
- UNLESS OTHERWISE INDICATED, PROVIDE PRODUCTS OF QUALITY SPECIFIED BY AWII/AWMA/MI ARCHITECTURAL WOODWORK STANDARDS FOR CUSTOM GRADE.
- HOLLOW METAL DOORS, FRAMES, AND HANDRAILS TO BE PAINTED PNT-3.
- "E" AT END OF PAINT TAG DESIGNATES TO USE EPOXY PAINT AT THIS LOCATION.
- COORDINATE ALL BRACKETS WITH OUTLET LOCATIONS UNDER COUNTER.
- WINDOW TREATMENTS ARE INDICATED ON REFLECTED CEILING PLANS.
- PAINT ALL EXPOSED METALS INCLUDING, BUT NOT LIMITED TO COLUMNS, RISERS, STRINGERS, HANDRAILS, GUARDRAILS, EXPOSED LINTELS AND FLOOR EDGES, UNLESS NOTED OTHERWISE.
- FOR ALL DOORS & FRAMES RECEIVING NEW PAINT, REMOVE/DISCARD ROOM SIGNAGE ATTACHED TO ALL DOOR FRAMES. REMOVE/CLEAN ASSOCIATED ADHESIVES AND ATTACHMENT. REMOVE & INSTALL DOOR HARDWARE AS REQUIRED FOR PAINTING. AT LOCATIONS WHERE FRAMES SHOW SIGNS OF DETEIORATION, FILE SMOOTH PRIOR TO PAINTING. PREP ALL FRAMES FOR PAINT.

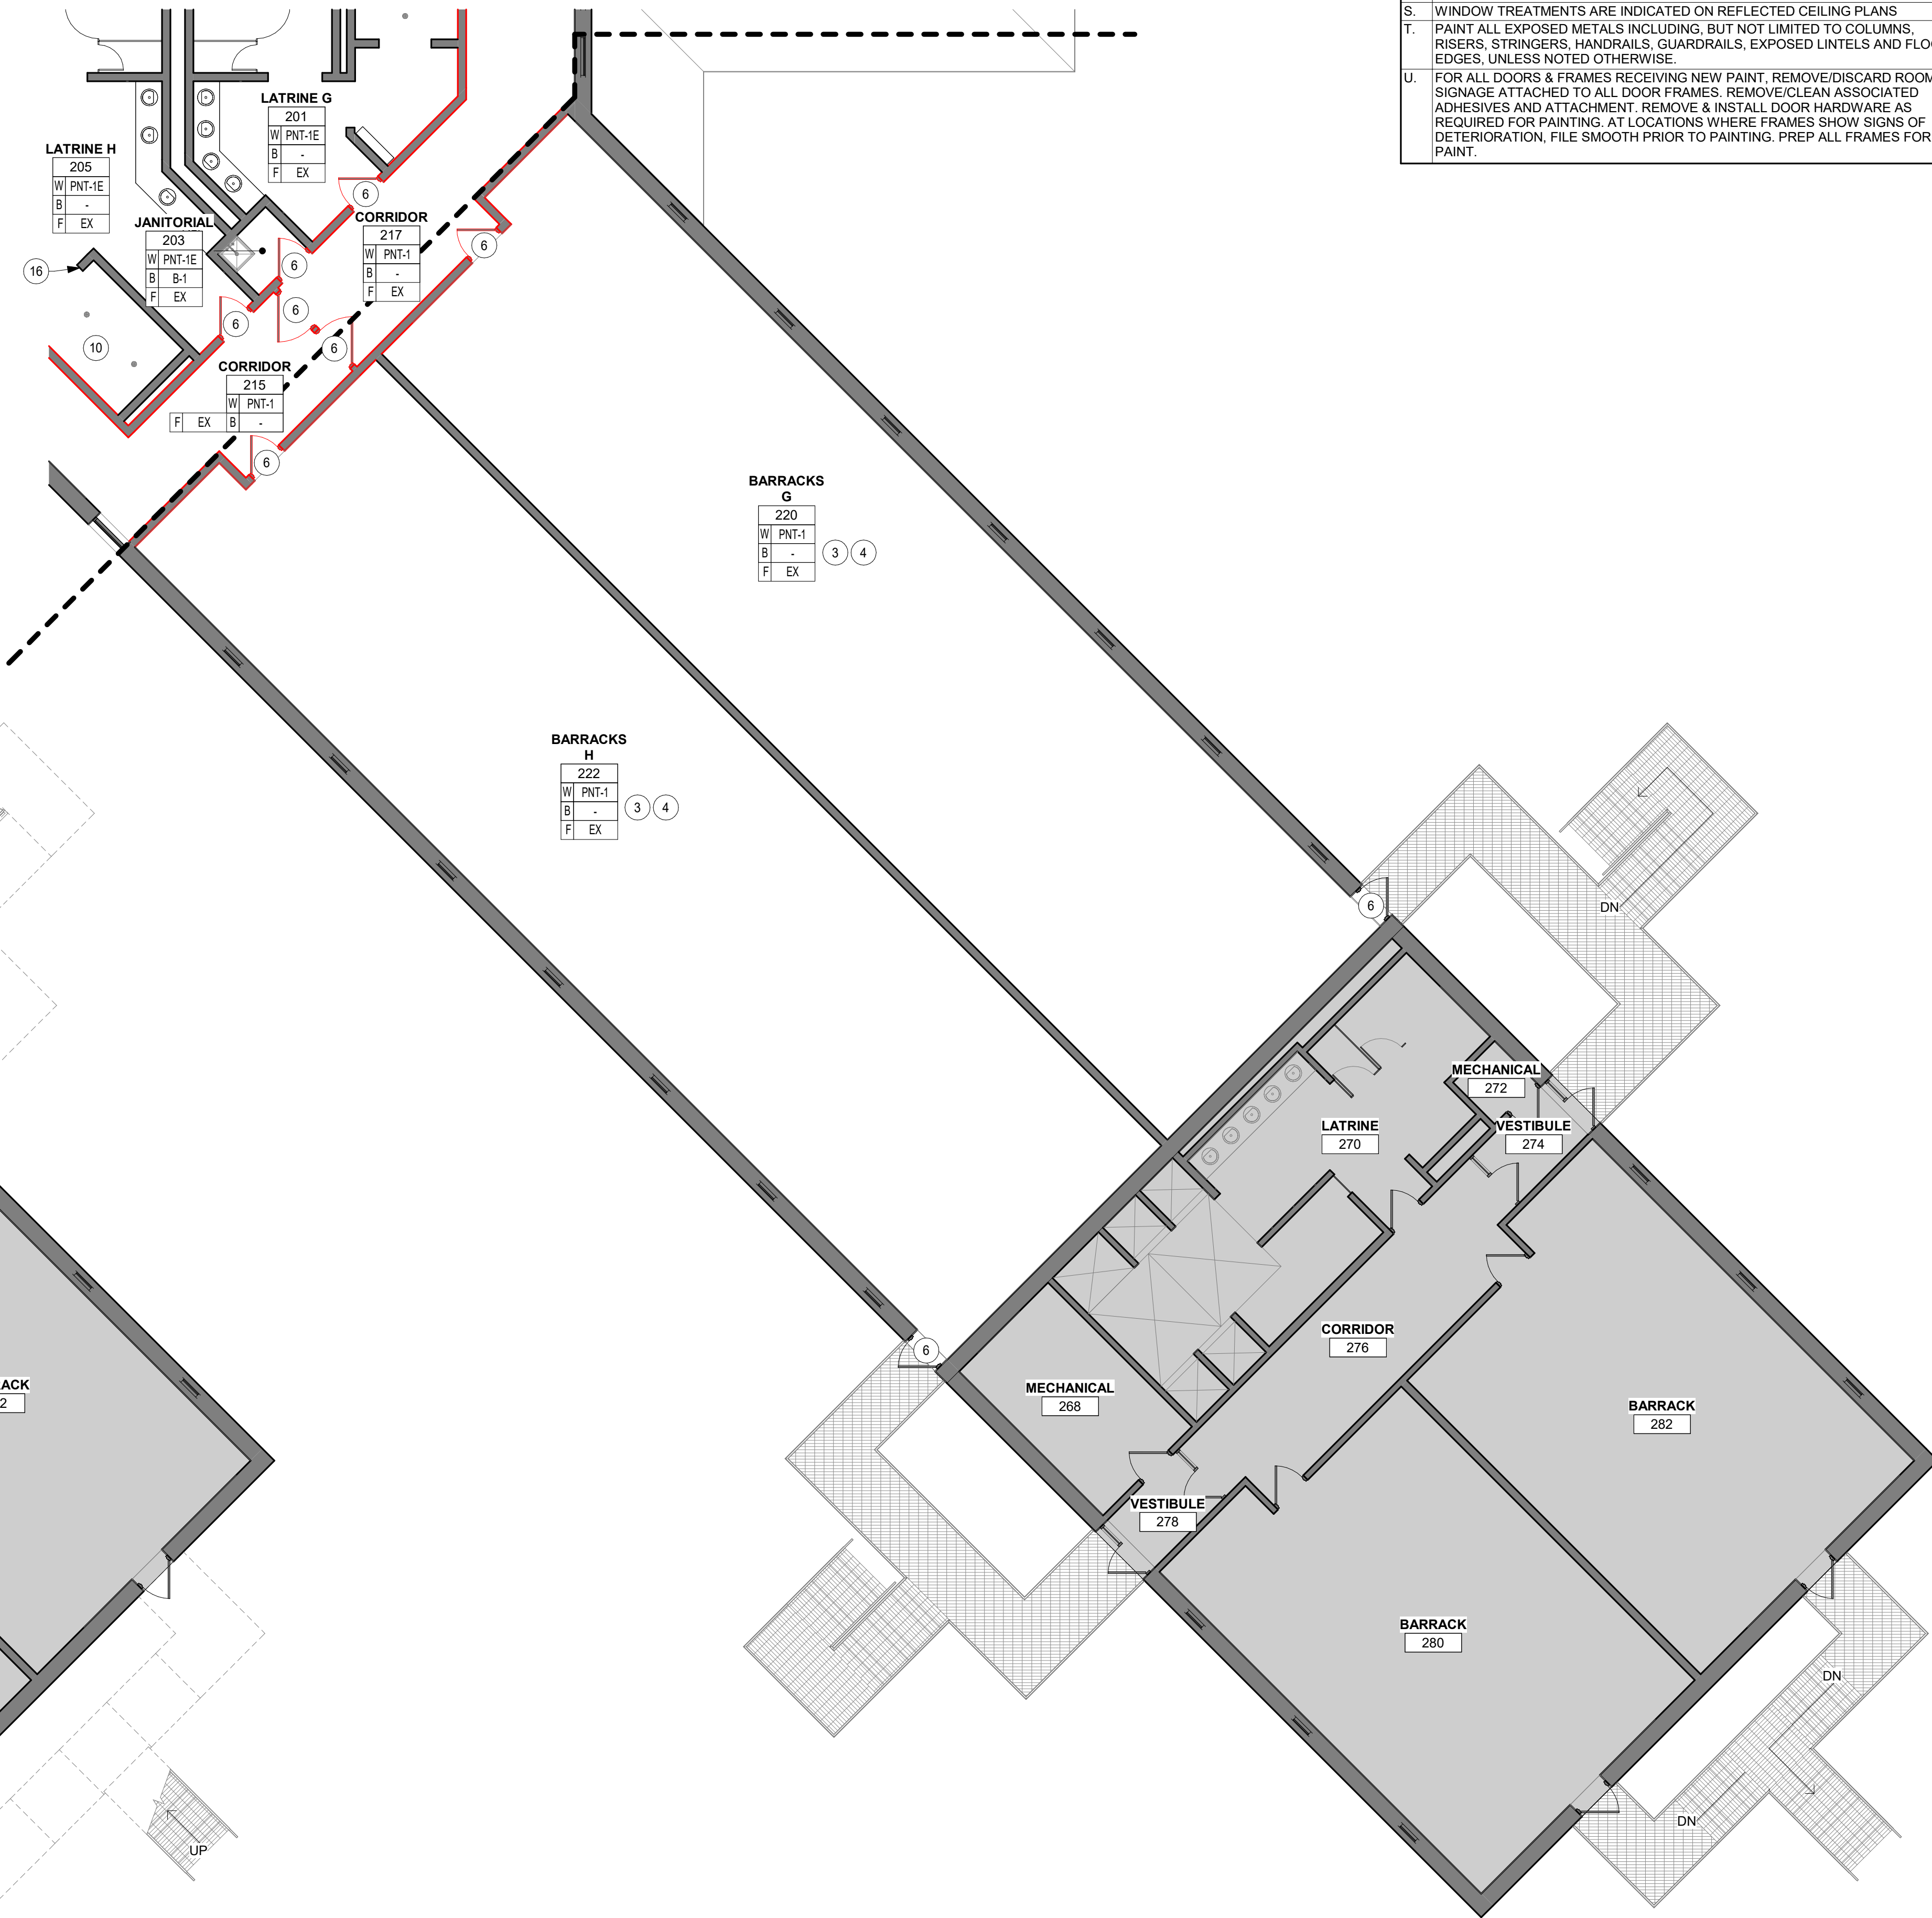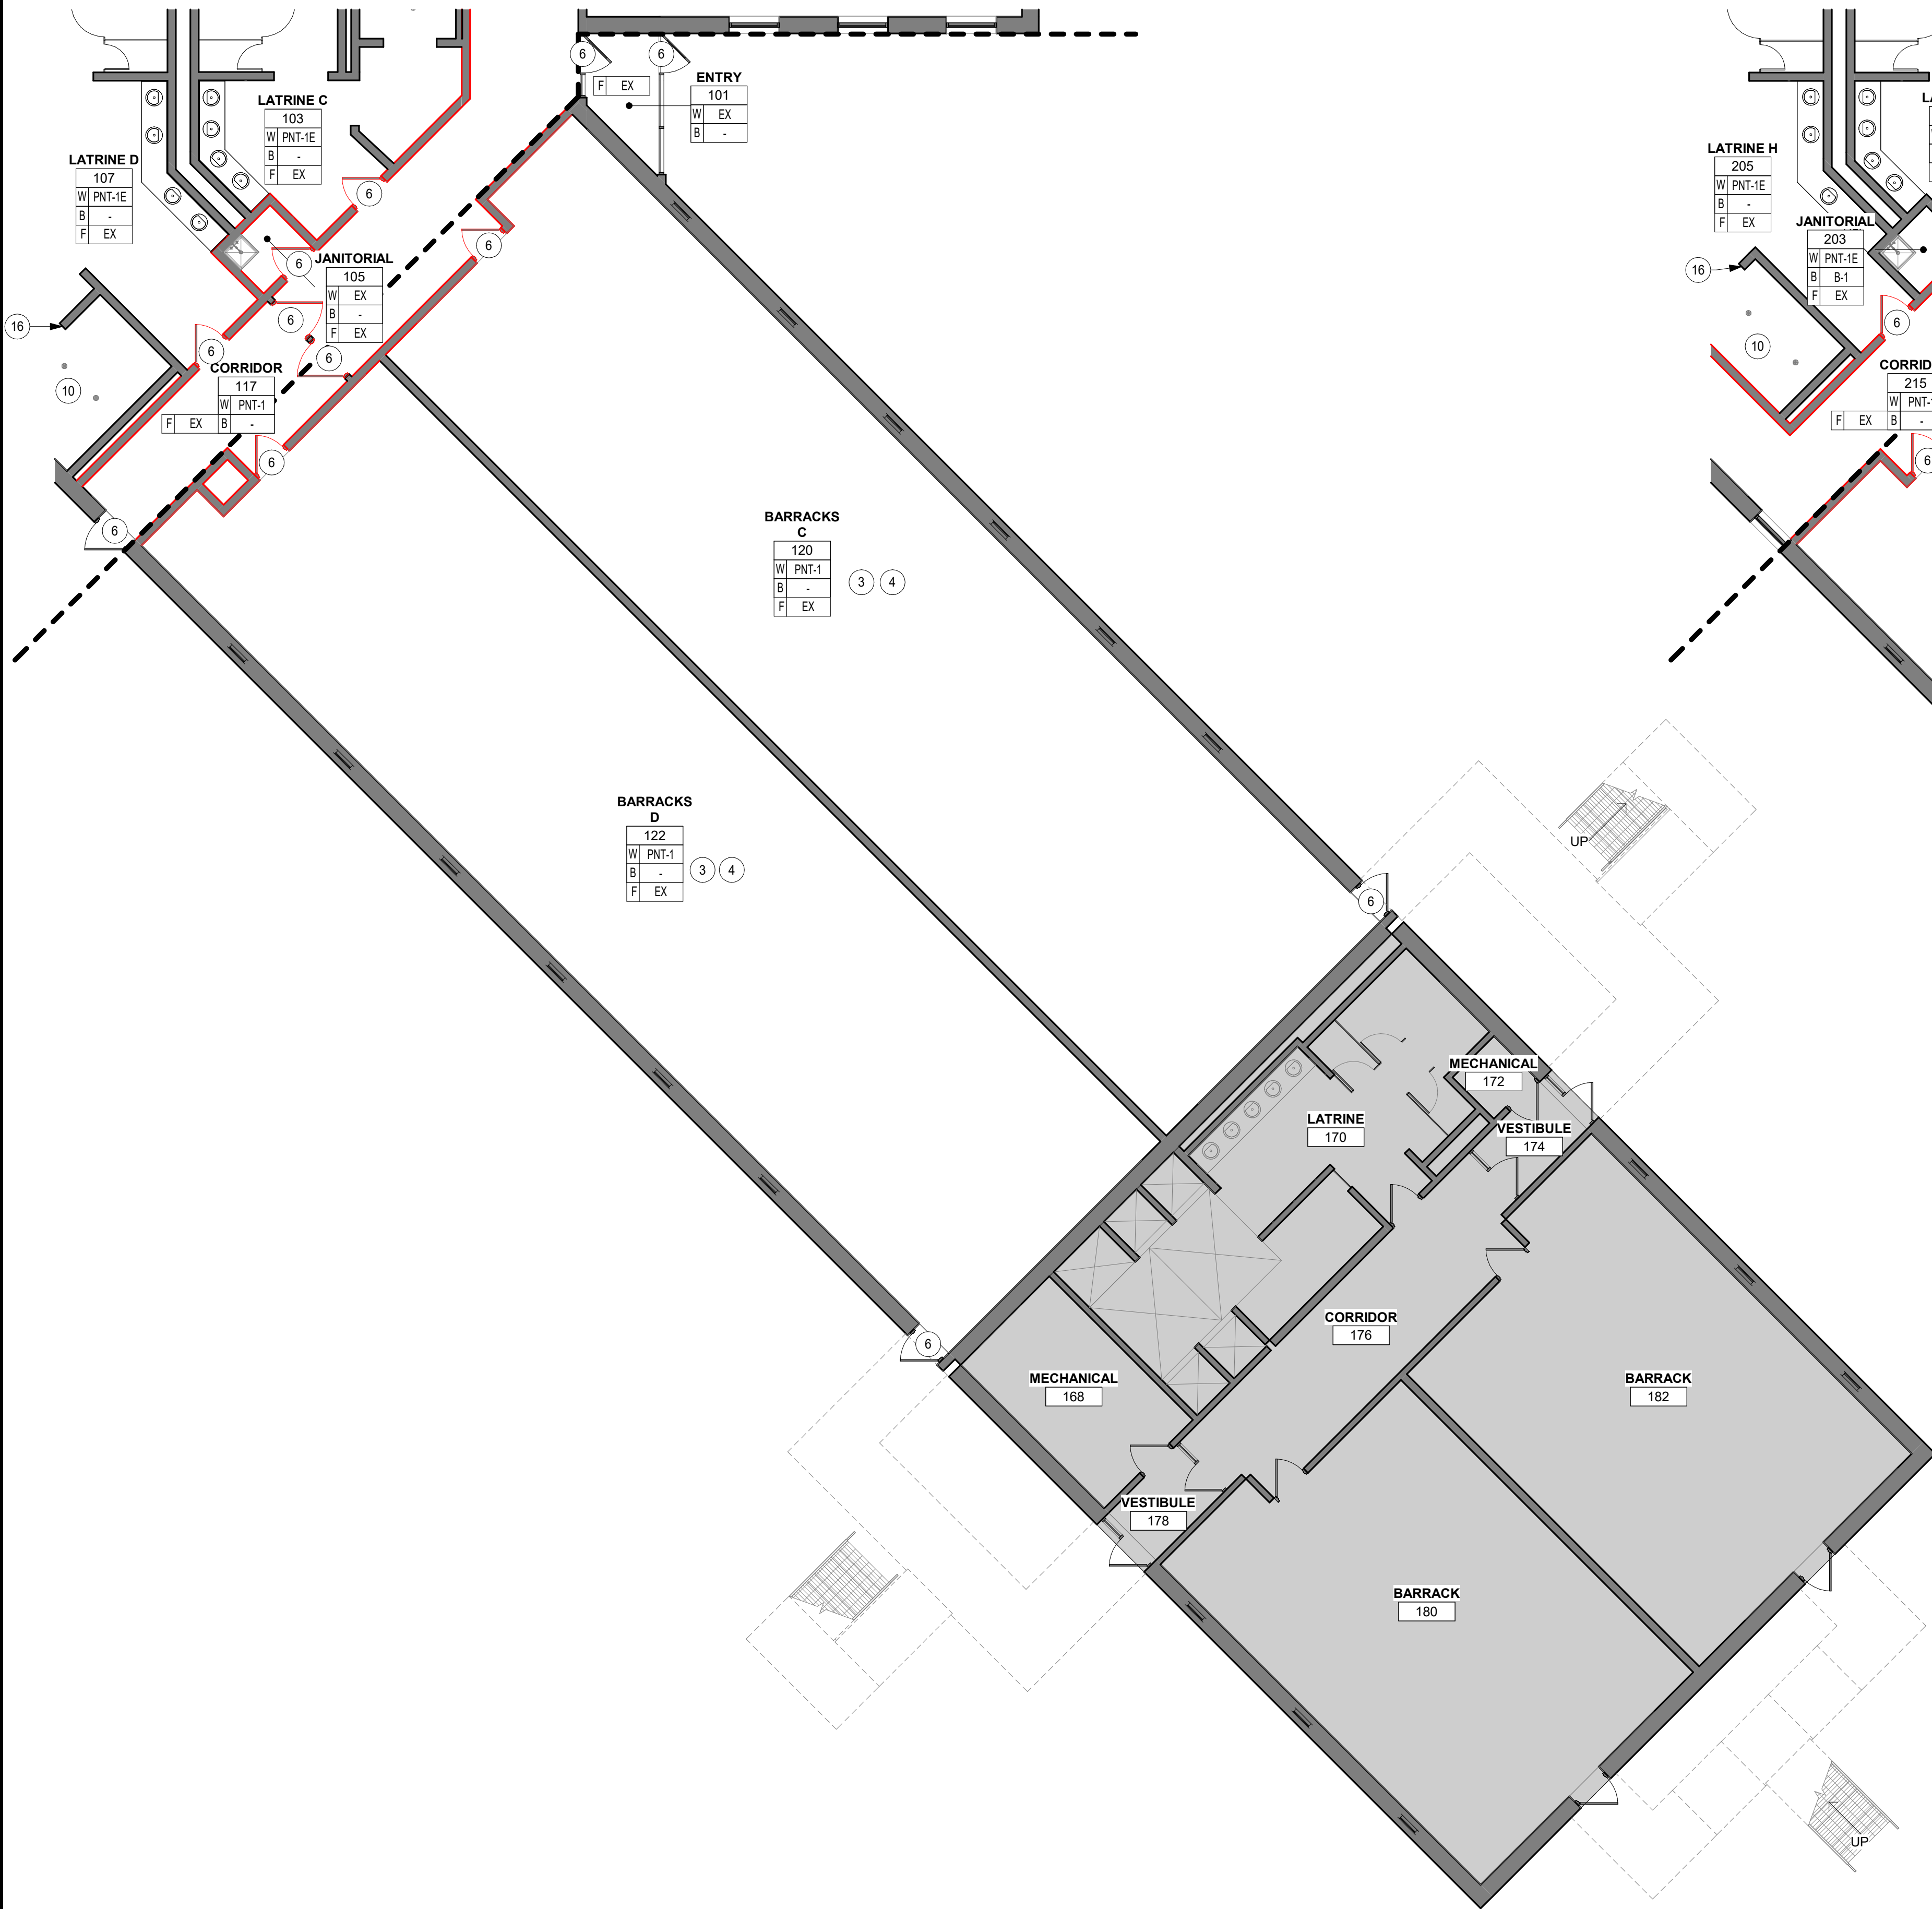

1 FIRST FLOOR FINISH PLAN - AREA B
1/8" = 1'-0"

 2 SECOND FLOOR FINISH PLAN - AREA B
1/8" = 1'-0"




REFERENCE SCALE
1" = 1'-0"
0 1/4" 1/2" 1" 2"

9/8/2026 3:14:54 PM


REFERENCE SCALE
1" = 1'-0"
0 1/4" 1/2" 1" 2"

1 SECOND FLOOR FINISH PLAN - OVERALL
3/32" = 1'-0"

9/8/2026 3:14:56 PM

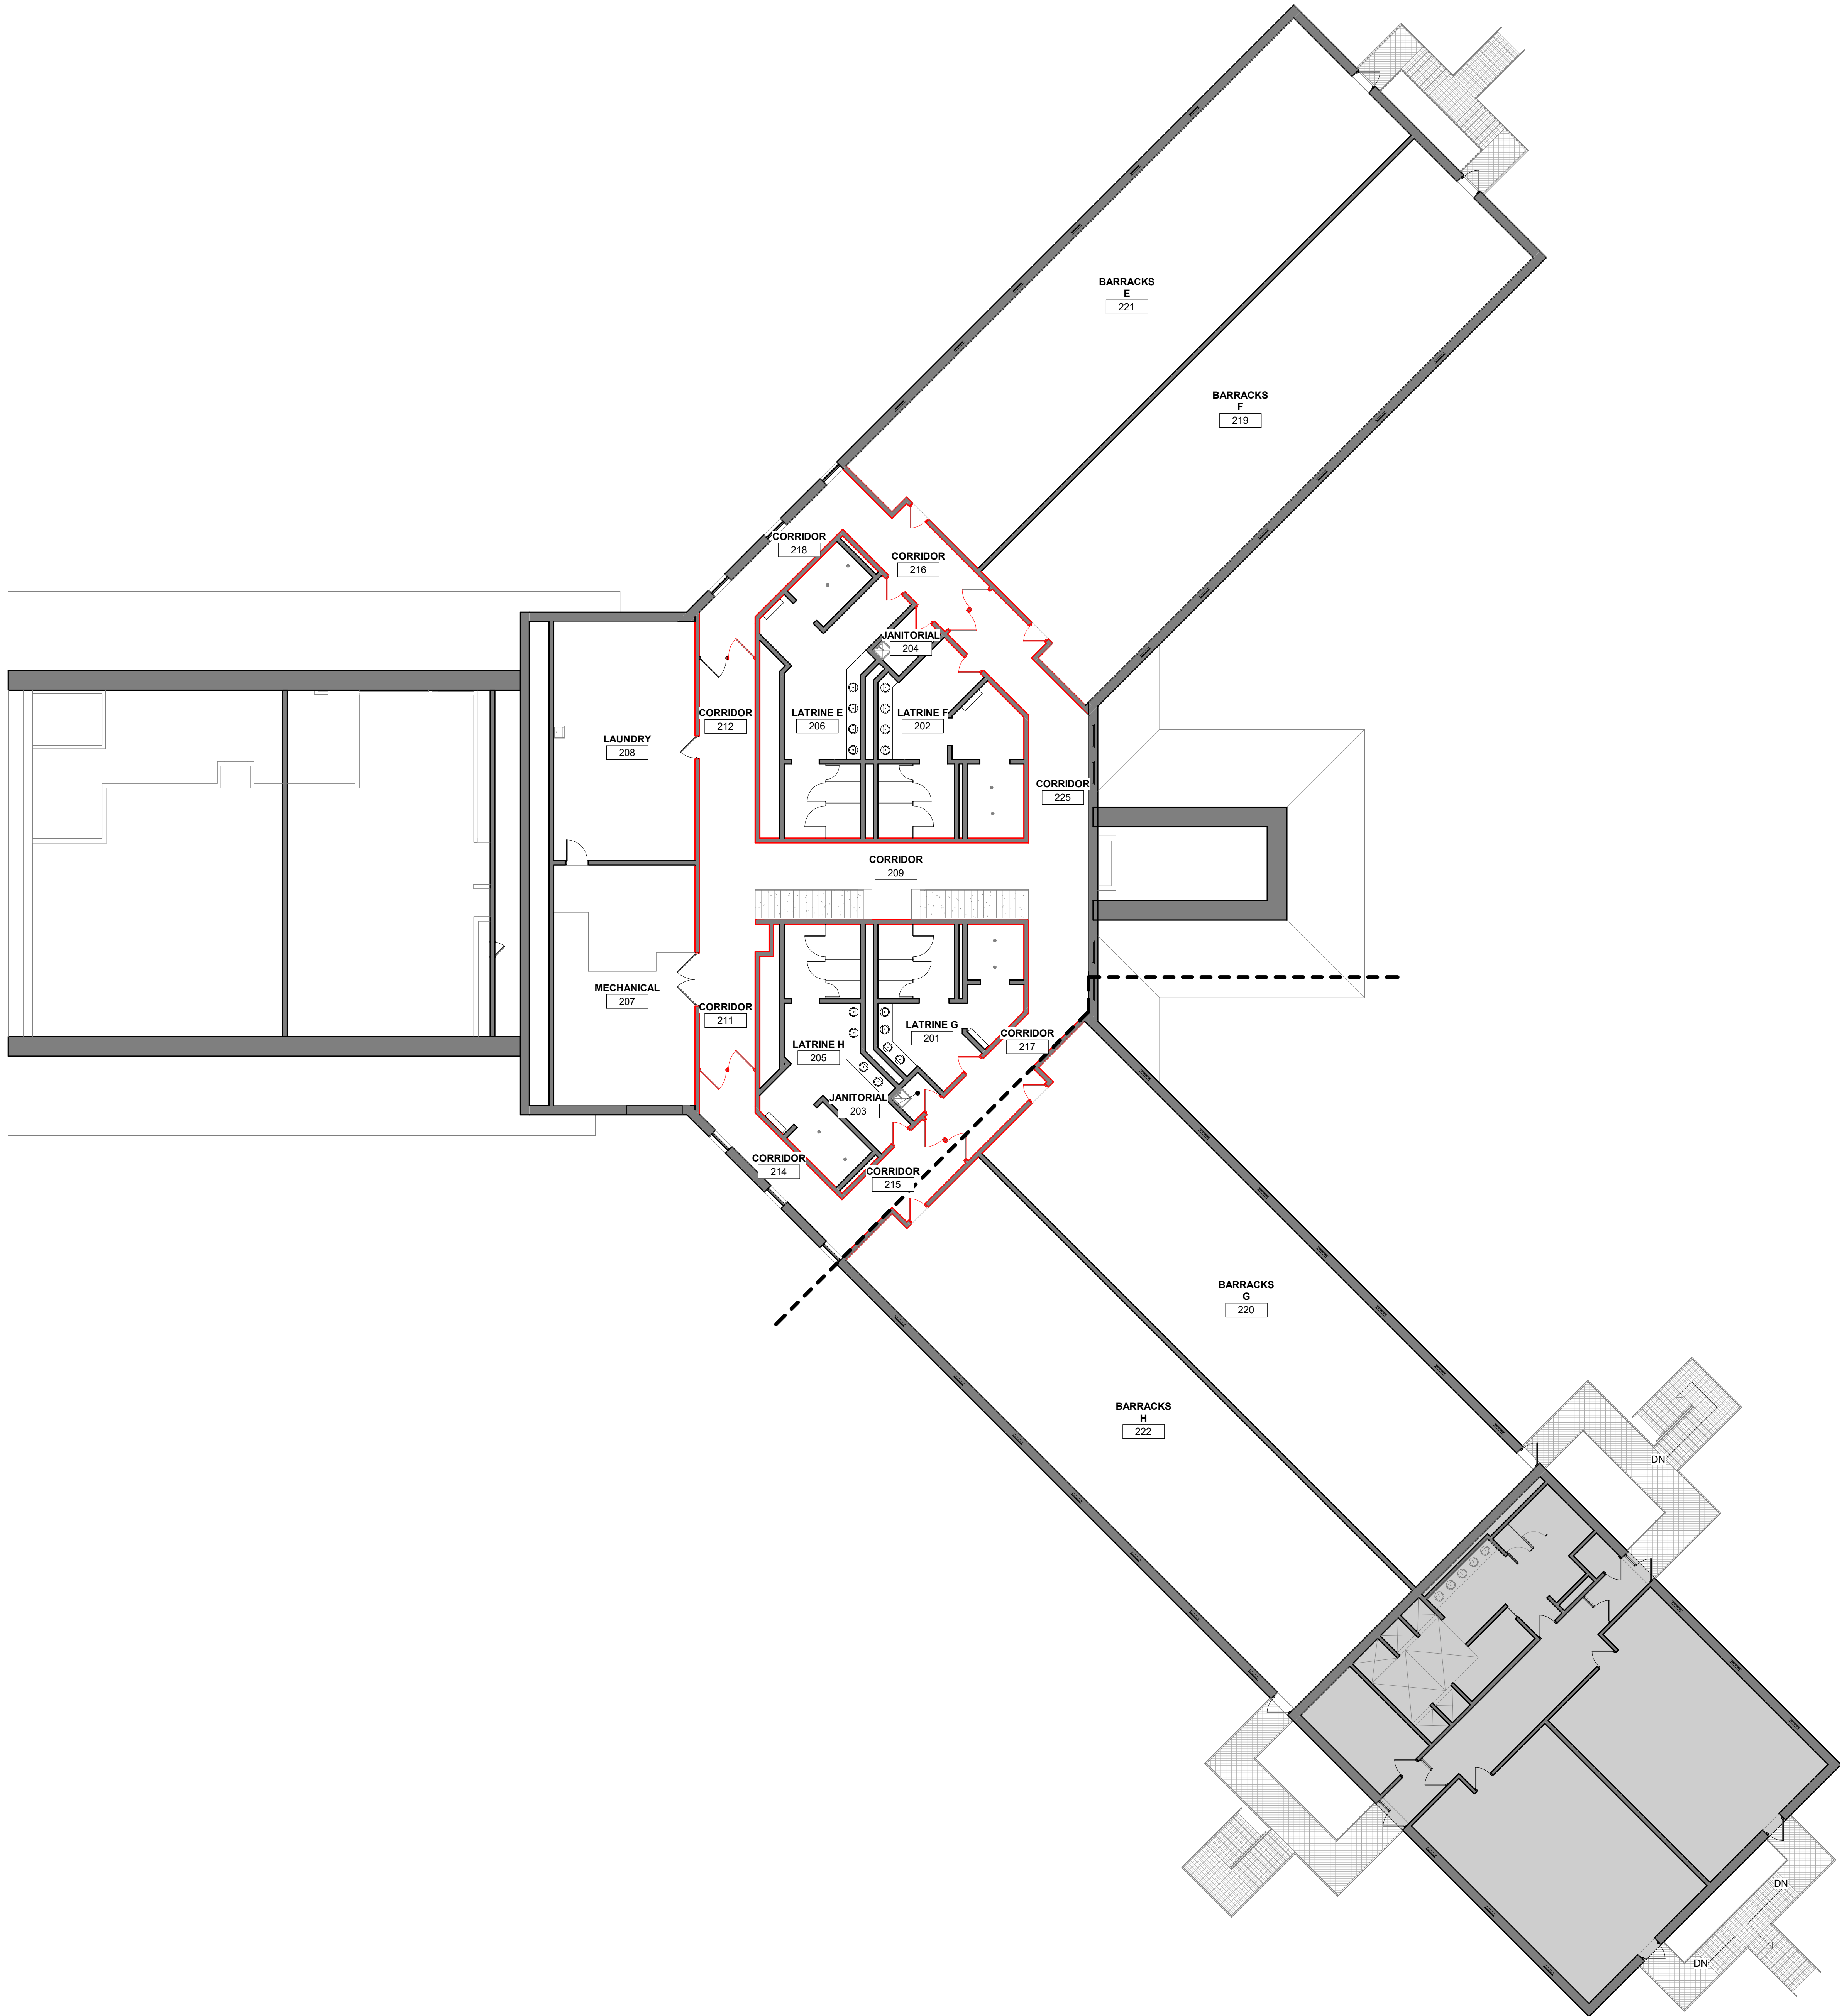

FLOOR PLAN LEGEND
SHADED REGION INDICATES AREA OF PLANS THAT ARE NOT INCLUDED IN SCOPE OF WORK.

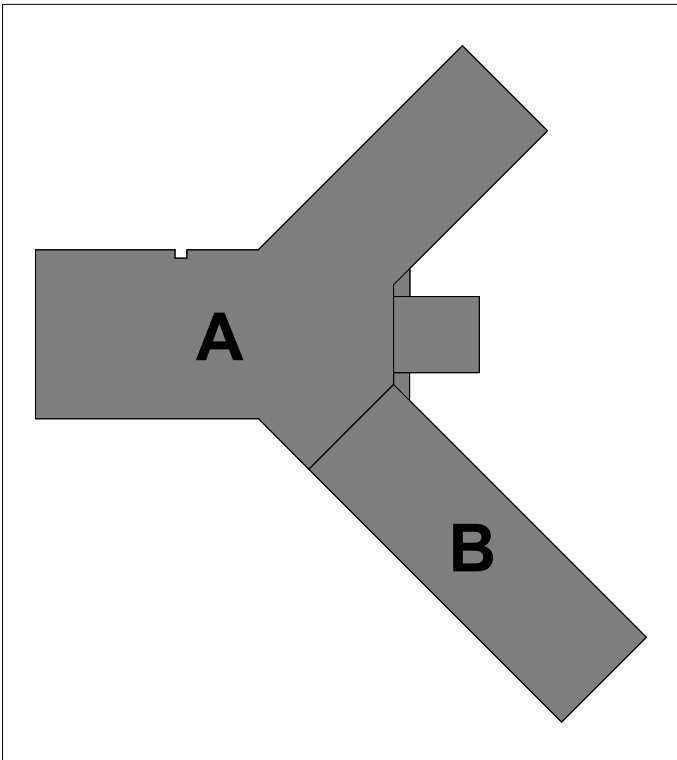

KEYPLAN

THIS DOCUMENT IS THE PROPERTY OF I & S GROUP, INC. AND MAY NOT BE USED, COPIED OR DUPLICATED WITHOUT PRIOR WRITTEN CONSENT.
© 2024 I & S GROUP, INC.

PROJECT

IOWA ARMY
NATIONAL GUARD
S54 FINISH
UPGRADES

CAMP DODGE, JOHNSTON IOWA

REVISION SCHEDULE		
DATE	DESCRIPTION	BY


PROJECT NO.	26-34920
FILE NAME	34920 Arch R26
DRAWN BY	LAD
DESIGNED BY	LAD
REVIEWED BY	LDB
ORIGINAL ISSUE DATE	09/08/26
CLIENT PROJECT NO.	19083733

TITLE


SECOND FLOOR
FINISH PLAN -
OVERALL

SHEET

 11-22



1 SECOND FLOOR FINISH PLAN - AREA A
1/8" = 1'-0"

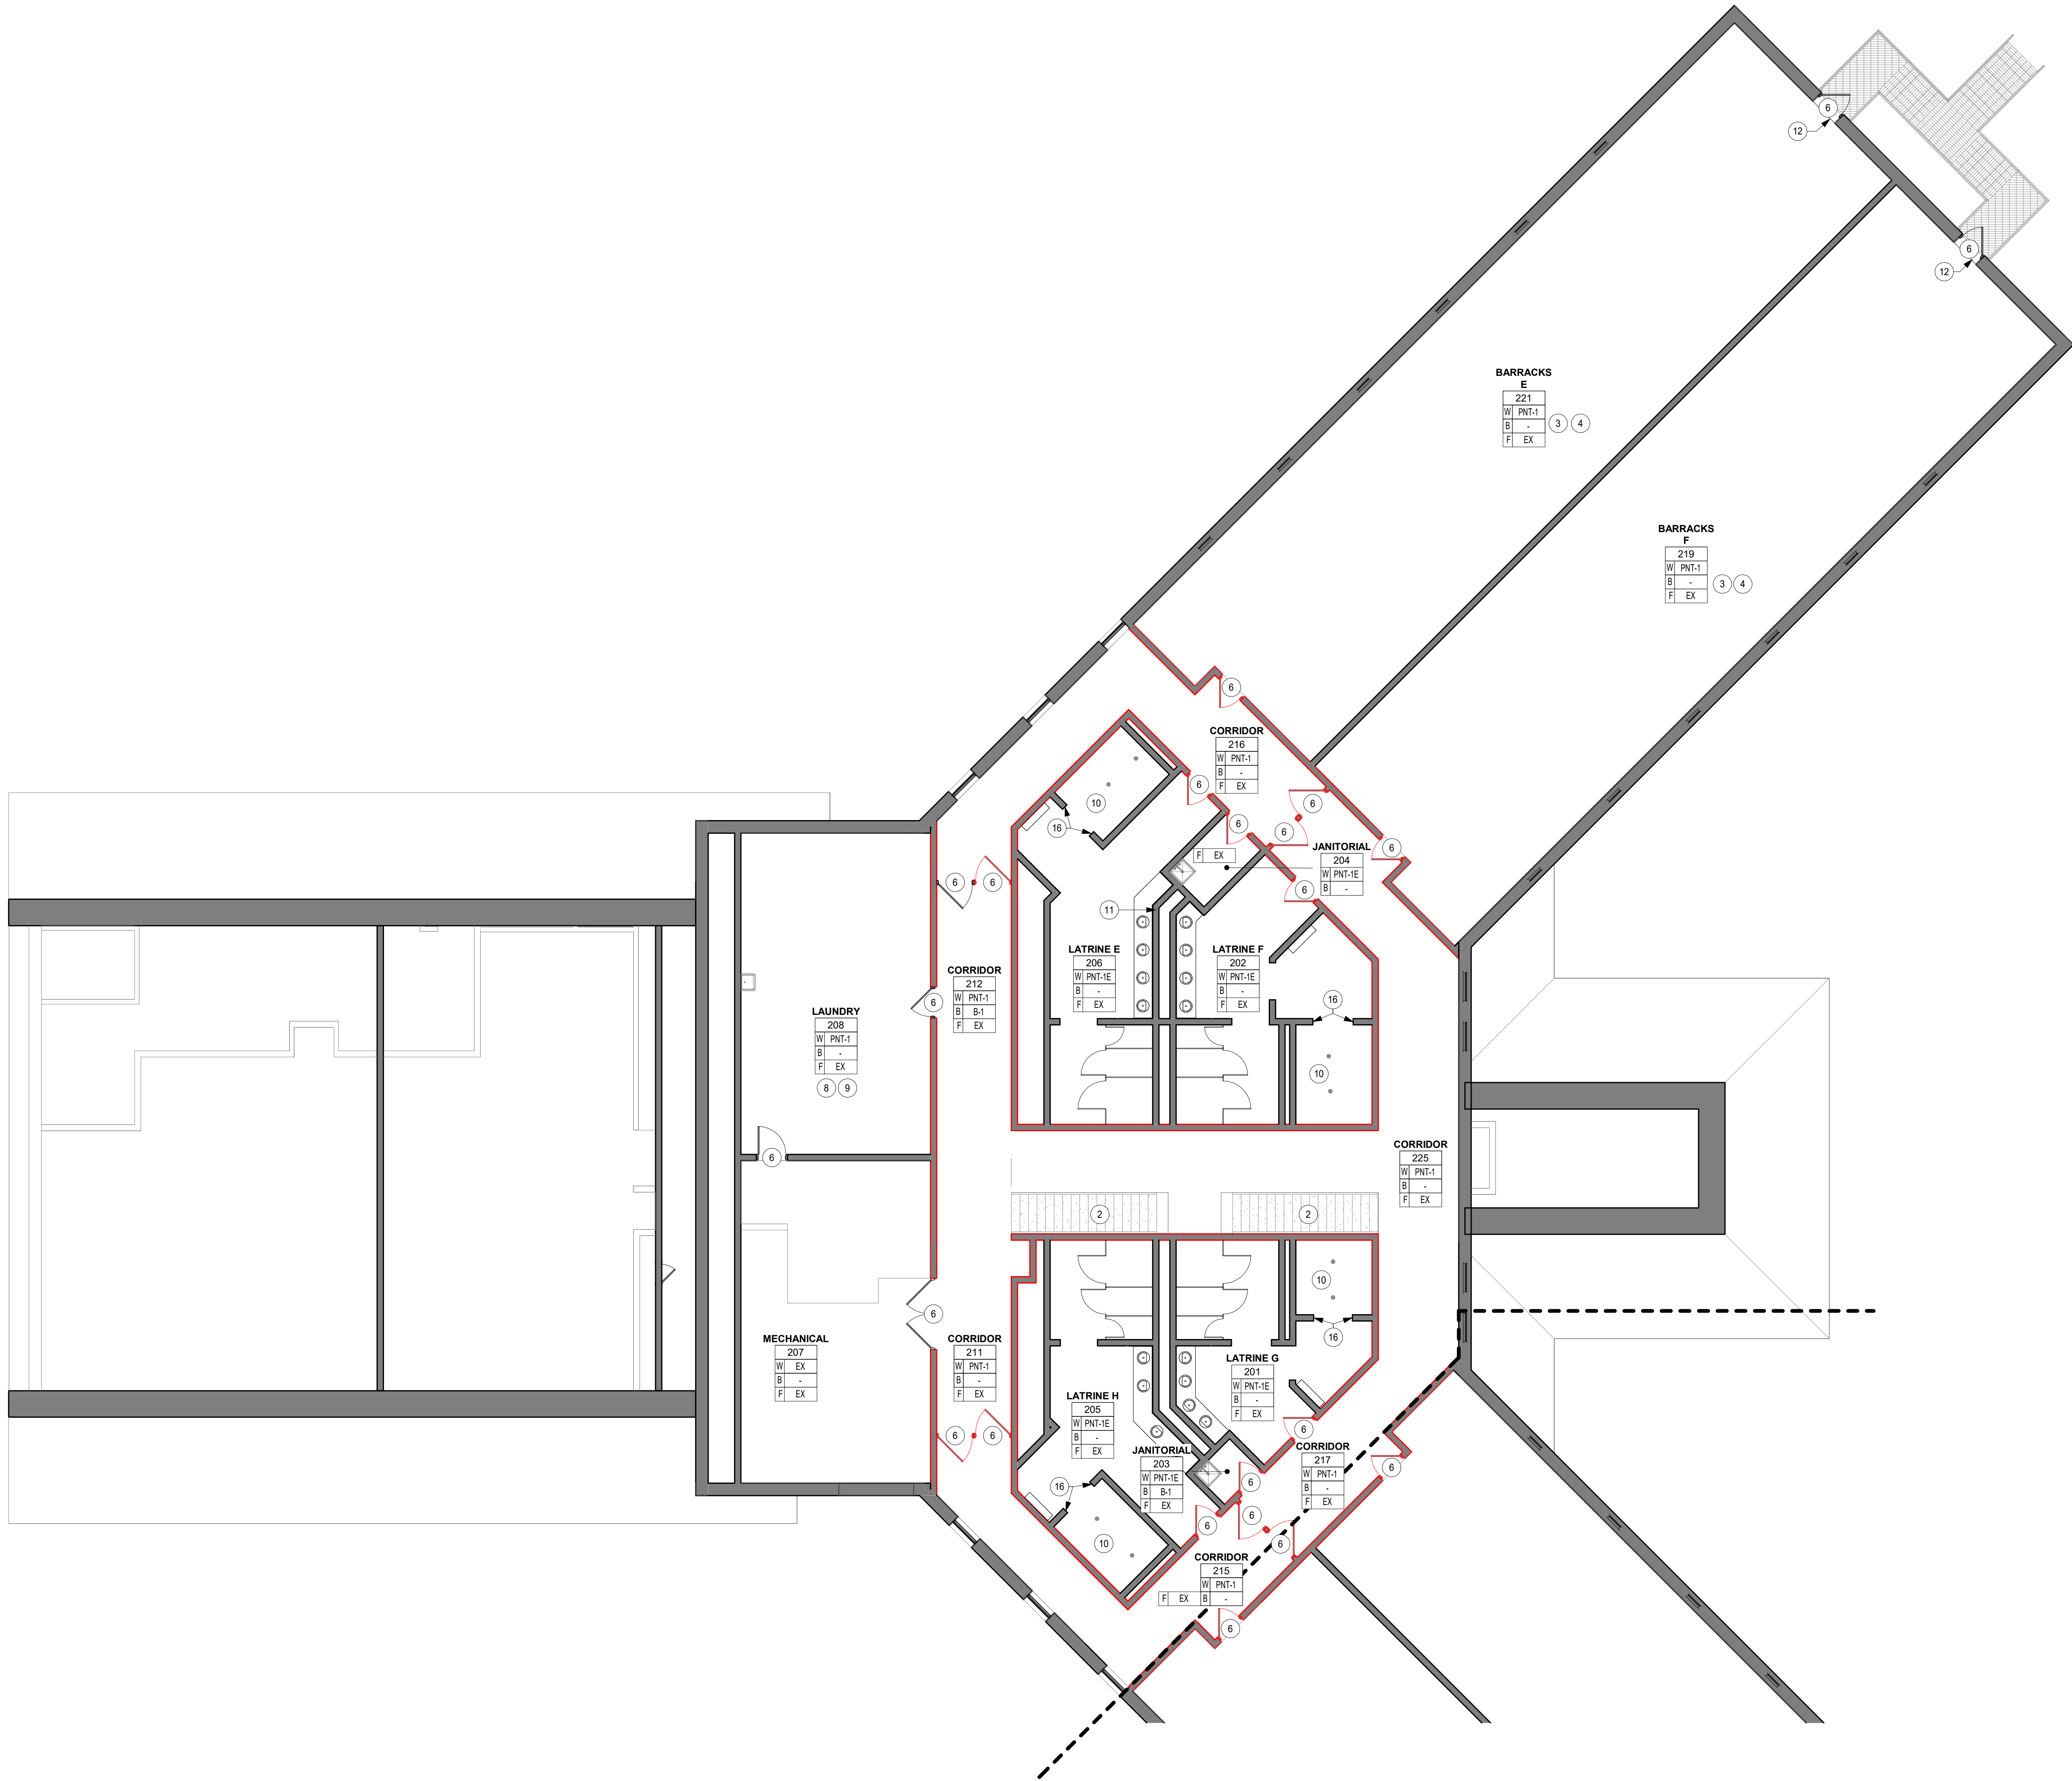

FINISH NOTES

- A. SOME SPECIFIED PRODUCTS AND FINISHES MAY HAVE SUBSTANTIAL LEAD TIMES. THE CONTRACTOR SHALL BE RESPONSIBLE FOR PLACING ORDERS IN A MANNER TO ENSURE THEIR TIMELY ARRIVAL. THE CONTRACTOR SHALL BE RESPONSIBLE FOR EXPENSES, INCLUDING DESIGN FEES, RELATED TO ANY RESELECTION REQUIRED DUE TO FAILURE TO ORDER PRODUCTS IN A TIMELY MANNER.
- B. ALL FINISH WORK SHALL BE PERFORMED IN COMPLIANCE WITH DRAWINGS AND SPECIFICATIONS. SHOP DRAWINGS, SAMPLES, AND PRODUCT DATA SHALL BE SUBMITTED TO THE ARCHITECT FOR THEIR REVIEW & APPROVAL PRIOR TO BEGINNING WORK.
- C. ALL WALLS TO RECEIVE PNT-1, UNLESS NOTED OTHERWISE.
- D. BULKHEADS AND SOFFITS: ALL SIDES AND UNDERSIDES TO BE PAINTED AS INDICATED ON REFLECTED CEILING PLANS, UNLESS NOTED OTHERWISE.
- E. REFER TO REFLECTED CEILING PLANS FOR CEILING/SOFFT FINISHES AND LOCATIONS.
- F. PAINT ALL EXPOSED DUCTWORK, CONDUIT, ELECTRICAL EQUIPMENT, GRILLES, VENTS, METAL ACCESS PANELS, ETC., TO MATCH ADJACENT SURFACES, UNLESS NOTED OTHERWISE.
- G. DO NOT PAINT VALVES, SENSORS, RELAYS, OR ACTUATORS.
- H. EXISTING SURFACES TO BE PATCHED AND PREPPED FOR PAINTING AS REQUIRED.
- I. MECHANICAL/ELECTRICAL ROOMS WILL NOT RECEIVE ANY NEW PAINTING ON WALLS OR CEILINGS.
- J. FIRE EXTINGUISHER CABINETS WILL NOT RECEIVE ANY NEW PAINTING.
- K. REMOVE AND REINSTALL SIGNAGE AS REQUIRED FOR PAINTING SCOPE.
- L. WALL MOUNTED ITEMS MAY BE PAINTED AROUND, UNLESS NOTED OTHERWISE.
- M. IN-WALL OR WALL SUPPORT BRACKETS TO BE PAINTED TO MATCH WALL FINISH, UNLESS NOTED OTHERWISE.
- N. PLUMBING FIXTURES HAVE BEEN REMOVED FROM FINISH PLAN FOR VIEWING CLARITY. REFER TO THE RESPECTIVE PLANS AND DOCUMENTS FOR PLUMBING CRITERIA.
- O. UNLESS OTHERWISE INDICATED, PROVIDE PRODUCTS OF QUALITY SPECIFIED BY AWI/AWMAC/WI ARCHITECTURAL WOODWORK STANDARDS FOR CUSTOM GRADE.
- P. HOLLOW METAL DOORS, FRAMES, AND HANDRAILS TO BE PAINTED PNT-3.
- Q. 'E' AT END OF PAINT TAG DESIGNATES TO USE EPOXY PAINT AT THIS LOCATION.
- R. COORDINATE ALL BRACKETS WITH OUTLET LOCATIONS UNDER COUNTER.
- S. WINDOW TREATMENTS ARE INDICATED ON REFLECTED CEILING PLANS.
- T. PAINT ALL EXPOSED METALS INCLUDING, BUT NOT LIMITED TO COLUMNS, RISERS, STRINGERS, HANDRAILS, GUARDRAILS, EXPOSED LINTELS AND FLOOR EDGES, UNLESS NOTED OTHERWISE.
- U. FOR ALL DOORS & FRAMES RECEIVING NEW PAINT, REMOVE/DISCARD ROOM SIGNAGE ATTACHED TO ALL DOOR FRAMES. REMOVE/CLEAN ASSOCIATED ADHESIVES AND ATTACHMENT. REMOVE & INSTALL DOOR HARDWARE AS REQUIRED FOR PAINTING. AT LOCATIONS WHERE FRAMES SHOW SIGNS OF DETERIORATION, FILE SMOOTH PRIOR TO PAINTING. PREP ALL FRAMES FOR PAINT.

ROOM / FINISH TAG

ROOM NAME	
ROOM #	
W WALL	
B BASE	
F FLOOR	

FINISHES LISTED IN ROOM TAG APPLY TO ALL ELEMENTS IN ROOM, UNLESS NOTED OTHERWISE

KEYNOTE LEGEND

- 2 PAINT ALL STAIR HANDRAILS, GUARDRAILS, RISERS AND STRINGERS PNT-3.
- 3 PAINT ALL HOLLOW METAL INTERIOR WINDOW FRAMES PNT-3.
- 4 CONTRACTOR TO COORDINATE MOVING FURNITURE WITH OWNER. PROTECT ALL FURNITURE DURING CONSTRUCTION.
- 6 PAINT BOTH SIDES OF HOLLOW METAL DOORS AND FRAMES. REFER TO INTERIOR FINISH SCHEDULE. REFER TO FINISH NOTES ON REQUIRED DOOR PREP.
- 8 LAUNDRY DRYER DUCTWORK TO REMAIN UNPAINTED.
- 9 CONTRACTOR/PLUMBER TO TURN OFF GAS AND DISCONNECT LAUNDRY MACHINES/EQUIPMENT FOR MOVING. CONTRACTOR TO COORDINATE MOVING OF LAUNDRY MACHINES/EQUIPMENT WITH OWNER. PROTECT ITEMS DURING CONSTRUCTION.
- 10 NO FINISH WORK EXCEPT CEILING PAINTING IN SHOWERS.
- 11 PAINT PIPES ON WALL ABOVE MIRROR PNT-1E.
- 12 PAINT STAINLESS STEEL CHASE ABOVE DOOR PNT-1 TO MATCH ADJACENT WALL.
- 16 NEW PAINT WORK TO STOP AT EXISTING PAINT LINE, CENTERED IN OPENING.

ISG

A

KEYPLAN

THIS DOCUMENT IS THE PROPERTY OF I & S GROUP, INC. AND MAY NOT BE USED, COPIED OR DUPLICATED WITHOUT PRIOR WRITTEN CONSENT.
© 2024 I & S GROUP, INC.

PROJECT

IOWA ARMY
NATIONAL GUARD
S54 FINISH
UPGRADES

CAMP DODGE, JOHNSTON IOWA

REVISION SCHEDULE

DATE	DESCRIPTION	BY


PROJECT NO. 26-34920
FILE NAME 34920 Arch R26
DRAWN BY LAD
DESIGNED BY LAD
REVIEWED BY LDB
ORIGINAL ISSUE DATE 09/08/26
CLIENT PROJECT NO. 19083733

TITLE

SECOND FLOOR
FINISH PLAN -
AREA A


SHEET

11-22A

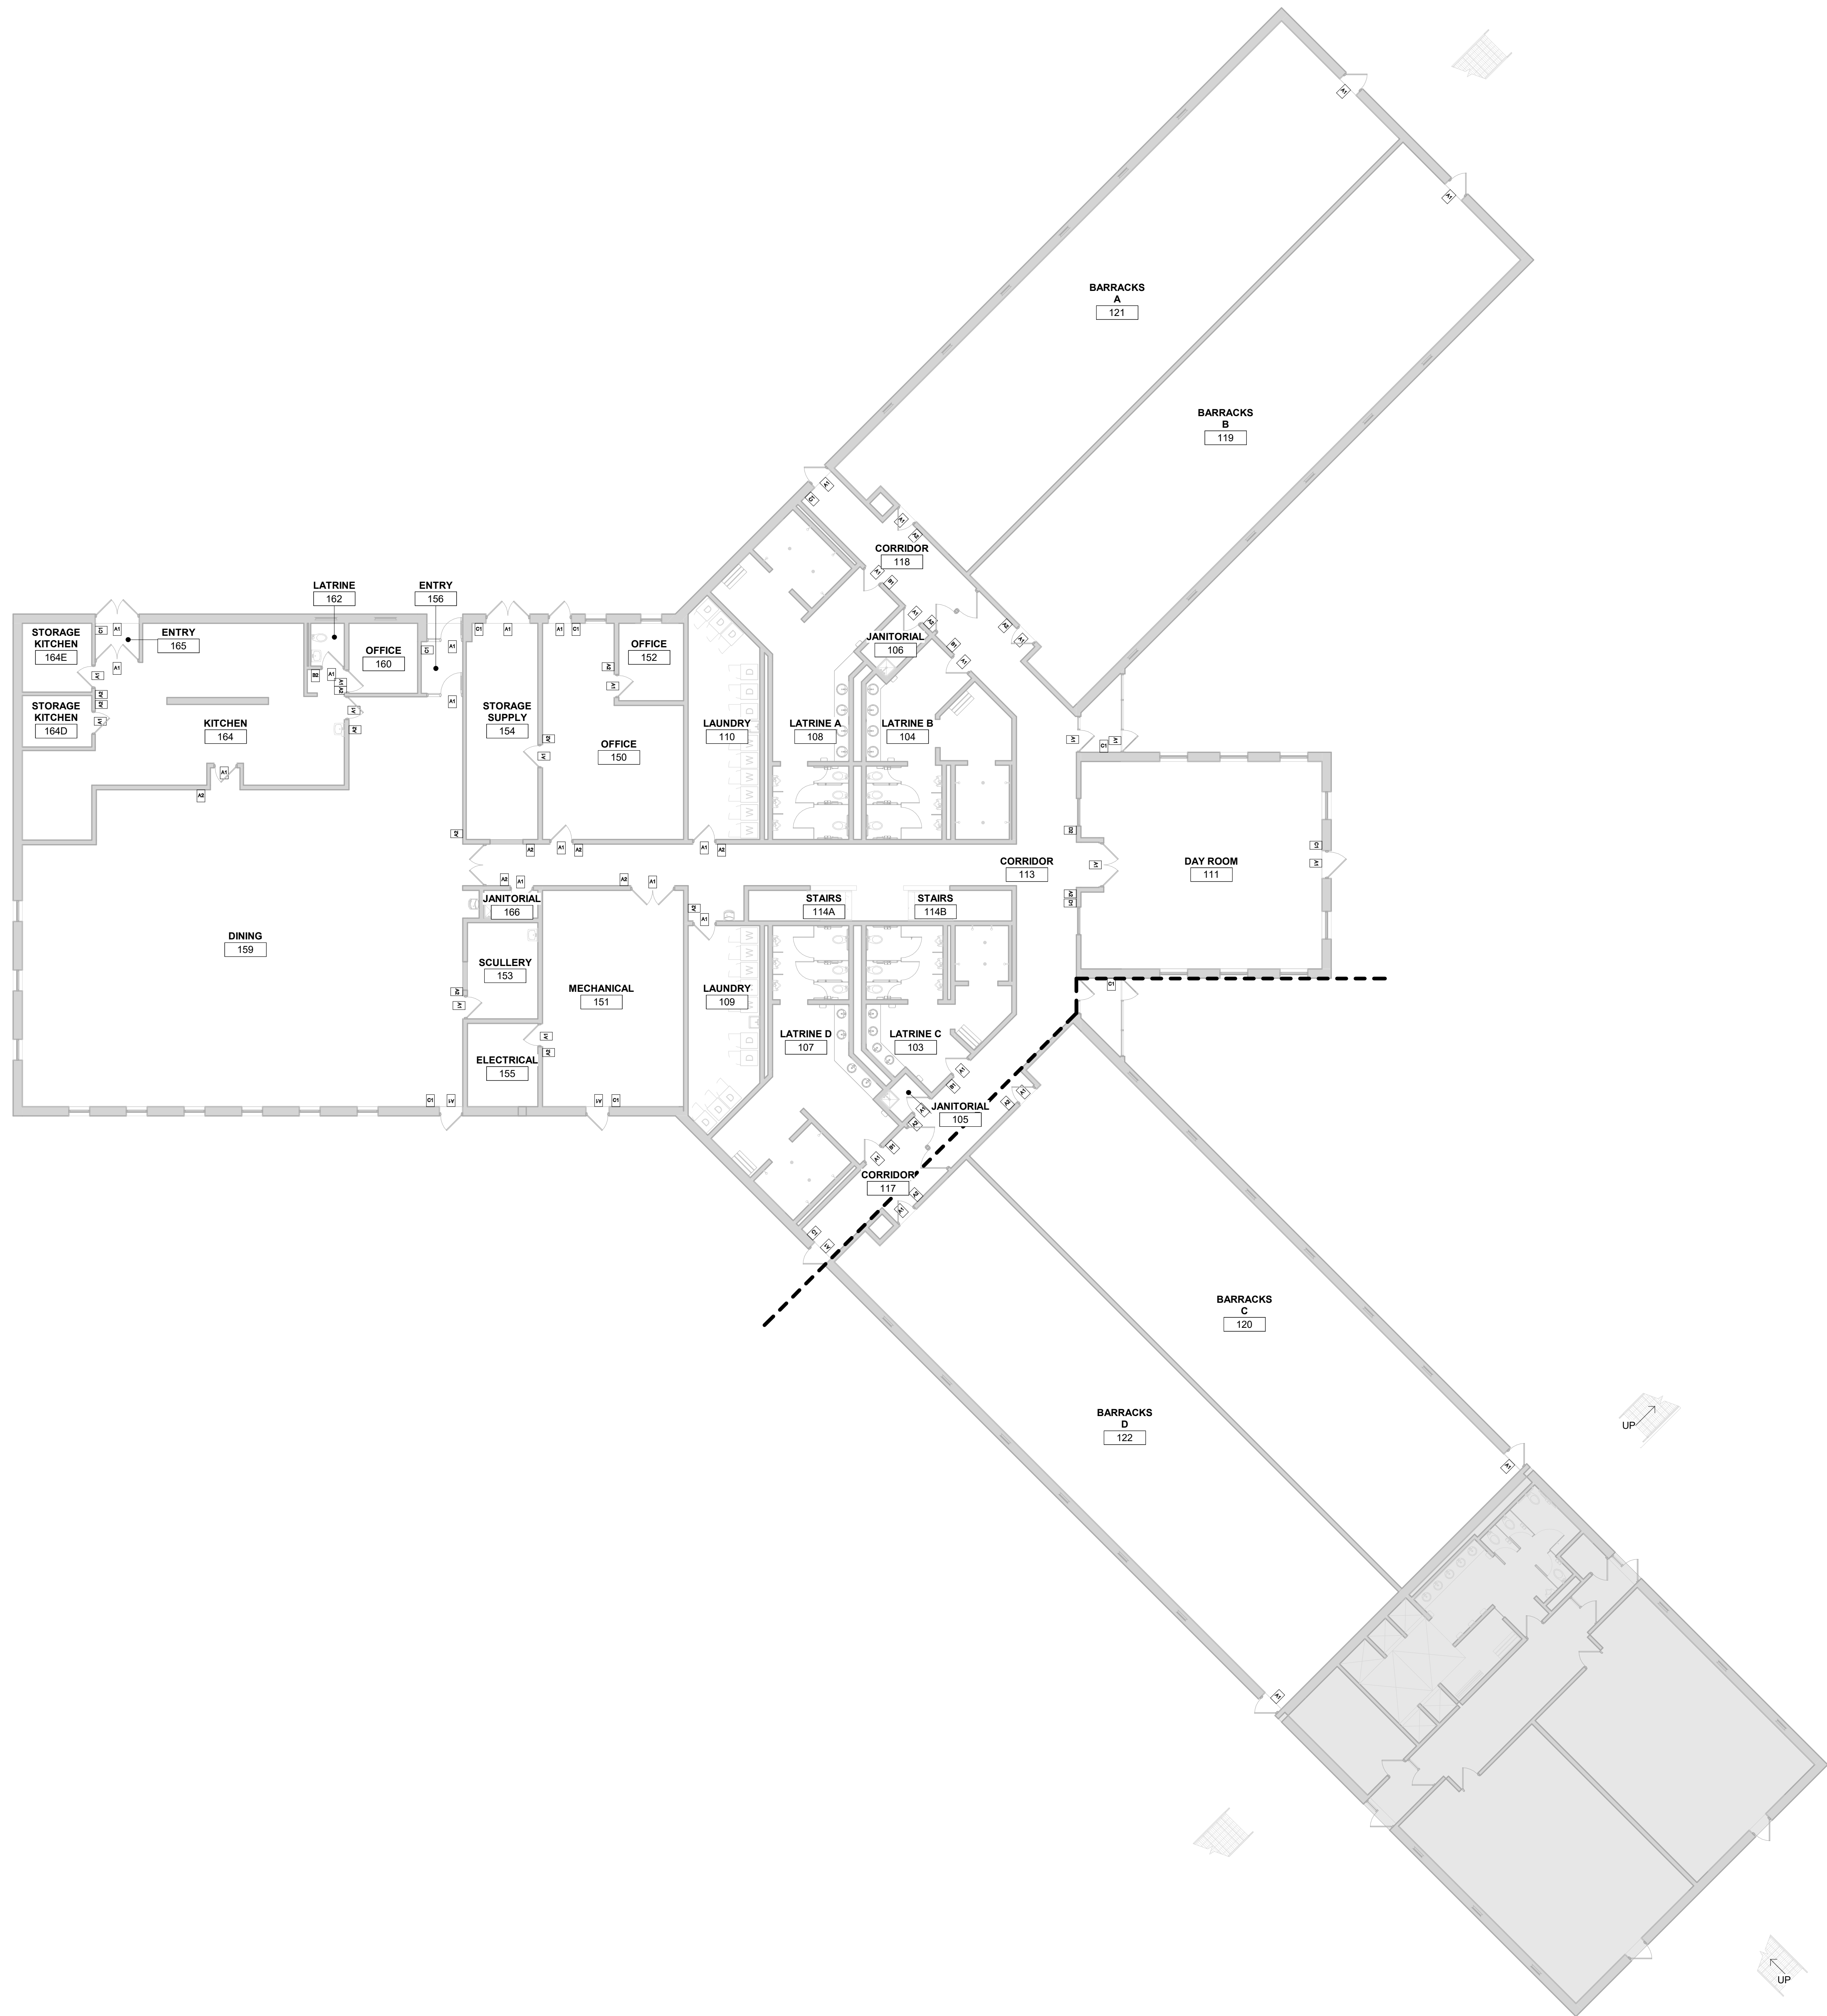

FLOOR PLAN LEGEND

SHADED REGION INDICATES AREA OF PLANS THAT ARE NOT INCLUDED IN SCOPE OF WORK.

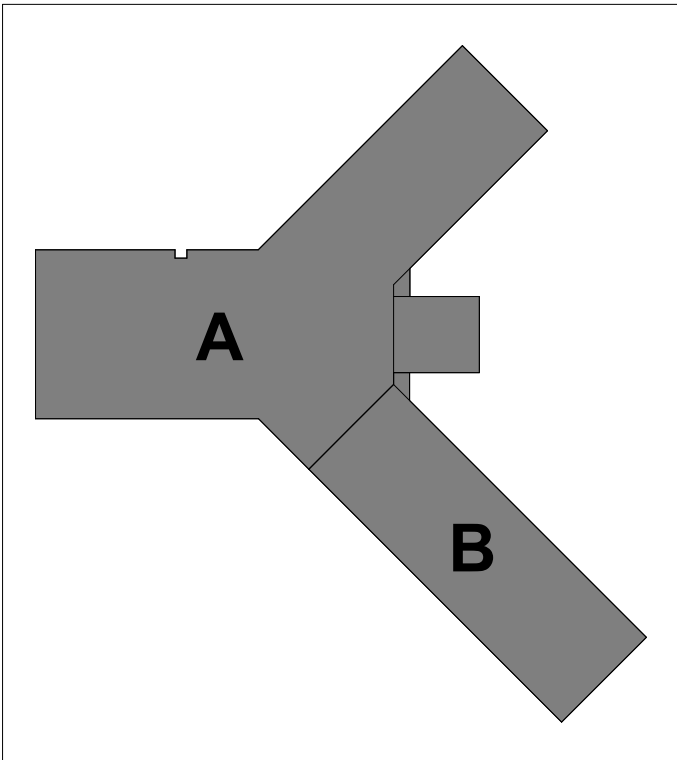

KEYPLAN

THIS DOCUMENT IS THE PROPERTY OF I & S GROUP, INC. AND MAY NOT BE USED, COPIED OR DUPLICATED WITHOUT PRIOR WRITTEN CONSENT.
© 2024 I & S GROUP, INC.

PROJECT

**IOWA ARMY
NATIONAL GUARD
S54 FINISH
UPGRADES**

CAMP DODGE, JOHNSTON IOWA

REVISION SCHEDULE		
DATE	DESCRIPTION	BY

PROJECT NO.	26-34920
FILE NAME	34920 Arch R26
DRAWN BY	LAD
DESIGNED BY	LAD
REVIEWED BY	LDB
ORIGINAL ISSUE DATE	09/08/26
CLIENT PROJECT NO.	19083733

TITLE


**FIRST FLOOR
SIGNAGE PLAN -
OVERALL**

SHEET

1 FIRST FLOOR SIGNAGE PLAN - OVERALL
3/32" = 1'-0"



KEYNOTE LEGEND	
18	D1 TO BE MOUNTED ABOVE A2.
19	D1 AND D2 SIGNS ON SAME WALL TO BE ALIGNED.
20	A2 SIGN FOR OFFICE 160 TO BE MOUNTED ON THE DOOR, CENTER IN WIDTH.

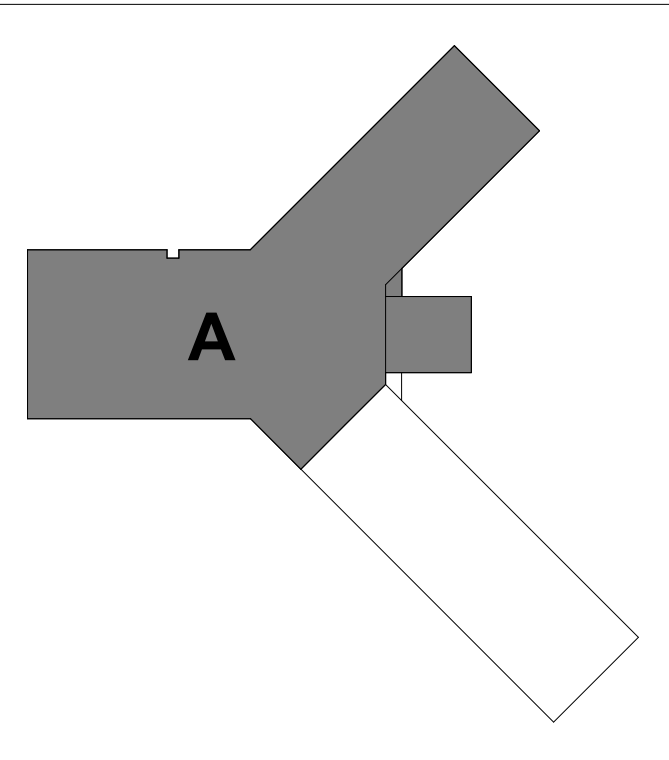

KEYPLAN

THIS DOCUMENT IS THE PROPERTY OF I & S GROUP, INC. AND MAY NOT BE USED, COPIED OR DUPLICATED WITHOUT PRIOR WRITTEN CONSENT.
© 2024 I & S GROUP, INC.

PROJECT

**IOWA ARMY
NATIONAL GUARD
S54 FINISH
UPGRADES**

CAMP DODGE, JOHNSTON IOWA

REVISION SCHEDULE		
DATE	DESCRIPTION	BY


PROJECT NO.	26-34920
FILE NAME	34920 Arch R26
DRAWN BY	LAD
DESIGNED BY	LAD
REVIEWED BY	LDB
ORIGINAL ISSUE DATE	09/08/26
CLIENT PROJECT NO.	19083733

TITLE

**FIRST FLOOR
SIGNAGE PLAN -
AREA A**

SHEET

I1-41A

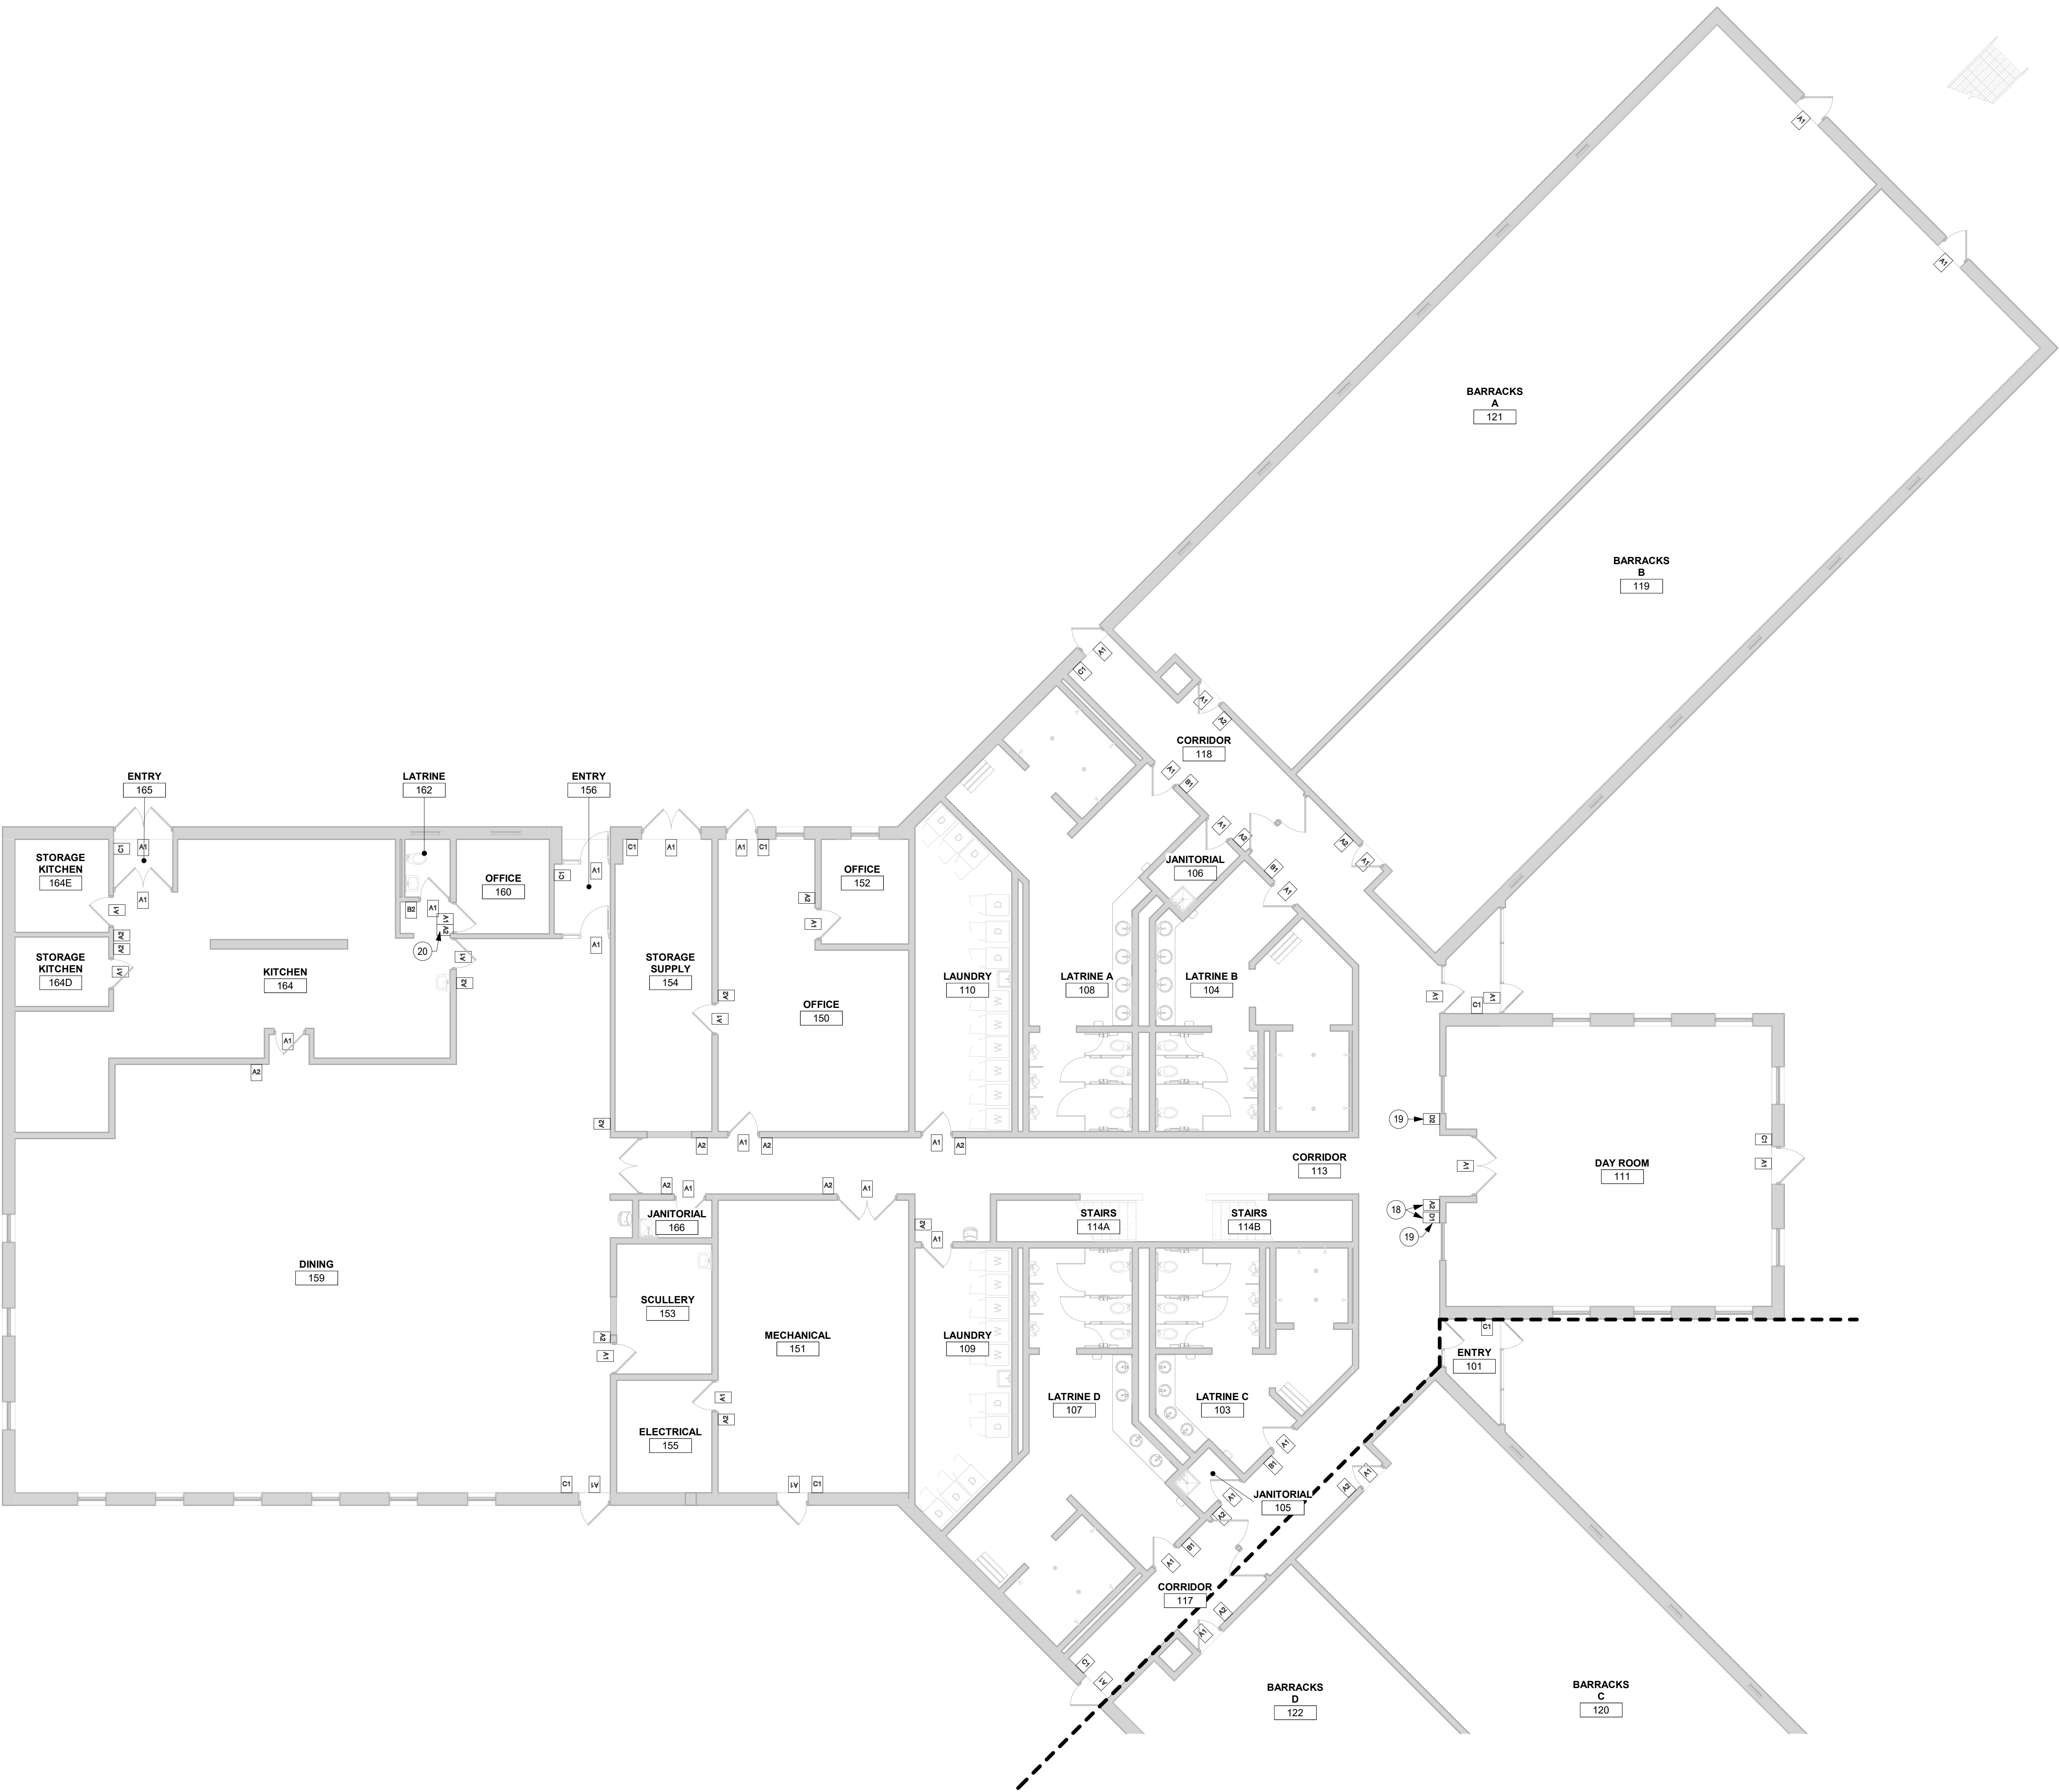

1 FIRST FLOOR SIGNAGE PLAN - AREA A
1/8" = 1'-0"




FLOOR PLAN LEGEND

SHADED REGION INDICATES AREA OF PLANS THAT ARE NOT INCLUDED IN SCOPE OF WORK.

KEYNOTE LEGEND

1 EXISTING DOOR ALARM SIGNAGE TO BE REINSTALLED.

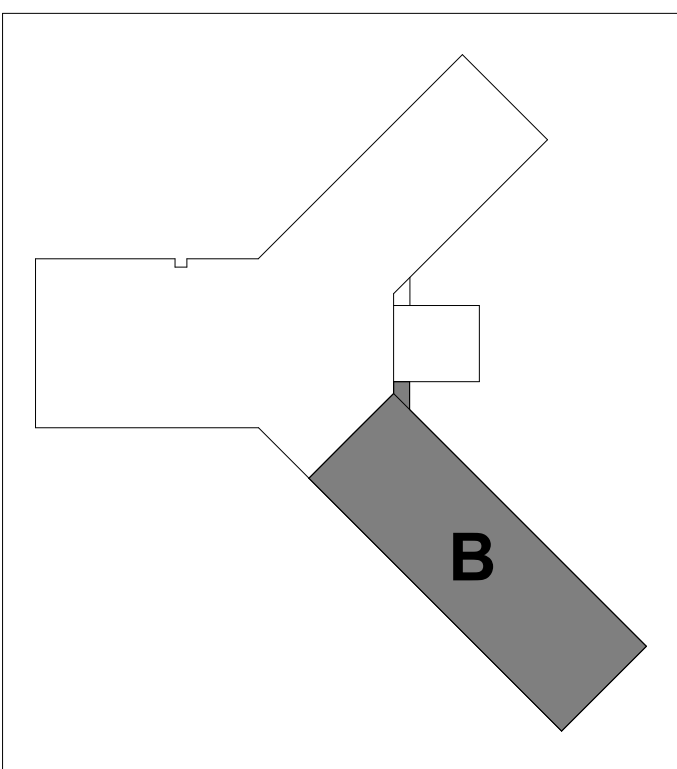

KEYPLAN

THIS DOCUMENT IS THE PROPERTY OF I & S GROUP, INC. AND MAY NOT BE USED, COPIED OR DUPLICATED WITHOUT PRIOR WRITTEN CONSENT.
© 2024 I & S GROUP, INC.

PROJECT

IOWA ARMY
NATIONAL GUARD
S54 FINISH
UPGRADES

CAMP DODGE, JOHNSTON IOWA

REVISION SCHEDULE		
DATE	DESCRIPTION	BY


PROJECT NO.	26-34920
FILE NAME	34920 Arch R26
DRAWN BY	LAD
DESIGNED BY	LAD
REVIEWED BY	LDB
ORIGINAL ISSUE DATE	09/08/26
CLIENT PROJECT NO.	19083733

TITLE

FIRST AND
SECOND FLOOR
SIGNAGE PLAN -
AREA B


SHEET

I1-41B

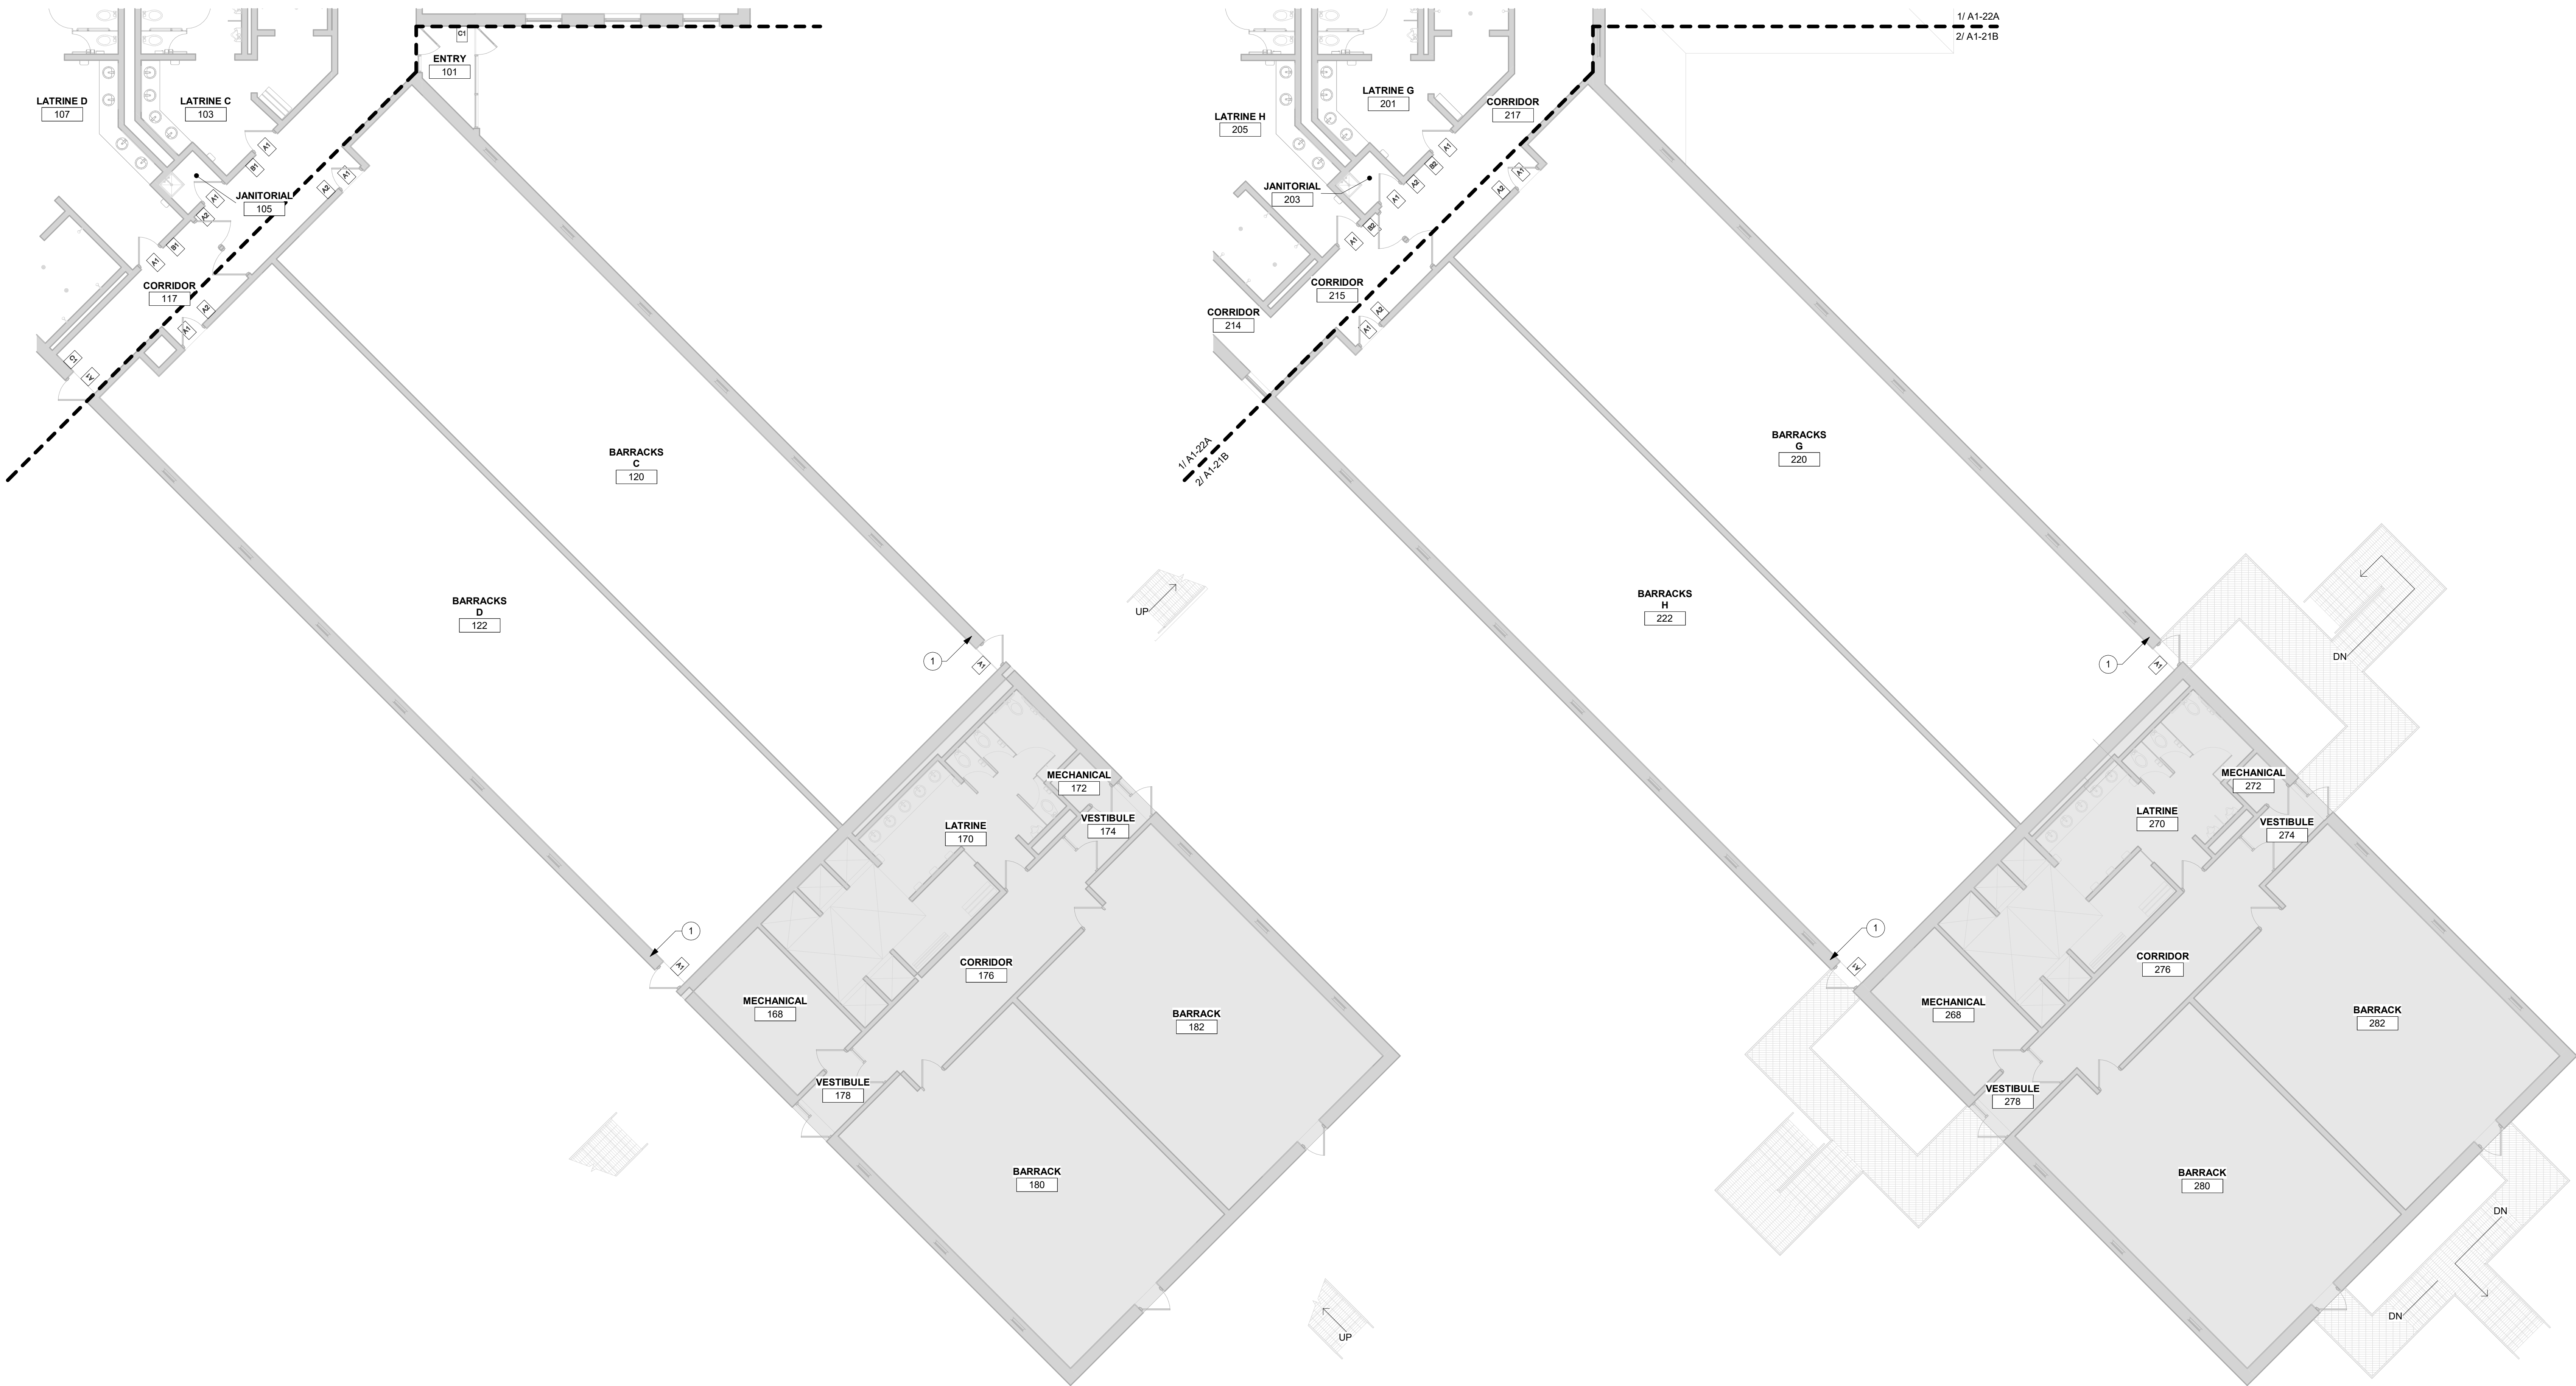

1 FIRST FLOOR SIGNAGE PLAN - AREA B
1/8" = 1'-0"

 2 SECOND FLOOR SIGNAGE PLAN - AREA B
1/8" = 1'-0"




REFERENCE SCALE
0 1/4" 1/2" 1" 2"

1 SECOND FLOOR SIGNAGE PLAN - OVERALL
3/32" = 1'-0"

9/8/2026 3:15:22 PM

FLOOR PLAN LEGEND

SHADED REGION INDICATES AREA OF PLANS THAT ARE NOT INCLUDED IN SCOPE OF WORK.

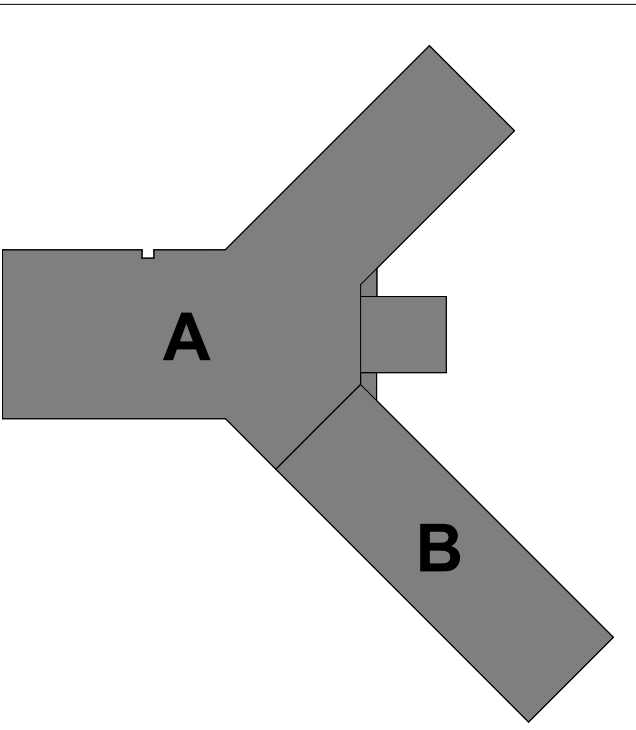

KEYPLAN

THIS DOCUMENT IS THE PROPERTY OF I & S GROUP, INC. AND MAY NOT BE USED, COPIED OR DUPLICATED WITHOUT PRIOR WRITTEN CONSENT.
© 2024 I & S GROUP, INC.

PROJECT

IOWA ARMY
NATIONAL GUARD
S54 FINISH
UPGRADES

CAMP DODGE, JOHNSTON IOWA

REVISION SCHEDULE		
DATE	DESCRIPTION	BY



PROJECT NO.	26-34920
FILE NAME	34920 Arch R26
DRAWN BY	LAD
DESIGNED BY	LAD
REVIEWED BY	LDB
ORIGINAL ISSUE DATE	09/08/26
CLIENT PROJECT NO.	19083733

TITLE


SECOND FLOOR
SIGNAGE PLAN -
OVERALL

SHEET

 11-42

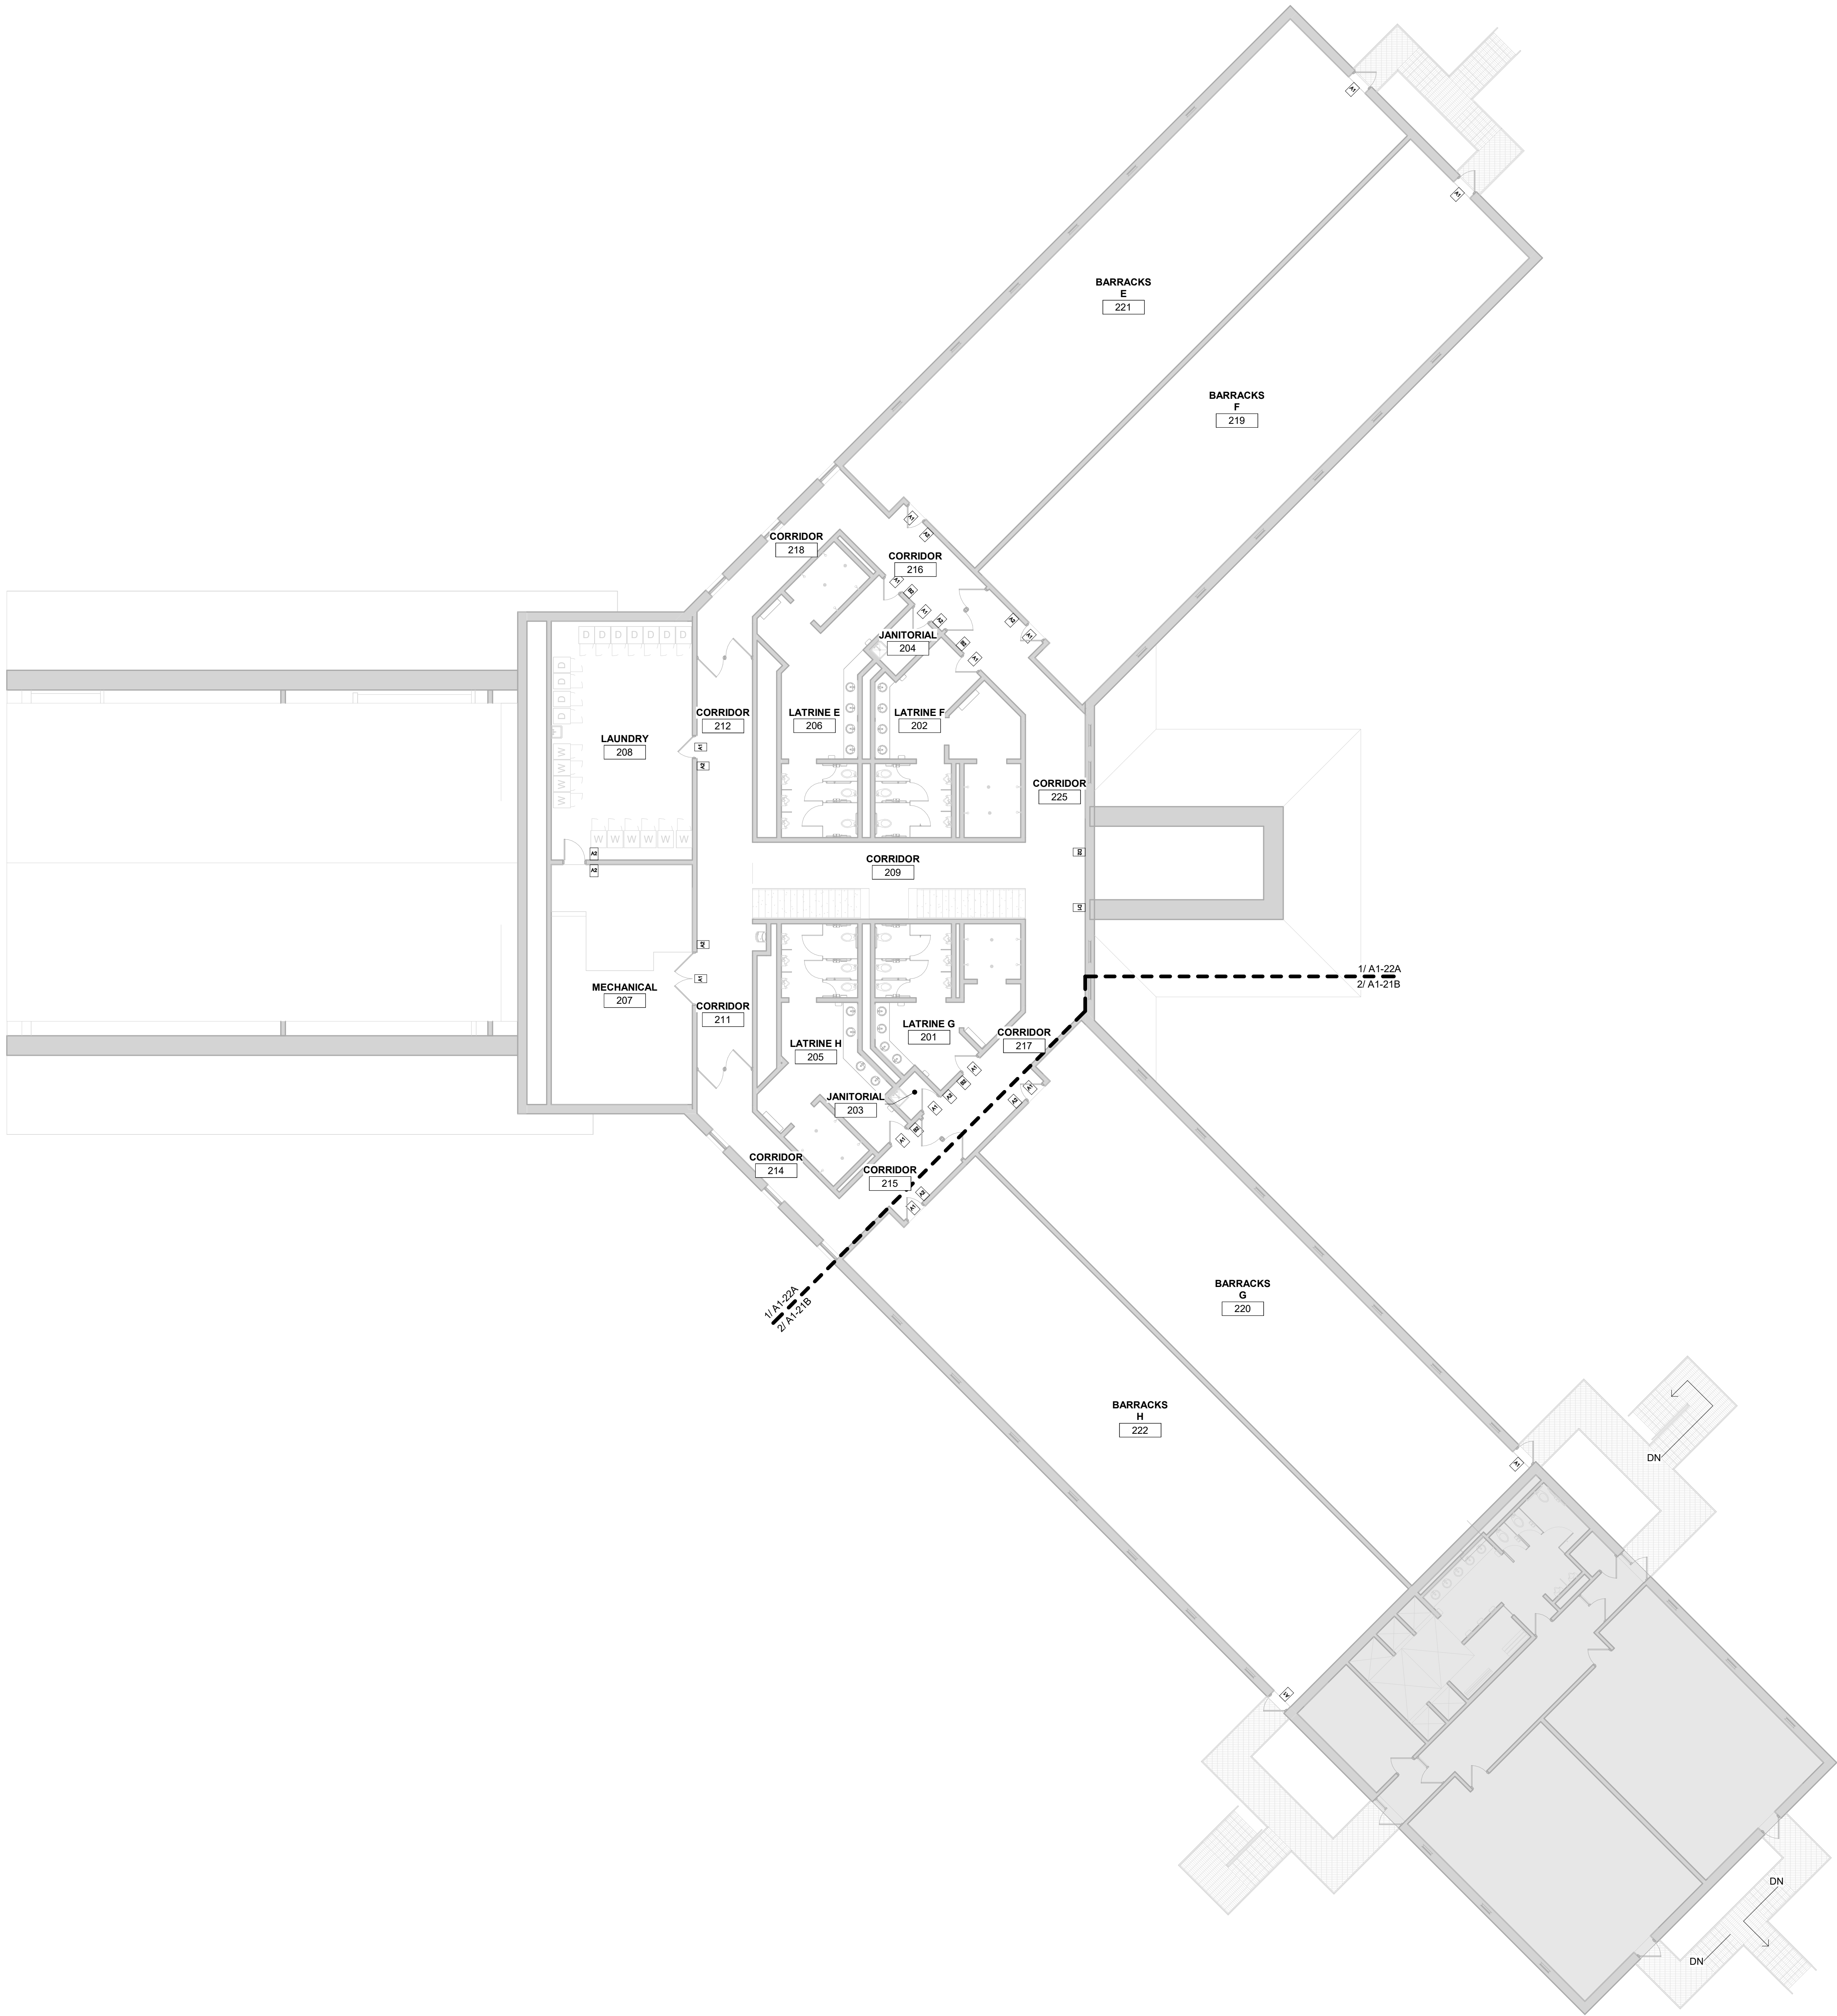

KEYNOTE LEGEND	
19	D1 AND D2 SIGNS ON SAME WALL TO BE ALIGNED.

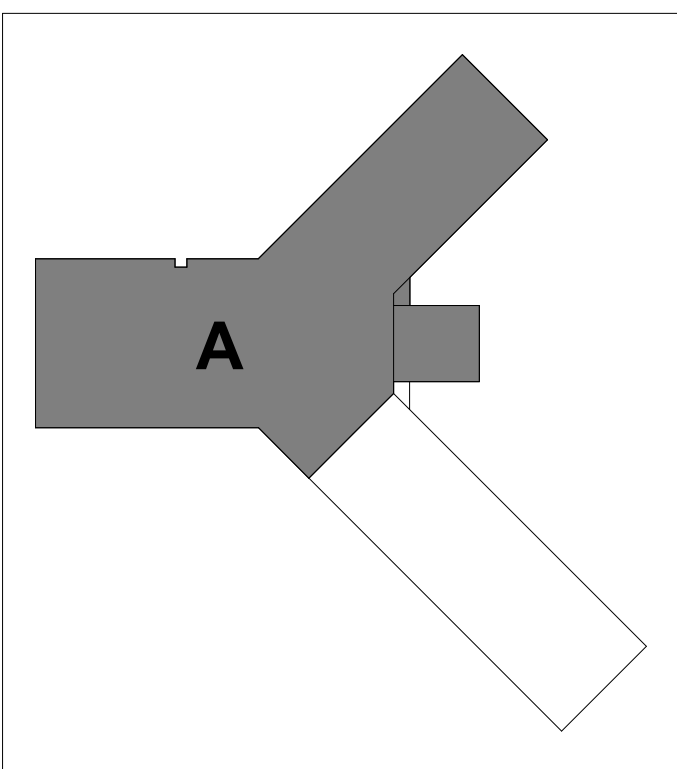

KEYPLAN

THIS DOCUMENT IS THE PROPERTY OF I & S GROUP, INC. AND MAY NOT BE USED, COPIED OR DUPLICATED WITHOUT PRIOR WRITTEN CONSENT.
© 2024 I & S GROUP, INC.

PROJECT

**IOWA ARMY
NATIONAL GUARD
S54 FINISH
UPGRADES**

CAMP DODGE, JOHNSTON IOWA

REVISION SCHEDULE		
DATE	DESCRIPTION	BY


PROJECT NO.	26-34920
FILE NAME	34920 Arch R26
DRAWN BY	LAD
DESIGNED BY	LAD
REVIEWED BY	LDB
ORIGINAL ISSUE DATE	09/08/26
CLIENT PROJECT NO.	19083733

TITLE

**SECOND FLOOR
SIGNAGE PLAN -
AREA A**

SHEET

I1-42A

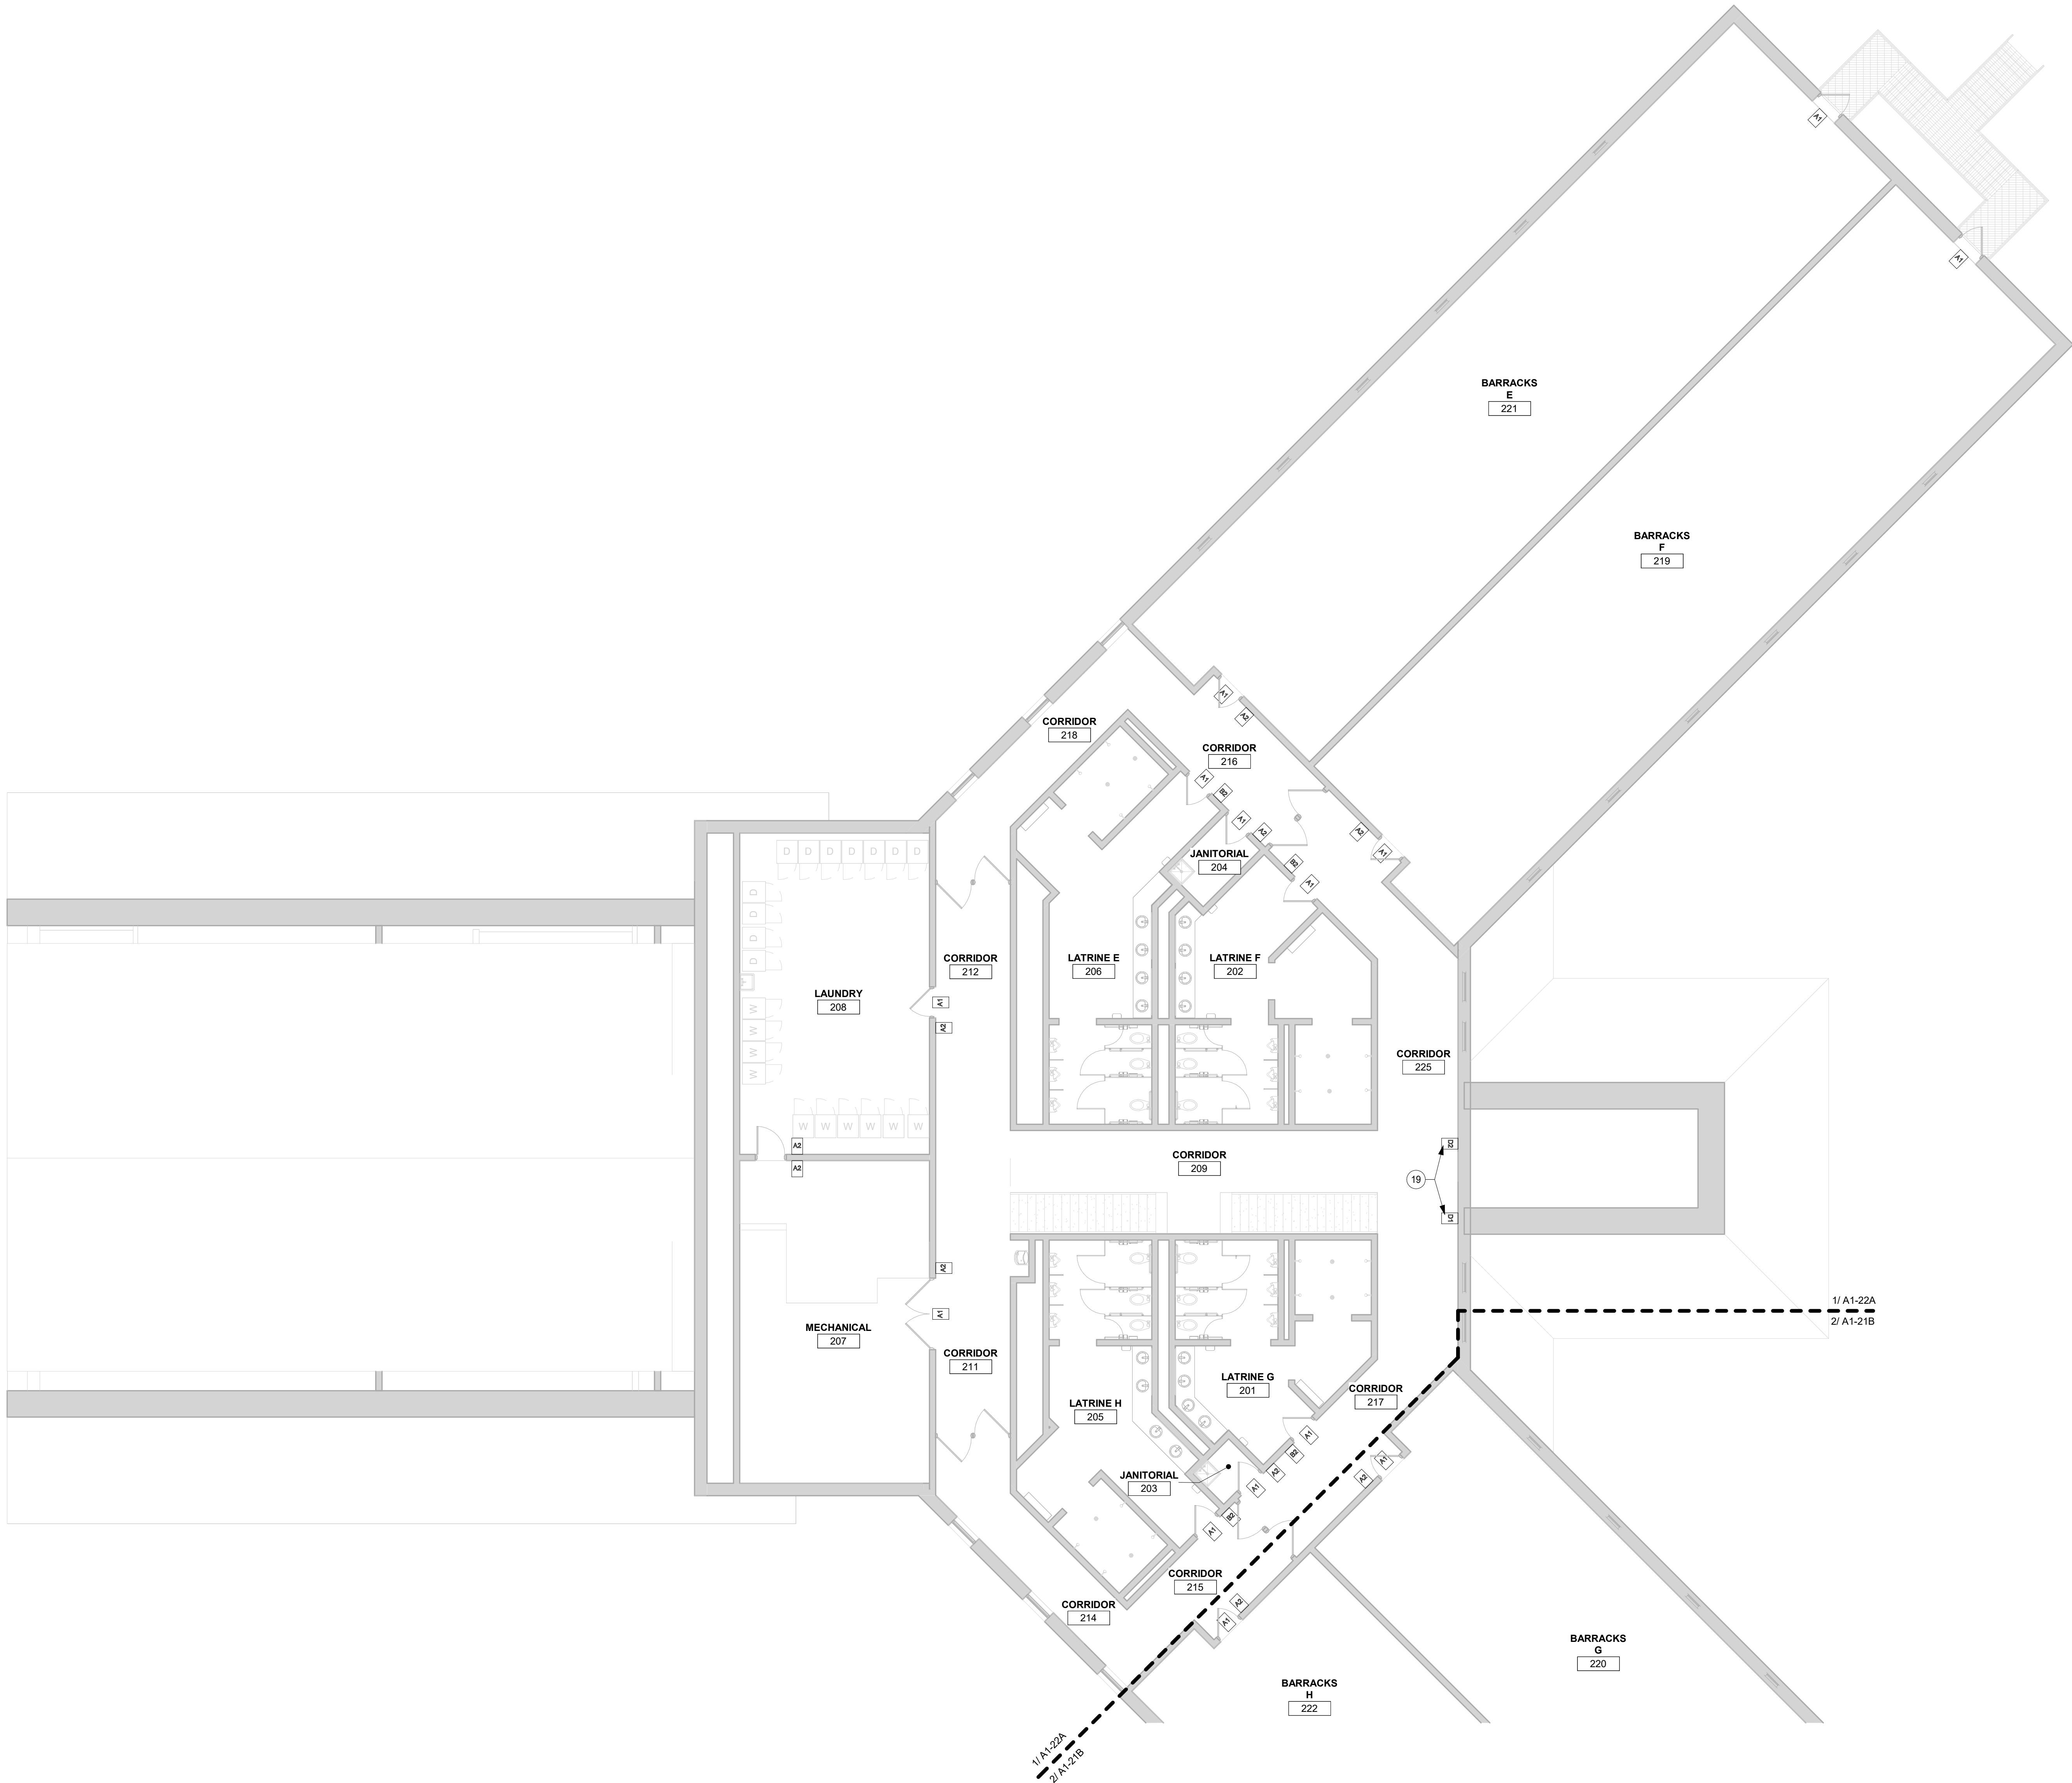

REFERENCE SCALE
1" = 1'-0"
0 1/4" 1/2" 1" 2"

1 SECOND FLOOR SIGNAGE PLAN - AREA A
1/8" = 1'-0"

INTERIOR FINISH SCHEDULE								
MARK	PRODUCT	MANUFACTURER	MODEL / STYLE	COLOR	SIZE	INSTALL	PRODUCT NOTES	DISTRIBUTOR / VENDOR INFO
3. WALLS								
PNT-1	PAINT	SHERWIN WILLIAMS	SEMI-GLOSS	IA DEFENSE ANTIQUE WHITE	-	-	REFER TO INTERIOR FINISH PLANS FOR LOCATIONS	-
PNT-1E	PAINT	SHERWIN WILLIAMS	SEMI-GLOSS / EPOXY	IA DEFENSE ANTIQUE WHITE	-	-	REFER TO INTERIOR FINISH PLANS FOR LOCATIONS	-
PNT-2	PAINT	SHERWIN WILLIAMS	SEMI-GLOSS	CAMP DODGE TOASTY GREY	-	-	REFER TO INTERIOR FINISH PLANS FOR LOCATIONS	-
PNT-3	PAINT	SHERWIN WILLIAMS	SEMI-GLOSS	CAMP BACKDROP	-	-	TO BE USED FOR HOLLOW METAL DOOR FRAMES, WINDOW FRAMES, STAIR HANDRAIL/GUARDRAIL/RISE/STRINGERS	-
4. CEILINGS								
ACT-1	ACOUSTICAL CEILING TILE	ARMSTRONG	DUNE / 24" X 24" X 5/8"	WHITE / WHITE GRID	TEGULAR / 15/16" GRID	-	REFER TO REFLECTED CEILING PLANS FOR LOCATIONS	
ACT-2	ACOUSTICAL CEILING TILE	ARMSTRONG	CLEAN ROOM / 24" X 24" X 5/8"	WHITE / WHITE GRID	SQUARE / 15/16" GRID	-	REFER TO REFLECTED CEILING PLANS FOR LOCATIONS	
PNT-1	PAINT	SHERWIN WILLIAMS	EGGSHELL	IA DEFENSE ANTIQUE WHITE	-	-	REFER TO REFLECTED CEILING PLANS FOR LOCATIONS	-
PNT-1E	PAINT	SHERWIN WILLIAMS	SEMI-GLOSS / EPOXY	IA DEFENSE ANTIQUE WHITE	-	-	REFER TO REFLECTED CEILING PLANS FOR LOCATIONS	-
5. MILLWORK								
SUR-1	SOLID SURFACE	CORIAN	SOLID SURFACE	SILVER BIRCH / MATTE FINISH	1/2" THICK	-	REFER TO COUNTERTOP TYPICAL FOR EDGE AND SPLASH DETAILS. REFER TO FLOOR PLANS FOR COUNTERTOP LOCATIONS.	-

MISCELLANEOUS SCHEDULE						
MARK	PRODUCT	MANUFACTURER	MODEL / STYLE	COLOR	SIZE	PRODUCT NOTES
BENCH-1	ADA LOCKER ROOM BENCH	ROBINSON STEEL COMPANY	ADA HARDWOOD LOCKER ROOM BENCH TOP WITH RSC 304 STAINLESS STEEL BENCH PEDESTALS	-	42"L X 20"W X 17.5"H	ANCHOR TO CONCRETE WITH STAINLESS STEEL SIDEWALK BOLTS
BENCH-2	LOCKER ROOM BENCH	ROBINSON STEEL COMPANY	HARDWOOD LOCKER ROOM BENCH TOP WITH RSC 304 STAINLESS STEEL BENCH PEDESTALS	-	42"L X 9 1/2"W X 17.5"H	ANCHOR TO CONCRETE WITH STAINLESS STEEL SIDEWALK BOLTS
HDW-1	COUNTERTOP BRACKET	A&M HARDWARE	ADA SINK BRACKETS	STAINLESS STEEL	-	TO BE USED IN LATRINES AT NEW COUNTERTOP AS REQUIRED
TOILET PARTITIONS	SOLID PLASTIC HDPE	SCRANTON	HINY HIDERS / TOILET PARTITIONS & URINAL SCREENS	GLACIER GREY / ORANGE PEEL TEXTURE	-	CONTINUOUS STAINLESS STEEL BRACKETS

SIGNAGE SCHEDULE		
TYPE	SIGNAGE LOCATION	SIGNAGE VERBIAGE
A1	102 ENTRY	102a
A1	111 DAY ROOM	111a
A1	113 CORRIDOR	102b
A1	113 CORRIDOR	103
A1	113 CORRIDOR	104
A1	113 CORRIDOR	105
A1	113 CORRIDOR	109
A1	113 CORRIDOR	110
A1	113 CORRIDOR	111b
A1	113 CORRIDOR	119a
A1	113 CORRIDOR	120a
A1	113 CORRIDOR	150a
A1	113 CORRIDOR	151a
A1	113 CORRIDOR	166
A1	117 CORRIDOR	107
A1	117 CORRIDOR	117
A1	117 CORRIDOR	122a
A1	118 CORRIDOR	106
A1	118 CORRIDOR	108
A1	118 CORRIDOR	118
A1	118 CORRIDOR	121a
A1	119 BARRACKS B	119b
A1	120 BARRACKS C	120b
A1	121 BARRACKS A	121b
A1	122 BARRACKS D	122b
A1	150 OFFICE	150b
A1	150 OFFICE	150c
A1	150 OFFICE	152
A1	151 MECHANICAL	151b
A1	151 MECHANICAL	155
A1	154 STORAGE SUPPLY	154
A1	156 ENTRY	156
A1	159 DINING	153
A1	159 DINING	157
A1	159 DINING	158
A1	159 DINING	164
A1	159 DINING	164a
A1	164 KITCHEN	160
A1	164 KITCHEN	162
A1	164 KITCHEN	164D
A1	164 KITCHEN	164E
A1	164 KITCHEN	165a
A1	165 ENTRY	165b
A1	211 CORRIDOR	207
A1	212 CORRIDOR	208
A1	215 CORRIDOR	205
A1	215 CORRIDOR	222a
A1	216 CORRIDOR	204
A1	216 CORRIDOR	206
A1	216 CORRIDOR	221a
A1	217 CORRIDOR	201
A1	217 CORRIDOR	203
A1	217 CORRIDOR	220a
A1	219 BARRACKS F	219b
A1	220 BARRACKS G	220b
A1	221 BARRACKS E	221b
A1	222 BARRACKS H	222b
A1	225 CORRIDOR	202
A1	225 CORRIDOR	219a
A2	113 CORRIDOR	105 JANITORIAL
A2	113 CORRIDOR	109 LAUNDRY
A2	113 CORRIDOR	110 LAUNDRY
A2	113 CORRIDOR	111 DAY ROOM
A2	113 CORRIDOR	119 BARRACKS B
A2	113 CORRIDOR	120 BARRACKS C
A2	113 CORRIDOR	150 OFFICE
A2	113 CORRIDOR	151 MECHANICAL
A2	113 CORRIDOR	154 STORAGE SUPPLY
A2	113 CORRIDOR	166 JANITORIAL
A2	117 CORRIDOR	122 BARRACKS D
A2	118 CORRIDOR	106 JANITORIAL
A2	118 CORRIDOR	121 BARRACKS A
A2	150 OFFICE	152 OFFICE
A2	150 OFFICE	154 STORAGE SUPPLY
A2	151 MECHANICAL	155 ELECTRICAL
A2	159 DINING	153 SCULLERY
A2	159 DINING	159 DINING
A2	159 DINING	164 KITCHEN
A2	159 DINING	164 KITCHEN
A2	164 KITCHEN	160 OFFICE
A2	164 KITCHEN	164D STORAGE
A2	164 KITCHEN	164E STORAGE
A2	207 MECHANICAL	208 LAUNDRY
A2	208 LAUNDRY	207 MECHANICAL
A2	211 CORRIDOR	207 MECHANICAL
A2	212 CORRIDOR	208 LAUNDRY
A2	215 CORRIDOR	222 BARRACKS H
A2	216 CORRIDOR	204 JANITORIAL
A2	216 CORRIDOR	221 BARRACKS E
A2	217 CORRIDOR	203 JANITORIAL
A2	217 CORRIDOR	220 BARRACKS G
A2	225 CORRIDOR	219 BARRACKS F
B1	113 CORRIDOR	LATRINE
B1	113 CORRIDOR	LATRINE
B1	117 CORRIDOR	LATRINE
B1	118 CORRIDOR	LATRINE
B2	164 KITCHEN	LATRINE
B2	215 CORRIDOR	LATRINE
B2	216 CORRIDOR	LATRINE
B2	217 CORRIDOR	LATRINE
B2	225 CORRIDOR	LATRINE
C1	101 ENTRY	DOOR PROVIDED WITH DOOR HOLD OPEN ALARM
C1	102 ENTRY	DOOR PROVIDED WITH DOOR HOLD OPEN ALARM
C1	111 DAY ROOM	DOOR PROVIDED WITH DOOR HOLD OPEN ALARM
C1	117 CORRIDOR	DOOR PROVIDED WITH DOOR HOLD OPEN ALARM
C1	118 CORRIDOR	DOOR PROVIDED WITH DOOR HOLD OPEN ALARM
C1	150 OFFICE	DOOR PROVIDED WITH DOOR HOLD OPEN ALARM
C1	151 MECHANICAL	DOOR PROVIDED WITH DOOR HOLD OPEN ALARM
C1	154 STORAGE SUPPLY	DOOR PROVIDED WITH DOOR HOLD OPEN ALARM
C1	156 ENTRY	DOOR PROVIDED WITH DOOR HOLD OPEN ALARM
C1	159 DINING	DOOR PROVIDED WITH DOOR HOLD OPEN ALARM
C1	165 ENTRY	DOOR PROVIDED WITH DOOR HOLD OPEN ALARM
D1	113 CORRIDOR	BARRACKS C & D
D1	225 CORRIDOR	BARRACKS G & H
D2	113 CORRIDOR	BARRACKS A & B
D2	225 CORRIDOR	BARRACKS E & F

- SIGNAGE GENERAL NOTES
- A. SIGNAGE TYPES SUPPLIED AS A BASIS OF DESIGN. ALL REGULATORY SIGNAGE SHALL COMPLY WITH ADAAG STANDARDS.

B. CONFIRM FINAL SELECTIONS AND SPECIFICATIONS WITH SIGNAGE CONTRACTOR PRIOR TO ORDER/INSTALL.

C. SIGN BACKERS REQUIRED ON ALL SIGNS MOUNTED TO GLASS

- SIGNAGE FINISHES
1. ROOM & REGULATORY SIGNAGE: 1/8" THICK ACRYLIC TYP.

BACKGROUND COLOR: MATTE BLACK ADA

FONT COLOR: ANTIQUE IVORY

FONT: HELVETICA LT STD ROMAN

BRAILLE COLOR: CLEAR

- FINISH NOTES
- A. SOME SPECIFIED PRODUCTS AND FINISHES MAY HAVE SUBSTANTIAL LEAD TIMES. THE CONTRACTOR SHALL BE RESPONSIBLE FOR PLACING ORDERS IN A MANNER TO ENSURE THEIR TIMELY ARRIVAL. THE CONTRACTOR SHALL BE RESPONSIBLE FOR EXPENSES, INCLUDING DESIGN FEES, RELATED TO ANY RESELECTION REQUIRED DUE TO FAILURE TO ORDER PRODUCTS IN A TIMELY MANNER.

B. ALL FINISH WORK SHALL BE PERFORMED IN COMPLIANCE WITH DRAWINGS AND SPECIFICATIONS. SHOP DRAWINGS, SAMPLES, AND PRODUCT DATA SHALL BE SUBMITTED TO THE ARCHITECT FOR THEIR REVIEW & APPROVAL PRIOR TO BEGINNING WORK.

C. ALL WALLS TO RECEIVE PNT-1, UNLESS NOTED OTHERWISE.

D. BULKHEADS AND SOFFITS: ALL SIDES AND UNDERSIDES TO BE PAINTED AS INDICATED ON REFLECTED CEILING PLANS, UNLESS NOTED OTHERWISE.

E. REFER TO REFLECTED CEILING PLANS FOR CEILING/SOFFIT FINISHES AND LOCATIONS.

F. PAINT ALL EXPOSED DUCTWORK, CONDUIT, ELECTRICAL EQUIPMENT, GRILLES, VENTS, METAL ACCESS PANELS, ETC., TO MATCH ADJACENT SURFACES, UNLESS NOTED OTHERWISE.

G. DO NOT PAINT VALVES, SENSORS, RELAYS, OR ACTUATORS.

H. EXISTING SURFACES TO BE PATCHED AND PREPPED FOR PAINTING AS REQUIRED.

I. MECHANICAL/ELECTRICAL ROOMS WILL NOT RECEIVE ANY NEW PAINTING ON WALLS OR CEILINGS.

J. FIRE EXTINGUISHER CABINETS WILL NOT RECEIVE ANY NEW PAINTING.

K. REMOVE AND REINSTALL SIGNAGE AS REQUIRED FOR PAINTING SCOPE.

L. WALL MOUNTED ITEMS MAY BE PAINTED AROUND, UNLESS NOTED OTHERWISE.

M. IN-WALL OR WALL SUPPORT BRACKETS TO BE PAINTED TO MATCH WALL FINISH, UNLESS NOTED OTHERWISE.

N. PLUMBING FIXTURES HAVE BEEN REMOVED FROM FINISH PLAN FOR VIEWING CLARITY. REFER TO THE RESPECTIVE PLANS AND DOCUMENTS FOR PLUMBING CRITERIA.

O. UNLESS OTHERWISE INDICATED, PROVIDE PRODUCTS OF QUALITY SPECIFIED BY AWII/AWMA/CWII ARCHITECTURAL WOODWORK STANDARDS FOR CUSTOM GRADE.

P. HOLLOW METAL DOORS, FRAMES, AND HANDRAILS TO BE PAINTED PNT-3

Q. "E" AT END OF PAINT TAG DESIGNATES TO USE EPOXY PAINT AT THIS LOCATION


R. COORDINATE ALL BRACKETS WITH OUTLET LOCATIONS UNDER COUNTER

S. WINDOW TREATMENTS ARE INDICATED ON REFLECTED CEILING PLANS

T. PAINT ALL EXPOSED METALS INCLUDING, BUT NOT LIMITED TO COLUMNS, RISERS, STRINGERS, HANDRAILS, GUARDRAILS, EXPOSED LINTELS AND FLOOR EDGES, UNLESS NOTED OTHERWISE.


U. FOR ALL DOORS & FRAMES RECEIVING NEW PAINT: REMOVE/DISCARD ROOM SIGNAGE ATTACHED TO ALL DOOR FRAMES. REMOVE/CLEAN ASSOCIATED ADHESIVES AND ATTACHMENT. REMOVE & INSTALL DOOR HARDWARE AS REQUIRED FOR PAINTING. AT LOCATIONS WHERE FRAMES SHOW SIGNS OF DETERIORATION, FILE SMOOTH PRIOR TO PAINTING. PREP ALL FRAMES FOR PAINT.

ROOM SIGNAGE


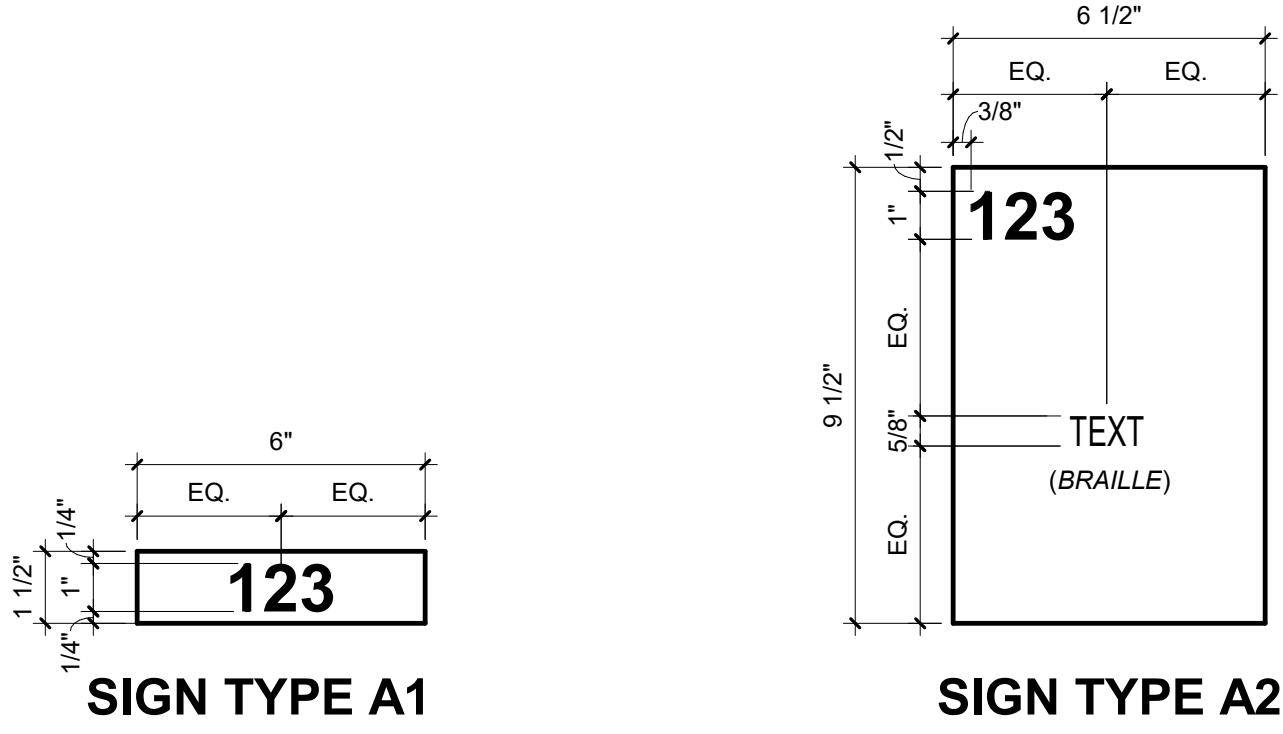


TO BE PLACED ON TOP CENTER OF DOOR FRAME


REGULATORY SIGNAGE

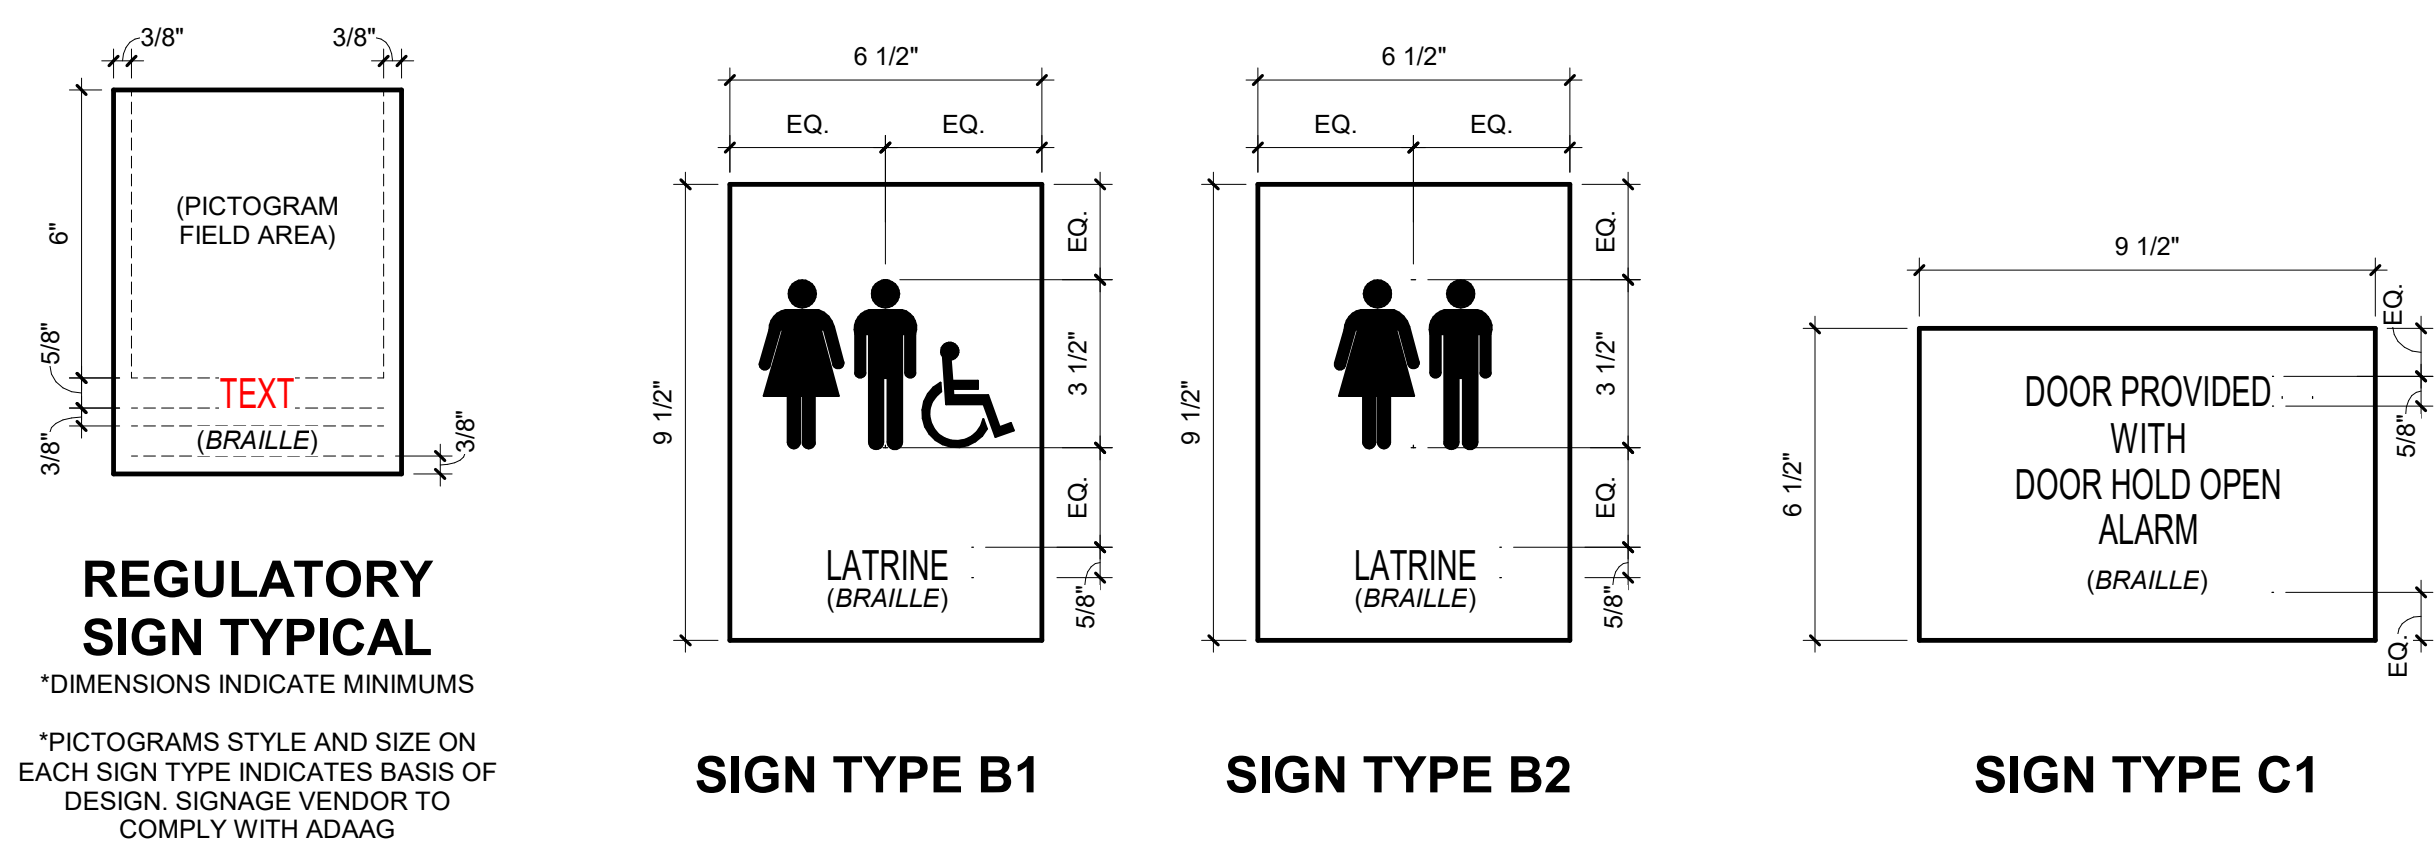

WAYFINDING SIGNAGE

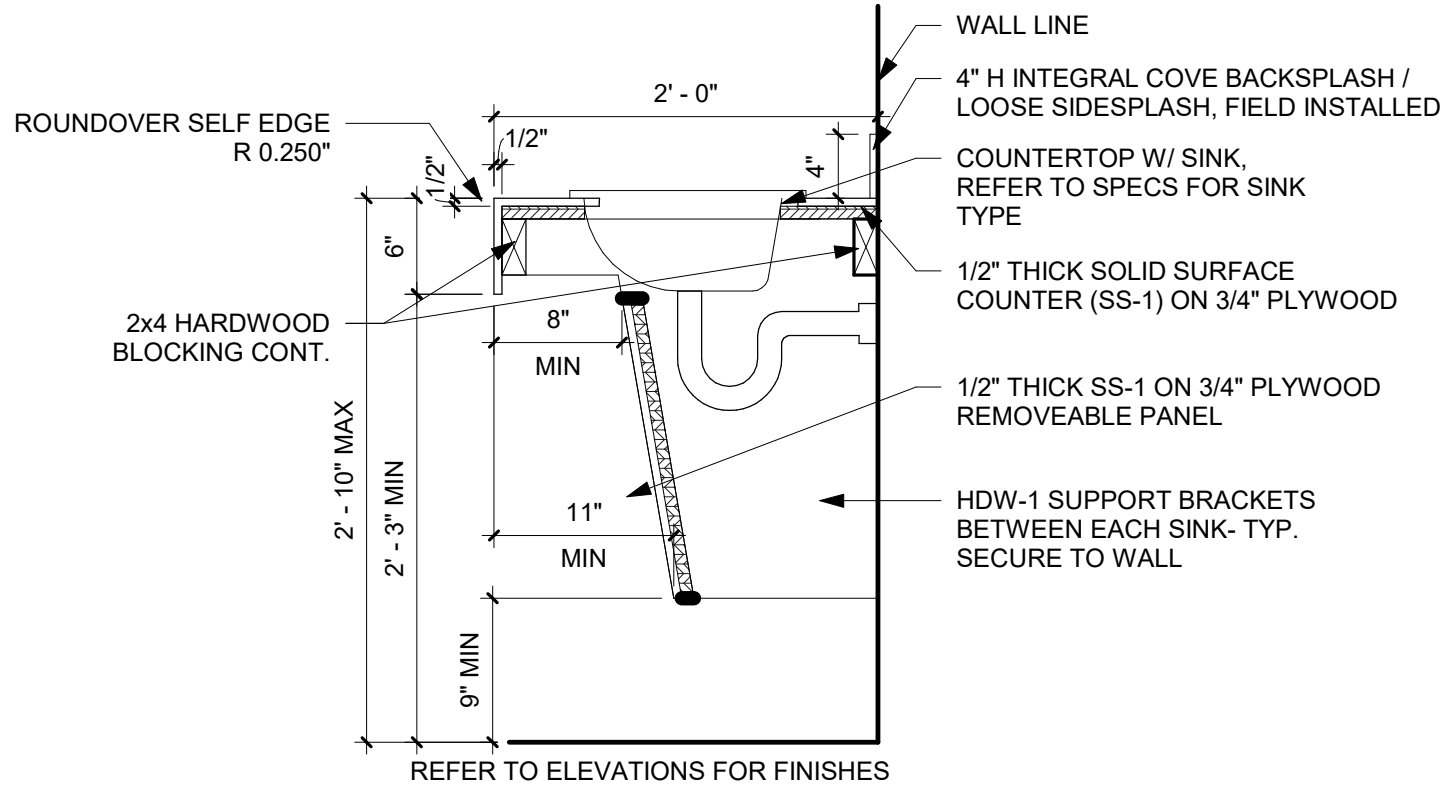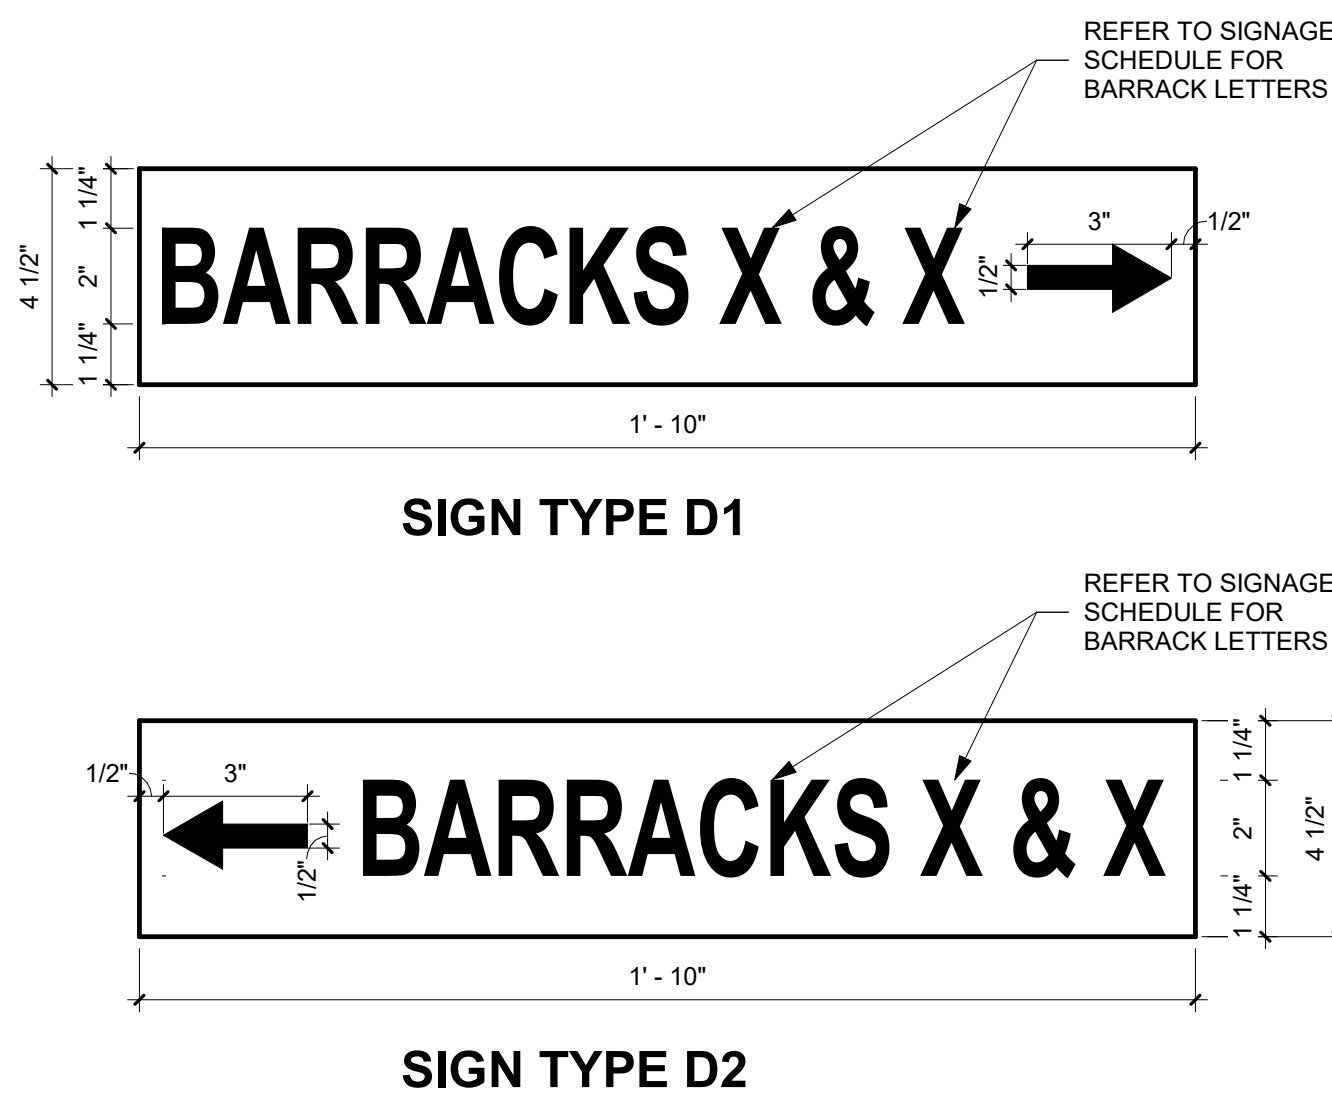

2 ADA SINK CABINET DETAIL
1" = 1'-0"

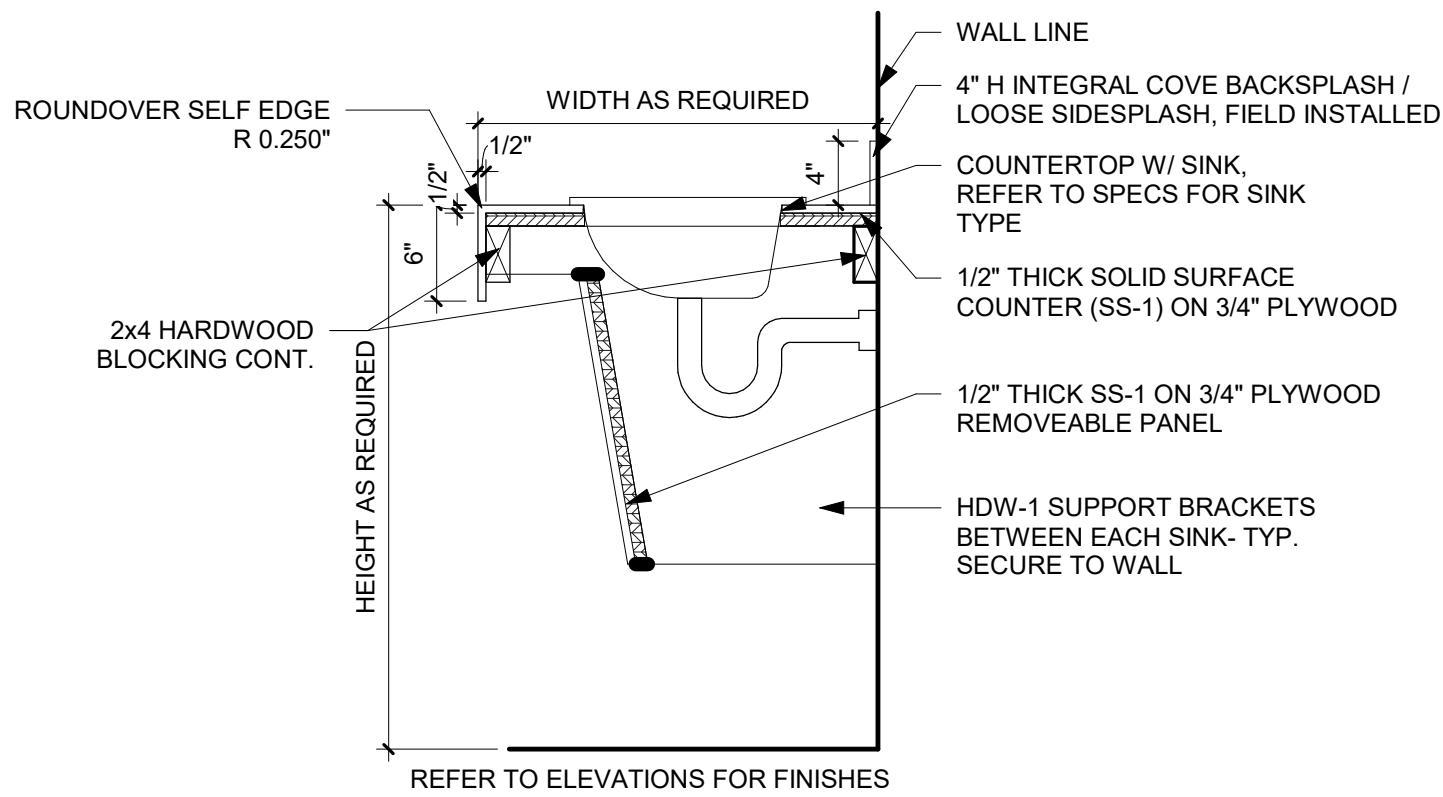

3 SINK CABINET DETAIL
1" = 1'-0"



THIS DOCUMENT IS THE PROPERTY OF I & S GROUP, INC. AND MAY NOT BE USED, COPIED OR DUPLICATED WITHOUT PRIOR WRITTEN CONSENT.
© 2024 I & S GROUP, INC.

PROJECT

IOWA ARMY NATIONAL GUARD S54 FINISH UPGRADES

CAMP DODGE, JOHNSTON IOWA

REVISION SCHEDULE		
DATE	DESCRIPTION	BY

PROJECT NO.	26-34920
FILE NAME	34920 Arch R26
DRAWN BY	LAD
DESIGNED BY	LAD
REVIEWED BY	LDB
ORIGINAL ISSUE DATE	09/08/26
CLIENT PROJECT NO.	19083733

TITLE

FINISH LEGENDS, SCHEDULES, AND DETAILS

SHEET

14-11

TYPICAL ANNOTATIONS

A - AMPS
ACH - AIR CHANGES PER HOUR
A.F.F. - ABOVE FINISH FLOOR
BMS - BUILDING MANAGEMENT SYSTEM
BOB - BOTTOM OF BEAM
BOD - BOTTOM OF DUCT
BOJ - BOTTOM OF JOIST
BOP - BOTTOM OF PIPE
BOS - BOTTOM OF STEEL
BTUH - BRITISH THERMAL UNITS PER HOUR
CFM - CUBIC FEET PER MINUTE
CL - CENTERLINE
DIA - DIAMETER
DB - DECIBELS
DDC - DIRECT DIGITAL CONTROL
DN - DOWN
EA - EXHAUST AIR
EAT - ENTERING AIR TEMPERATURE (°F)
ESP - EXTERNAL STATIC PRESSURE
EWT - ENTERING WATER TEMPERATURE (°F)
FDC - FIRE DEPARTMENT CONNECTION
FLA - FULL LOAD AMPS
FPM - FEET PER MINUTE
FT - FEET
GC - GENERAL CONTRACTOR
GPM - GALLONS PER MINUTE
HD - HEAD
HP - HORSEPOWER
KW - KILOWATT
LAT - LEAVING AIR TEMPERATURE (°F)
LWT - LEAVING WATER TEMPERATURE (°F)
MBH - THOUSANDS OF BTUS PER HOUR

TYPICAL ANNOTATIONS CONT'D

MC - MECHANICAL CONTRACTOR
MCA - MINIMUM CIRCUIT AMPACITY
MFR - MANUFACTURER
MOC - MAXIMUM OVER CURRENT PROTECTION
N.I.C. - NOT IN CONTRACT
NC - NORMALLY CLOSED
NC - NOISE CRITERIA
NO - NORMALLY OPEN
OA - OUTSIDE AIR (UNCONDITIONED)
OFCI - OWNER FURNISHED, CONTRACTOR INSTALLED
OFOI - OWNER FURNISHED, OWNER INSTALLED
PC - PLUMBING CONTRACTOR
PD - PRESSURE DROP (FEET)
PH - PHASE
PSIA - POUNDS PER SQUARE INCH, ATMOSPHERIC
PSIG - POUNDS PER SQUARE INCH, GAUGE
RA - RETURN AIR
RH - RELATIVE HUMIDITY
RPM - REVOLUTIONS PER MINUTE
SA - SUPPLY AIR
TOB - TOP OF BEAM
TOD - TOP OF DUCT
TON - TON OF COOLING (12,000 BTU/H)
TOP - TOP OF PIPE
TOS - TOP OF STEEL
TSP - TOTAL STATIC PRESSURE
TYP - TYPICAL
UP - UP
V/VOLT. - VOLTAGE
VFD - VARIABLE FREQUENCY DRIVE
VTR - VENT THROUGH ROOF

PIPING SYMBOLS

ISOLATION VALVE
BALANCING VALVE
BALL VALVE
BUTTERFLY VALVE
CHECK VALVE
GAS COCK
GATE VALVE
GATE VALVE (NORMALLY CLOSED)
GLOBE VALVE
GLOBE VALVE (NORMALLY CLOSED)
NEEDLE VALVE
NEEDLE VALVE (NORMALLY CLOSED)
2 WAY CONTROL VALVE
3 WAY CONTROL VALVE
CLEAN OUT
FLOOR DRAIN
FLOOR SINK
WALL HYDRANT/ HOSE BIBB
REDUCED PRESSURE PRINCIPLE BACKFLOW PREVENTER
UNION
PIPING DROP
INLINE PIPING DROP
PIPING RISE
INLINE PIPING RISE
PIPE CAP
PIPE BREAK
FLEXIBLE CONNECTOR
RELIEF VALVE
METER
WALL / END CLEANOUT
THERMOMETER
STRAINER
IN LINE PUMP
PIPE ANCHOR
PIPE GUIDE
STEAM TRAP

PLUMBING PIPING LEGEND

DCW - DOMESTIC COLD WATER
DHW - DOMESTIC HOT WATER
DHW - DOMESTIC HOT WATER RECIRCULATION
V - VENT
W - SANITARY WASTE

DOUBLE LINE EXISTING PLUMBING PIPING LEGEND

V - VENT
W - SANITARY WASTE

DOUBLE LINE NEW PLUMBING PIPING LEGEND

V - VENT
W - SANITARY WASTE

SYMBOL LEGEND

CONNECT TO EXISTING
DISCONNECT FROM EXISTING
THERMOSTAT
TEMPERATURE SENSOR (DDC)
HUMIDITY SENSOR
DUCT SMOKE DETECTOR
CARBON MONOXIDE SENSOR
CARBON DIOXIDE SENSOR
NITROGEN DIOXIDE SENSOR
PRESSURE SENSOR

NOTES:
THIS DRAWING IS FOR INFORMATIONAL PURPOSES ONLY. ITEMS SHOWN ARE NOT NECESSARILY USED ON THIS PROJECT.
DUCT SIZE: FIRST NUMBER INDICATES DIMENSION OF SIDE SHOWN. THE SECOND NUMBER INDICATES SIDE NOT SHOWN

PIPING / EQUIPMENT LINE STYLES

EXISTING
DEMOLISHED
NEW

SHEET ANNOTATION SYMBOLS

KEYNOTE
REVISION NUMBER
DETAIL NUMBER ON SHEET
SHEET NUMBER
SPOT ELEVATION (BOTTOM OF ELEMENT)

PIPING TAGS

NOMINAL PIPE SIZE

###-XXX - PIPE SYSTEM ABBREVIATION

###-XXX (##) - FIXTURE UNITS / FLOW

SHEET NOTES


- FIELD VERIFY ALL SITE CONDITIONS BEFORE STARTING CONSTRUCTION.
- ALL EXISTING DUCTWORK, PIPING, EQUIPMENT, ETC. INDICATED ON PLANS ARE BASED ON INFORMATION FROM CONSTRUCTION DOCUMENTS AND FIELD VERIFICATION OF EXISTING BUILDING.
- COORDINATE INSTALLATION OF ALL NEW DUCTWORK, PIPING, EQUIPMENT, ETC. WITH OTHER TRADES.

KEYNOTE LEGEND


- D1 REMOVE AND DISPOSE OF EXISTING LAVATORY (LAVATORY FAUCET, TRAP, SUPPLIES AND STOPS BACK TO WALL. PREPARE REMAINING PIPING FOR NEW CONNECTIONS.
- P1 INSTALL LAVATORY INTO NEW COUNTERTOP. CONNECT FIXTURE TO EXISTING ROUGH-IN FOR SUPPLY AND SANITARY PIPING. COORDINATE NEW PIPING WITH NEW CASEWORK'S KNEE GUARD.

PLUMBING FIXTURE SCHEDULE

FIXTURE	MFR	MODEL	FINISH / COLOR	TRIM		TYPE	WASTE	VENT	COLD WATER	HOT WATER	NOTES
				MFR	MODEL						
L-1	AMERICAN STANDARD	RONDALYN 0491.019	WHITE	AMERICAN STANDARD	RELIANT 3 7385.008	SINGLE HANDLE FAUCET	1 1/4"		1/2"	1/2"	FIXTURE: ADA SINGLE DROP-IN LAVATORY, ASME A112.19.2M VITREOUS CHINA, FAUCET LEDGE, FRONT OVERFLOW, 3 FAUCET HOLES ON 4" CENTERS, NOMINAL 19 1/8" ROUND WITH 15" x 12 1/8" x 5 3/4" DEEP BOWL. FAUCET: CERAMIC MIXING CARTRIDGE, INDEXED 4 5/8" SINGLE METAL LEVER HANDLE, 3/8" FLEXIBLE STAINLESS-STEEL INLETS, 4 7/8" SPOUT WITH 0.5 GPM FLOW OUTLET, CHROME PLATED, 3/8" CHROME PLATED ANGLE STOPS WITH WHEEL HANDLE AND FLEXIBLE RISERS. INSTALL STOPS CLOSE TO WALL. WASTE: CHROME PLATED POP-UP DRAIN FOR 1 1/2" HOLE SIZE, 17 GAUGE - 1 1/4" CHROME PLATED BRASS ADJUSTABLE P-TRAP AND WASTE-TO-WALL. OFFSET DRAIN PIPING ASSEMBLY FOR ADA INSTALLATION. MIXING VALVE: POWERS HYDROGUARD LFLM495 SERIES, ASSE 1070 LEAD FREE THERMOSTATIC MIXING VALVE. MOUNT UNDER THE FIXTURE, 1/2" INLETS AND OUTLET. SET VALVE TO DELIVER 105 DEG WATER TO THE HOT WATER SIDE OF MANUAL FAUCET.

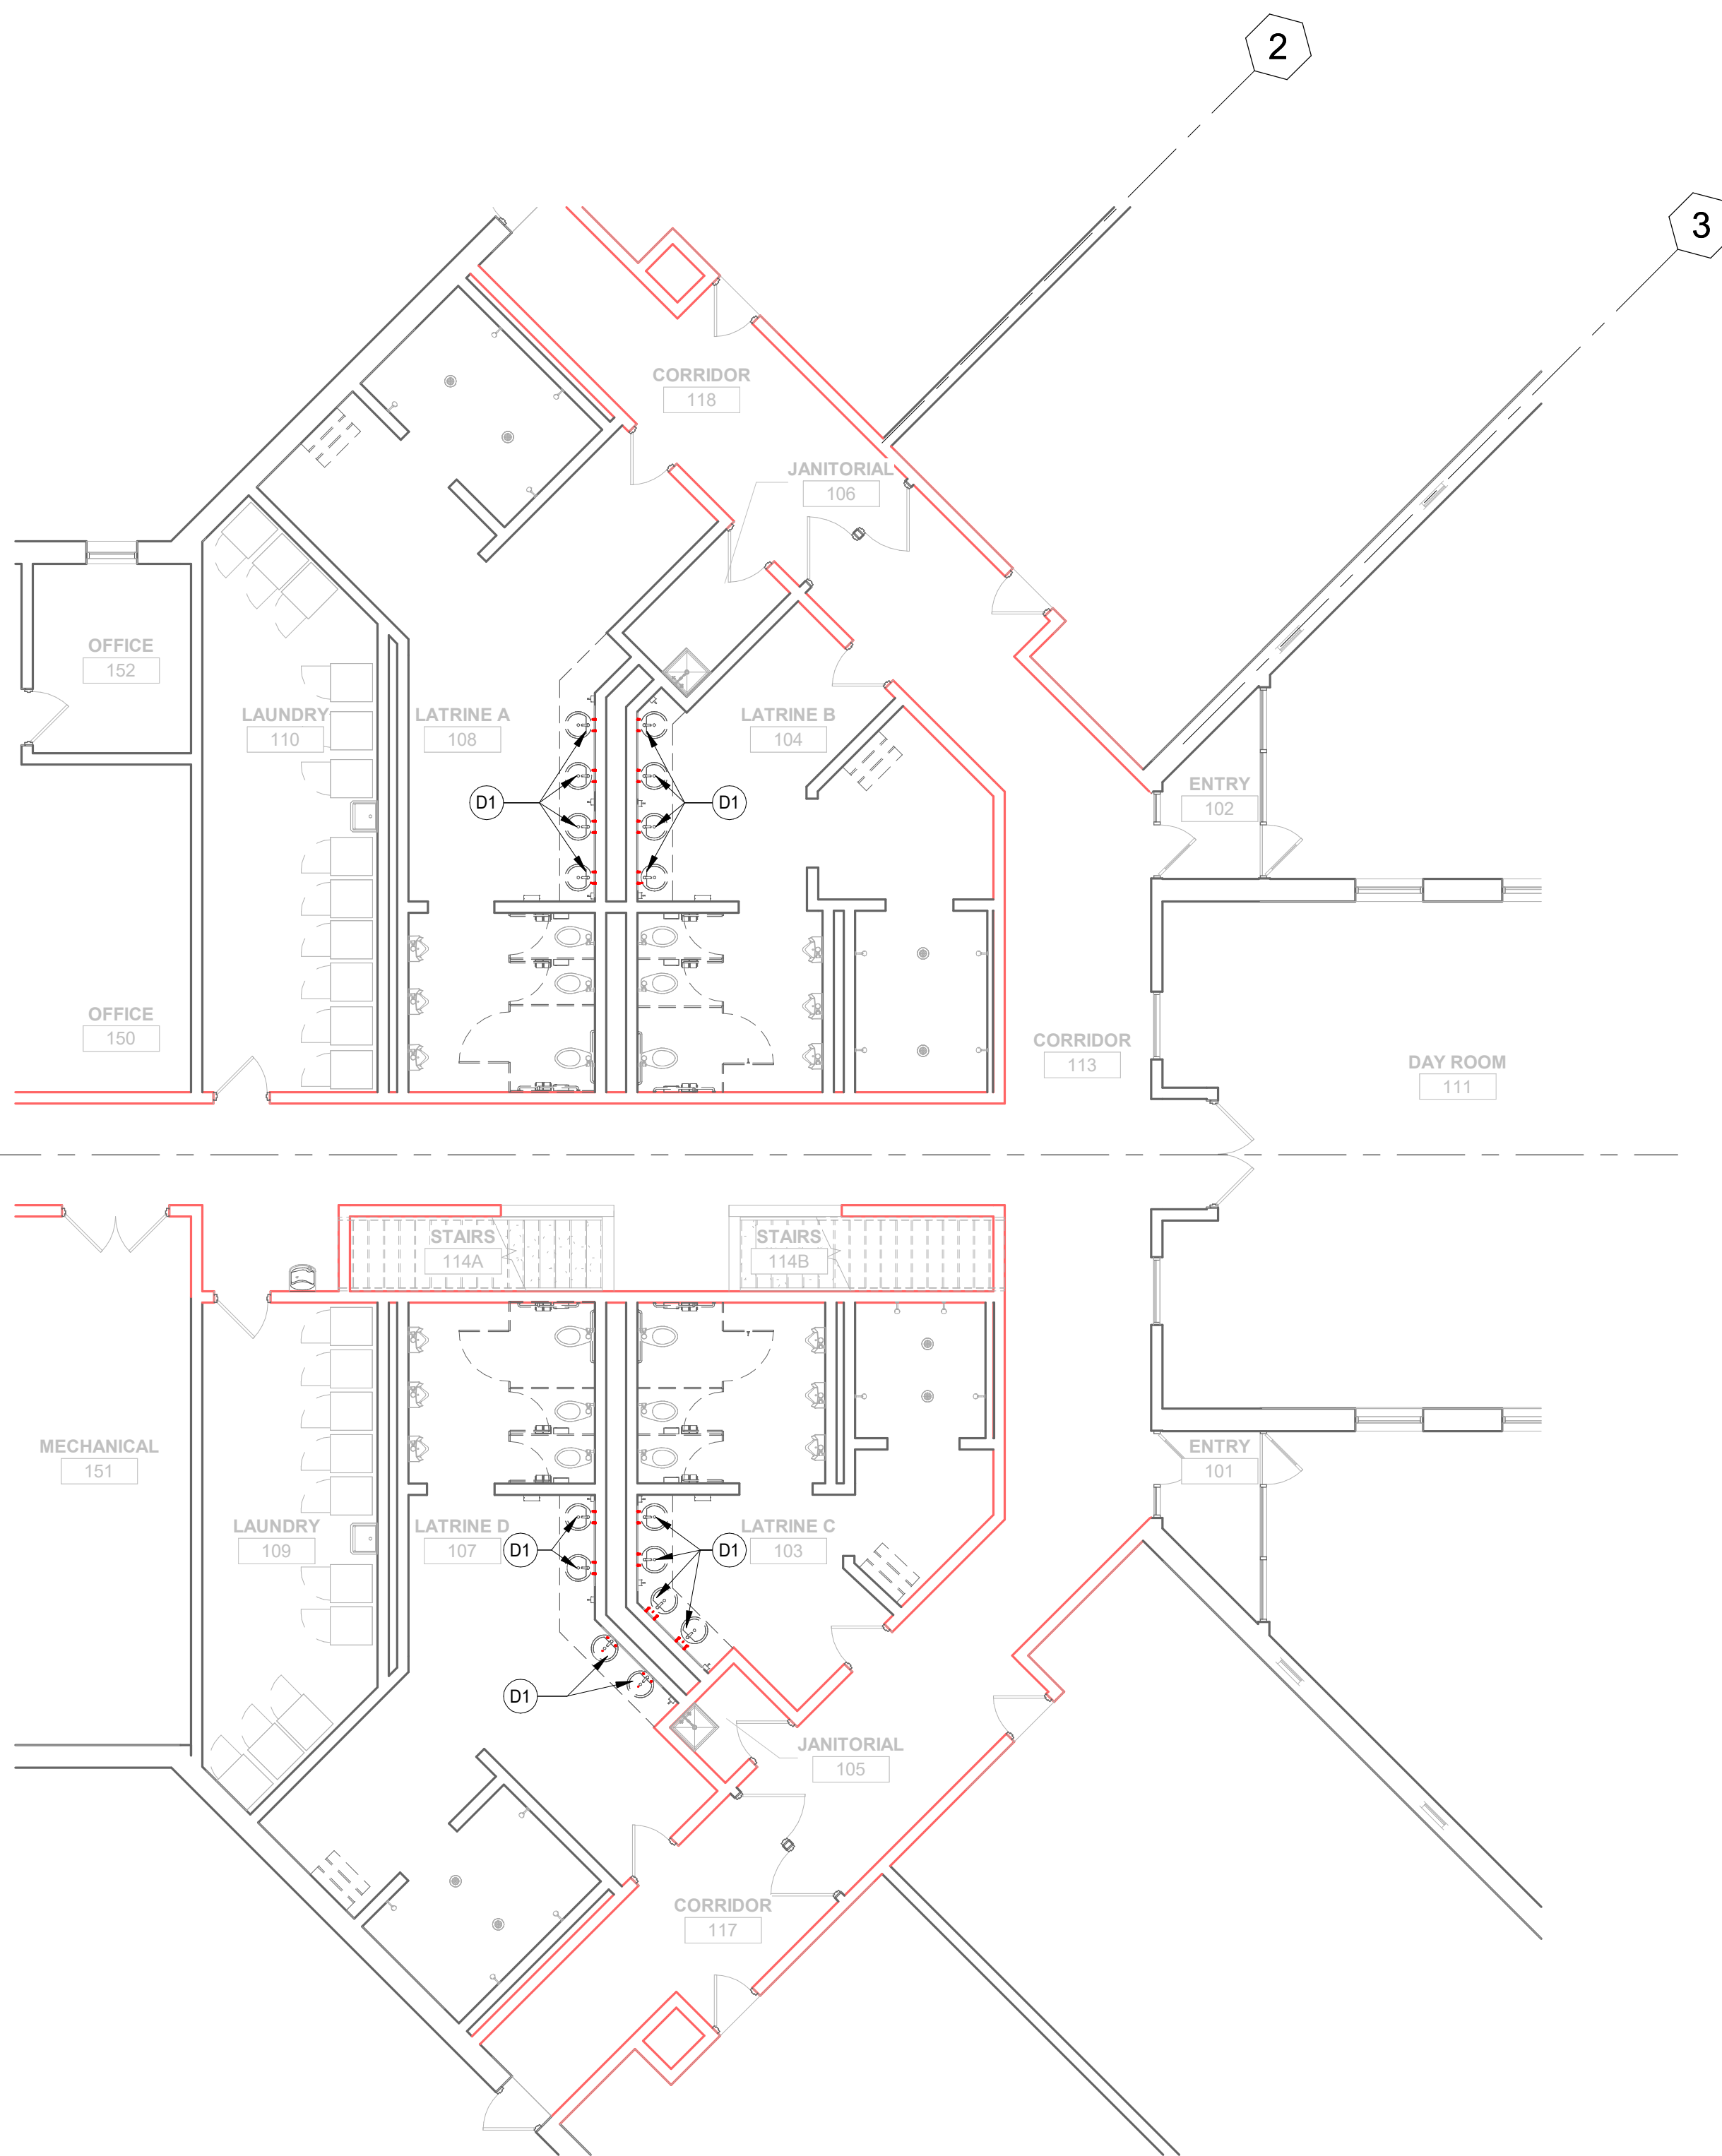

1 DEMOLITION FIRST FLOOR PLUMBING PLAN
1/8" = 1'-0"

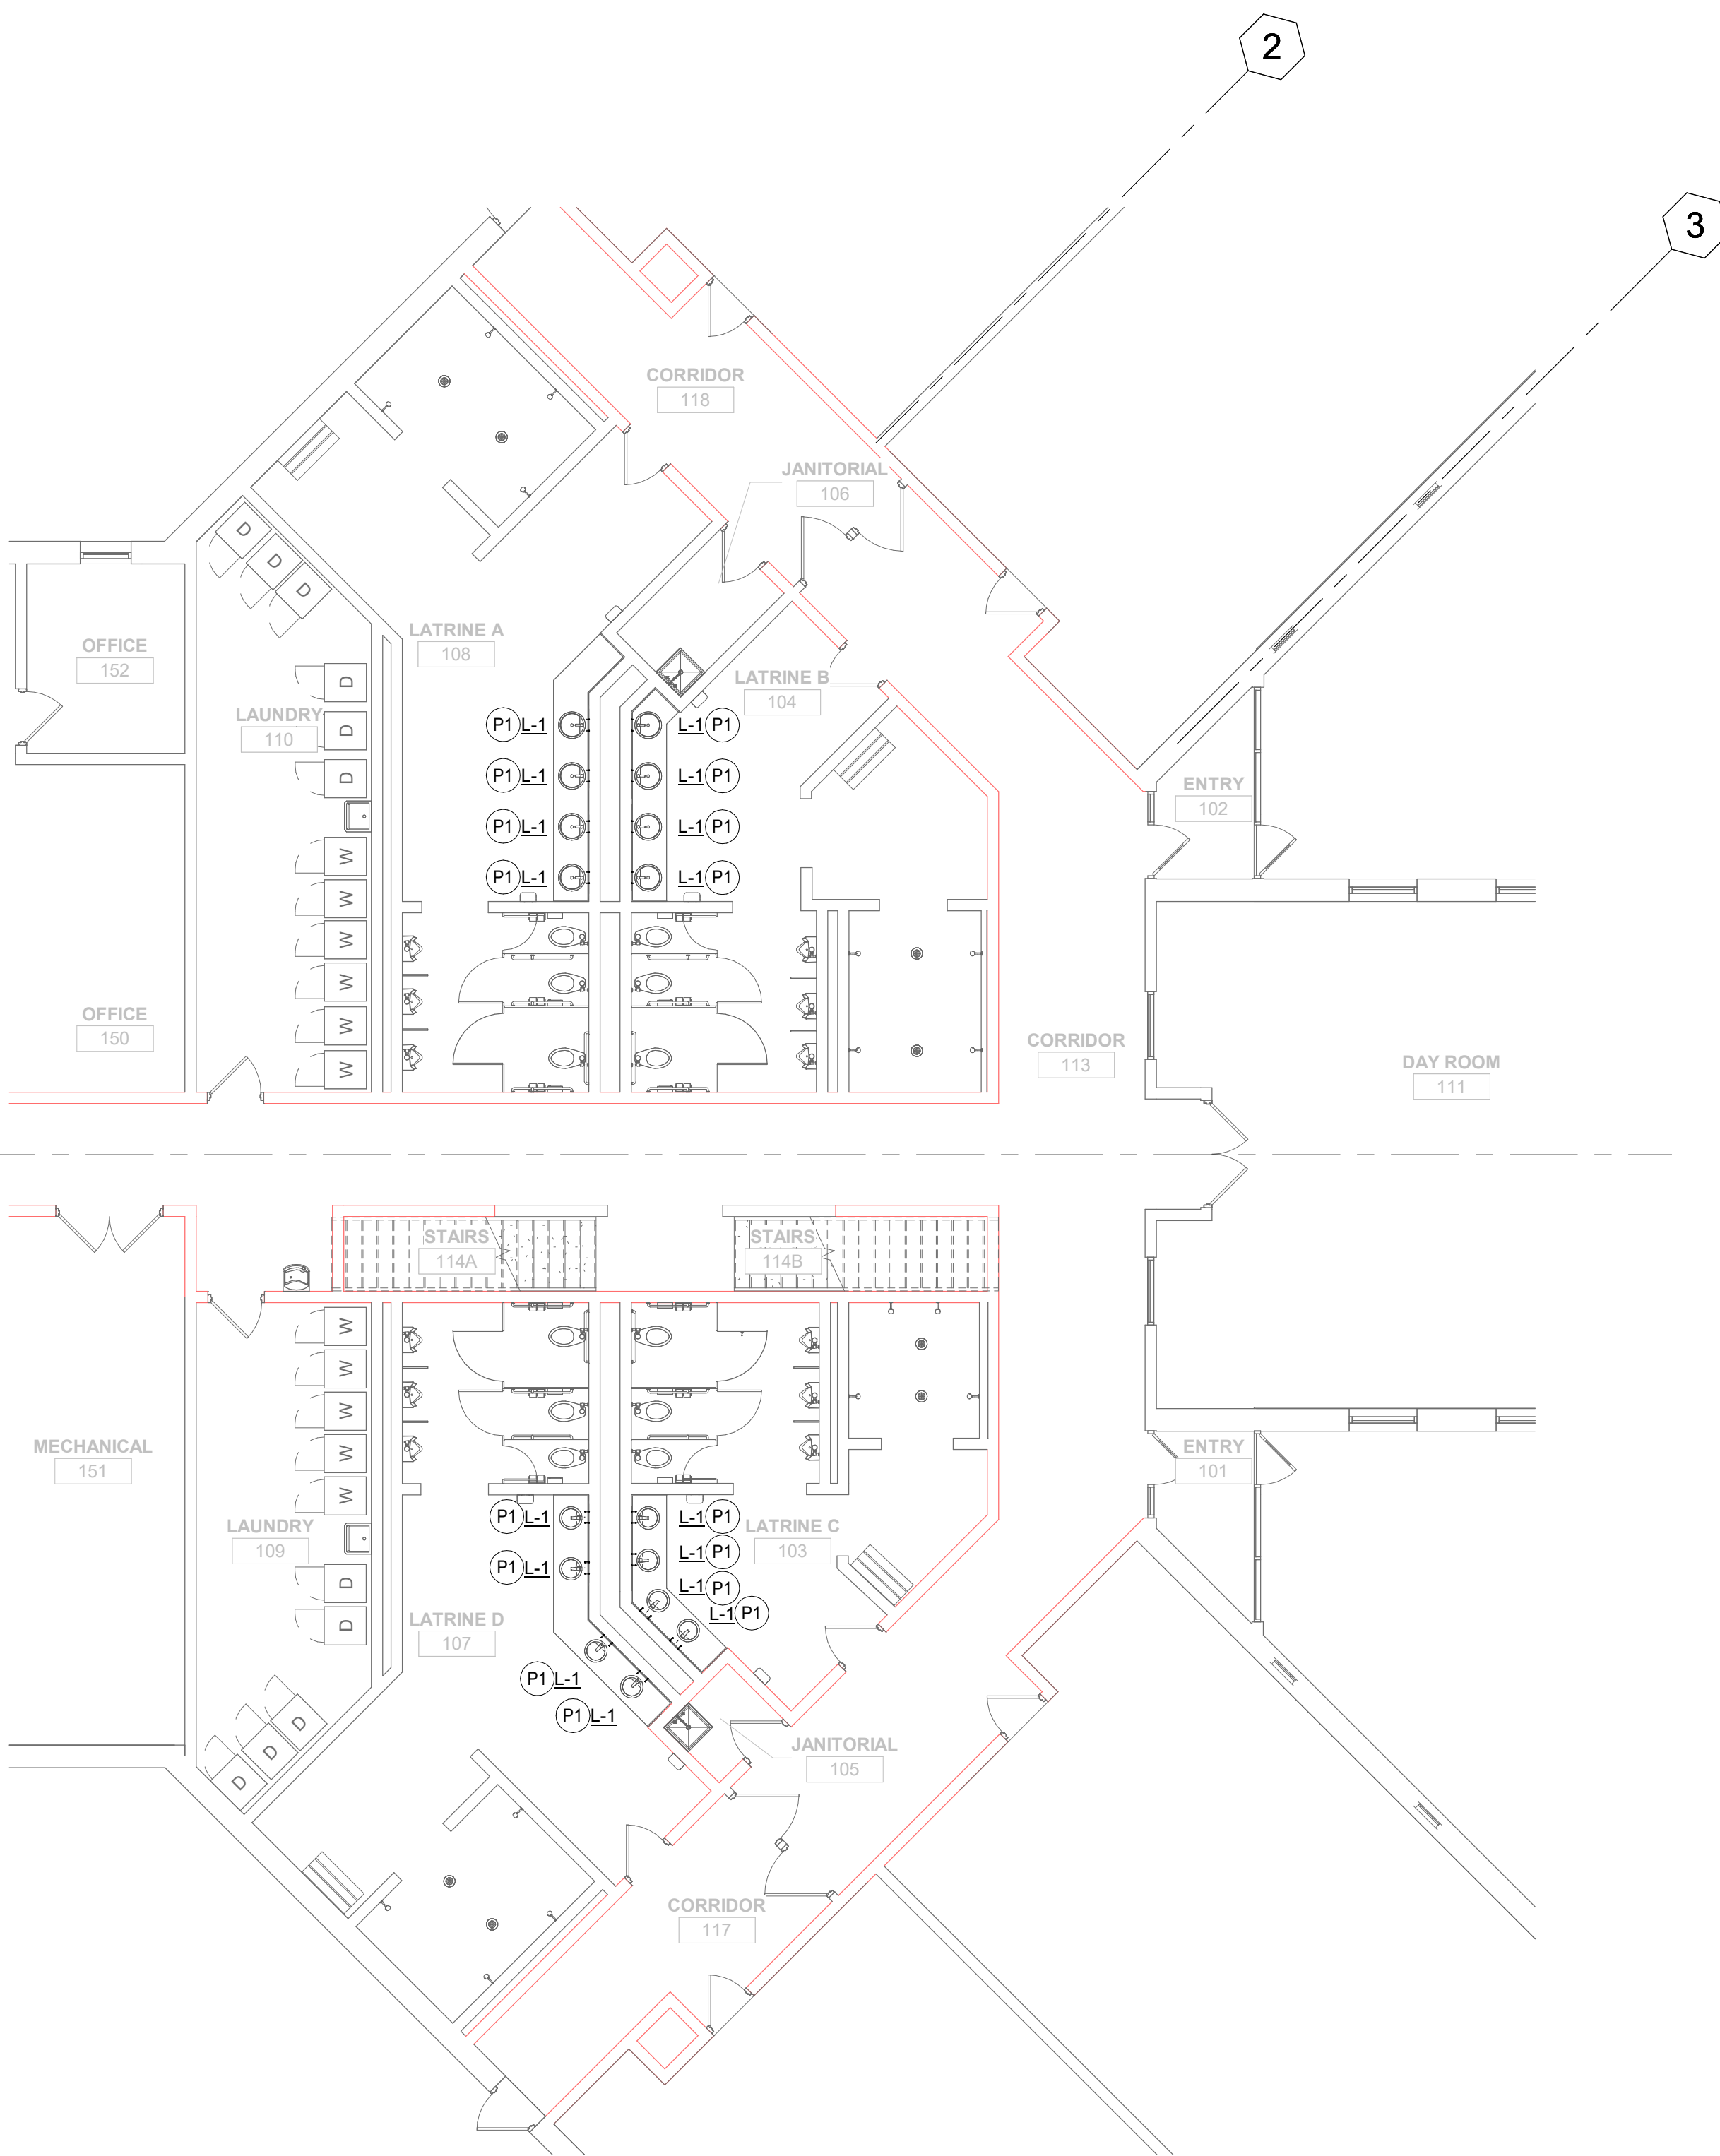

2 FIRST FLOOR PLUMBING PLAN
1/8" = 1'-0"

ISG

KEYPLAN

THIS DOCUMENT IS THE PROPERTY OF I & S GROUP, INC. AND MAY NOT BE USED, COPIED OR DUPLICATED WITHOUT PRIOR WRITTEN CONSENT.

PROJECT

IOWA ARMY
NATIONAL GUARD
S54 FINISH
UPGRADES

CAMP DODGE, JOHNSTON IOWA

REVISION SCHEDULE

DATE	DESCRIPTION	BY

PROJECT NO. 26-34920
FILE NAME 34920 Mech R26
DRAWN BY AWP
DESIGNED BY AWP
REVIEWED BY AWP
ORIGINAL ISSUE DATE 09/08/26
CLIENT PROJECT NO. 19083733

TITLE

FIRST FLOOR
PLUMBING PLAN

SHEET

P2-12




SHEET NOTES

1. FIELD VERIFY ALL SITE CONDITIONS BEFORE STARTING CONSTRUCTION.
2. ALL EXISTING DUCTWORK, PIPING, EQUIPMENT, ETC. INDICATED ON PLANS ARE BASED ON INFORMATION FROM CONSTRUCTION DOCUMENTS AND FIELD VERIFICATION OF EXISTING BUILDING.
3. COORDINATE INSTALLATION OF ALL NEW DUCTWORK, PIPING, EQUIPMENT, ETC. WITH OTHER TRADES.

KEYNOTE LEGEND

- D1 REMOVE AND DISPOSE OF EXISTING LAVATORY, LAVATORY FAUCET, TRAP, SUPPLIES AND STOPS BACK TO WALL. PREPARE REMAINING PIPING FOR NEW CONNECTIONS.
- P1 INSTALL LAVATORY INTO NEW COUNTERTOP, CONNECT FIXTURE TO EXISTING ROUGH-IN FOR SUPPLY AND SANITARY PIPING. COORDINATE NEW PIPING WITH NEW CASEWORK'S KNEE GUARD.

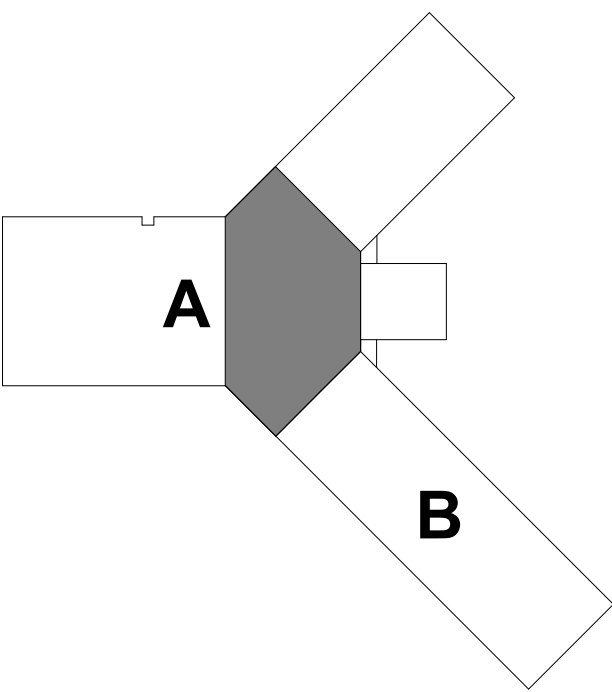

KEYPLAN

THIS DOCUMENT IS THE PROPERTY OF I & S GROUP, INC. AND MAY NOT BE USED, COPIED OR DUPLICATED WITHOUT PRIOR WRITTEN CONSENT.

PROJECT

IOWA ARMY
NATIONAL GUARD
S54 FINISH
UPGRADES

CAMP DODGE, JOHNSTON IOWA

REVISION SCHEDULE

DATE	DESCRIPTION	BY


PROJECT NO.	26-34920
FILE NAME	34920 Mech R26
DRAWN BY	AWP
DESIGNED BY	AWP
REVIEWED BY	AWP
ORIGINAL ISSUE DATE	09/08/26
CLIENT PROJECT NO.	19083733

TITLE


SECOND FLOOR
PLUMBING PLAN

SHEET

P2-13

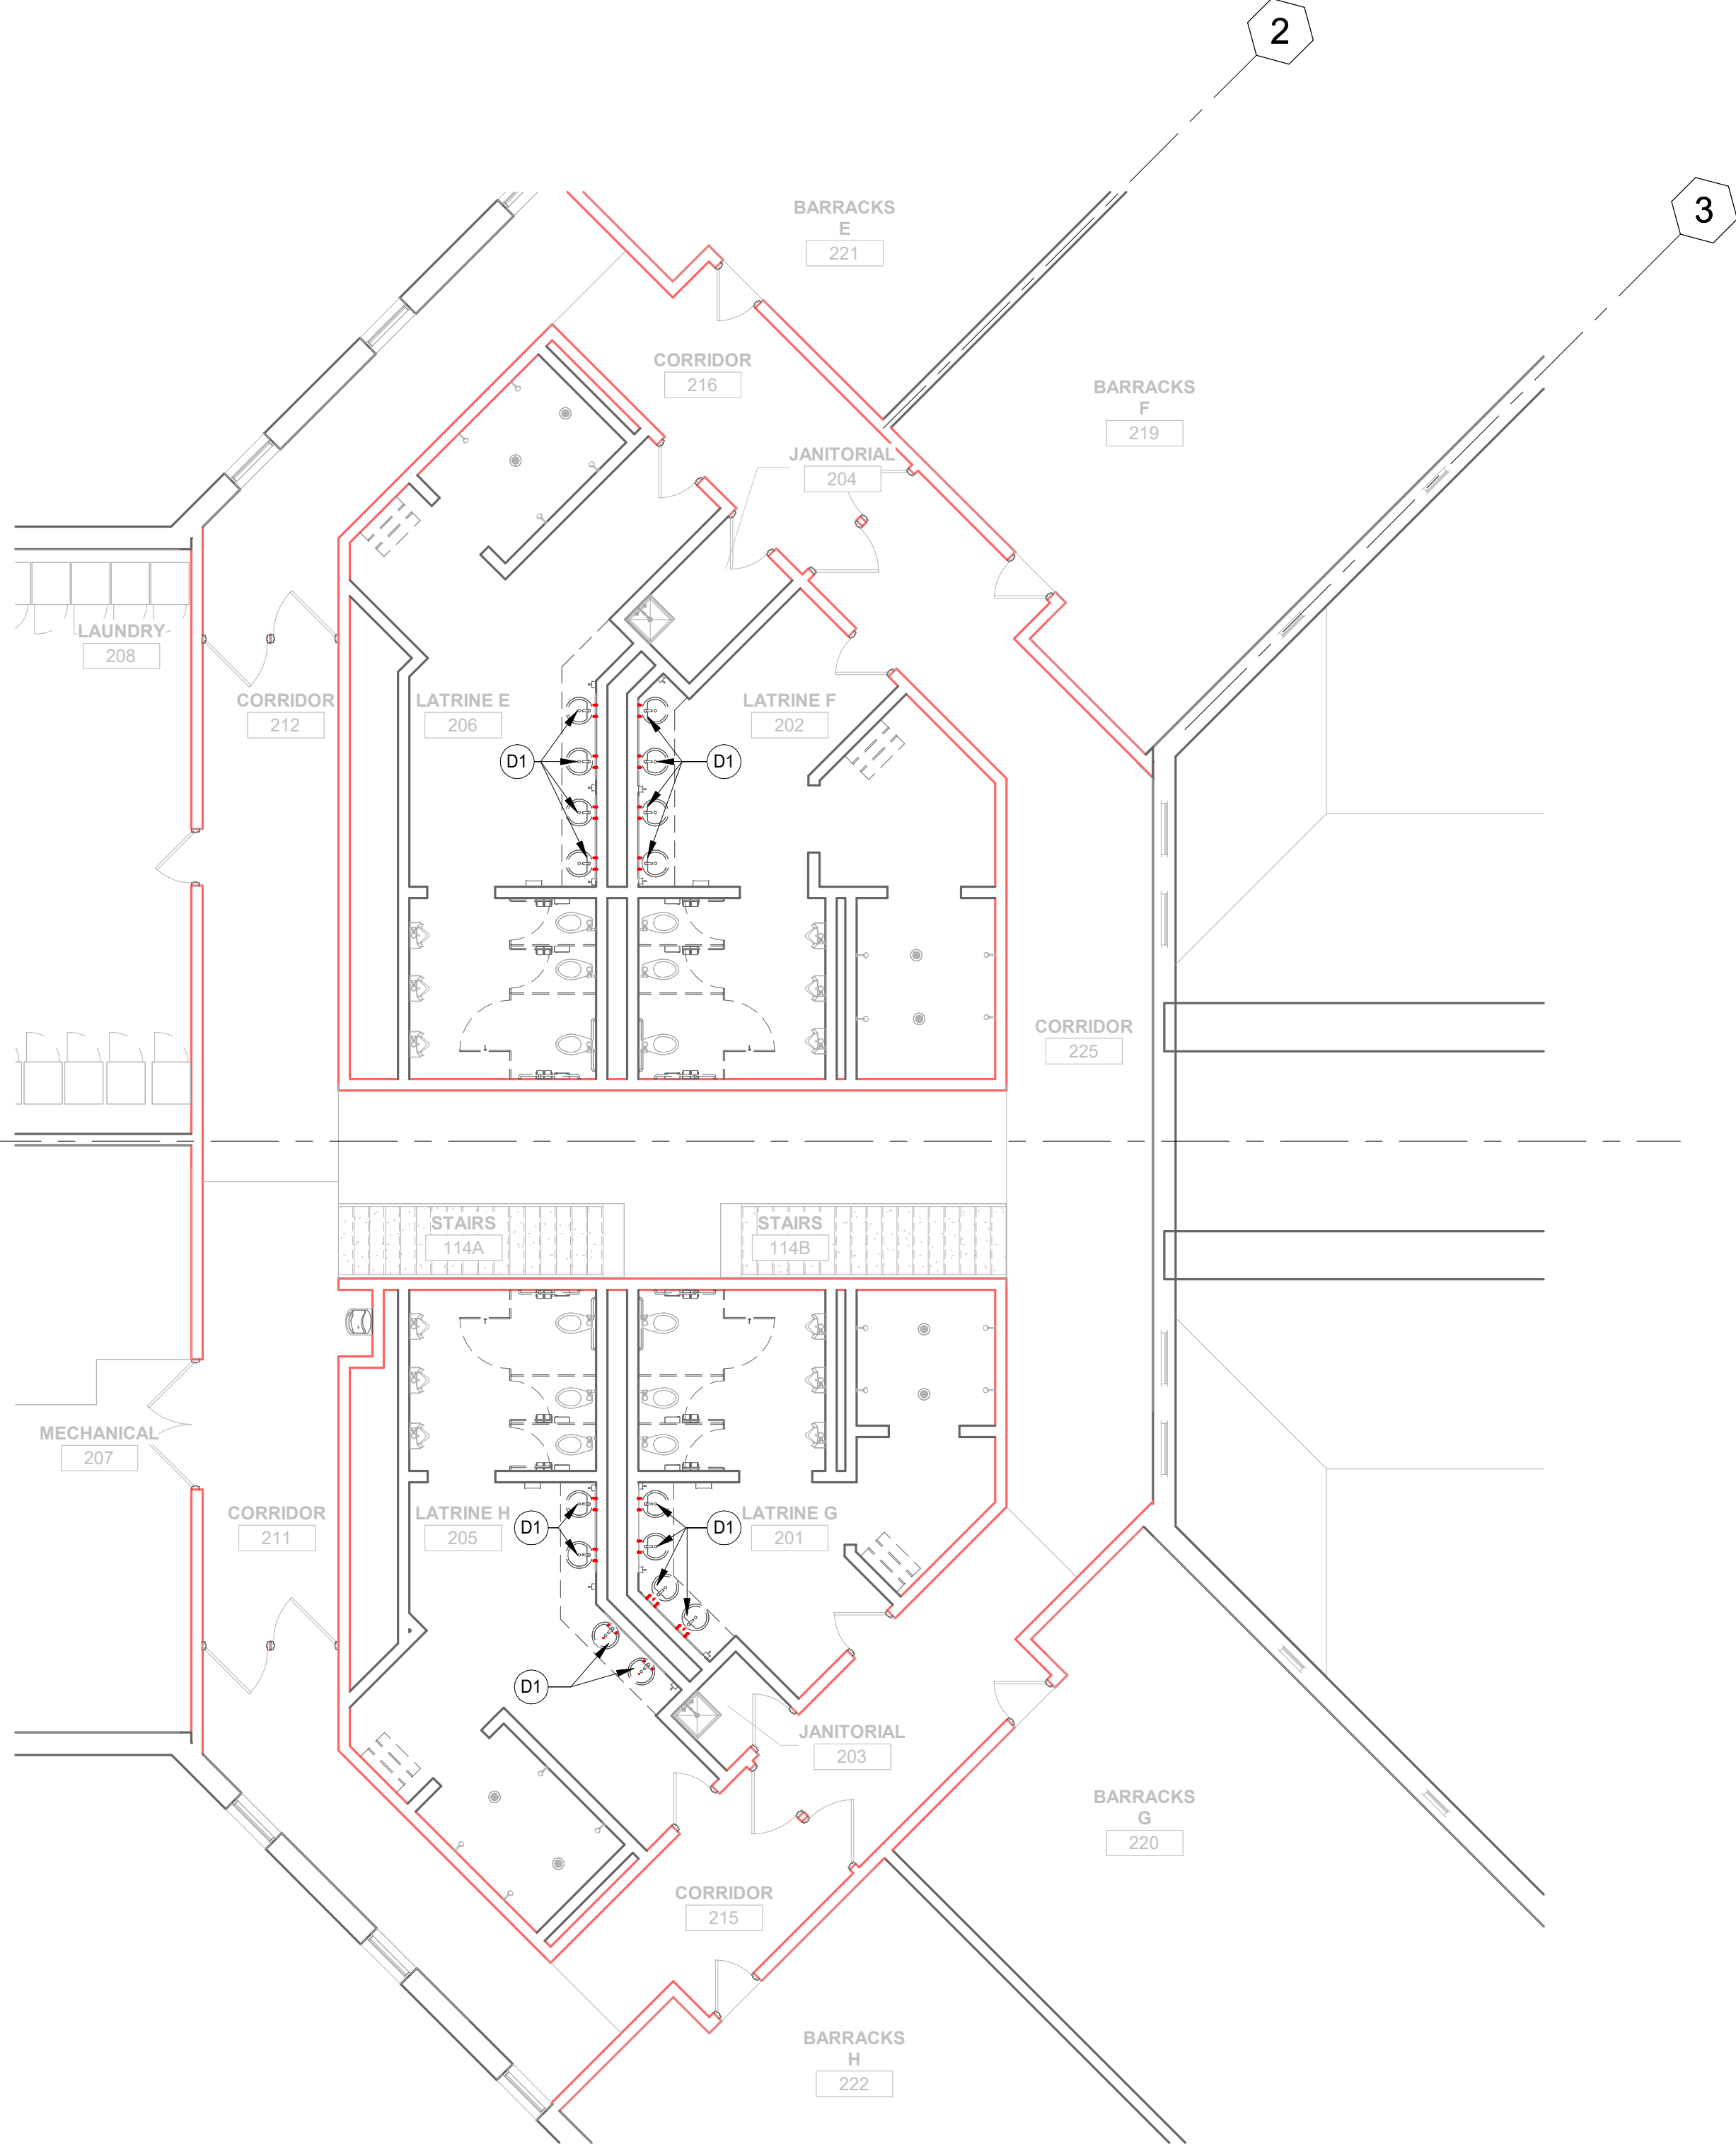

1 DEMOLITION SECOND FLOOR PLUMBING PLAN
1/8" = 1'-0"

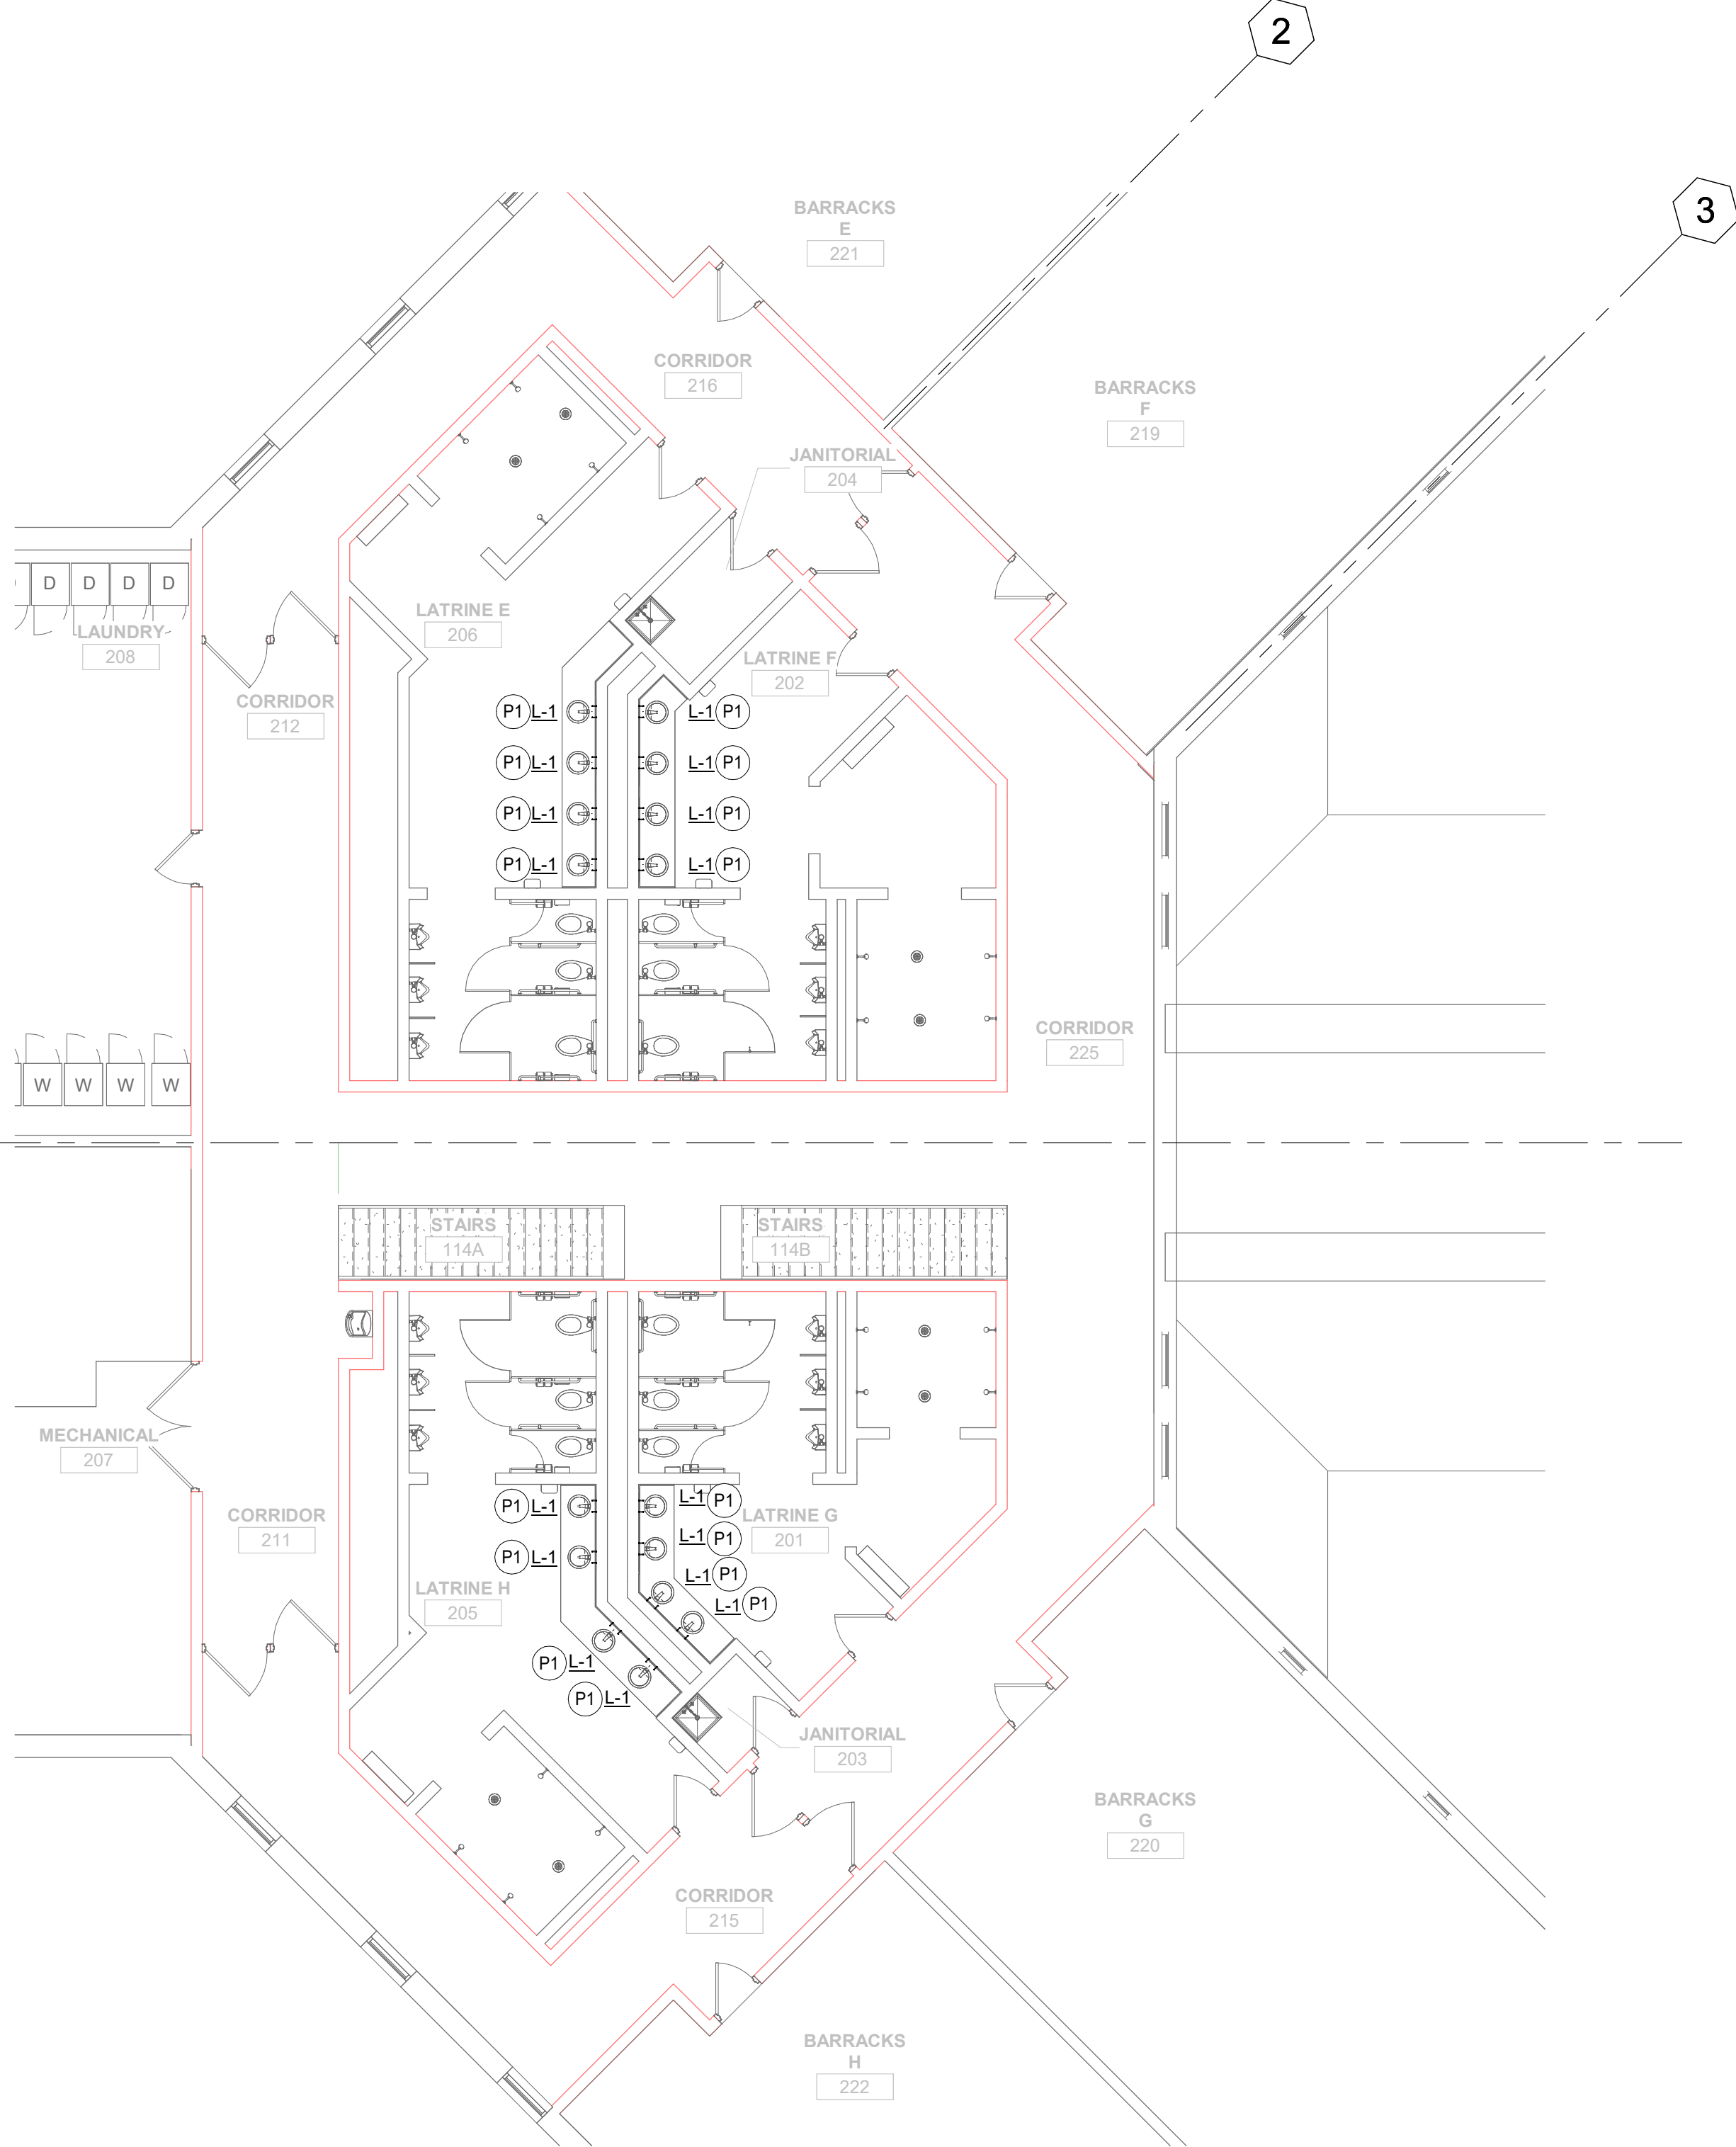

2 SECOND FLOOR PLUMBING PLAN
1/8" = 1'-0"

REFERENCE SCALE
0' 1/4" 1/2" 1' 2'

9/8/2026 3:17:56 PM




SHEET NOTES

1. ALL EXISTING ELECTRICAL EQUIPMENT INDICATED ON PLANS ARE BASED ON INFORMATION FROM CONSTRUCTION DOCUMENTS AND FIELD OBSERVATION OF THE EXISTING BUILDING.
2. "X" = INDICATES EXISTING DEVICE TO REMAIN.
3. MAINTAIN FIRE RATING OF ALL WALLS AND FLOORS. PROVIDE FIRE PROOFING FOR ALL WALL AND FLOOR PENETRATIONS PER CODE.
4. COORDINATE WORK WITH OTHER TRADES.
5. CIRCUIT NUMBERS ARE USED FOR DESIGN INTENT TO EXISTING PANELBOARDS. ELECTRICAL CONTRACTOR SHALL VERIFY EXACT CIRCUIT NUMBERS IN THE FIELD.
6. NO LOADS SHALL BE PERMITTED TO BE HUNG FROM METAL ROOF DECKING. ALL HANGERS SHALL BE HUNG DIRECTLY FROM THE TOP MEMBER OF STRUCTURAL STEEL OR SUPPLEMENTARY MEMBERS ACCEPTABLE TO STRUCTURAL ENGINEER AND ONLY WITH PRIOR APPROVAL.

ELECTRICAL KEYNOTE LEGEND

- | | |
|---|--|
| 1 | EXISTING CIRCUITS CIRCUIT DESCRIPTION TO MATCH EXISTING. WHERE NO CIRCUIT DESCRIPTION IS INDICATED FIELD CONFIRM & UPDATE. IF CIRCUIT BREAKER IS UNUSED THEN LABEL AS SPARE & PLACE IN OFF POSITION. |
|---|--|

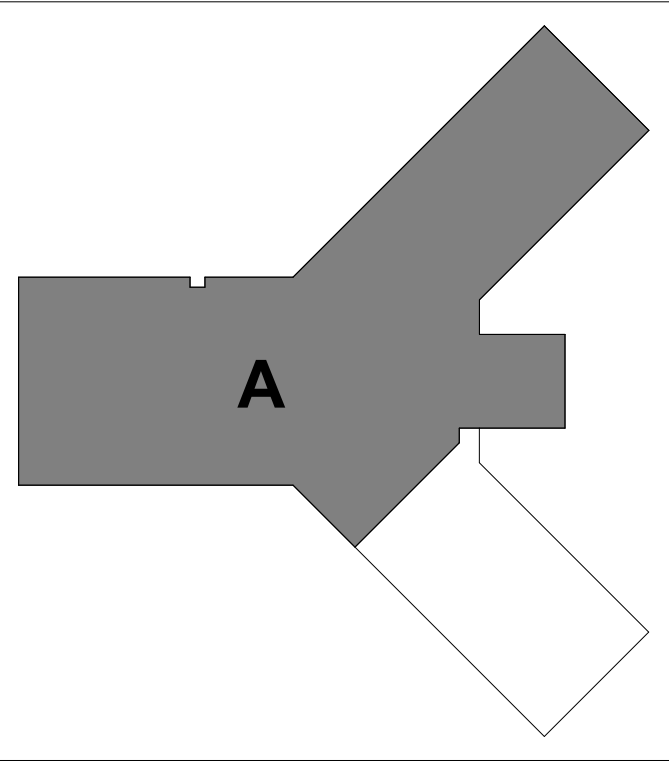

KEYPLAN

THIS DOCUMENT IS THE PROPERTY OF I & S GROUP, INC. AND MAY NOT BE USED, COPIED OR DUPLICATED WITHOUT PRIOR WRITTEN CONSENT.

PROJECT

IOWA ARMY
NATIONAL GUARD
S54 FINISH
UPGRADES

CAMP DODGE, JOHNSTON IOWA

REVISION SCHEDULE		
DATE	DESCRIPTION	BY


PROJECT NO.	26-34920
FILE NAME	34920 Elec R26.rvt
DRAWN BY	DCP
DESIGNED BY	DCP
REVIEWED BY	CGL
ORIGINAL ISSUE DATE	09-08-2026
CLIENT PROJECT NO.	19083733

TITLE

FIRST FLOOR
POWER AND
SYSTEMS PLAN -
AREA A

SHEET

E2-11A

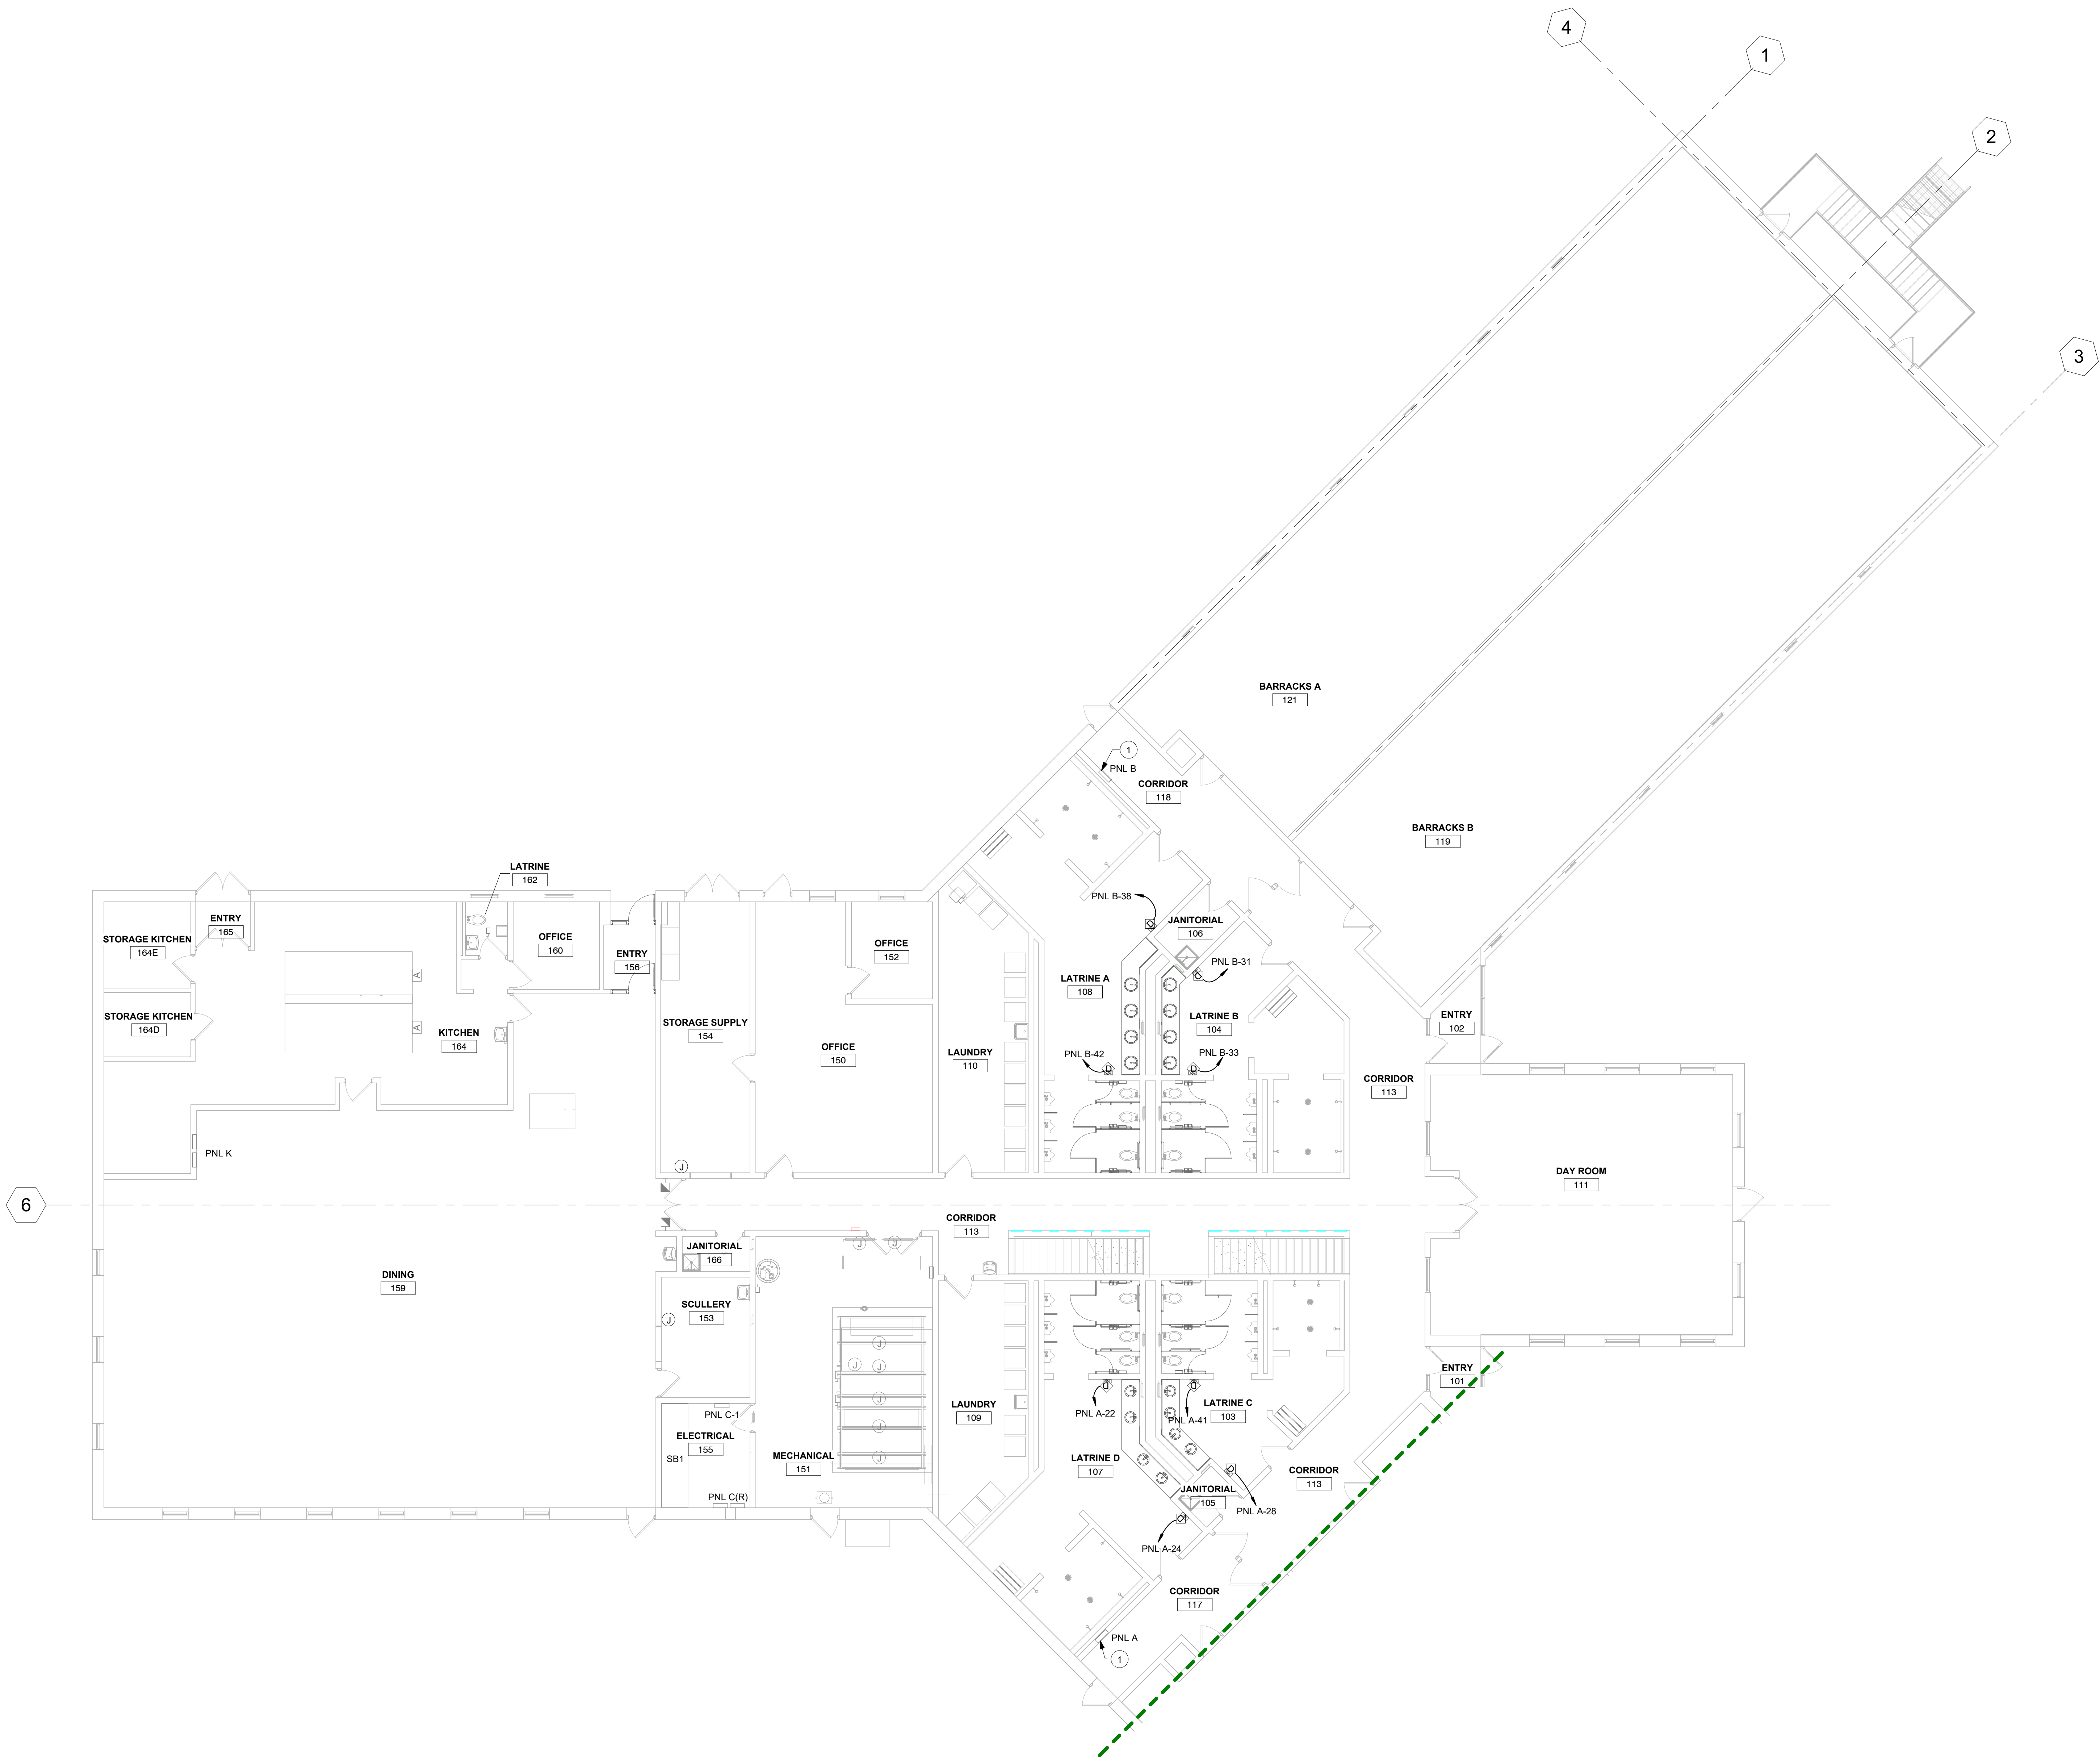

1 FIRST FLOOR POWER AND SYSTEMS PLAN - AREA A
1/8" = 1'-0"

REFERENCE SCALE
1" = 1'-0"
0 1/4" 1/2" 1" 2"

9/8/2026 3:12:20 PM




SHEET NOTES

1. ALL EXISTING ELECTRICAL EQUIPMENT INDICATED ON PLANS ARE BASED ON INFORMATION FROM CONSTRUCTION DOCUMENTS AND FIELD OBSERVATION OF THE EXISTING BUILDING.
2. "X" = INDICATES EXISTING DEVICE TO REMAIN.
3. MAINTAIN FIRE RATING OF ALL WALLS AND FLOORS. PROVIDE FIRE PROOFING FOR ALL WALL AND FLOOR PENETRATIONS PER CODE.
4. COORDINATE WORK WITH OTHER TRADES.
5. CIRCUIT NUMBERS ARE USED FOR DESIGN INTENT TO EXISTING PANELBOARDS. ELECTRICAL CONTRACTOR SHALL VERIFY EXACT CIRCUIT NUMBERS IN THE FIELD.
6. NO LOADS SHALL BE PERMITTED TO BE HUNG FROM METAL ROOF DECKING. ALL HANGERS SHALL BE HUNG DIRECTLY FROM THE TOP MEMBER OF STRUCTURAL STEEL OR SUPPLEMENTARY MEMBERS ACCEPTABLE TO STRUCTURAL ENGINEER AND ONLY WITH PRIOR APPROVAL.

ELECTRICAL KEYNOTE LEGEND

- 1 EXISTING CIRCUITS CIRCUIT DESCRIPTION TO MATCH EXISTING. WHERE NO CIRCUIT DESCRIPTION IS INDICATED FIELD CONFIRM & UPDATE. IF CIRCUIT BREAKER IS UNUSED THEN LABEL AS SPARE & PLACE IN OFF POSITION.

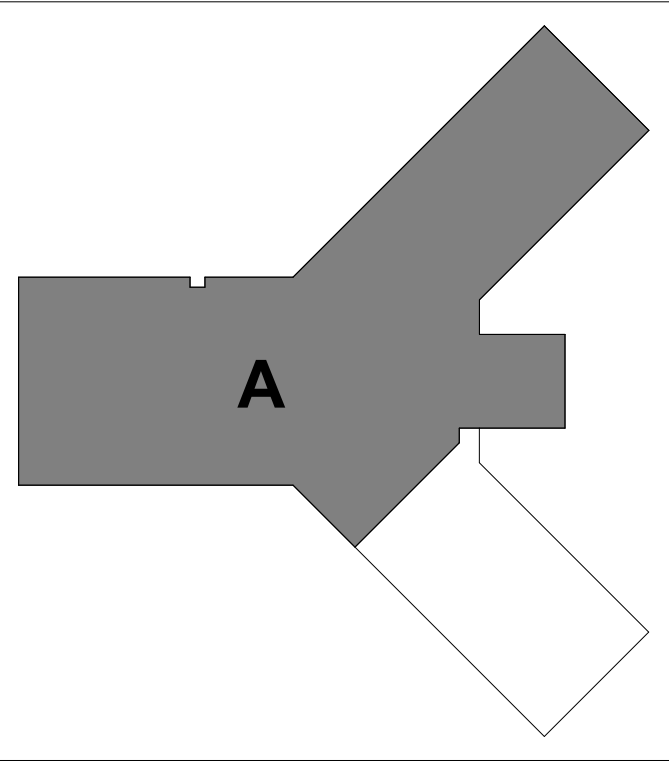

KEYPLAN

THIS DOCUMENT IS THE PROPERTY OF I & S GROUP, INC. AND MAY NOT BE USED, COPIED OR DUPLICATED WITHOUT PRIOR WRITTEN CONSENT.

PROJECT

IOWA ARMY
NATIONAL GUARD
S54 FINISH
UPGRADES

CAMP DODGE, JOHNSTON IOWA

REVISION SCHEDULE		
DATE	DESCRIPTION	BY


PROJECT NO.	26-34920
FILE NAME	34920 Elec R26.rvt
DRAWN BY	DCP
DESIGNED BY	DCP
REVIEWED BY	CGL
ORIGINAL ISSUE DATE	09-08-2026
CLIENT PROJECT NO.	19083733

TITLE

SECOND FLOOR
POWER AND
SYSTEMS PLAN -
AREA A

SHEET

E2-12A

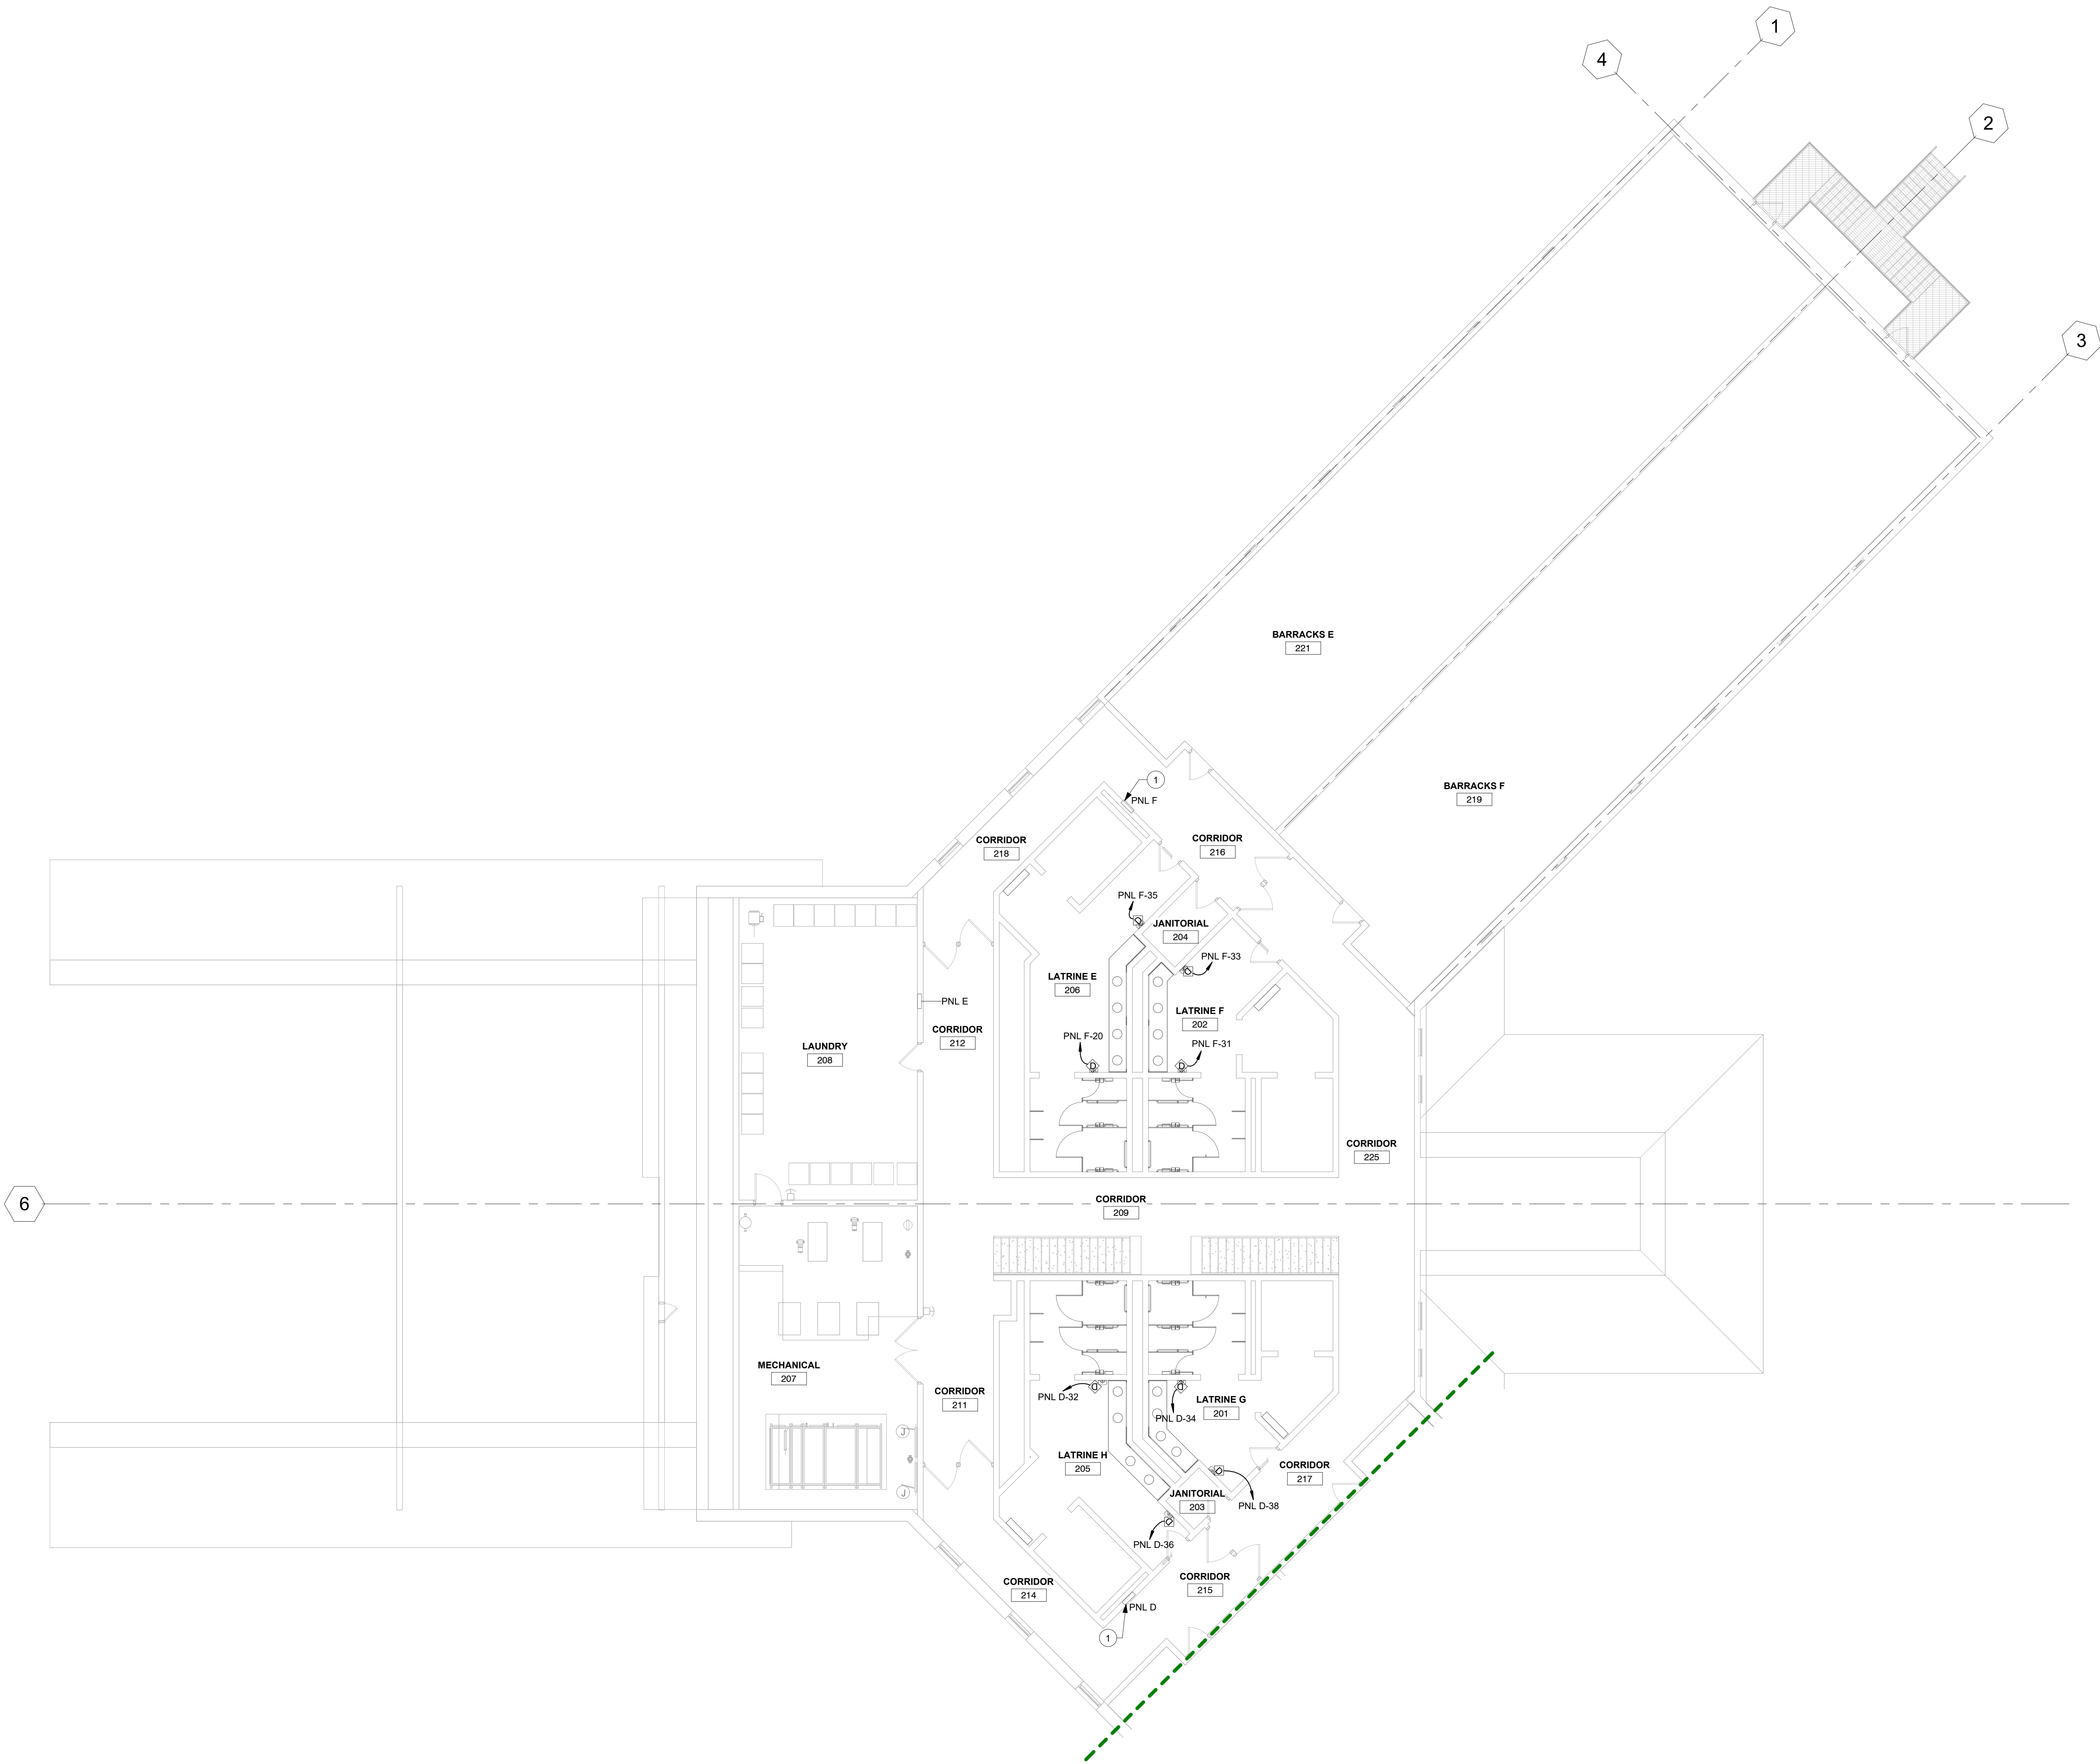

1 SECOND FLOOR POWER AND SYSTEMS PLAN - AREA A
1/8" = 1'-0"





Existing Panel: PNL F

Location: CORRIDOR 216

Supply From:

Mounting: Recessed

Enclosure: Type 1

Volts: 120/208 Vye

Phases: 3

Wires: 4

A.I.C. Rating: 10 KAIC

Maine Type: MLO

Mains Rating: 225 A

MCB Rating: 200 A

Notes:

EXISTING SQUARE D NQ PANEL

Note			Trip	Pole										Pole	Trip				CKT	Note
	CKT	Circuit Description			A	B	C	Circuit Description												
	1	REC W WING W WALL	20 A	1	0	210							1	20 A	BARRACKS 219 - W WALL	2	1			
	1	3 REC W WING W WALL	20 A	1			0	1300					1	20 A	BARRACKS 221 - CLG...	4	1			
	1	5 REC W WING W WALL	20 A	1					0	0			1	20 A	CEILING LTS WEST WING	6	1			
	1	7 REC W WING E WALL	20 A	1	0	196							1	20 A	BARRACKS 221 - W WALL	8	1			
	1	9 REC W WING E WALL	20 A	1			0	196					1	20 A	BARRACKS 219 - E WALL	10	1			
	1	11 REC W WING E WALL	20 A	1					0	1300			1	20 A	BARRACKS 219 - CLG...	12	1			
	1	13 REC E WING W WALL	20 A	1	0	0							1	20 A	CEILING LTS EAST WING	14	1			
	1	15 REC E WING W WALL	20 A	1			0	210					1	20 A	BARRACKS 221 - E WALL	16	1			
	1	17 REC E WING W WALL	20 A	1					0	688			1	20 A	202,204,206 - LIGHTING	18	1			
	1	19 REC E WING E WALL	20 A	1	0	516							1	15 A	LATRINE 206 HAND DRYER	20	3			
	1	21 REC E WING E WALL	20 A	1			0	1023					1	20 A	CORRIDOR - LIGHTING	22	1			
	1	23 DRINKING FOUNTAIN	20 A	1					0	0	0		1	20 A	BATHROOM & PHONE REC	24	1			
1	25				1224	0							1	20 A	ATTIC LTS	26	1			
	27	EF-5 EXHAUST FAN	20 A	3			1224	0					1	20 A	SPARE	28	1			
	29								1224	0			1	20 A	REC E WING E WALL	30	1			
3	31	LATRINE 202 HAND DRYER	20 A	1	516	0							1	20 A	SPARE	32	1			
3	33	LATRINE 202 HAND DRYER	20 A	1			516	0					1	20 A	SPARE	34	1			
3	35	LATRINE 206 HAND DRYER	20 A	1					516	0			1	20 A	SPARE	36	1			
1	37	SPARE	20 A	1	0	0							1	20 A	SPARE	38	1			
1	39	SPARE	20 A	1			0	0					1	20 A	SPARE	40	1			
1	41	SPARE	20 A	1					0	0			1	20 A	SPARE	42	1			
Total Load:					2645 VA			4420 VA			3681 VA									
Total Amps:					22 A			38 A			32 A									

NOTE:

'1' DENOTES EXISTING CIRCUIT

'2' DENOTES NEW CIRCUIT UTILIZING EXISTING BREAKER

'3' DENOTES NEW CIRCUIT AND BREAKER

ELECTRICAL SYMBOLS, PANELBOARDS SCHEDULES