


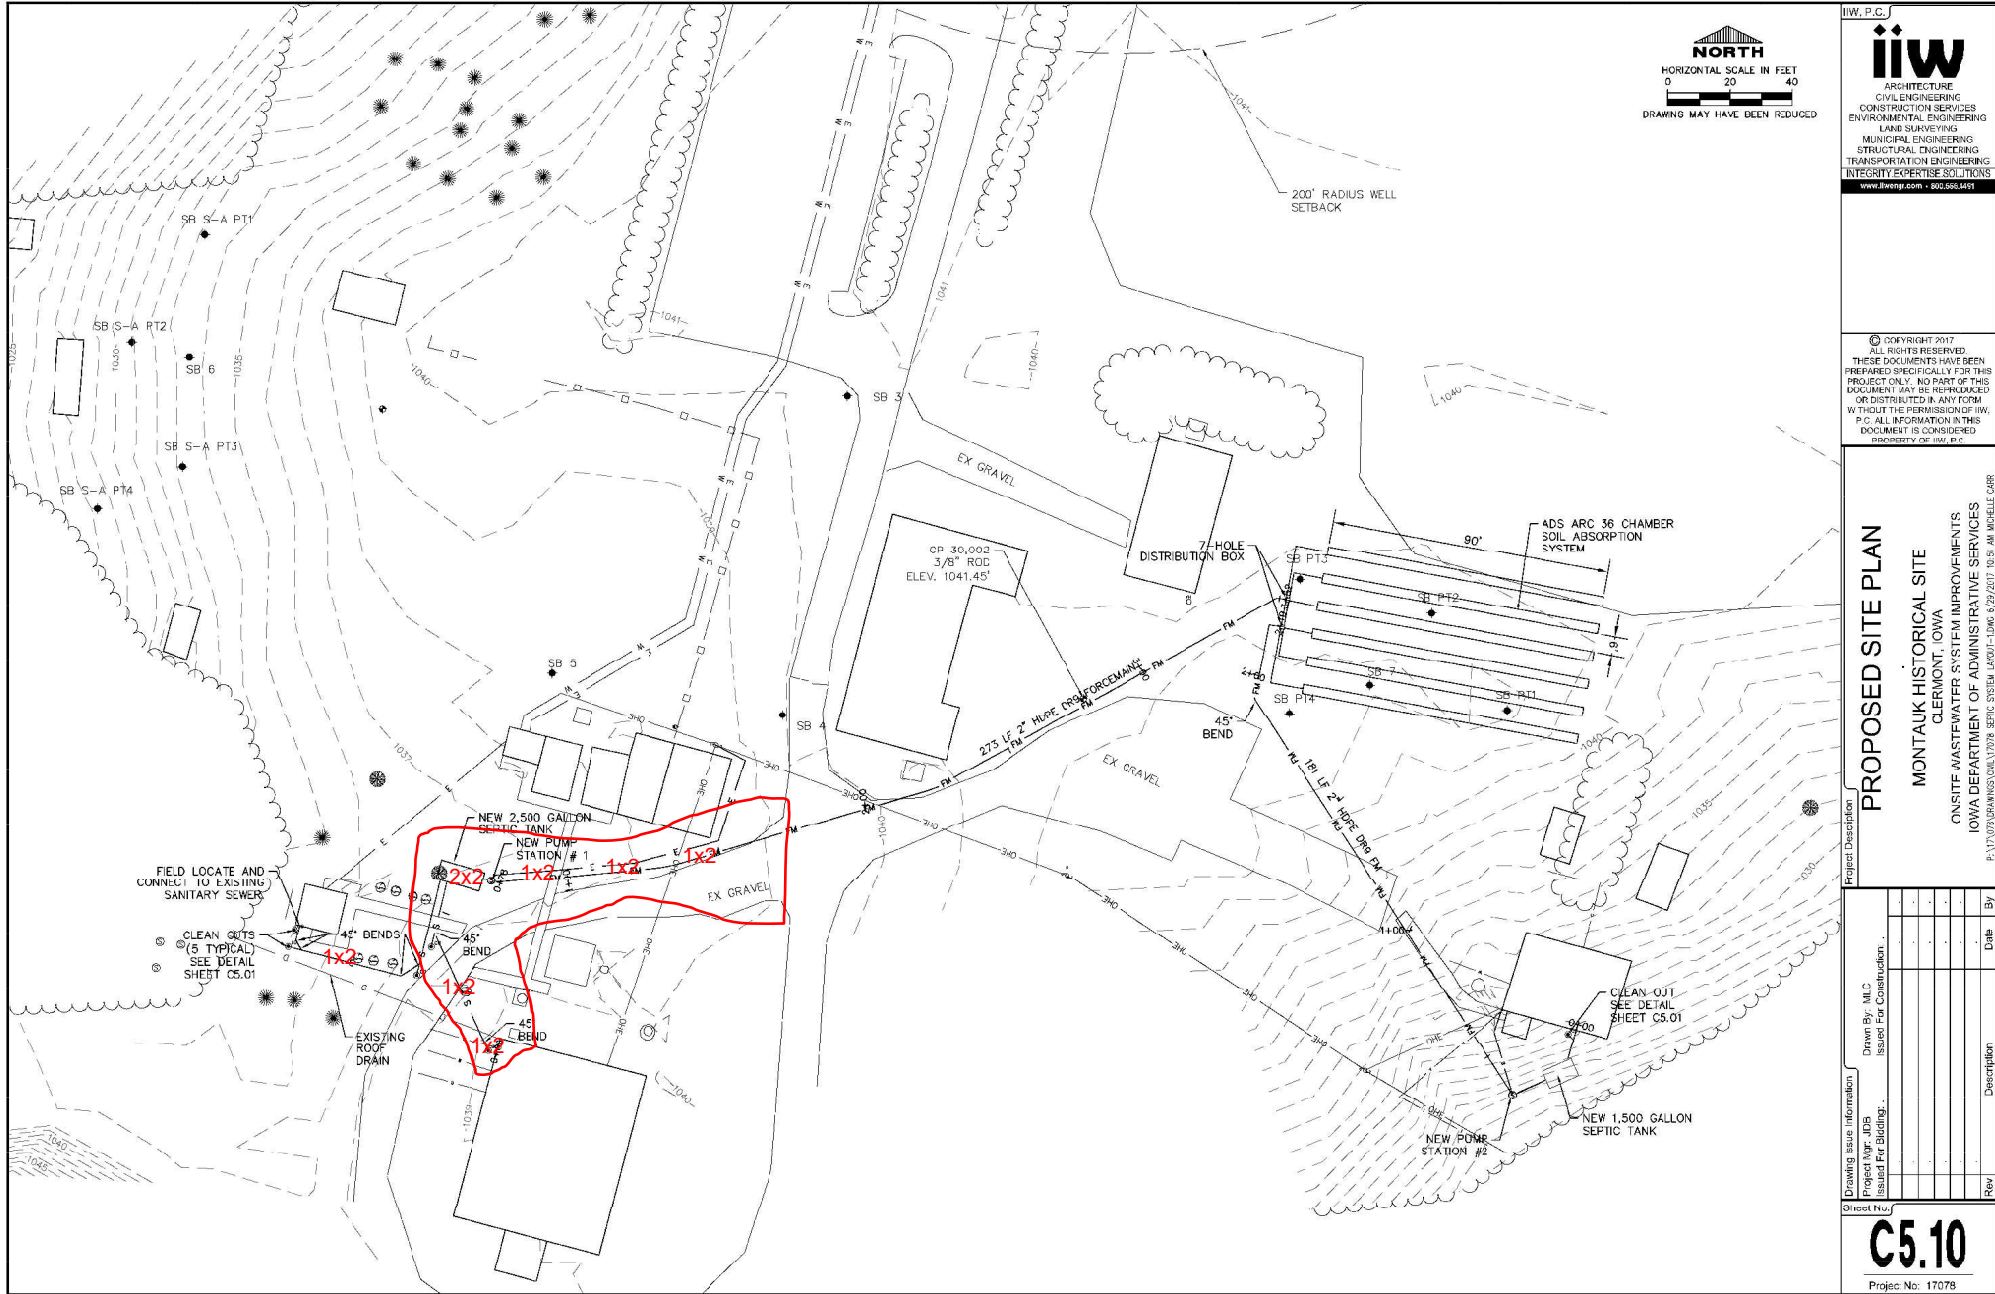

iiw P.C.
iiw
ARCHITECTURE
CIVIL ENGINEERING
CONSTRUCTION SERVICES
ENVIRONMENTAL ENGINEERING
LAND SURVEYING
MUNICIPAL ENGINEERING
STRUCTURAL ENGINEERING
TRANSPORTATION ENGINEERING
INTEGRITY EXPERTISE SOLUTIONS
www.iiw.com • 802.582.4151

© COPYRIGHT 2017
ALL RIGHTS RESERVED.
THESE DOCUMENTS HAVE BEEN
PREPARED SPECIFICALLY FOR THIS
PROJECT ONLY. NO PART OF THIS
DOCUMENT (ANY REPRODUCTION
OR DISTRIBUTION IN ANY FORM
WITHOUT THE PERMISSION OF IIW,
P.C.) ALL INFORMATION IN THIS
DOCUMENT IS CONSIDERED
PROPERTY OF IIW, P.C.

PROPOSED SITE PLAN
MONTAUK HISTORICAL SITE
CLEMONT, IOWA
ON-SITE WASTEWATER SYSTEM IMPROVEMENTS
IOWA DEPARTMENT OF ADMINISTRATIVE SERVICES
P:\17078\MONTAUK\17078_SWS_SSEI\17078_6/29/2017_02.DWG

Drawing Issue Information		Project Manager		Project Manager	
Drawn By:	MLC	Project Mgr. JDS	Issued For Construction	Project Mgr. JDS	Issued For Construction
Rev	Description	Date	By	Rev	Description

Project No: 17078
C5.10