

## RFQ #0919335134

The Iowa Department of Administrative Services – Central Procurement Bureau, Hoover State Office Building, Level 3, 1305 East Walnut Street, Des Moines, Iowa 50319 will be receiving quotes for private electrical services locating services at the State Training School for Boys in Eldora, Iowa 50627.

Quotes must be received no later than **2:00 pm, local time, Friday, May 3, 2019**. Quotes are to be delivered via e-mail to Steve Oberbroeckling at [steve.oberbroeckling@iowa.gov](mailto:steve.oberbroeckling@iowa.gov).

### Schedule

May 3, 2019 – Quotations due.

May 6 – May 10, 2019 - Order executed between the DAS and the Contractor.

May 6 – May 10, 2019 – Submit and run background check.

May 13 – Start locating services.

### Scope

1. Locate existing, privately owned electrical circuits generally shown on the attached drawings.
2. STS personnel will accompany and assist the locator.
3. The Department request a daily rate for this RFQ which shall include all costs such as direct labor costs, indirect labor costs, marking materials, equipment, travel time, travel expenses, etc.
4. For the purposes of this RFQ, a day shall include being onsite performing locating services for a minimum of 6 (six) hours.
5. Work is to be performed Monday through Friday.
6. Outside of this scope, a surveying crew will be following behind the locator to document locations.
7. All personnel coming onto the site will have to pass a background check prior to entry. There is no fee to the Contractor and the application form is attached for use after award.

The Iowa Department of Administrative Services reserves the right to reject any and all quotes, and to waive irregularities and to accept a quote that is deemed in the best interest of the State of Iowa.

This project is exempt from Iowa Sales Tax. Davis Bacon Wages **will not** apply to this project.

For further information regarding this project contact:

Steve Oberbroeckling – Issuing Officer

Iowa Department of Administrative Services – Central Procurement Bureau

1305 East Walnut Street

Des Moines, Iowa 50319

Phone: (515) 725-2090

E-Mail: [steve.oberbroeckling@iowa.gov](mailto:steve.oberbroeckling@iowa.gov)

**END OF SECTION**



# STATE OF IOWA

## Criminal History Record Check Request Form



DCI Account Number: \_\_\_\_\_  
(if applicable)

**To: Iowa Division of Criminal Investigation**  
**Support Operations Bureau, 1<sup>st</sup> Floor**  
 215 E. 7<sup>th</sup> Street  
 Des Moines, Iowa 50319  
 (515) 725-6066  
 (515) 725-6080 Fax

**From: Story Construction**  
 \_\_\_\_\_  
**Janie Bates**  
 \_\_\_\_\_  
**janie.bates@storycon.com**  
 \_\_\_\_\_  
**Phone: 515-817-2602**  
 \_\_\_\_\_  
**Fax: 515-232-1981**  
 \_\_\_\_\_

I am requesting an Iowa Criminal History Record Check on:

<b>Last Name</b> (mandatory)	<b>First Name</b> (mandatory)	<b>Middle Name</b> (recommended)
<b>Date of Birth</b> (mandatory)	<b>Gender</b> (mandatory)	<b>Social Security Number</b> (mandatory)
	<input type="checkbox"/> Male <input type="checkbox"/> Female	

**Waiver Information:** Without a signed waiver from the subject of the request, a complete criminal history record may not be releasable, per Code of Iowa, Chapter 692.2. For complete criminal history record information, as allowed by law, always obtain a waiver signature from the subject of the request.

**Waiver Release:** I hereby give permission for the above requesting official to conduct an Iowa criminal history record check with the Division of Criminal Investigation (DCI). Any criminal history data concerning me that is maintained by the DCI may be released as allowed by law.

**Waiver Signature:** \_\_\_\_\_

### Iowa Criminal History Record Check Results

(DCI use only)

As of \_\_\_\_\_, a search of the provided name and date of birth revealed:

- No Iowa Criminal History Record found with DCI
- Iowa Criminal History Record attached, DCI # \_\_\_\_\_

DCI initials \_\_\_\_\_

### **Waiver Information:**

Iowa law does ***not*** require a waiver. However, without a signed waiver from the subject of the request any arrest over 18 months old, ***without*** a final disposition, cannot be released to a non-law enforcement agency.

Deferred judgments where DCI has received notice of successful completion of probation also cannot be released to non-law enforcement agencies without a signed waiver from the subject of the request.

If the “No Iowa Criminal History Record found with DCI” box is checked, it could mean that the information on file is not releasable per Iowa law without a waiver.

### **General Information:**

The information requested is based on ***name*** and ***exact date of birth only***. Without fingerprints, a ***positive*** identification cannot be assured. If a person disputes the accuracy of information maintained by the Department, they may challenge the information by writing to the address on the front of this form or personally appearing at DCI headquarters during normal business hours.

The records maintained by the Iowa Department of Public Safety are based upon reports from other criminal justice agencies and therefore, the Department cannot guarantee the completeness of the information provided.

The criminal history record check is of the Iowa Central Repository (DCI) ***only***. The DCI files do not include other states’ records, FBI records, or subjects convicted in federal court within Iowa.

In Iowa, a ***deferred judgment*** ***is not*** considered a conviction once the defendant has been discharged after successfully completing probation. However, it should be noted that a deferred judgment may still be considered as an offense when considering charges for certain specified multiple offense crimes, i.e. second offense OWI. If a disposition reflects that a deferred judgment was given, you may want to inquire of the individual his or her current status.



A ***deferred sentence*** ***is*** a conviction. The judge simply withholds implementing a sentence for a certain probationary period. If probation is successful, the sentence is not carried out.

Any questions in reference to Iowa criminal history records can be answered by writing to the address on the front of this form or calling (515) 725-6066 between 8:00 a.m. and 4:00 p.m., Monday - Friday.

**REMINDER** - (1) Send in a separate Request Form for each last name, (2) a fee is required for each last name submitted, (3) a completed Billing Form must be submitted with all request(s).

Iowa law requires employers to pay the fee for potential employees’ record checks.

\\shivehattery\work\2019\2019\02\04\15681\Drawings\DWG\1\_C300\UTILITY\_Plan.dwg  
Printed: 3/14/2019 2:31:32 PM

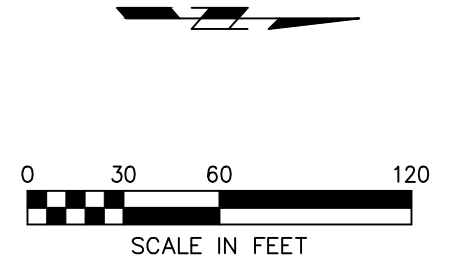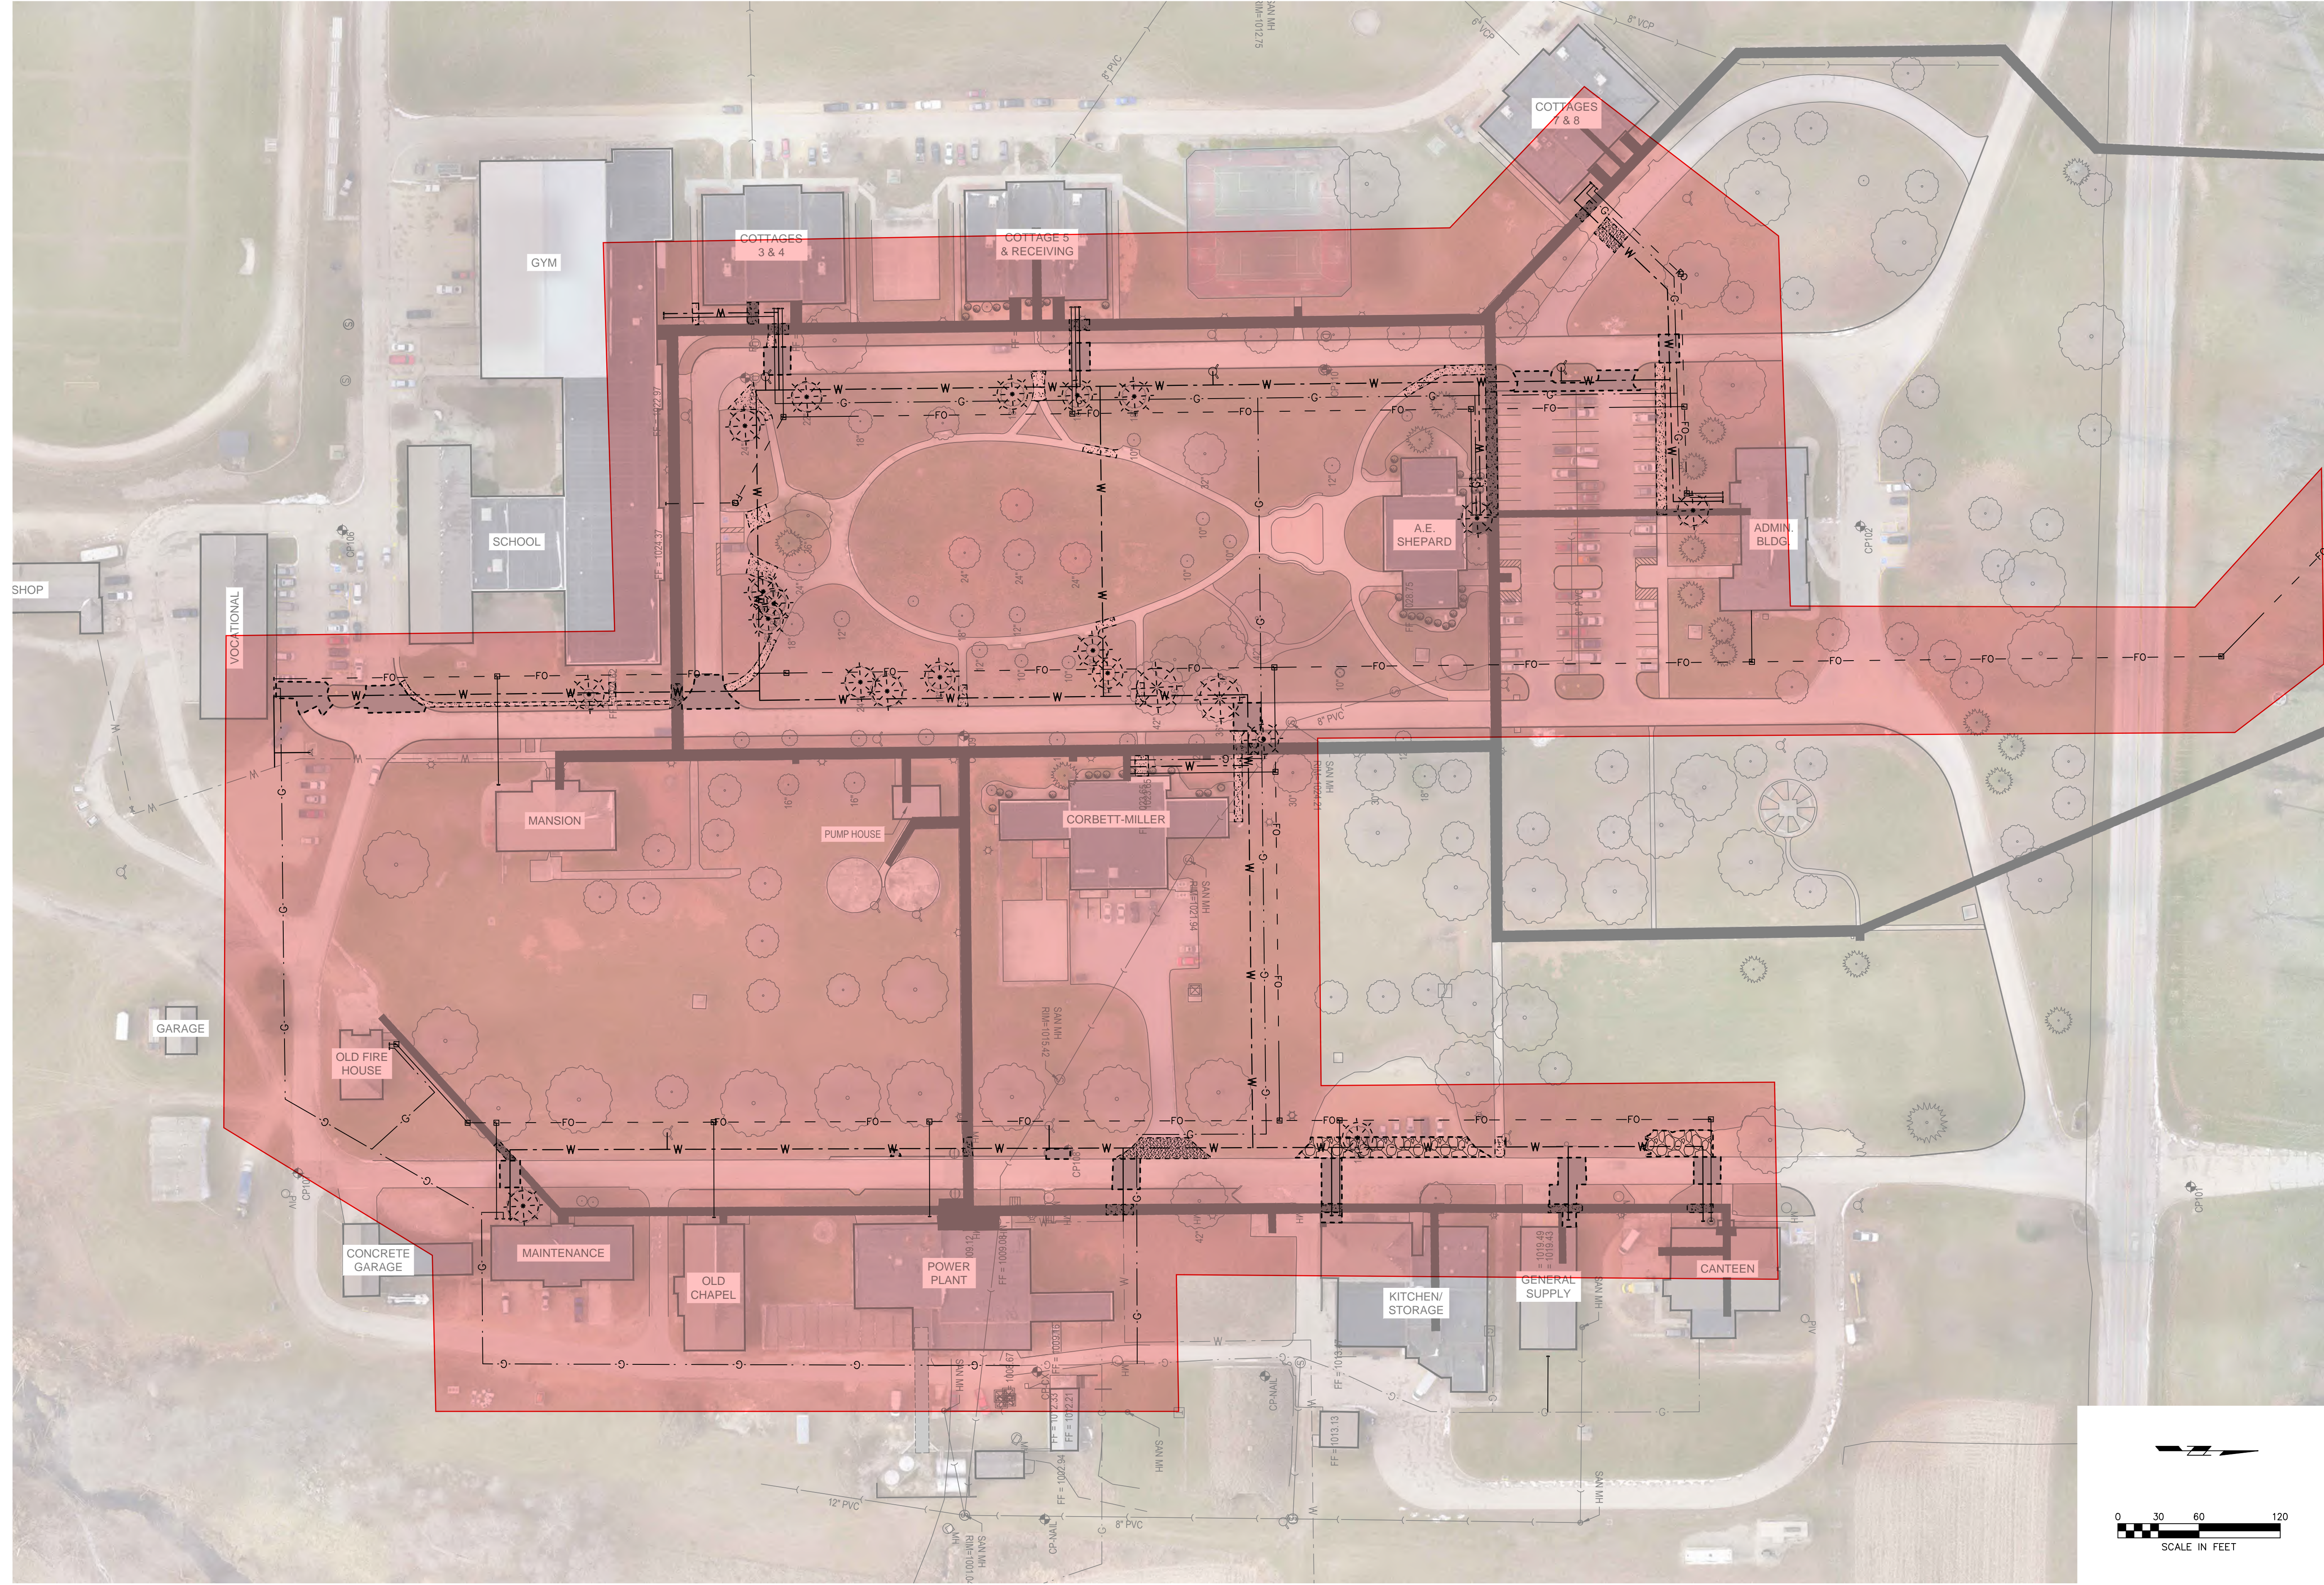

UTILITY PLAN -  
OVERALL

C300


PRELIMINARY  
- NOT FOR  
CONSTRUCTION

ELDORA STATE TRAINING  
SCHOOL DECENTRALIZATION


IOWA DEPARTMENT OF ADMINISTRATIVE SERVICES  
3211 EDGINGTON AVE, ELDORA, IOWA 50627

SHIVEHATTERY  
ARCHITECTURE + ENGINEERING  
4125 Westown Pkwy, Suite 100 | West Des Moines, Iowa 50266  
515.223.8104 | www.shivehattery.com  
Iowa | Illinois | Indiana


DRAWN:	KAL
APPROVED:	CRB
ISSUED FOR:	SCHEMATIC DESIGN
DATE:	02/15/2019
PROJECT NO.:	4175681
FIELD BOOK:	--
CLIENT NO.:	--

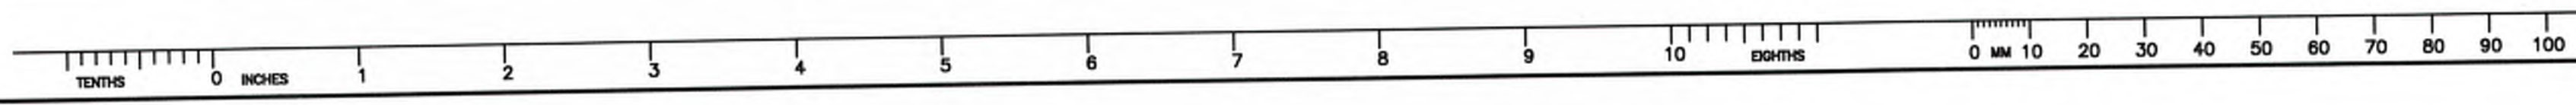

TRANSFORMER DATA & FUSE SIZES			
XFMR	XFMR RATING	4160V FUSE SIZE	12.5KV FUSE SIZE
TE01	500KVA	100A	50A
TE02	750KVA	125A	65A
TC05	300KVA	65A	15A
TC06	300KVA	65A	15A
TC08	300KVA	65A	15A
TC09	300KVA	65A	15A
TN15	300KVA	65A	15A
TN16	750KVA	125A	65A
TW19	500KVA	100A	50A
TW20	750KVA	125A	65A
TW22	1000KVA	NONE	65A

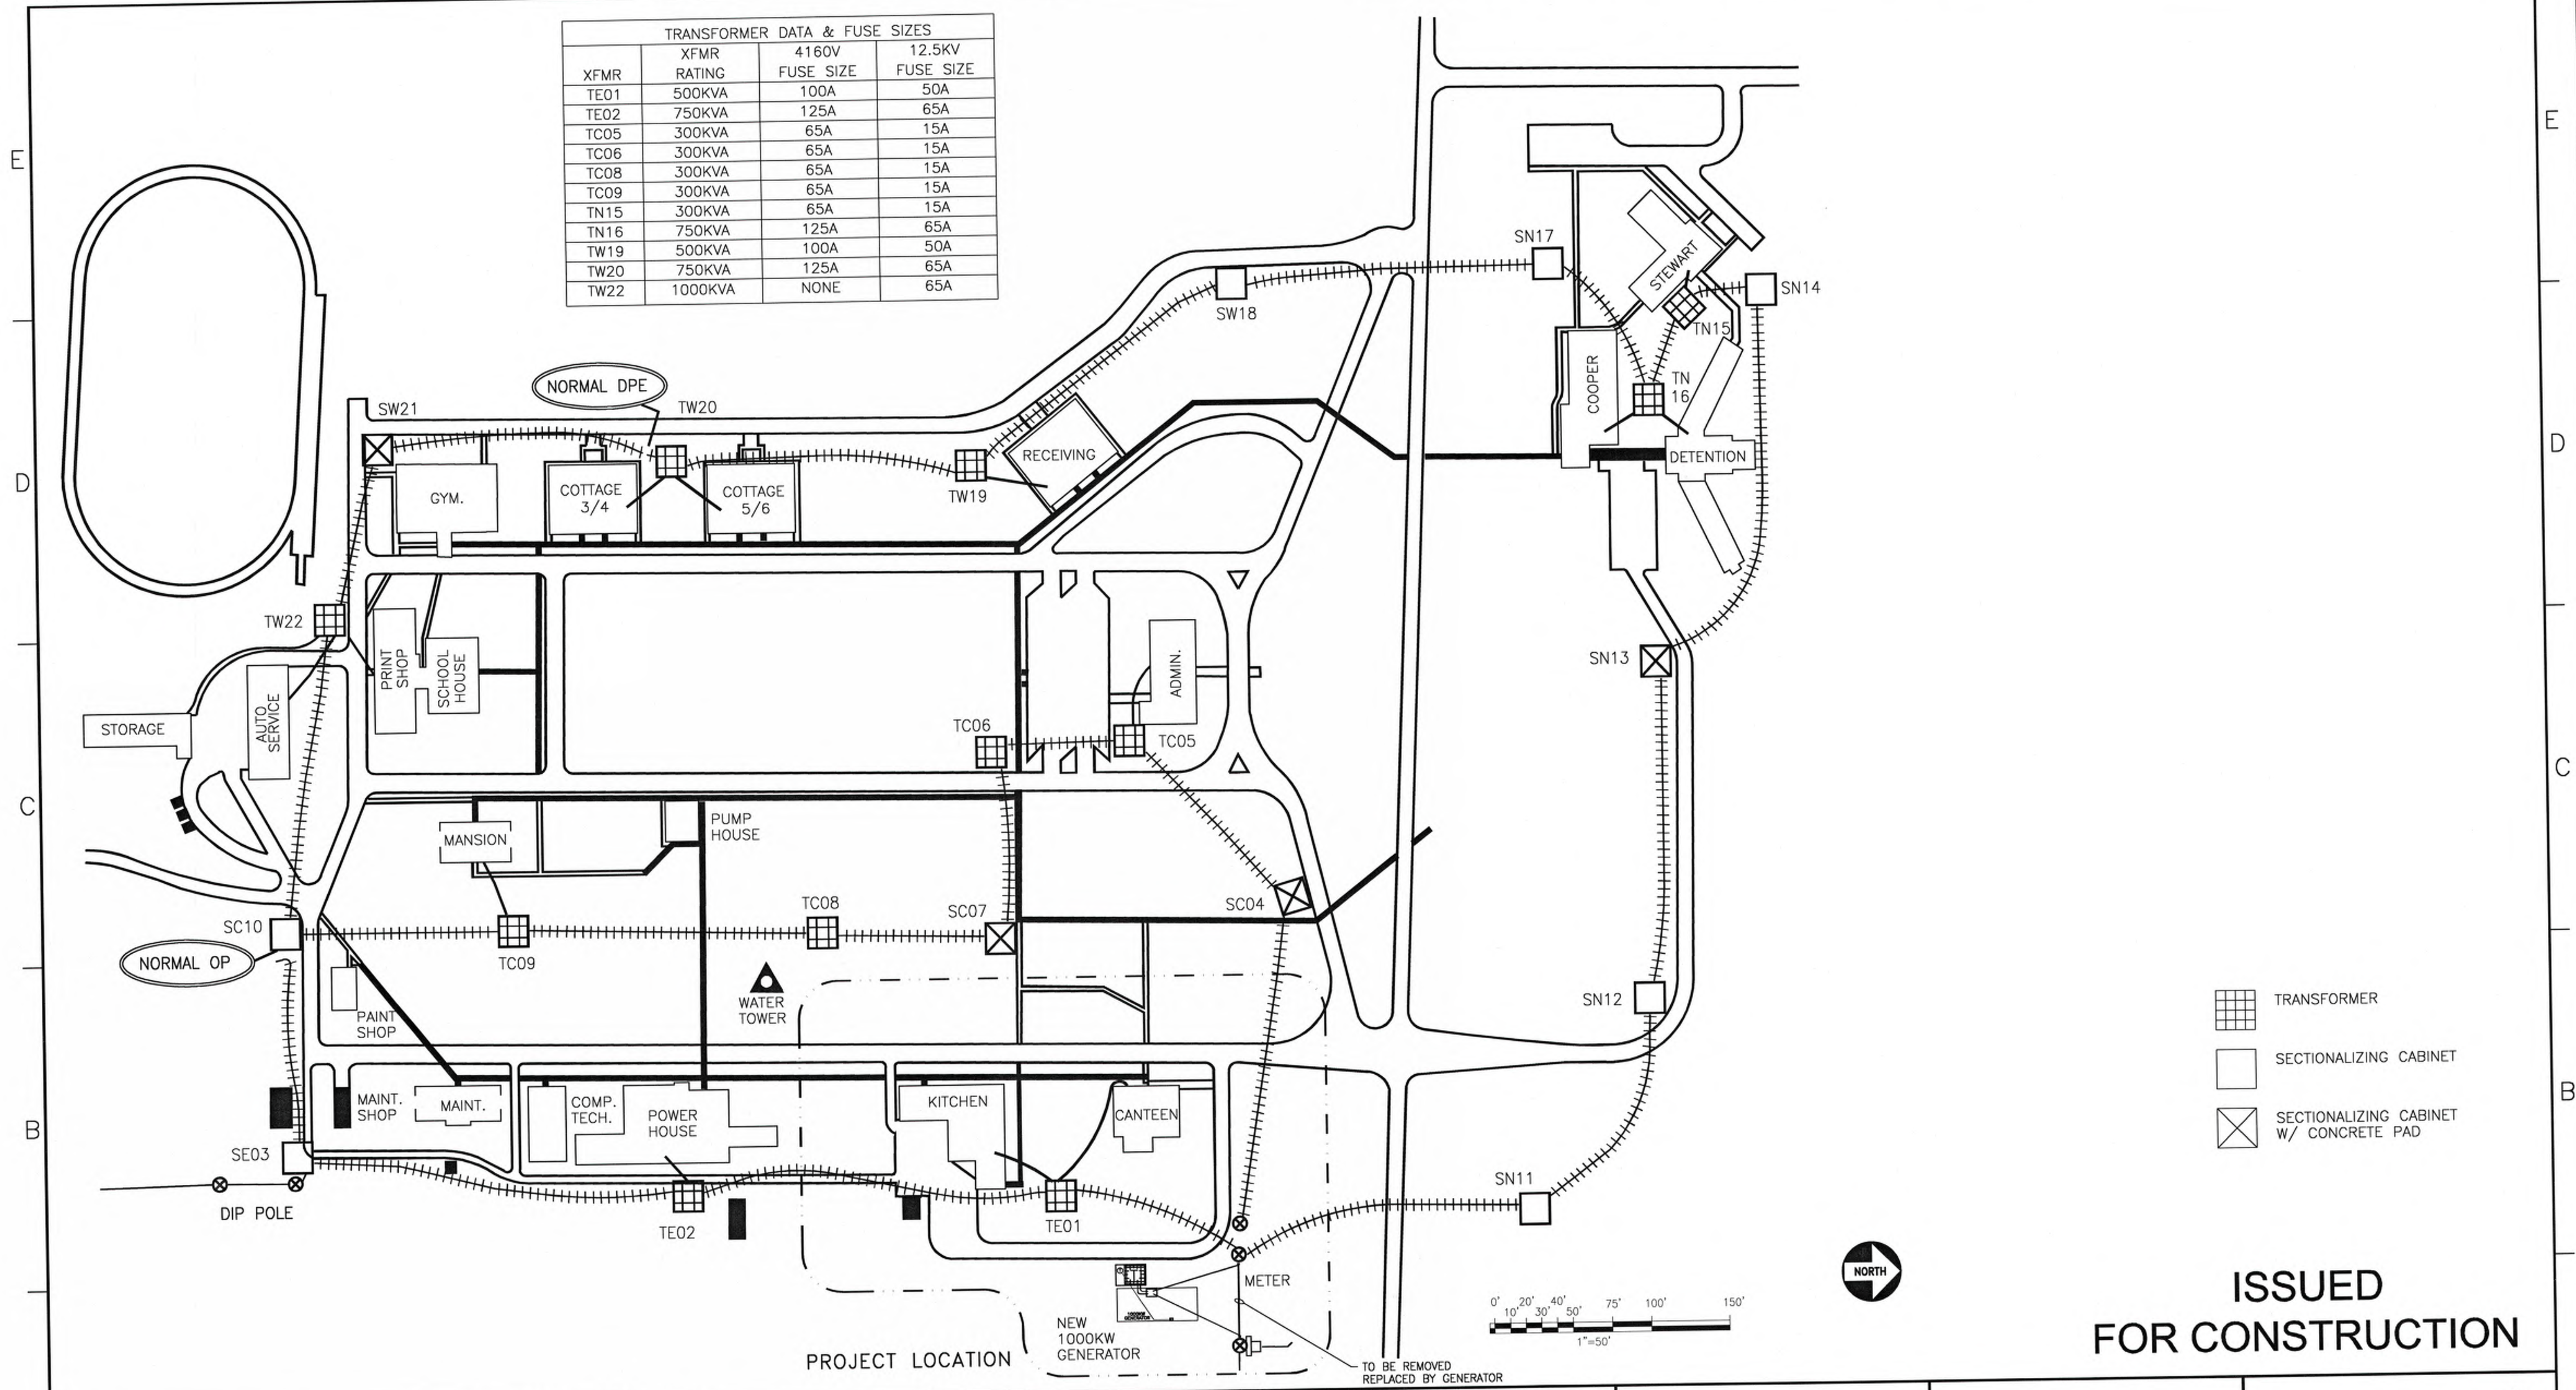

- TRANSFORMER
- SECTIONALIZING CABINET
- SECTIONALIZING CABINET W/ CONCRETE PAD

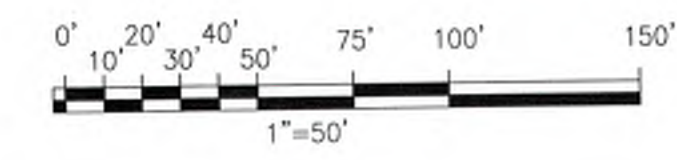

**ISSUED FOR CONSTRUCTION**



REV	ID/M/Y	REVISION	DRN	CHK	ISS ID/M/Y	APP	ISSUED FOR CONSTRUCTION	ISSUED FOR	REF	NUMBER	TITLE	REFERENCES
1	16/01/03	YR					ISSUED FOR CONSTRUCTION					

CLIENT PROJECT MGR.	DEPARTMENT MGR.	PROJECT MGR.	AREA	STATE OF IOWA
PROJECT NO. J518	BY DRN. MRA	D/M/Y 16/10/02		3049.01
PACKAGE CODE	DSN.	CHK.	TITLE	
	APP.		SITE PLAN	
SCALE NTS			ELDORA STATE TRAINING SCHOOL	
			ELDORA ELECTRICAL UPGRADE	

CLIENT DWG. NO.	REV.
E-5	0
DRAWING NO.	
PP-E-5	
CADD FILE ADDRESS	
ELDORA/ELDO_PP-E-5	


STAMP/SEAL  
 PROPRIETARY INFORMATION  
 THIS DRAWING, THE KNOW HOW AND INFORMATION DISCLOSED HEREIN IS THE PROPERTY OF AMEC E&C SERVICES INC. THIS DRAWING MAY NOT BE USED, COPIED OR DISCLOSED EXCEPT AS APPROVED BY AMEC E&C SERVICES INC. UPON DEMAND, THIS DRAWING AND ALL COPIED HEREOF SHALL BE RETURNED IMMEDIATELY TO AMEC E&C SERVICES INC.

P:\CAD\ELDO\ELDO\_PP-E-5.DWG, Layout1, 01/13/03 10:52:16 AM, MIKE ANDERSON, 16/10/02

FEEDER SCHEDULE	
NOTE	FEEDER
①	1- 2" C W/4 - #3/0 & 1 - #4 GND
②	2- 3" C W/4 - #350 & 1 - #1/0 GND
③	2- 3" C W/4 - #350 & 1 - #1/0 GND AND 4 - 3" C SPARE
④	1- 3 1/2" C W/4 #500 & 1 - #1/0 GND
⑤	2- 3 1/2" C W/4 - #500 & 1 - #1/0 GND
⑥	4- 3 1/2" C W/4 - #500 & 1 - #1/0 GND
⑦	2- 4" C W/4 - #500 & 1 - #1/0 GND
⑧	3- 2" C W/1 - #4/0 & 1 - 11X14 CU NEUTRAL, DRY, 0.220" TRXLP

SWITCHBOARD / PANEL SCHEDULE	
NOTE	MAIN BUS RATING
①	200 A
②	400 A
③	600 A
④	800 A
⑤	1600 A

TRANSFORMER DATA & FUSE SIZES			
XFMR	XFMR RATING	4160V FUSE SIZE	12.5kV FUSE SIZE
TE01	500 KVA	100 A	50 A
TE02	750 KVA	125 A	65 A
TC05	300 KVA	65 A	15 A
TC06	300 KVA	65 A	15 A
TC08	300 KVA	65 A	15 A
TC09	300 KVA	65 A	15 A
TN15	300 KVA	65 A	15 A
TN16	750 KVA	125 A	65 A
TV19	500 KVA	100 A	50 A
TW20	750 KVA	125 A	65 A
TW22	1000 KVA	NONE	65 A

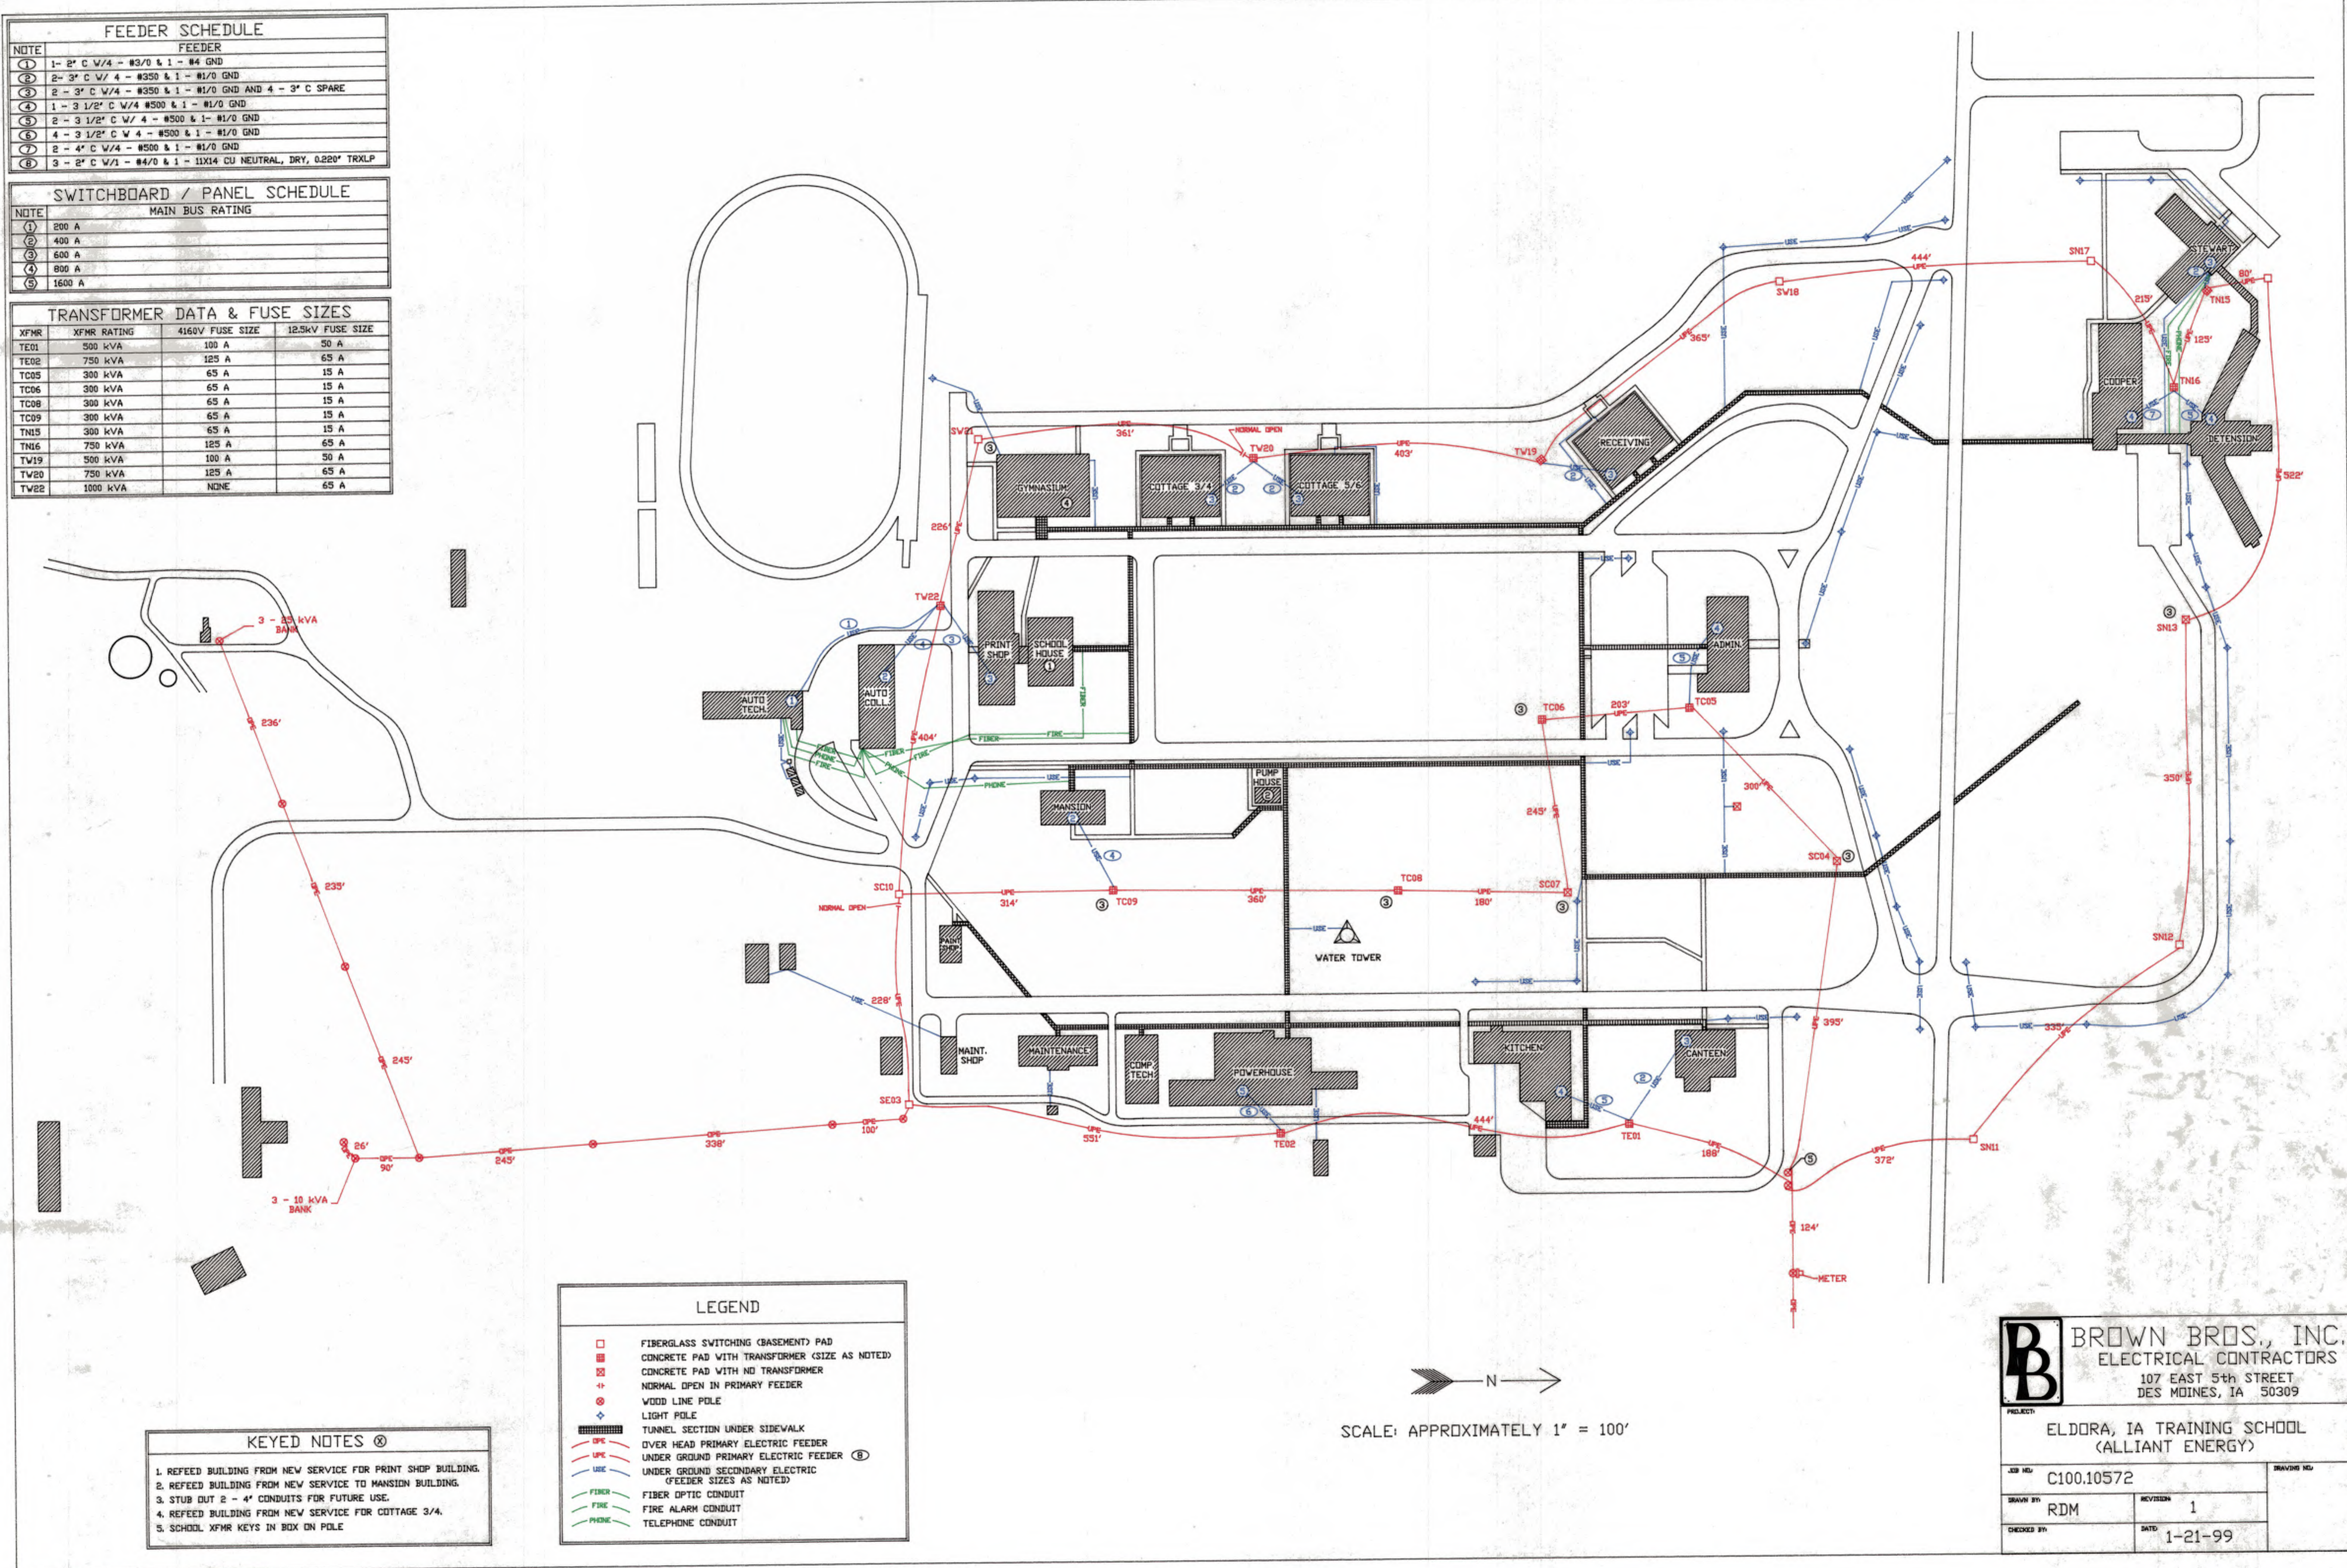

**KEYED NOTES** ⓧ

1. REFEED BUILDING FROM NEW SERVICE FOR PRINT SHOP BUILDING.
2. REFEED BUILDING FROM NEW SERVICE TO MANSION BUILDING.
3. STUB OUT 2 - 4" CONDUITS FOR FUTURE USE.
4. REFEED BUILDING FROM NEW SERVICE FOR COTTAGE 3/4.
5. SCHOOL XFMR KEYS IN BOX ON POLE

LEGEND	
□	FIBERGLASS SWITCHING (BASEMENT) PAD
■	CONCRETE PAD WITH TRANSFORMER (SIZE AS NOTED)
□	CONCRETE PAD WITH NO TRANSFORMER
+	NORMAL OPEN IN PRIMARY FEEDER
⊙	WOOD LINE POLE
⊙	LIGHT POLE
▬	TUNNEL SECTION UNDER SIDEWALK
—UPC—	OVER HEAD PRIMARY ELECTRIC FEEDER
—UPC—	UNDER GROUND PRIMARY ELECTRIC FEEDER ⓧ
—USC—	UNDER GROUND SECONDARY ELECTRIC FEEDER (FEEDER SIZES AS NOTED)
—FIBER—	FIBER OPTIC CONDUIT
—FIRE—	FIRE ALARM CONDUIT
—PHONE—	TELEPHONE CONDUIT


SCALE: APPROXIMATELY 1" = 100'

**B** BROWN BROS., INC.  
ELECTRICAL CONTRACTORS  
107 EAST 5th STREET  
DES MOINES, IA 50309

ELDORA, IA TRAINING SCHOOL  
(ALLIANT ENERGY)

PROJ. NO. C100.10572  
DRAWING NO. 1

DATE 1-21-99

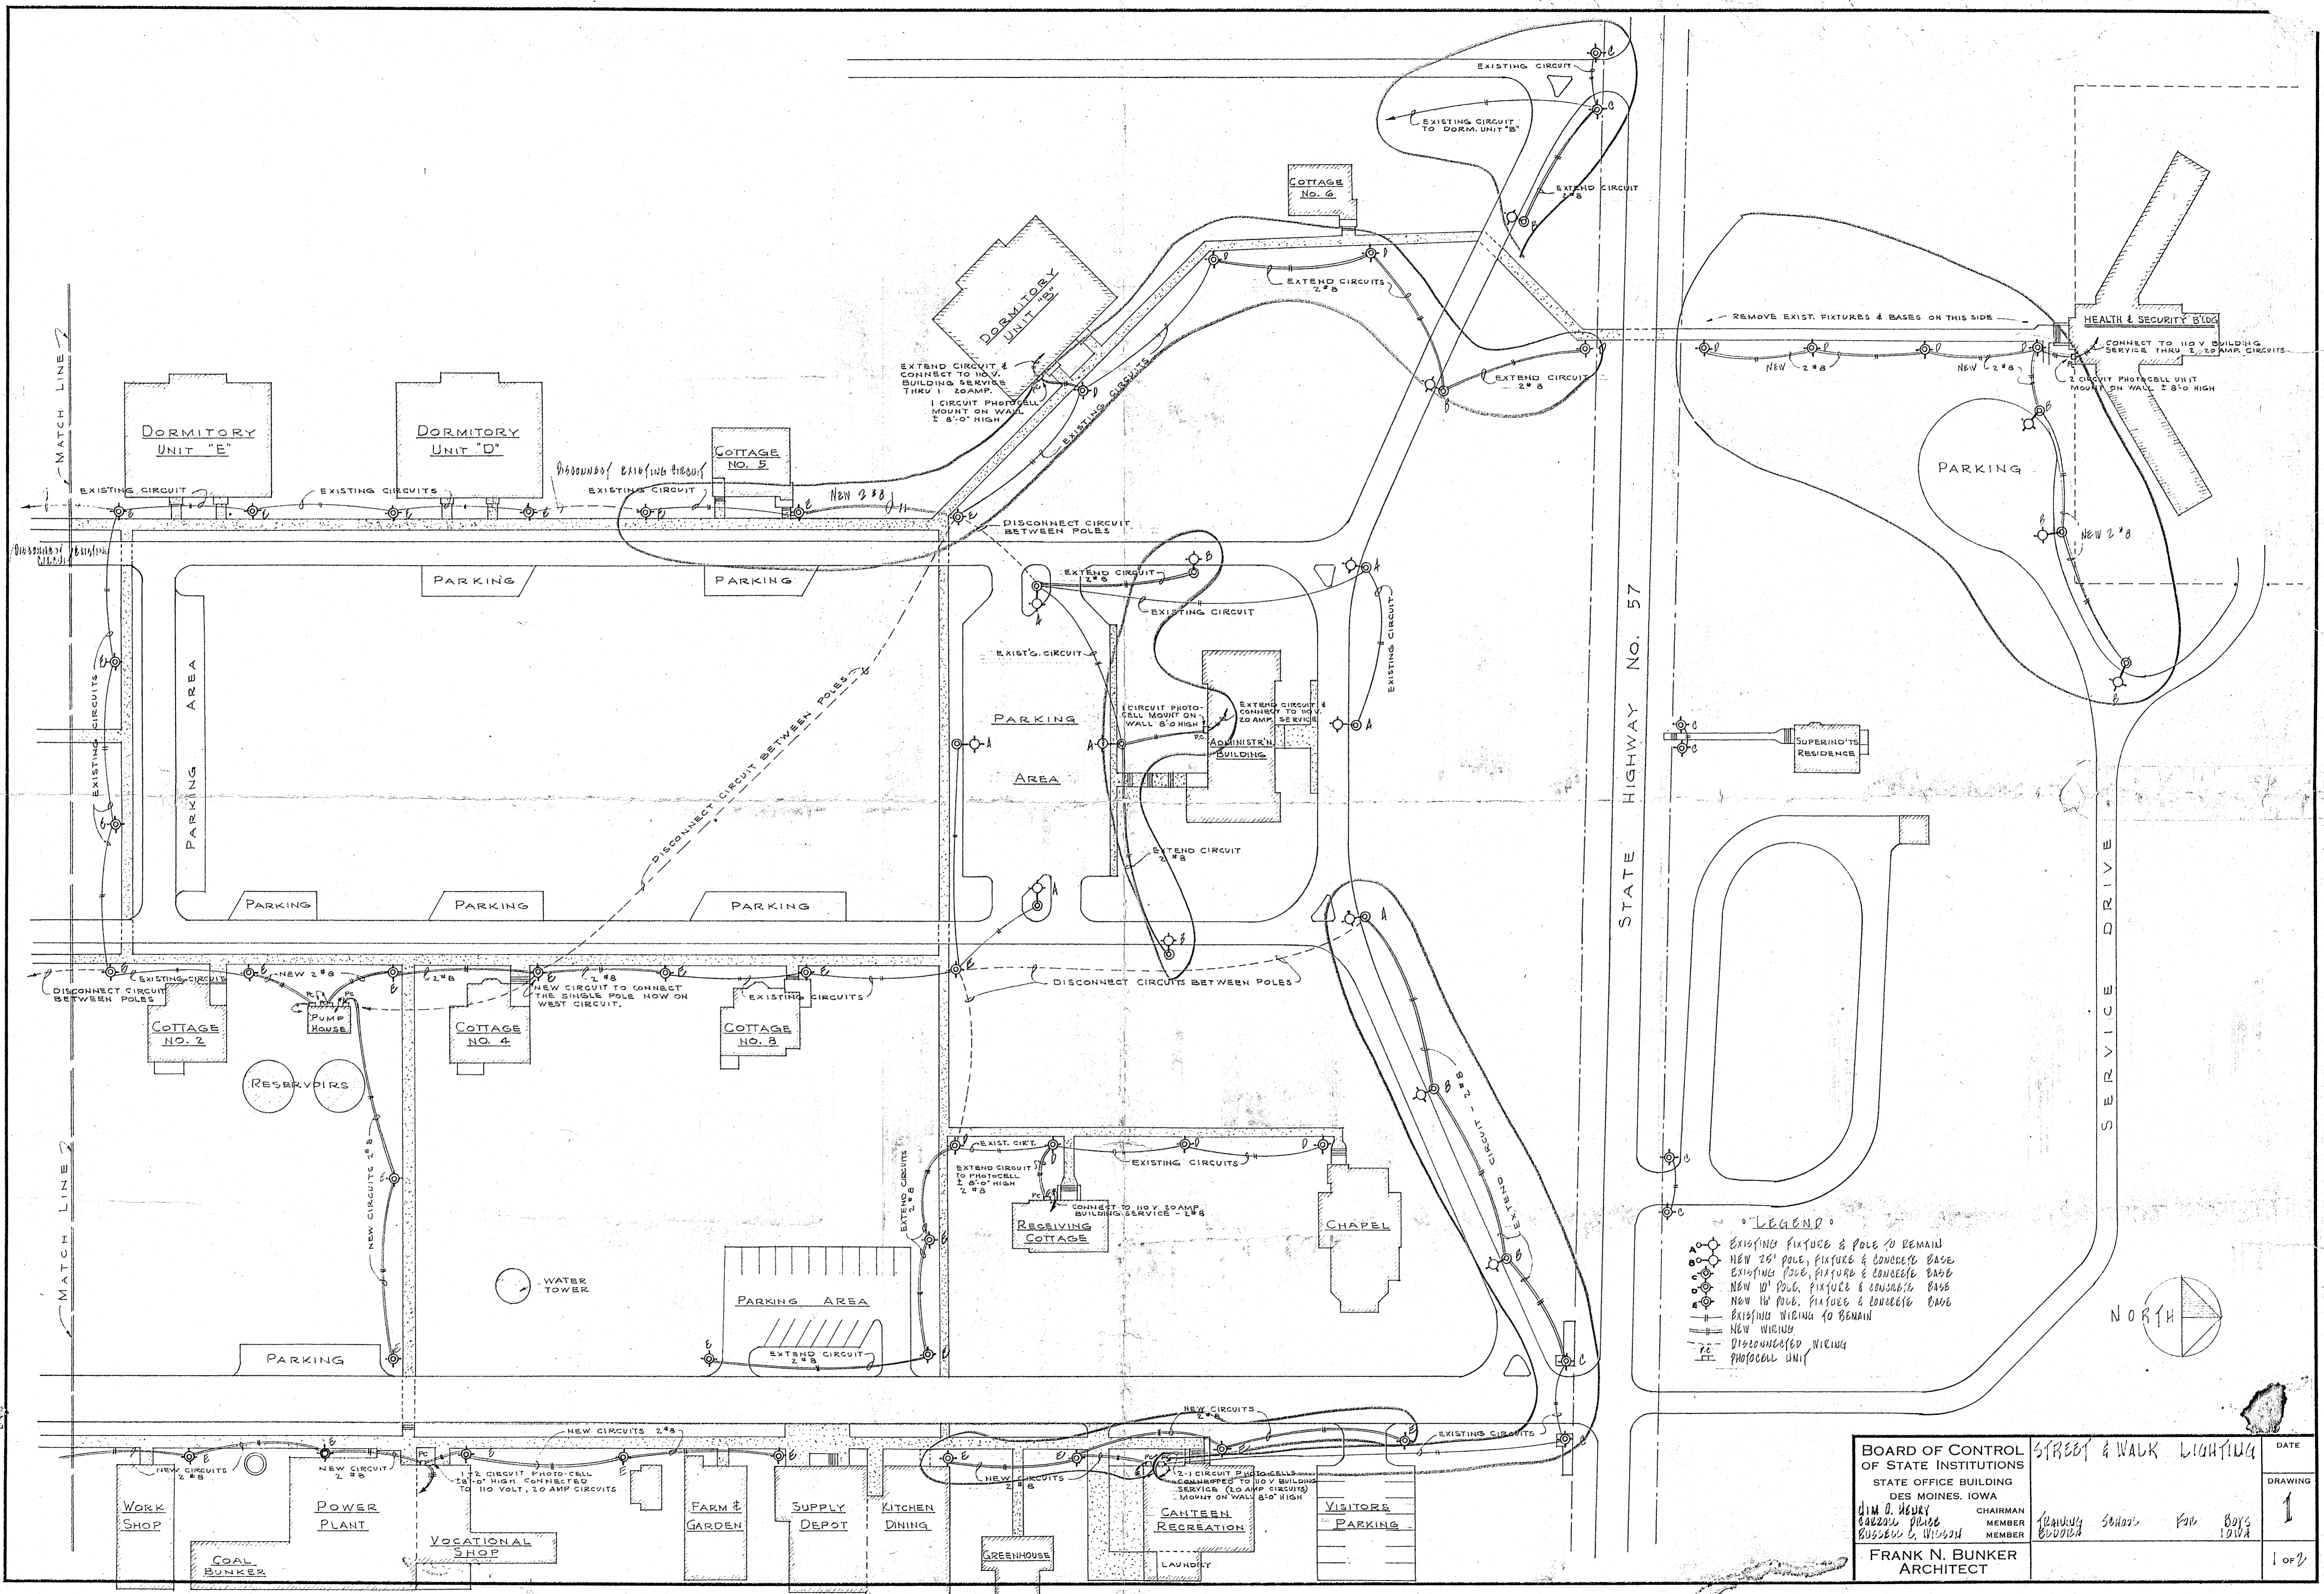


- LEGEND**
- Existing fixture & pole to remain
  - New 25' pole, fixture & concrete base
  - Existing pole, fixture & concrete base
  - New 10' pole, fixture & concrete base
  - New 16' pole, fixture & concrete base
  - Existing wiring to remain
  - New wiring
  - Disconnected wiring
  - Photocell unit




BOARD OF CONTROL OF STATE INSTITUTIONS		DATE	
STATE OFFICE BUILDING DES MOINES, IOWA		DRAWING	
JIM D. WELBY CHAIRMAN		1	
WILLIAM G. WILSON MEMBER		1 of 2	
FRANK N. BUNKER ARCHITECT		1 of 2	





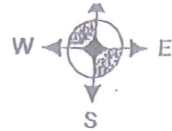

STREET & WALK LIGHTING

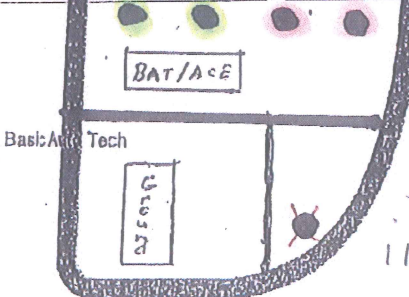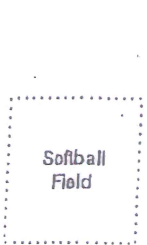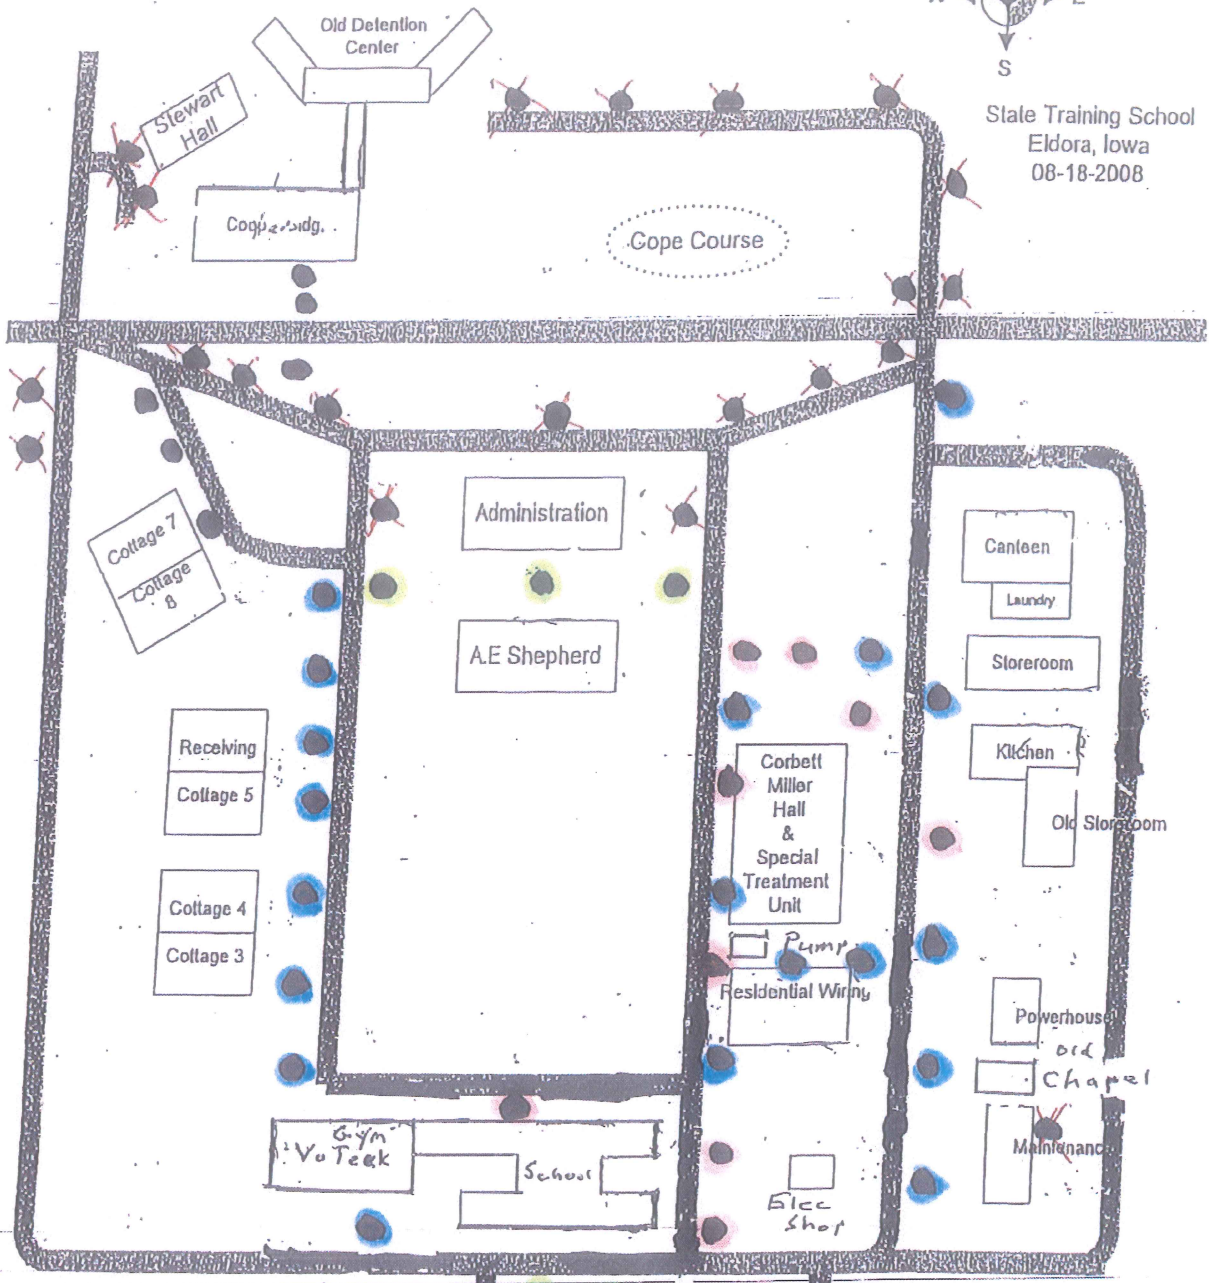BRANDY SODOR FOR BOYS IOWA



State Training School  
Eldora, Iowa  
08-18-2008




-  Storage
-  5 250W HPS
-  11 150W HPS
-  2:2 100W HPS
-  2:2 X Arm Mount
-  60


East gate  
Cobra lights  
100 watt

STREET

LIGHTS

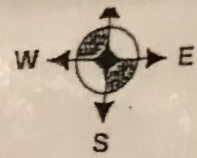

State Training School  
Eldora, Iowa  
08-18-2008

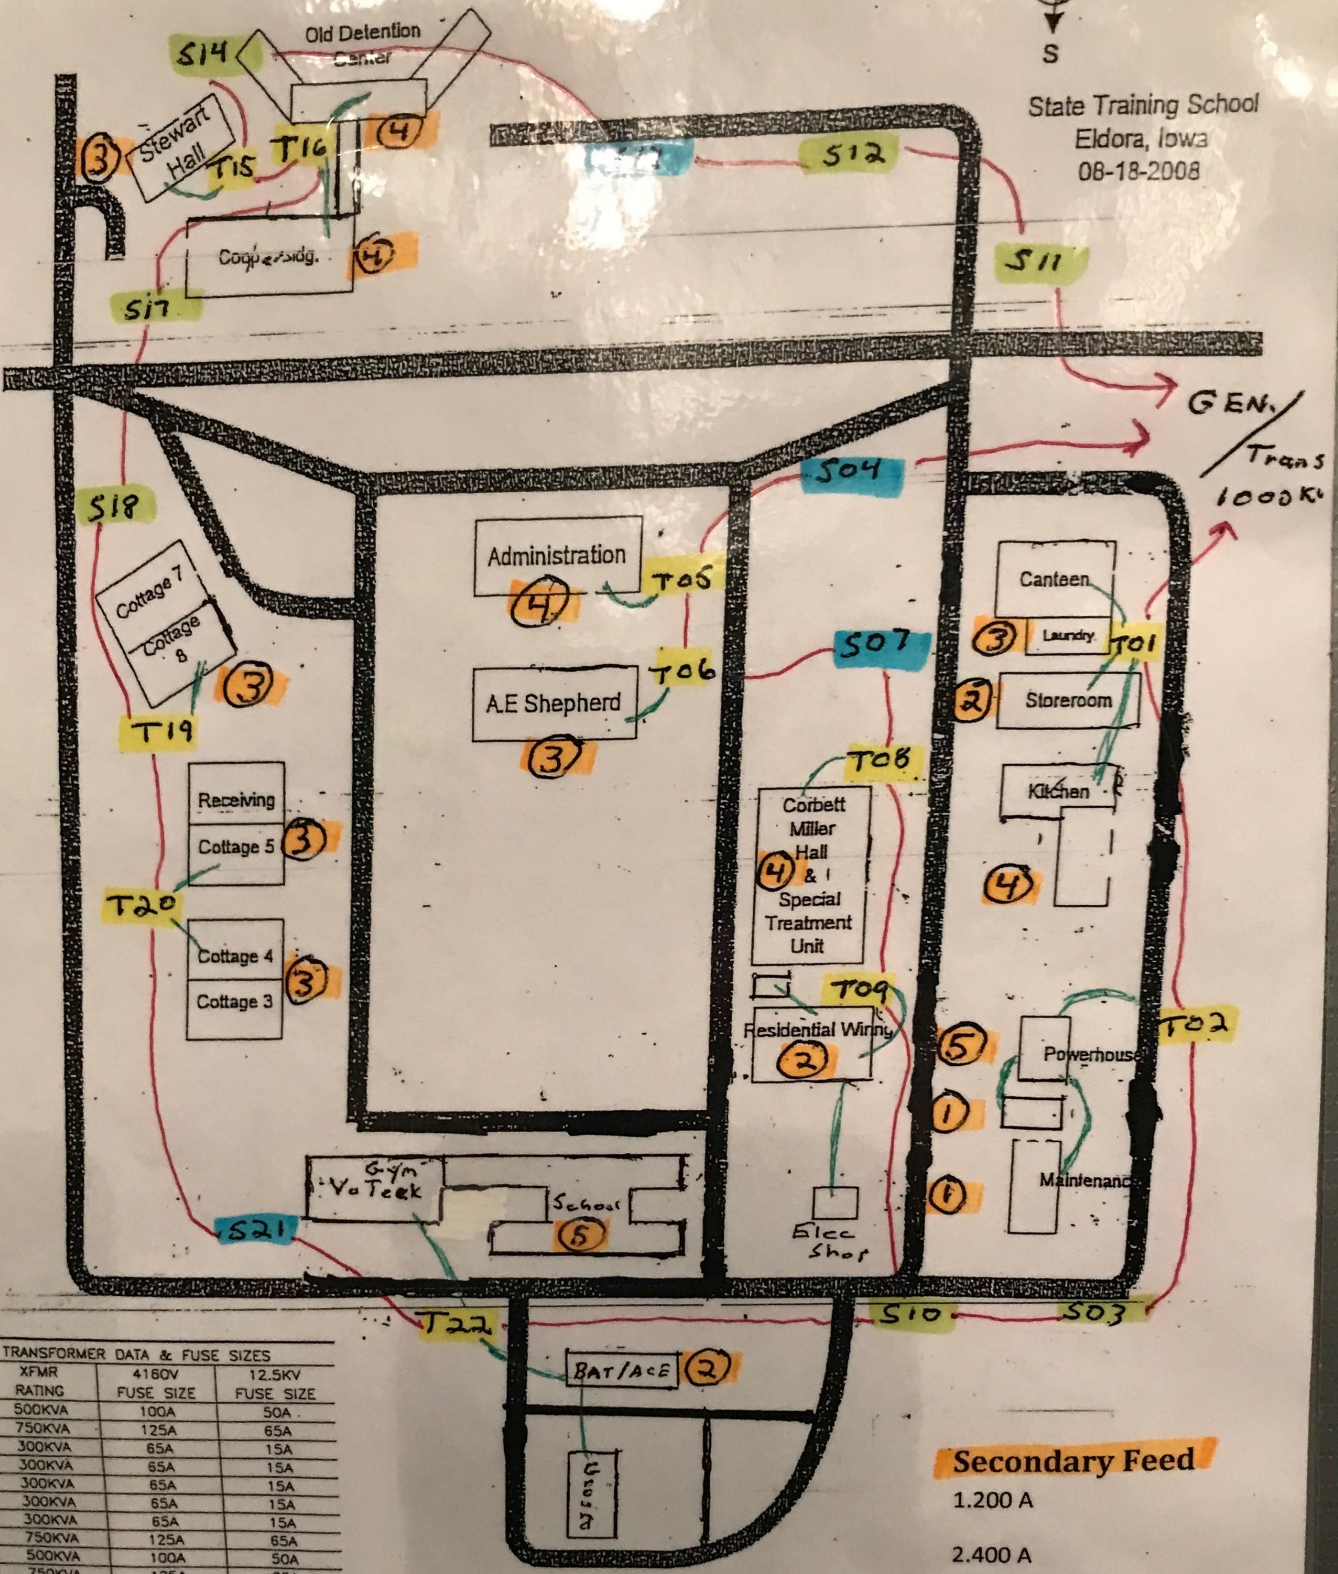

TRANSFORMER DATA & FUSE SIZES			
XFMR	XFMR RATING	4160V FUSE SIZE	12.5KV FUSE SIZE
TE01	500KVA	100A	50A
TE02	750KVA	125A	65A
TC05	300KVA	65A	15A
TC06	300KVA	65A	15A
TC08	300KVA	65A	15A
TC09	300KVA	65A	15A
TN15	300KVA	65A	15A
TN16	750KVA	125A	65A
TW19	500KVA	100A	50A
TW20	750KVA	125A	65A
TW22	1000KVA	NONE	65A

- TRANSFORMER
- SECTIONALIZING CABINET
- SECTIONALIZING CABINET W/ CONCRETE PAD

Primary  
Secondary

**Secondary Feed**

- 1.200 A
- 2.400 A
- 3.600 A
- 4.800 A
- 5.1600 A